



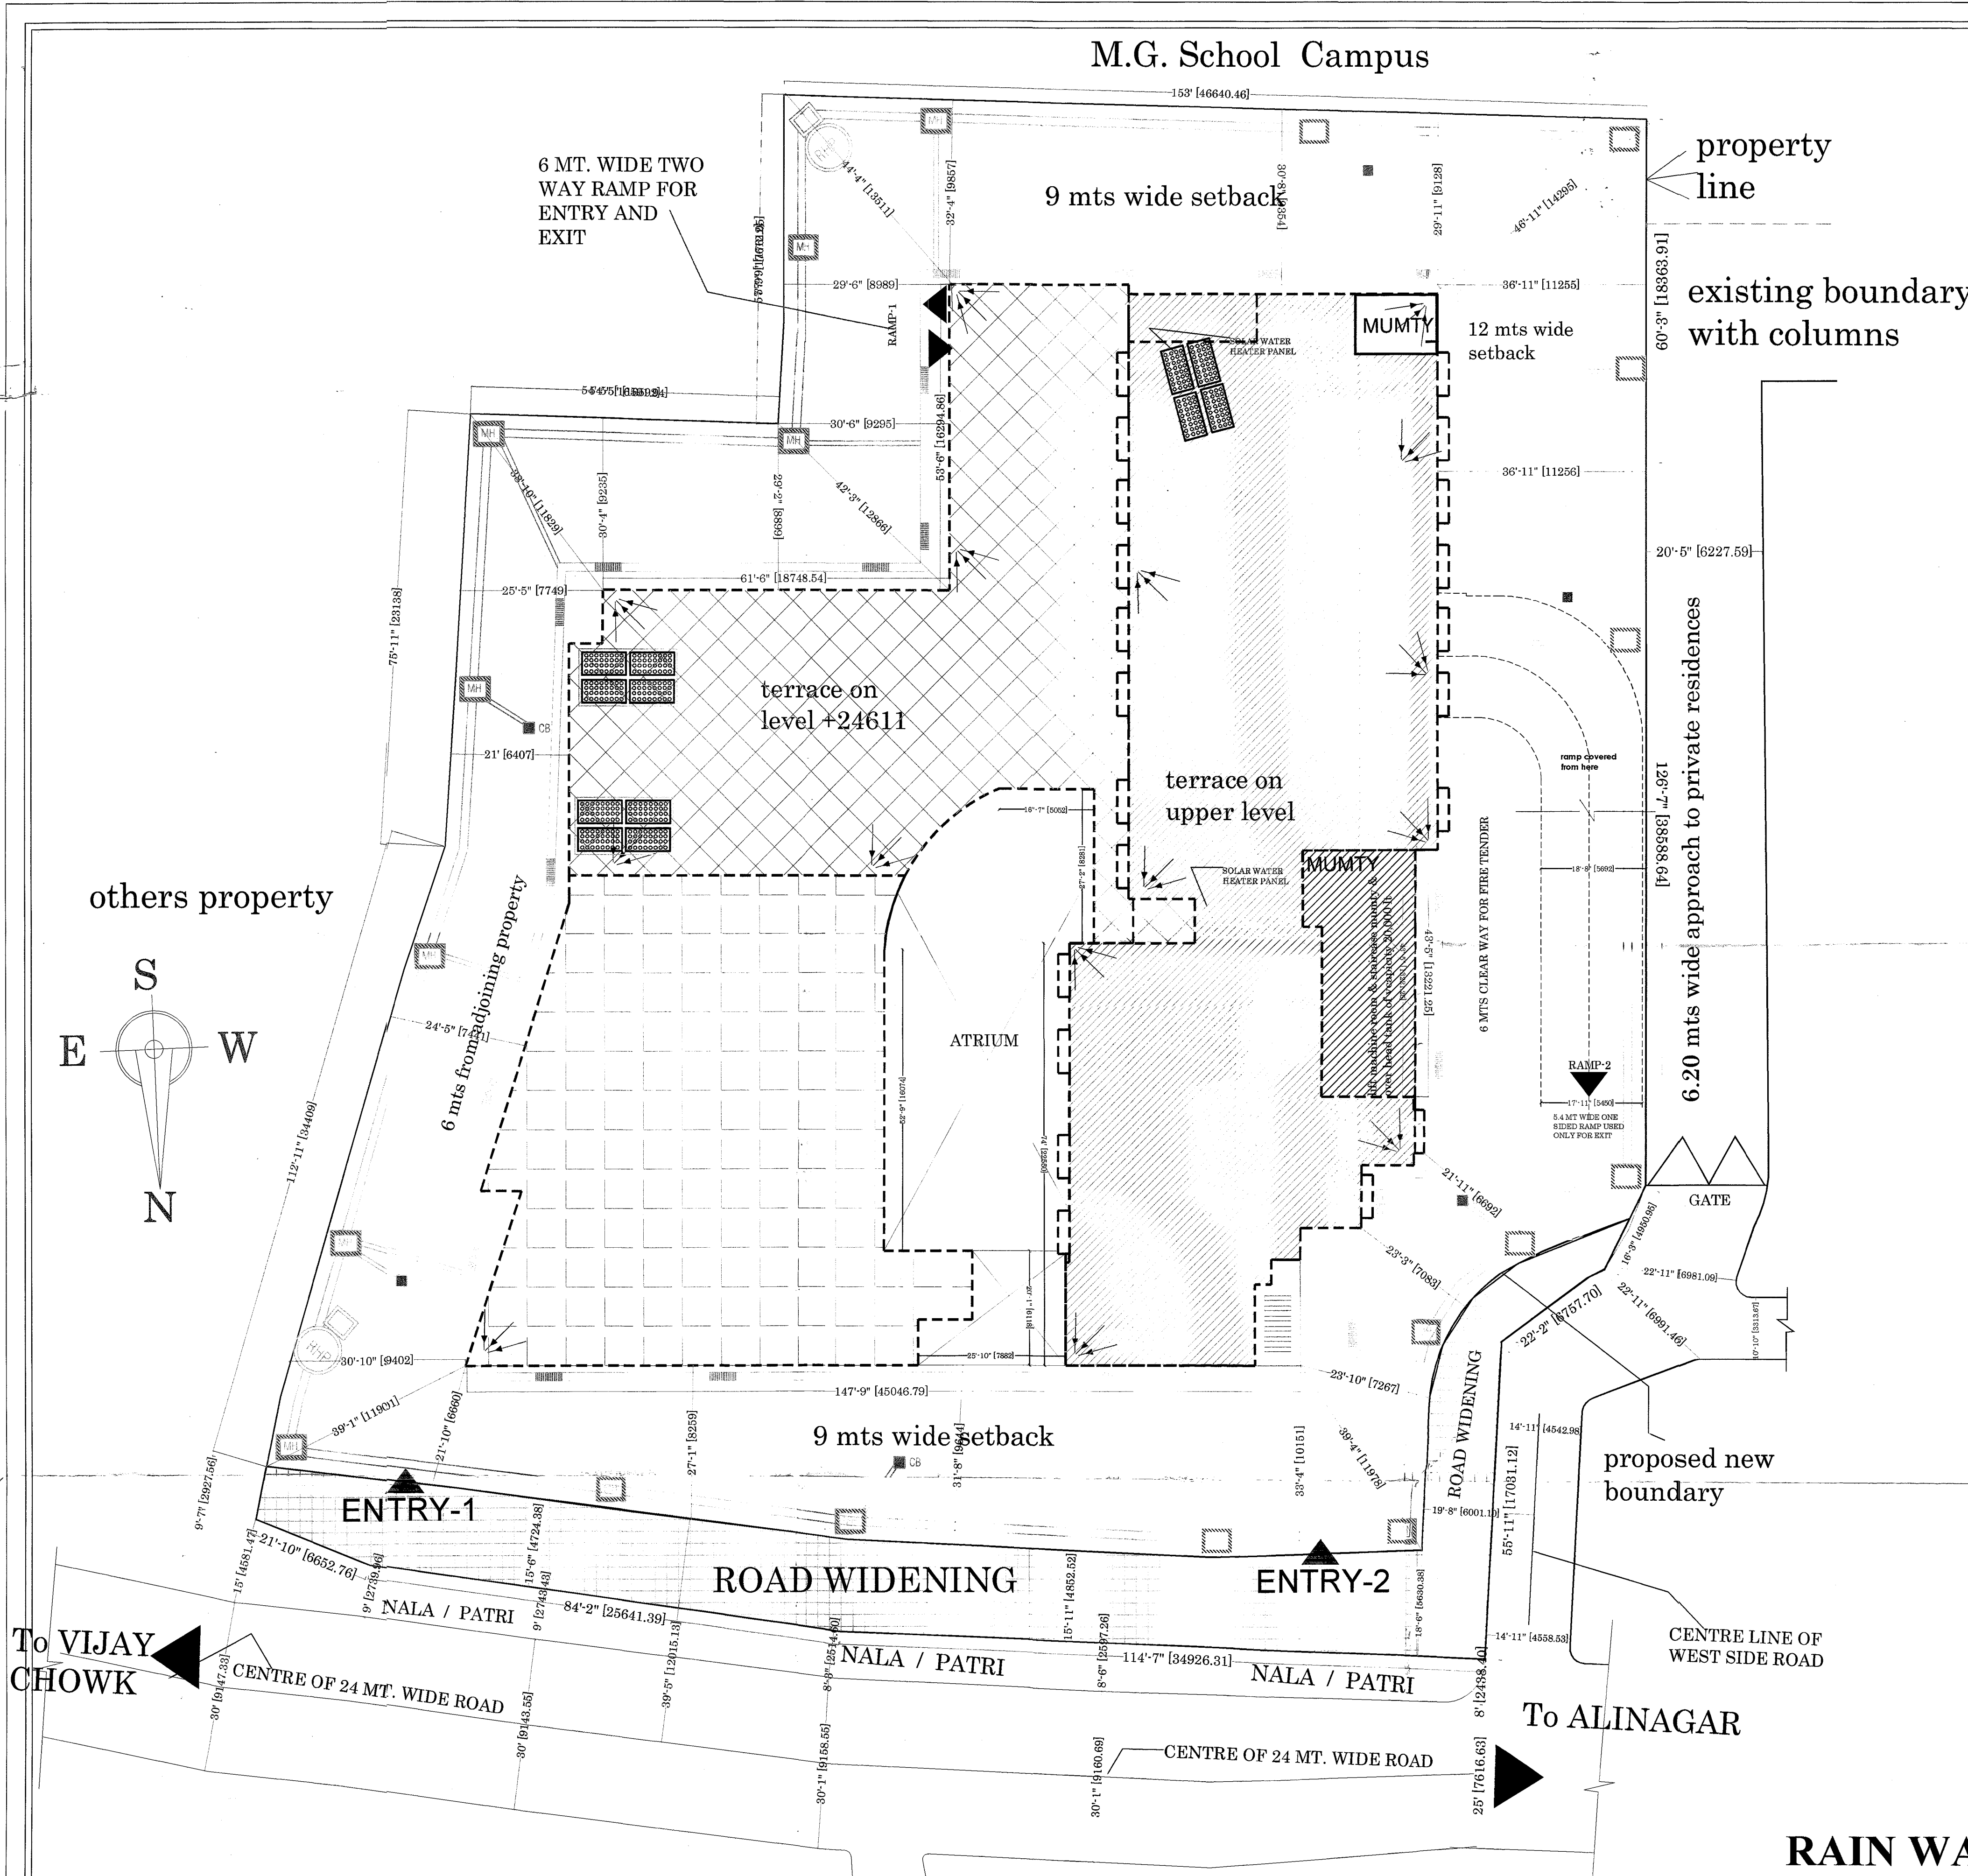

LEGEND :

	RAINWATER HARVESTING PIT
	MANHOLE
	DRAIN CHANNEL
	CATCH BASIN

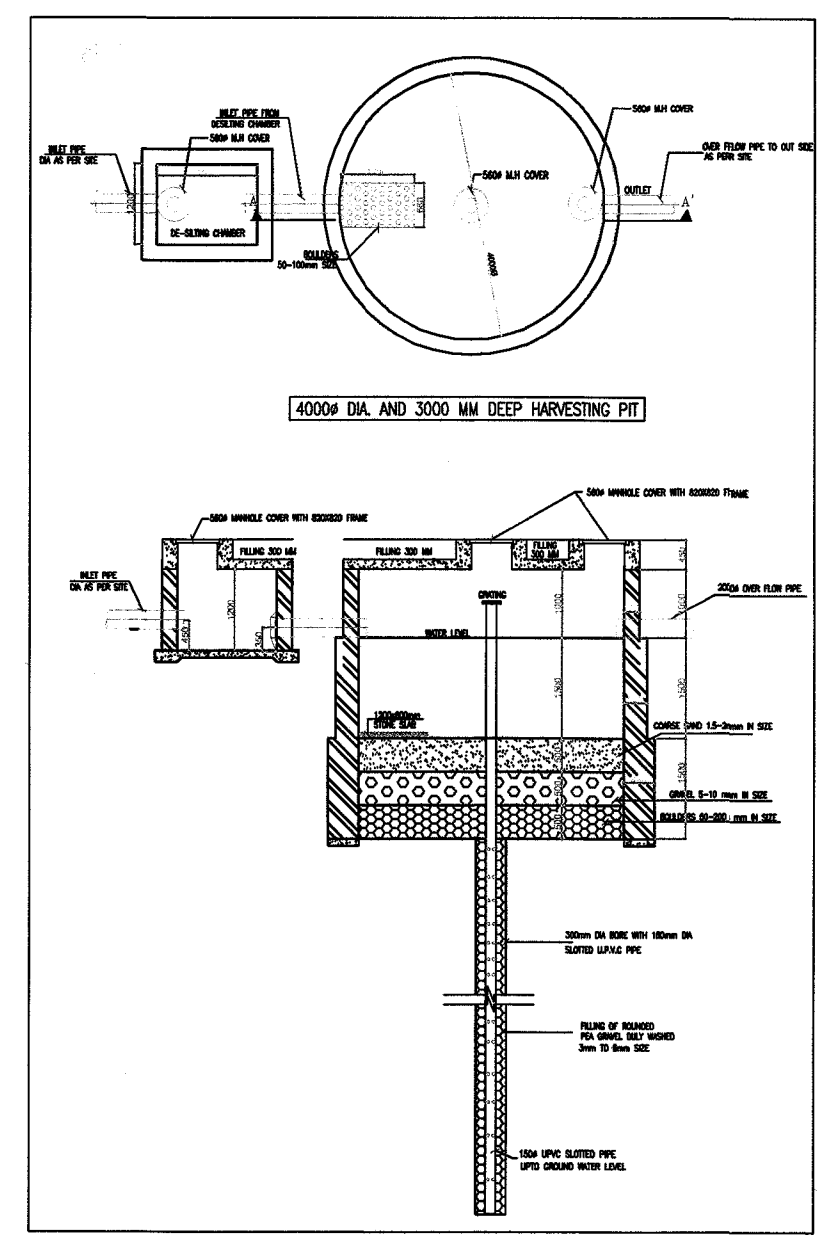

गोरखपुर विकास प्राधिकरण
जोड़कर
महोदय ११/०७/१४ दिनांक ११/०७/१४
स्वीकृत
प्रस्तुत मानचित्र वास्तविक संख्या-१२०
(१)/८-३-१४-२२१ विधि/१३ टीओसी,
दिनांक २२ अप्रैल, २०१४ सहरी आवास
विभाग अनुयाय-३ द्वारा दिये गये निर्देश
के अन्तर्गत ३० मीटर लम्बाई के
विशेष अनुयाय बाधिका
संख्या-७०६९/२०१४ में दिये गये निर्देश
आदेश के अन्तर्गत स्वीकृत किया जा रहा है।
[Signatures]

SEAL OF G.D.

SUBMISSION DRG

Remarks
THIS DRAWING IS THE PROPERTY OF
A-CORE ARCHITECTURAL SERVICES
PVT. LTD. AND ISSUED FOR THE SPECIFIC
PROJECT MENTIONED THEREIN. THIS IS NOT
TO COPIED OR USED FOR THE OTHER
PROJECTS UNLESS EXPRESSLY PERMITTED
BY THE ARCHITECT.

PROJECT
PROPOSED MULTIPLEX AND HOTEL
AT EXISTING MENKA AND Inderlok
CINEMA CAMPUS,
NEAR VIJAY CHAUK, GORAKHPUR

DEVELOPER/OWNER
SMT SAVITRI DAS
W/O LATE SHRI PREM MOHAN DAS
AND
SHREE HARI MOHAN DAS,
AND
SHREE VED MOHAN DAS,
AND
SHRI SOMENDRA MOHAN DAS
S/O LATE SHRI PREM MOHAN DAS
AND
SHRI SHOBHIT MOHAN DAS
S/O LATE SHRI PREM MOHAN DAS

Drawing Title
SITE PLAN

sheet number 01 F
REVISED

Drg. No.
Scale
Date 19-11-2014
Drawn By
Issued To

ACORE ARCHITECTURAL
SERVICES PVT. LTD.
ARCHITECT:ASHISH SRIVASTAVA
BRANCH OFFICE : 935/D MATR-ANCHAL
NEAR GORAKHNATH RAILWAY
CROSSING GORAKHPUR
TEL: OFF:3294813,RES:2255290,
MOBILE:9415321836.

RAIN WATER HARVESTING PLAN