



12.00 METER WIDE ROAD

213465

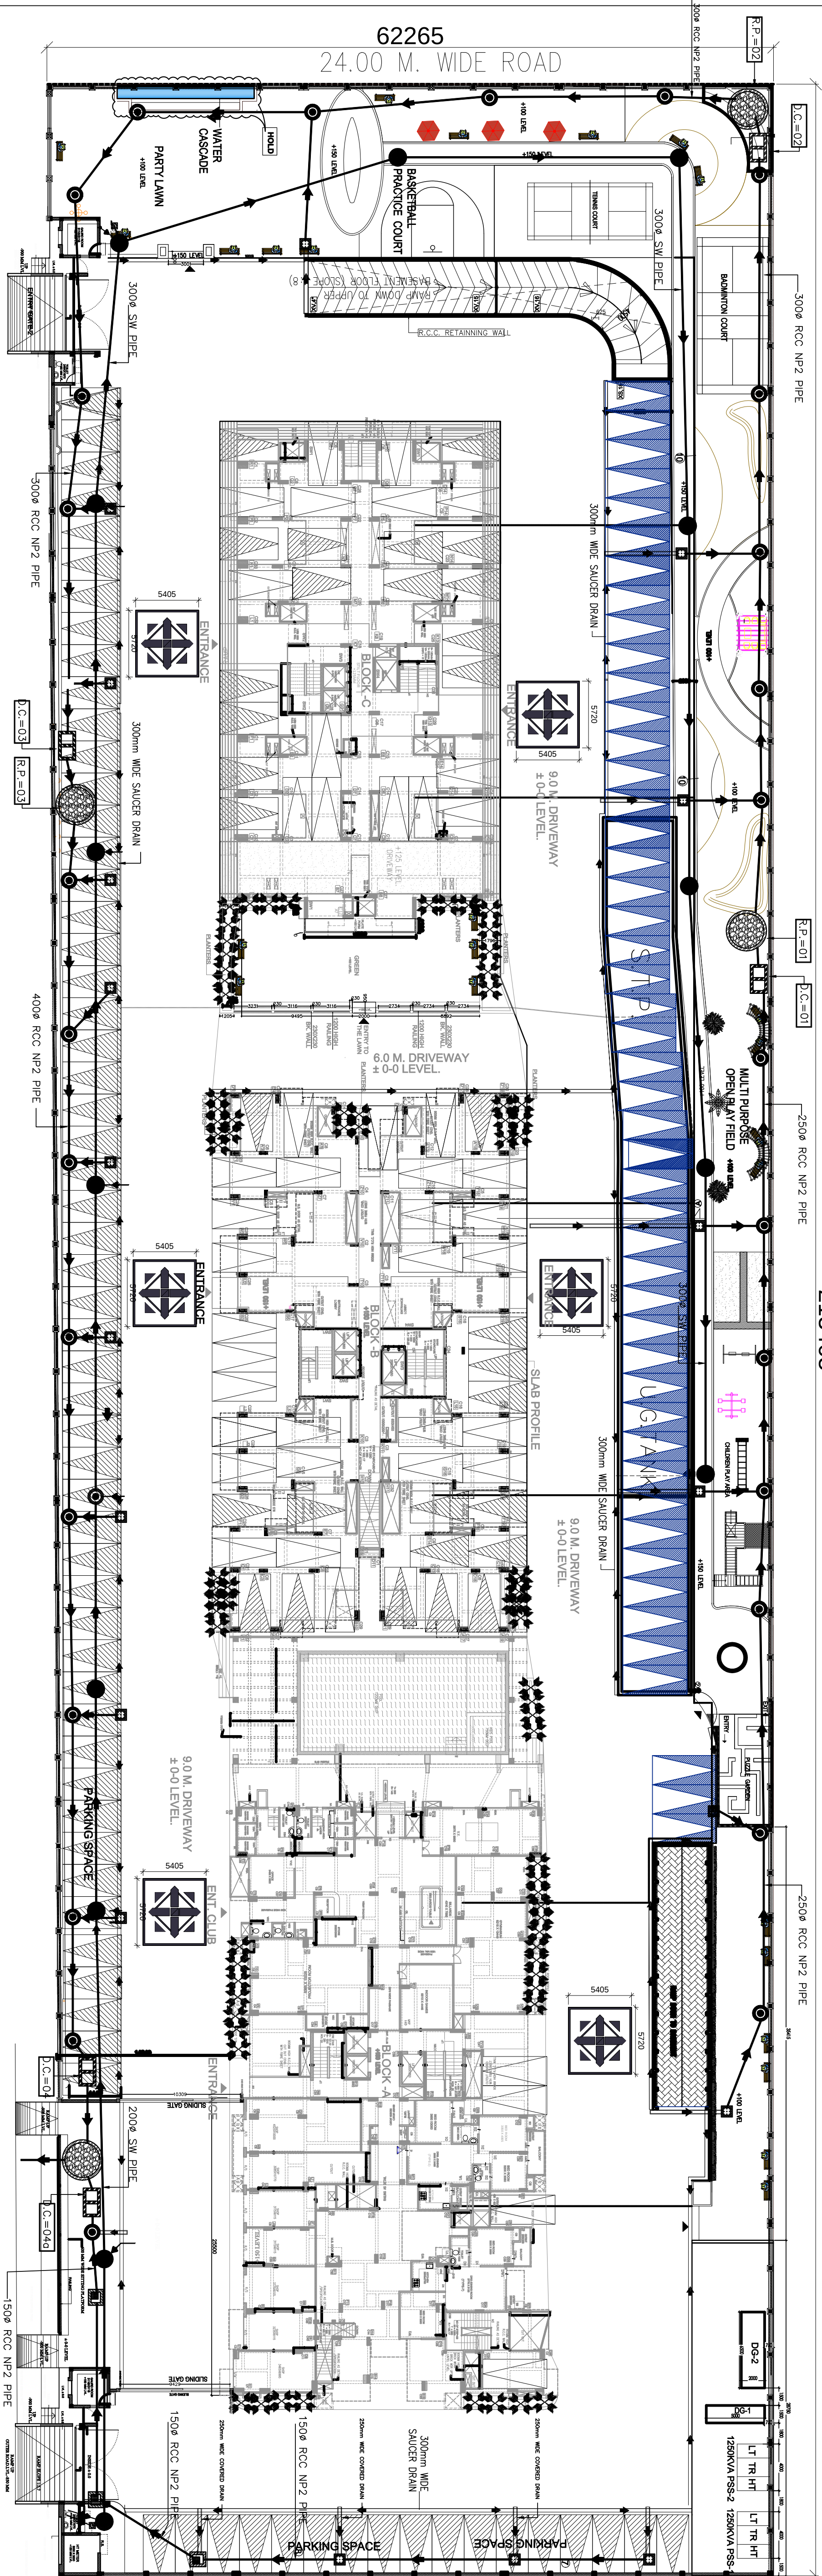

57.00 METER WIDE ROAD

PLUMBING LEGEND:-	
	EXTERNAL SEWER LINE
	EXTERNAL STORM WATER LINE
	RECHARGE PIT (3000 MM DIA)
	DESILTING CHAMBER (1000 x 2000 MM DIA)
	VALVE WITH CHAMBER
	NON RETURN VALVE WITH CHAMBER
	SEWER MANHOLE WITH 560mm MANHOLE COVER.
	STORM WATER MANHOLE WITH 560mm PERFORATED MANHOLE COVER.
	STORM WATER CATCH BASIN SIZE=(600x600)mm
	STORM WATER MANHOLE SIZE=(800x900)mm

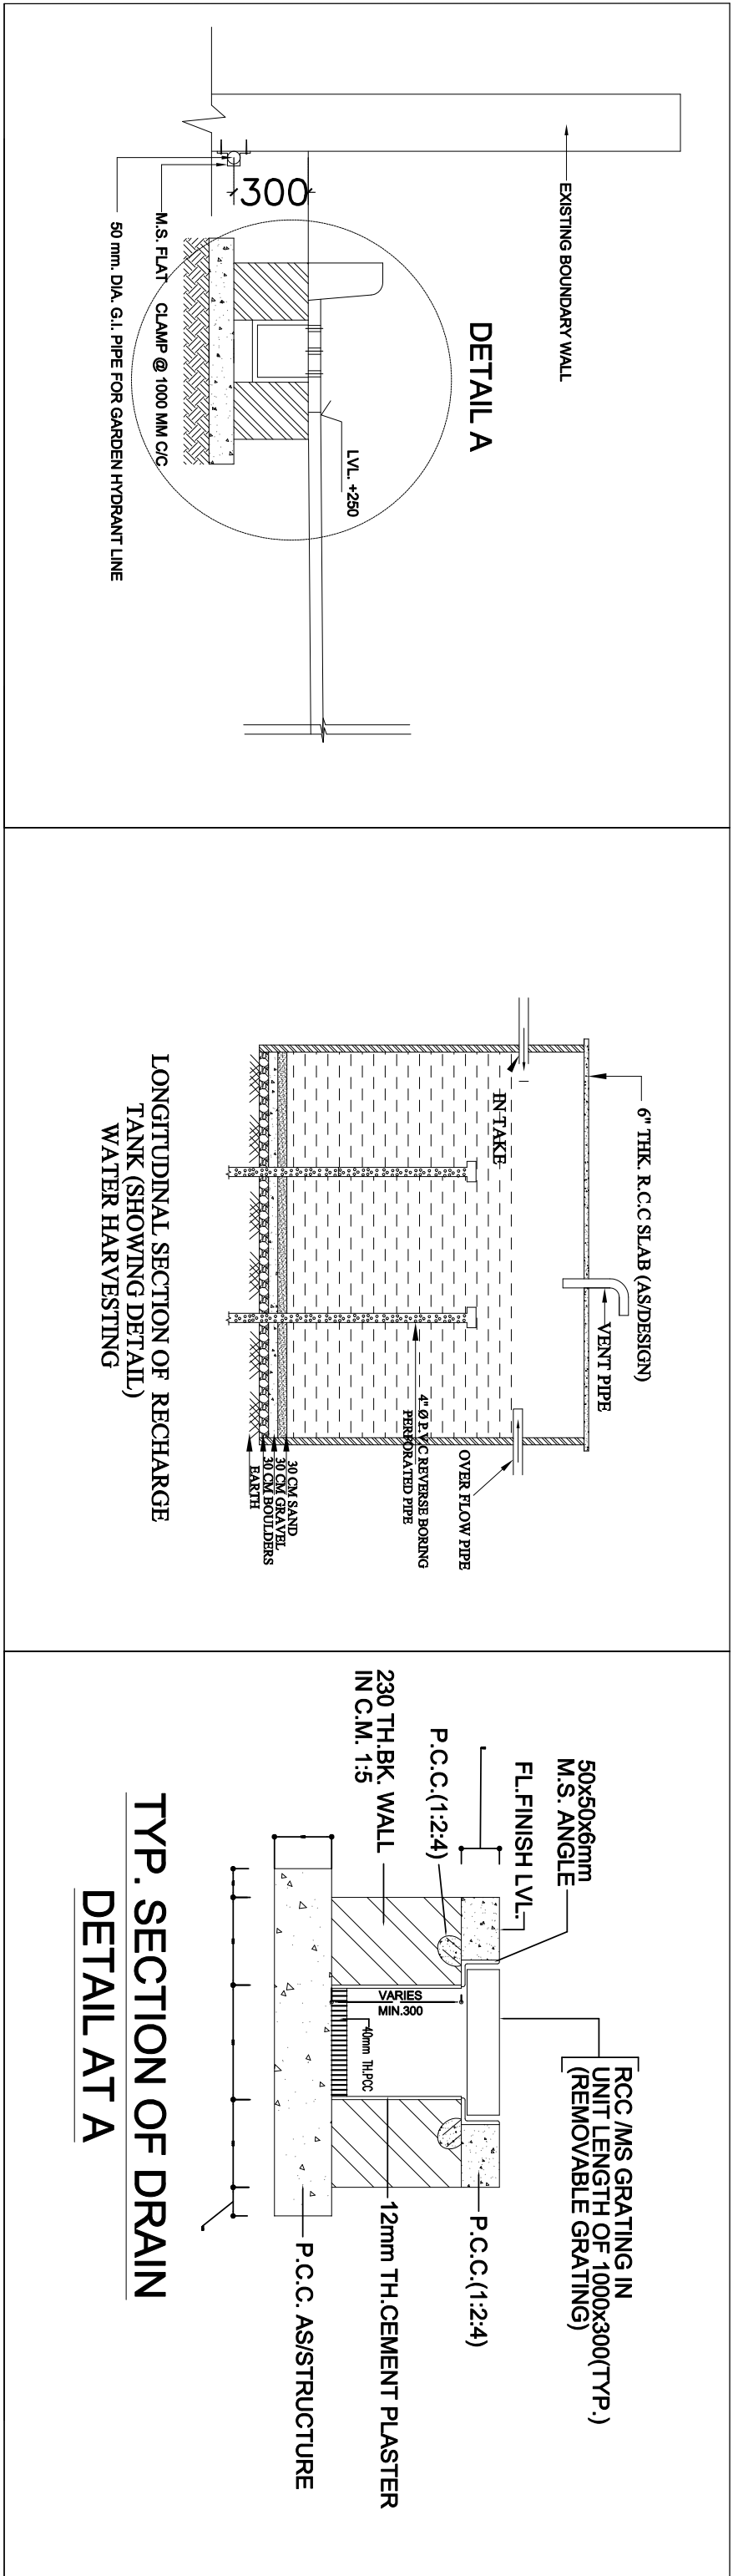

PROJECT:

DRAWING FOR THE PROPOSED

GROUP HOUSING AT PLOT-NO.GH-1

SEC.- 6 IN "WAVE CITY", NH-24GHAZIABAD

DEVELOPER COMPANY -

Uppal Chadha Hi- Tech Developers Pvt. Ltd.

Plot No.-757, Village Dasna, Kazipura More,

NH-24 Ghaziabad

OWNERS SIGN

ANUJ AGARWAL ARCHITECTS

DRAWING TITLE :

EXTERNAL SERVICES PLAN

ARCHITECTS SIGN.

SCALE	DEALT BY	DATE
DESIGN BY	CHECKED BY	DRG. NO.