


NIP HOUSING PVT. LTD.

 DIRECTOR

**ELECTRICAL
 PANEL @ BASEMENT LEVEL**

Nishant Shekhar
 NISHANT SHEKHAR
 CA/2006/39203

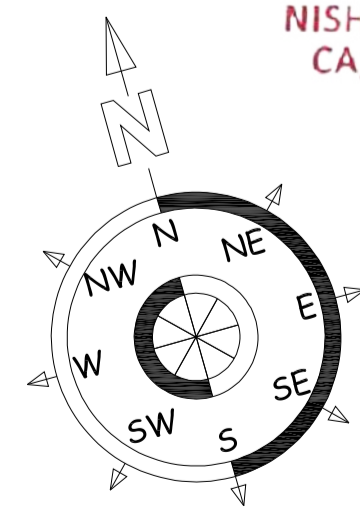


DES ARC
 ARCHITECTS, INTERIORS, PLANNING
 UG SR 1A, ANSAL PLAZA, SEC - 1, VAISHALI, GHAZIABAD, U.P.
 PH: 0120 - 4253114 M : 0-9818711273
 EMAIL- desarc14@gmail.com

PROJECT :
 PROPOSED SERVICE APARTMENTS - NIP GRAND ARCADIA AT
 PLOT NO. 69, MAUZA : JAGGAPATTI, PARGANA - KASWAR RAJA,
 TEHSIL : RAJATALAB B, DISTRICT - VARANASI, UTTAR PRADESH
 FOR M/S. NIP HOUSING PVT. LTD.


DRAWING TITLE
SITE PLAN - ELECTRICAL

DRAWING TYPE
FLOOR PLAN
 DRG. NO.

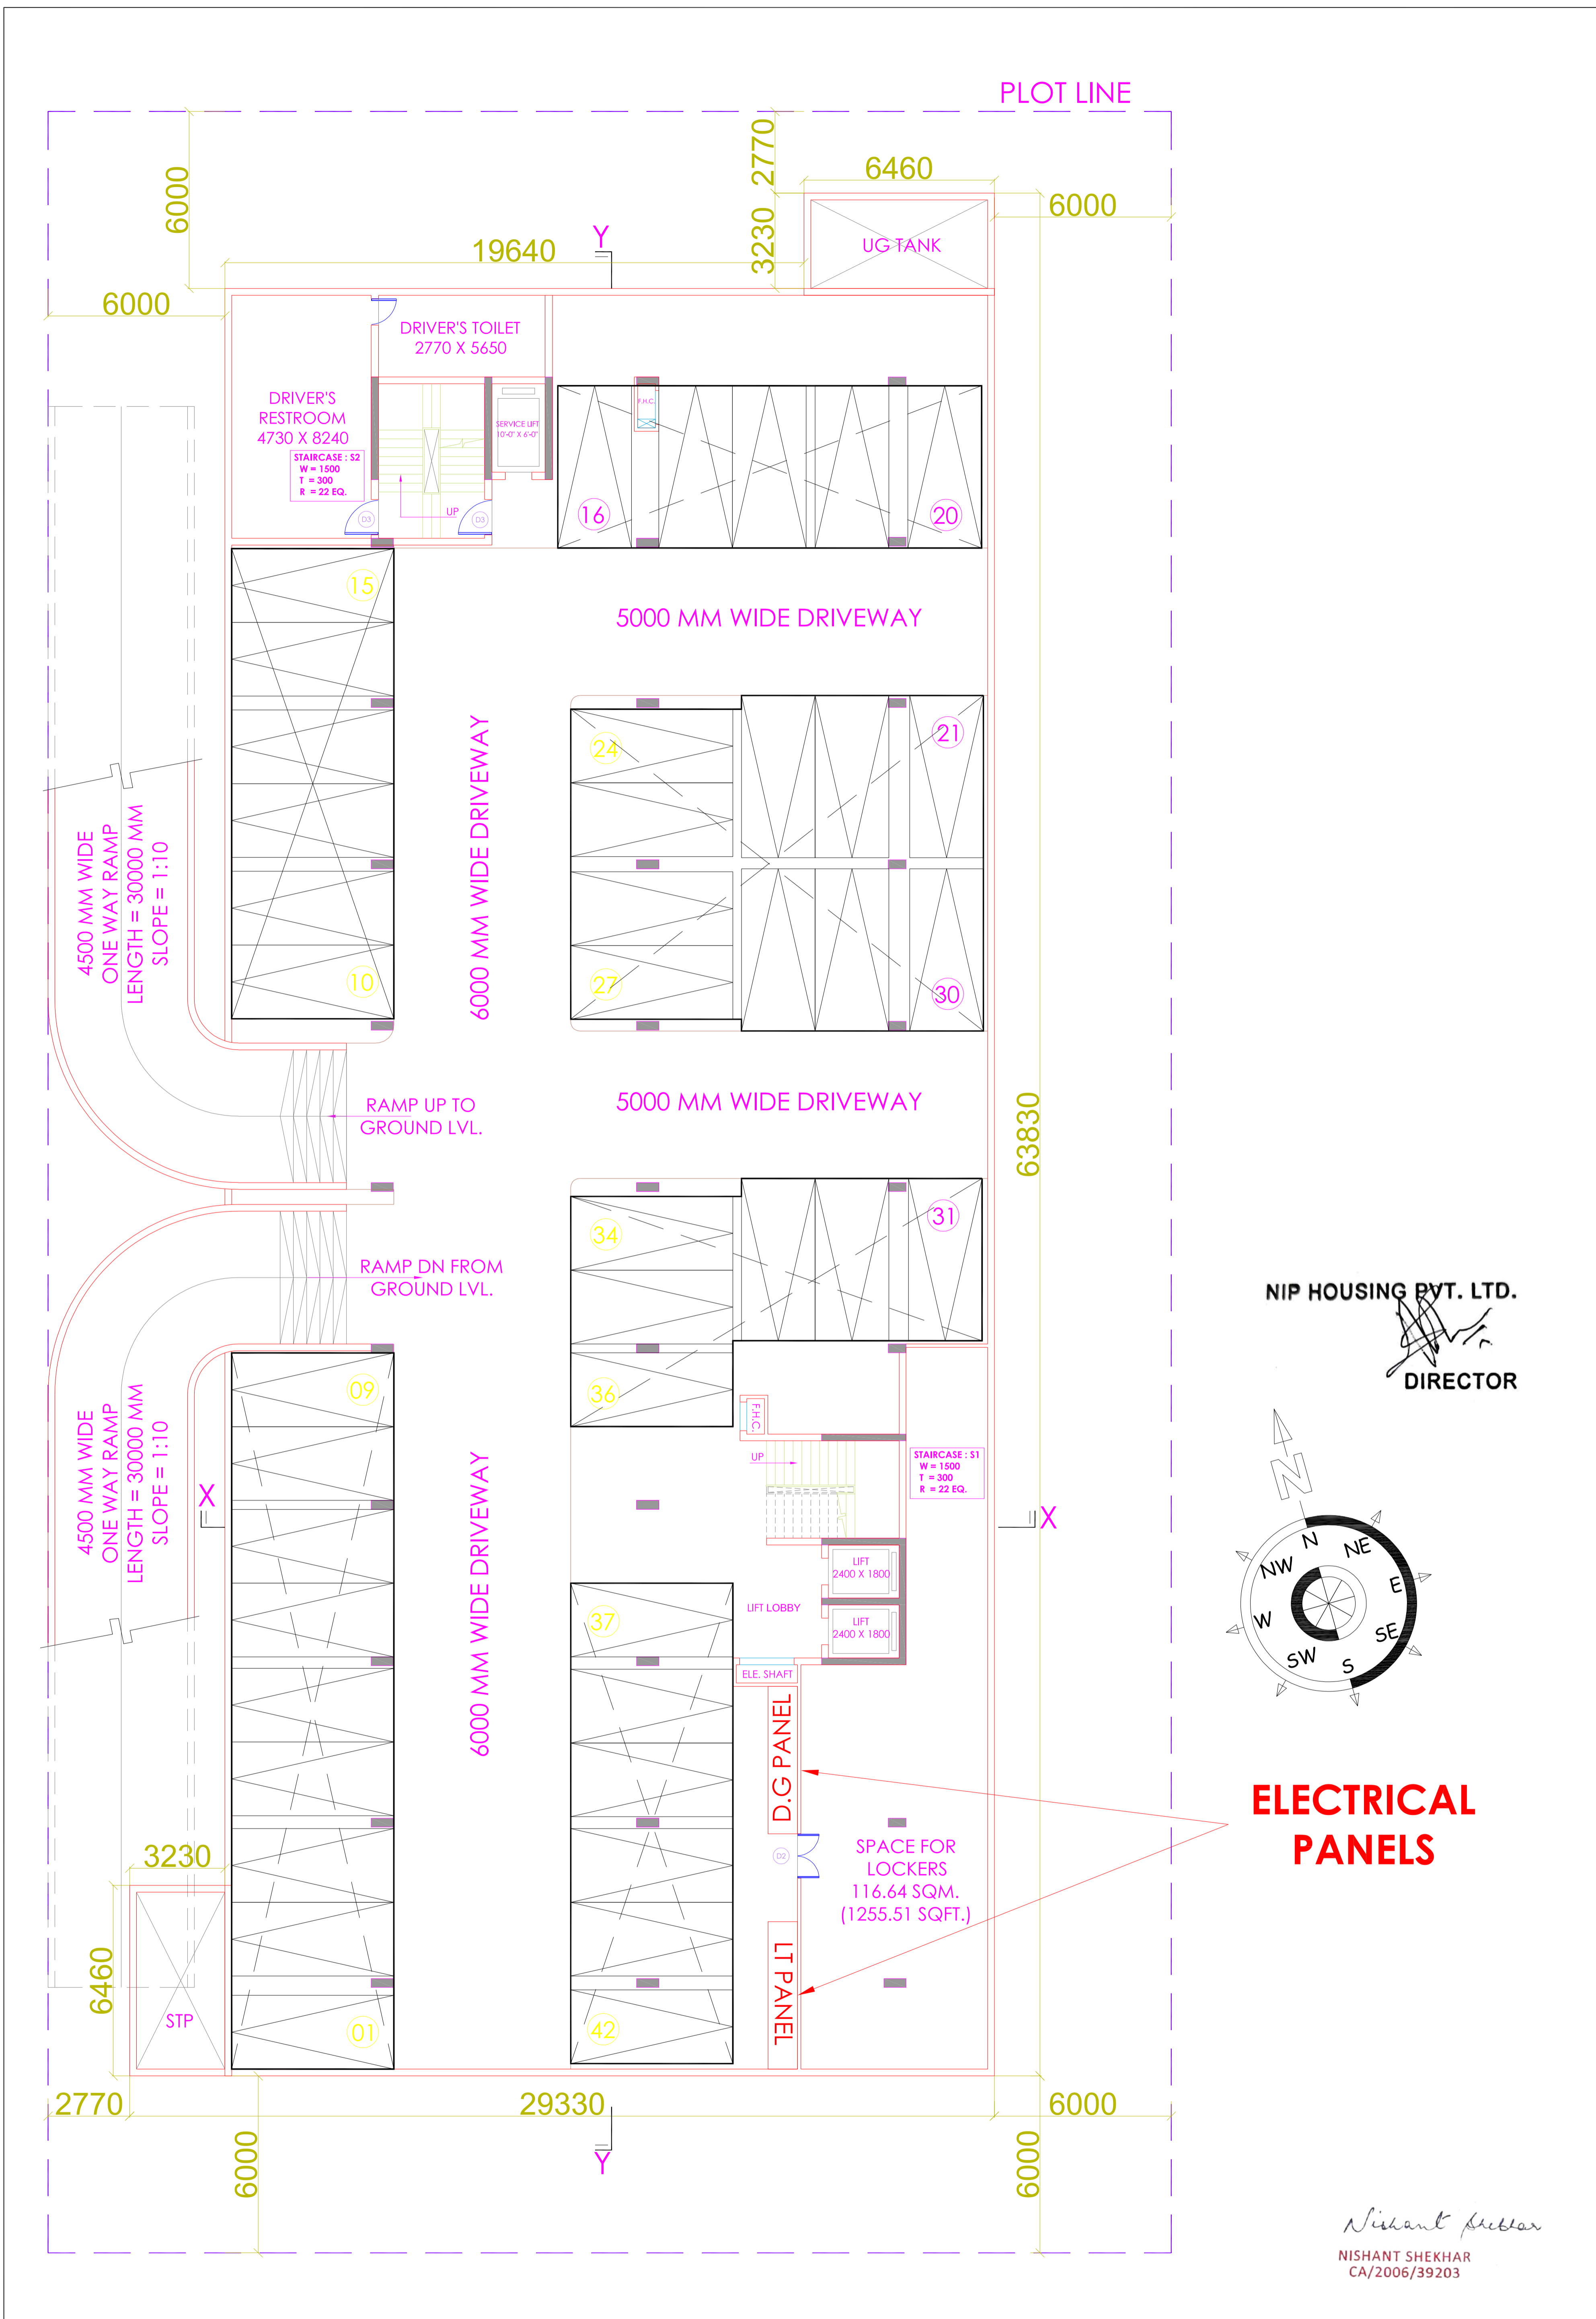

NIP HOUSING PVT. LTD.

 DIRECTOR

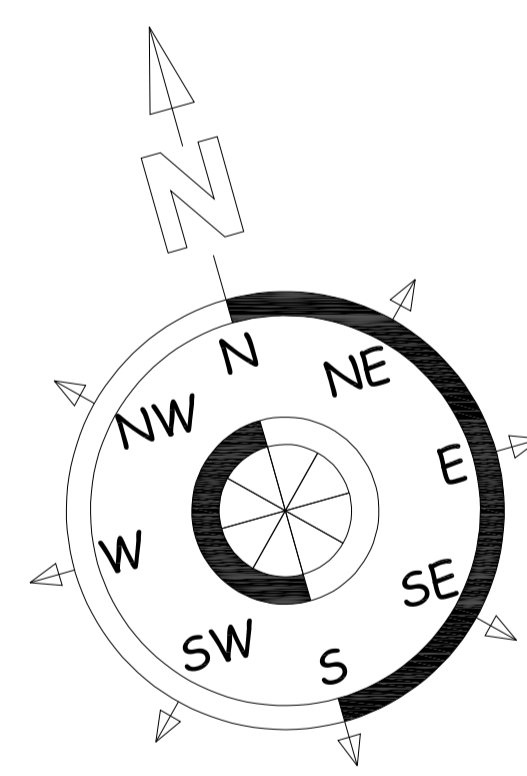

**ELECTRICAL
 PANELS**

Nishant Shekhar
 NISHANT SHEKHAR
 CA/2006/39203

<p>DES ARC ARCHITECTS, INTERIORS, PLANNING UG SR 1A, ANSAL PLAZA, SEC - 1, VAISHALI, GHAZIABAD, U.P. PH: 0120 - 4253114 M: 0-9818711273 EMAIL- desarc14@gmail.com</p>	<p>PROJECT : PROPOSED SERVICE APARTMENTS - NIP GRAND ARCADIA AT PLOT NO. 69, MAUZA : JAGGAPATTI, PARGANA - KASWAR RAJA, TEHSIL : RAJATALAB B. DISTRICT - VARANASI, UTTAR PRADESH FOR M/S. NIP HOUSING PVT. LTD.</p>	<p>DRAWING TITLE BASEMENT PLAN - ELECTRICAL</p>	<p>DRAWING TYPE FLOOR PLAN DRG. NO.</p>
--	---	--	---