


DRG. NO.

FILE. NO.

NOTES:-

- 1) All Dimensions are in MM.
- 2) The site staff should coordinate this Arch. drwg. with the relevant Str. & Services drwg. before the start of the work.
- 3) In case any discrepancy is found in the drwg. the same shall be brought to the notice of the E.I. Charge / consultant. The work shall not be carried out without clarification from the consultant.
- 4) For details of the sect. 1-1 & 2-2 ref. drawing no. -211.AR.00.03

| SYMBOL | DESCRIPTION |
|--------|---------------------------------|
| | 150 MM Ø HDPE PIPE FOR MV CABLE |
| | 150 MM Ø HDPE PIPE FOR HV CABLE |
| | 150 MM Ø HDPE PIPE FOR LV CABLE |
| | ELECTRICAL PANELS |
| | 1200X1200 MM CABLE CHAMBER |
| | 900X900 MM CABLE CHAMBER |
| | 600X600 MM CABLE CHAMBER |
| | 300X300 MM CABLE CHAMBER |
| | LA EARTHING PIT |
| | BODY EARTHING PIT |
| | NEUTRAL EARTHING PIT |
| | RCC MV CABLE TRENCH |
| | RCC HT CABLE TRENCH |

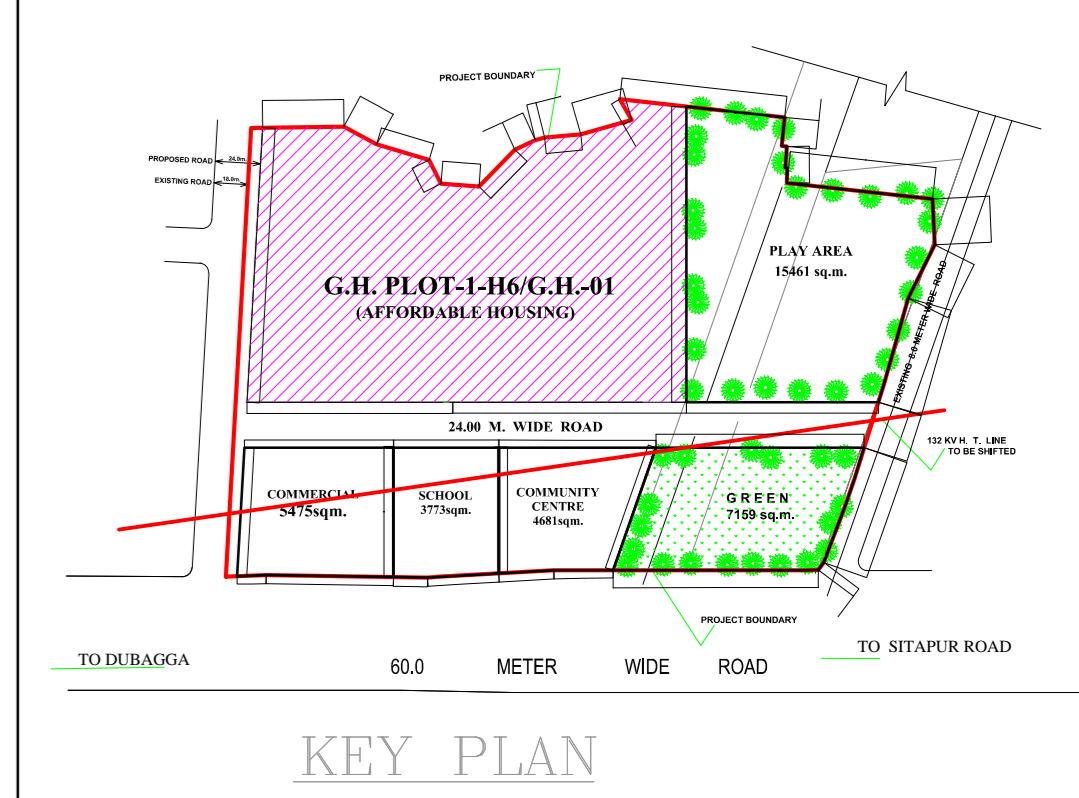

| DATE | NO. | ISSUED TO | INITIAL |
|----------|-----|--|---------|
| 08.09.16 | R1 | SITE PLAN REVISED A/P REVISION IN DIMENSION OF THE PLOT. | |
| | | BRIEF RECORD | |

REVISION

CONSULTANTS:
SAJAG CONSULTANTS
C-146 KILOKRI
NEAR MAHARANI BAGH CROSSING
NEW DELHI-110014
TELEPHONE-26343059,9868848054

| DIVISION | DRAWN | CHECKED | APPD | UNIT |
|----------|--------|---------|------|------|
| PL | VIKRAM | VIJAY | R.B. | M.M. |

DRG. NO. : 211.E00.02
SCHEME:
AMRAPALI YOJNA, HARDOI ROAD,
LUCKNOW.

DRG. TITLE:
DETAIL - D.G.TRANSFORMER &
ELECTRICAL ROOMS WITH
CABLE ROUTING

PROJECT:
GROUP HOUSING ON
PLOT NO. H6/G.H.-1

DATE: 21-04-2017

SCALE: 1:250

24.0 M WIDE ROAD

PLAY AREA

24.0 M WIDE ROAD

BENCH MARK
TOP OF CULVERT
99.117 R. 113.167)

