


24.0 M WIDE ROAD

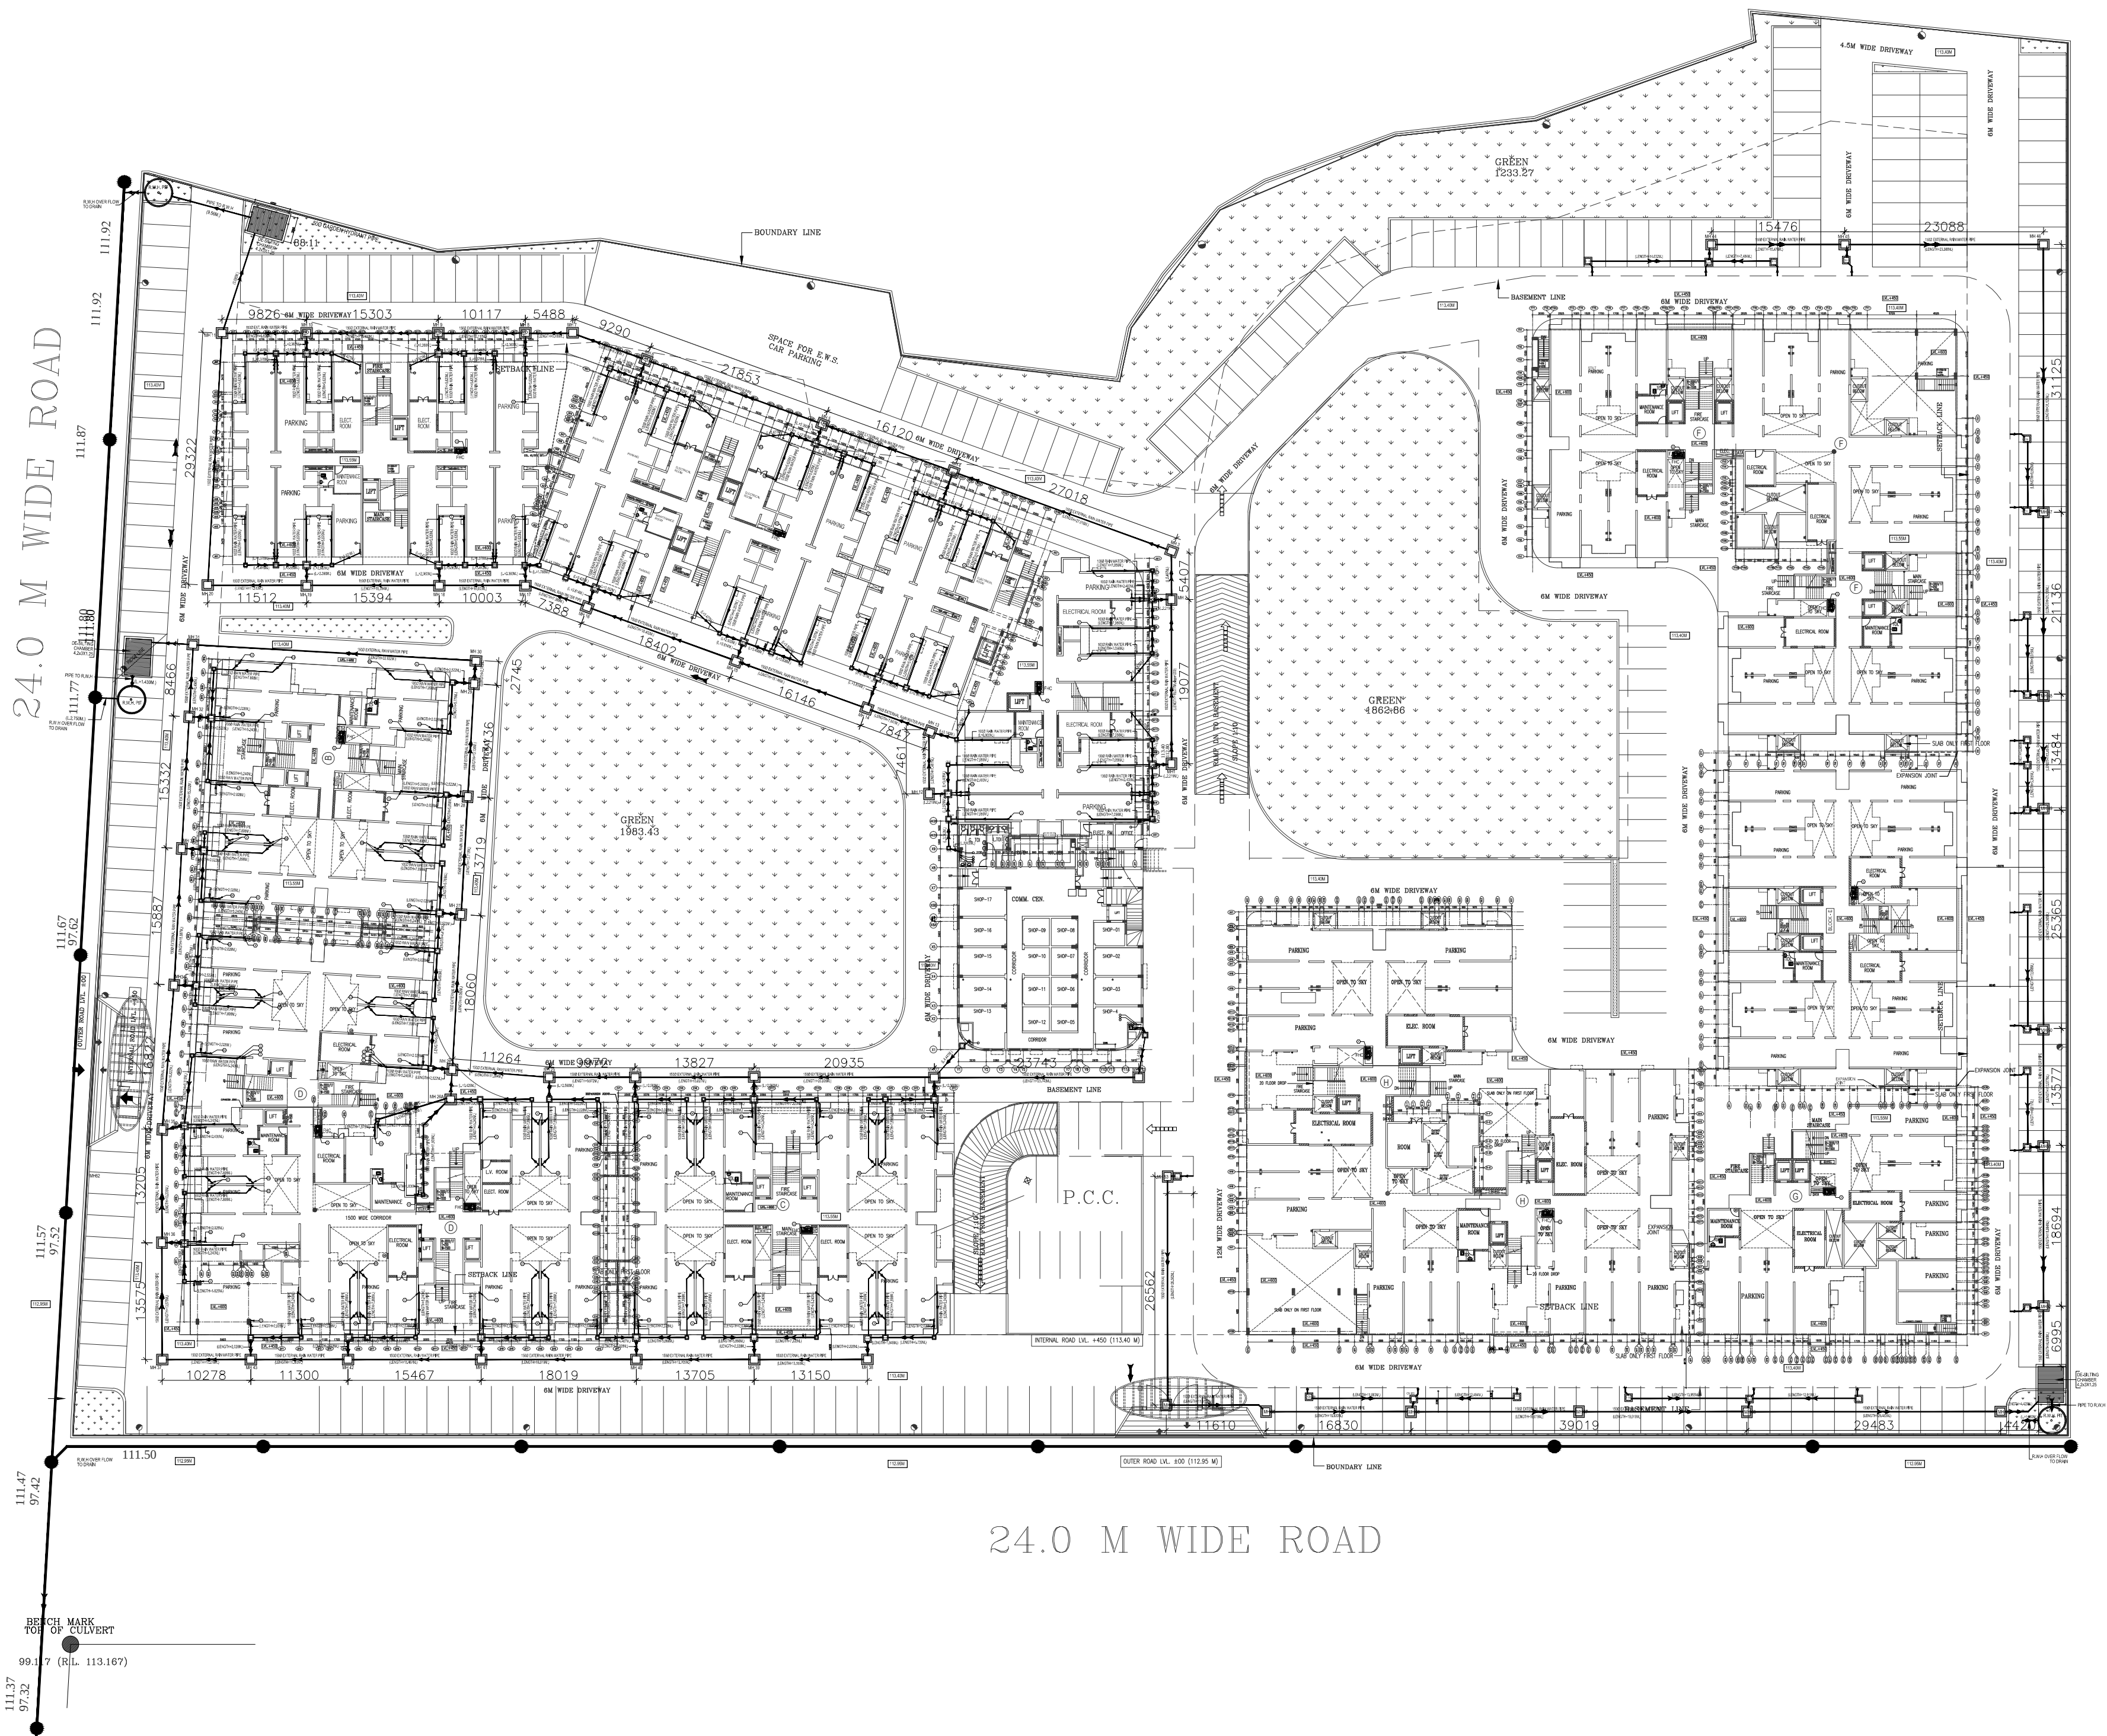

24.0 M WIDE ROAD



UPAVP
ARCHITECTURE AND PLANNING UNIT-5
NEELGIRI COMPLEX LUCKNOW.


DRG. NO.

FILE. NO.

NOTES:-

- 1) All Dimensions are in MM.
- 2) The site staff should coordinate this Arch. drwg. with the relevant Str. & Services drwg. before the start of the work.
- 3) In case any discrepancy is found in the drwg. the same shall be brought to the notice of the E.I. Charge / consultant. The work shall not be carried out without clarification from the consultant.
- 4) For details of the sect. 1-1 & 2-2 ref. drawing no.. -211.AR.00.03

	CUTOUT
	900X800mm. MANHOLE(DRAINAGE)
	450mmx450mm. CATCH BASIN
SEWERAGE	INTERNAL U.P.V.C SWR PIPE
WATER SUPPLY	EXTERNAL C.P.V.C PIPE

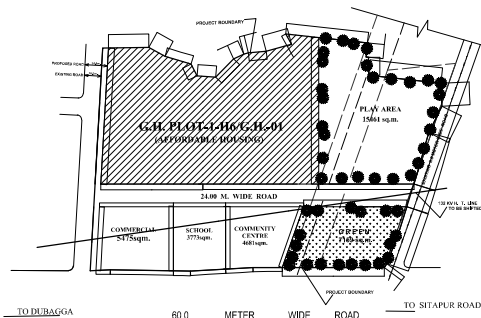

KEY PLAN

NOTE:-
FOR SITE SECTIONS REFER
DRAWING NO. - 211.AR.00.03

DATE	NO.	ISSUED TO	INITIAL
------	-----	-----------	---------

08.09.16	R1	SITE PLAN REVISED A/P REVISION IN DIMENSION OF THE PLOT.	
DATE	REV. NO.	BRIEF RECORD	INITIAL

REVISION

CONSULTANTS:
SAJAG CONSULTANTS
C-146 KILOKRI
NEAR MAHARANI BAGH CROSSING
NEW DELHI-110014
TELEPHONE-26343059,9868848054

DIVISION	DRAWN	CHECKED	APPD	UNIT
PL_	VIKRAM	VIJAY	R.B.	M.M.

DRG. NO. : 211.RH.00.04

SCHEME:
AMRAPALI YOJNA, HARDOI ROAD,
LUCKNOW.

DRG. TITLE:

RAIN WATER HARVESTING PLAN

PROJECT:
GROUP HOUSING ON
PLOT NO. H6/G.H.-1

DATE: 21-04-2017

SCALE: 1:200