



DRG. NO.

FILE NO.


NOTES:-

- 1) All Dimensions are in MM.
- 2) The site staff should coordinate this Arch. drwg. with the relevant Str. & Services drwg. before the start of the work.
- 3) In case any discrepancy is found in the drwg. the same shall be brought to the notice of the E.I. Charge / consultant. The work shall not be carried out without clarification from the consultant.
- 4) For details of the sect. 1-1 & 2-2 ref. drawing no.. -211.AR.00.03

SCHEDULE OF PIPES

PIPE NO.	DESCRIPTION
①	100mm SWR PVC SOIL VENT PIPE
②	100mm SWR PVC WASTE VENT PIPE
③	75mm SWR PVC ANTISYPHONAGE PIPE
④	100mm SWR PVC KITCHEN WASTE PIPE
⑤	100mm SWR PVC RAIN WATER PIPE
⑥	100mm SWR PVC RAIN BALCONY DRAINAGE PIPE
⑦	DOMESTIC WATER RISER PIPE
⑧	DOMESTIC WATER SUPPLY PIPE
FD	FLOOR DRAIN
FT	FLOOR TRAP
NT	NAHANI TRAP
CUTOUT	CUTOUT
300mmx300mm.	GULLY TRAP
900mm.DIA	MANHOLE(SEWERAGE)
900x800mm.	MANHOLE(DRAINAGE)
600mm.x600mm.x600mm.	CHAMBER
450mm.x450mm.	CATCH BASIN

	INTERNAL	EXTERNAL
SEWERAGE	U.P.V.C SWR PIPE	U.P.V.C SWR PIPE
WATER SUPPLY	C.P.V.C PIPE	C.P.V.C PIPE/D.I.

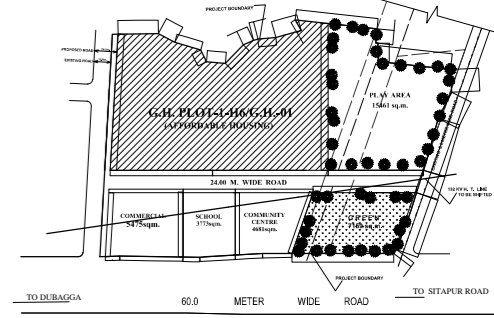

KEY PLAN

DATE	NO.	ISSUED TO	INITIAL

DATE	REV. NO.	BRIEF RECORD	INITIAL
08.09.16	R1	SITE PLAN REVISED A/P REVISION IN DIMENSION OF THE PLOT.	

REVISION

CONSULTANTS:  
**SAJAG CONSULTANTS**  
C-146 KILOKRI  
NEAR MAHARANI BAGH CROSSING  
NEW DELHI-110014  
TELEPHONE-26343059,9868848054

DIVISION	DRAWN	CHECKED	APPD	UNIT
PL	VIKRAM	VIJAY	R.B.	M.M.

DRG. NO. : 211.ES.00.01


SCHEME:  
AMRAPALI YOJNA, HARDOI ROAD,  
LUCKNOW.

DRG. TITLE:  
EXTERNAL SEWERAGE LAYOUT PLAN

PROJECT:  
GROUP HOUSING ON  
PLOT NO. H6/G.H.-1

DATE: 21-04-2017

SCALE: 1:200

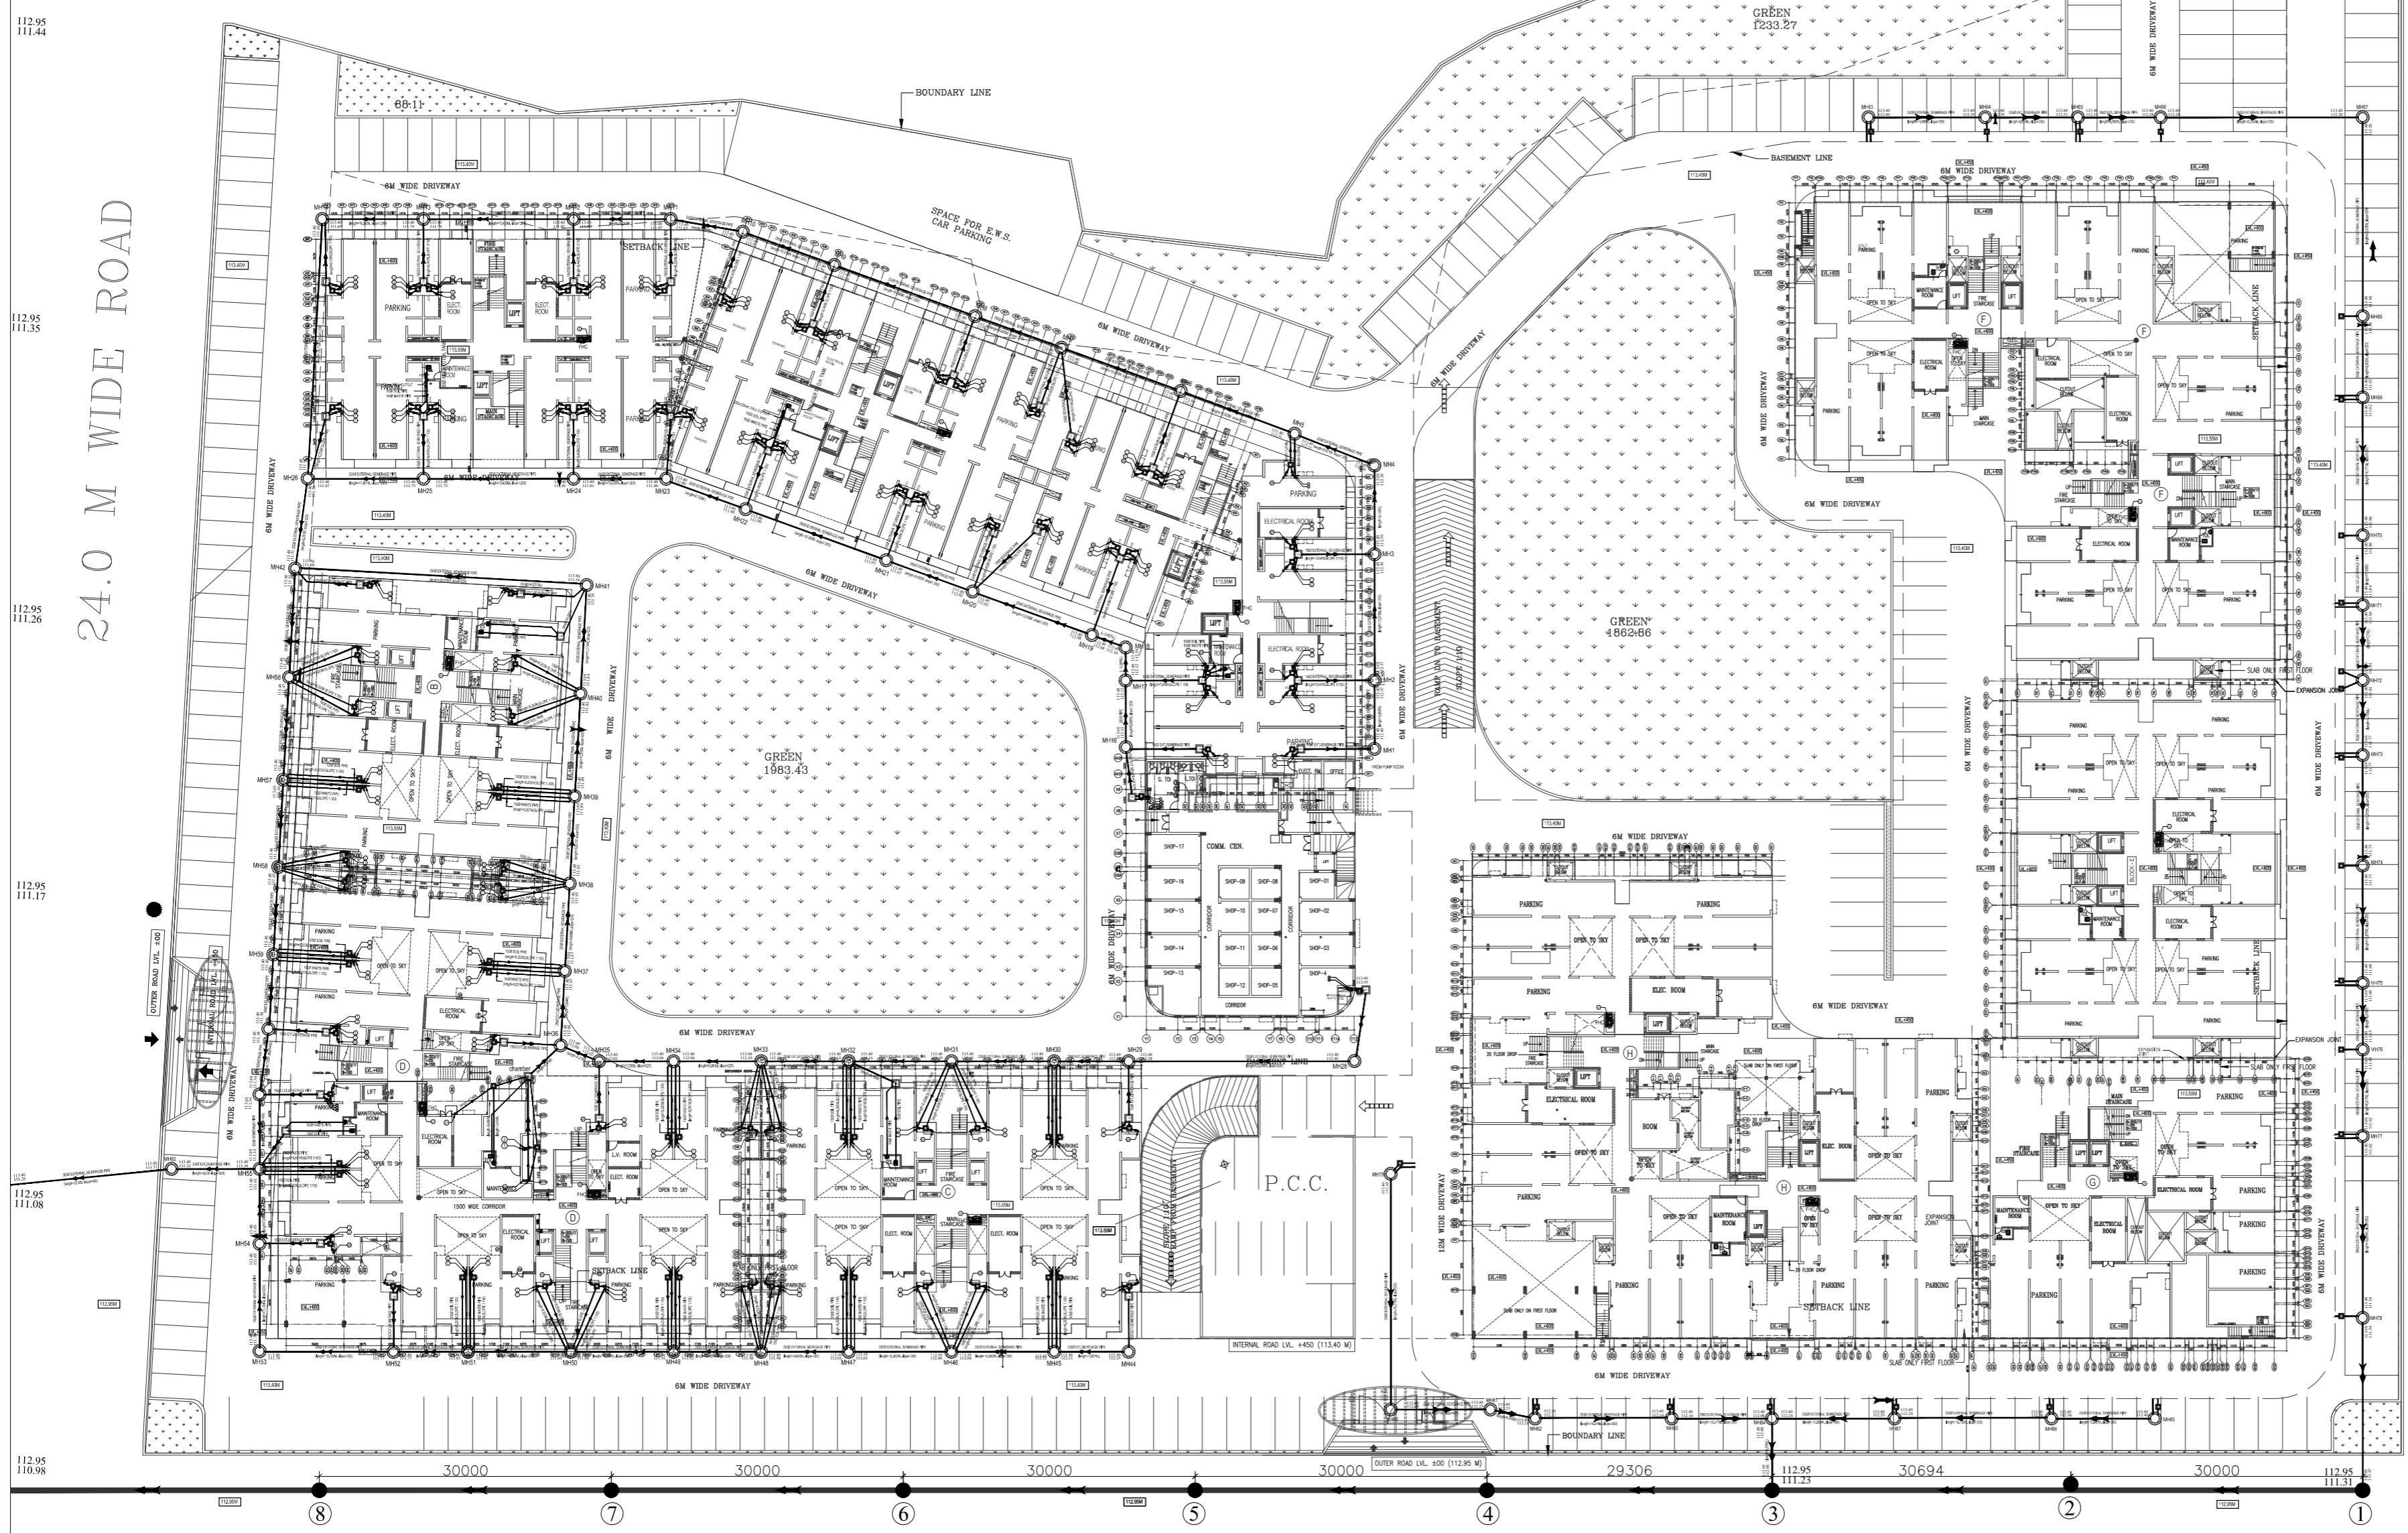

112.95  
111.44  
112.95  
111.35  
112.95  
111.26  
112.95  
111.17  
112.95  
111.08  
112.95  
110.98

24.0 M WIDE ROAD

24.0 M WIDE ROAD

PLAY AREA

BENCH MARK  
TOP OF CULVERT  
99.117 (R/L. 113.167)