

30.0 M. WIDE ROAD



45.0 M. WIDE ROAD

45.0 M. WIDE ROAD

IN 1ST BASEMENT
RAW WATER TANK
CAP. 250 KL
DOMESTIC WATER TANK IN
TWO COMPARTMENT
CAP. = 100KL+150= 250KL

IN LOWER GROUND FLOOR
FIRE WATER TANK
IN 3 COMPARTMENT=
CAP. = 320KL+265+255= 840KL

IN 2ND BASEMENT
STP CAP. 700 KLD

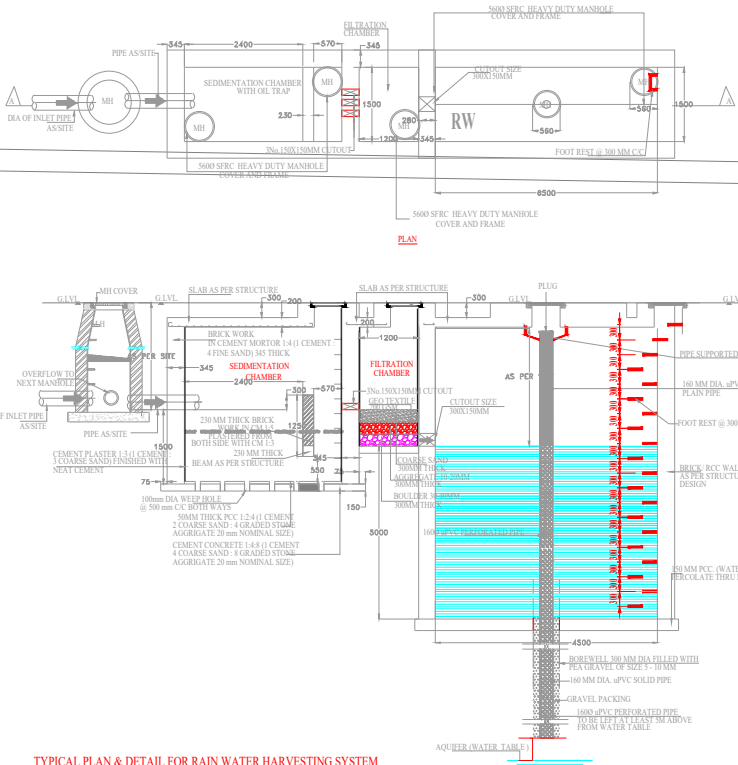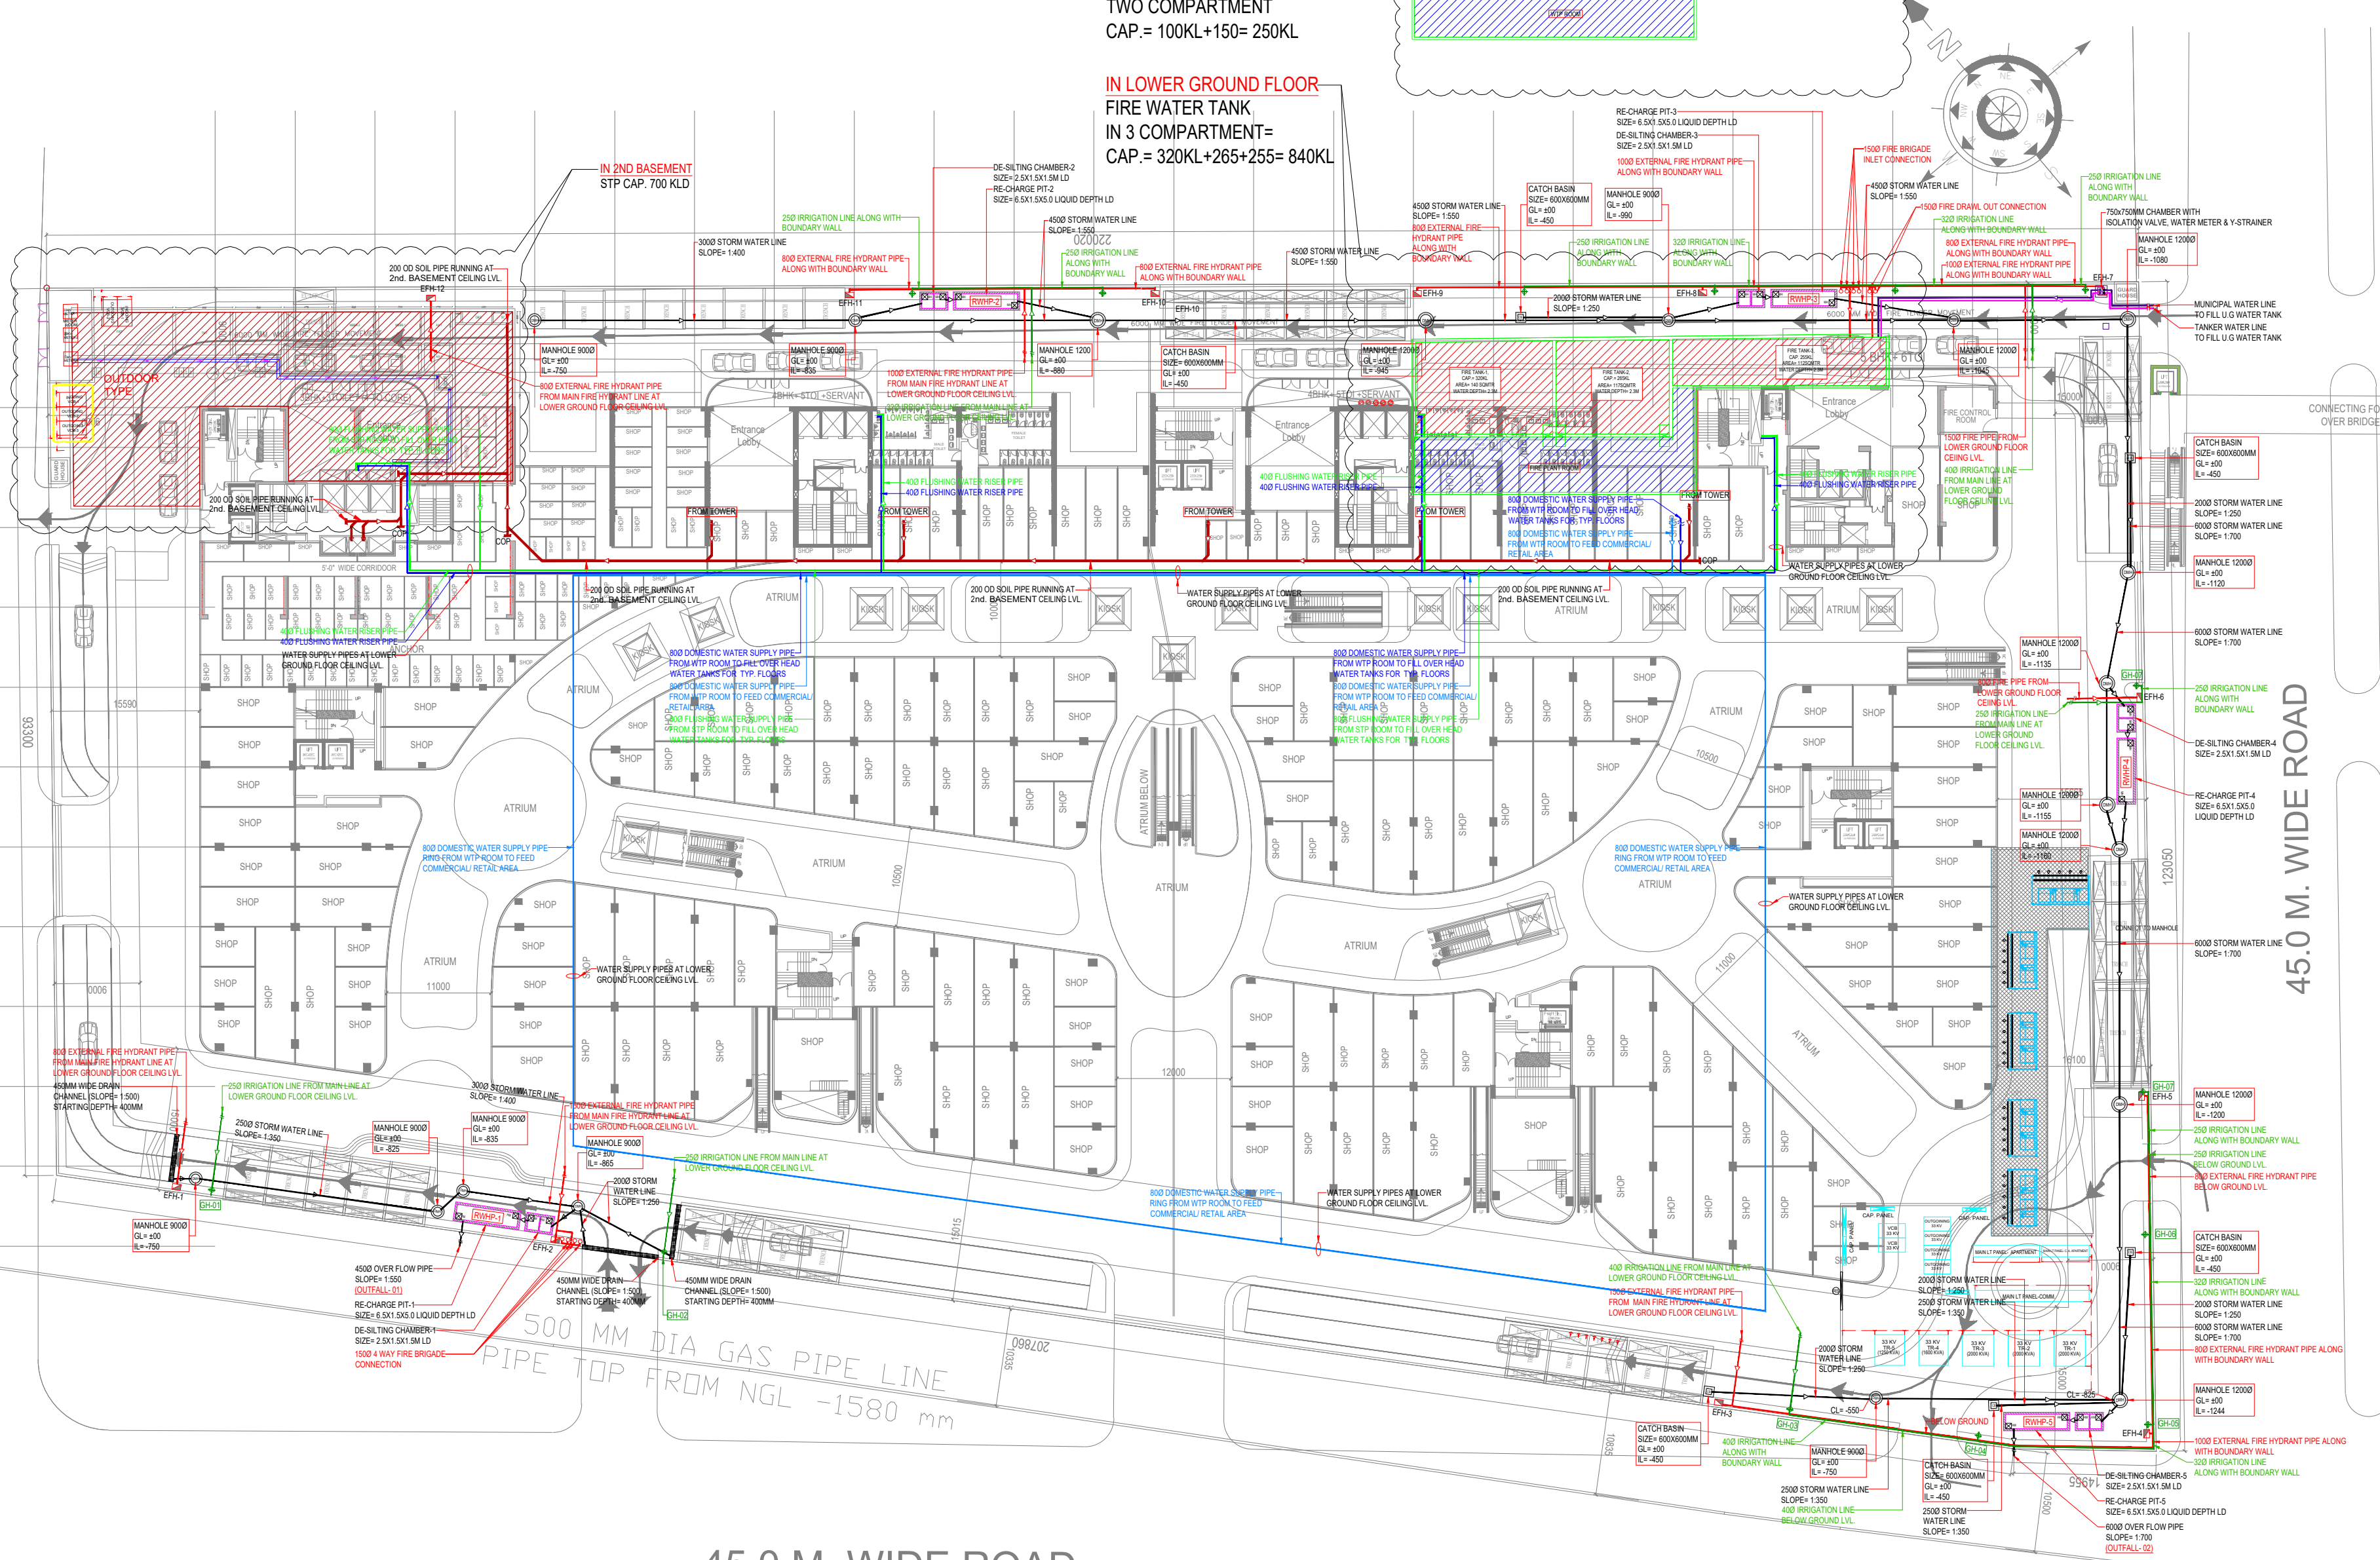

LEGENDS FOR : WATER SUPPLY

SYM.	DESCRIPTION
—	MUNICIPAL WATER SUPPLY LINE
—	TANKER WATER SUPPLY LINE
—	WATER SUPPLY LINE FOR RETAIL/ COMMERCIAL AREA
—	DOMESTIC WATER SUPPLY LINE FOR TYP. FLOOR
—	FLUSHING WATER SUPPLY LINE FOR TYP. FLOOR
—	IRRIGATION WATER SUPPLY LINE
+	GARDEN HYDRANT

LEGENDS FOR : SEWERAGE





SYM.	DESCRIPTION
—	SEWERAGE LINE

LEGENDS FOR : STORM WATER

SYM.	DESCRIPTION
—	CATCH BASIN
—	CIRCULAR STORM WATER MANHOLE
G.L.	GROUND LVL.
I.L.	INVERT LVL.
C.L.	CONNECTION LVL.
—	STORM WATER LINE (FOR ROOF WATER)
—	DE-SILTING CHAMBER-1 SIZE= 2.5X1.5X1.5M LD & RE-CHARGE PIT-1, SIZE= 6.5X1.5X5.0 LIQUID DEPTH LD

LEGENDS FOR : FIRE FIGHTING

SYM.	DESCRIPTION
—	FIRE LINE BELOW GROUND LVL.
EFH	EXTERNAL FIRE HYDRANT

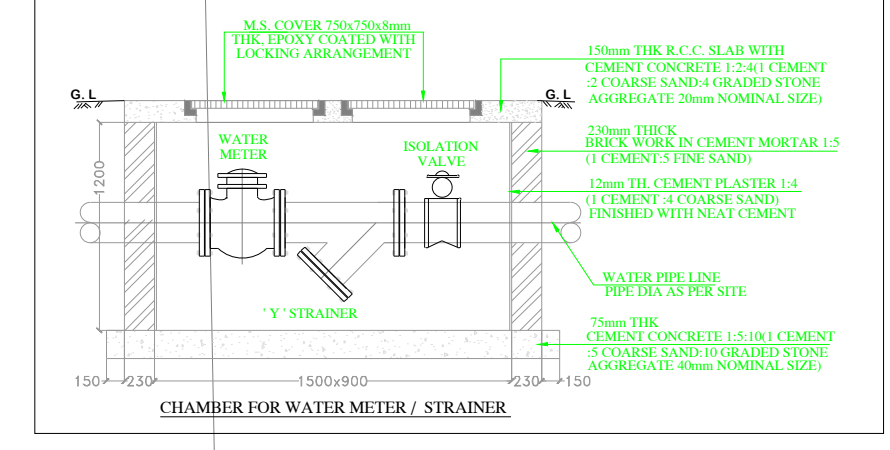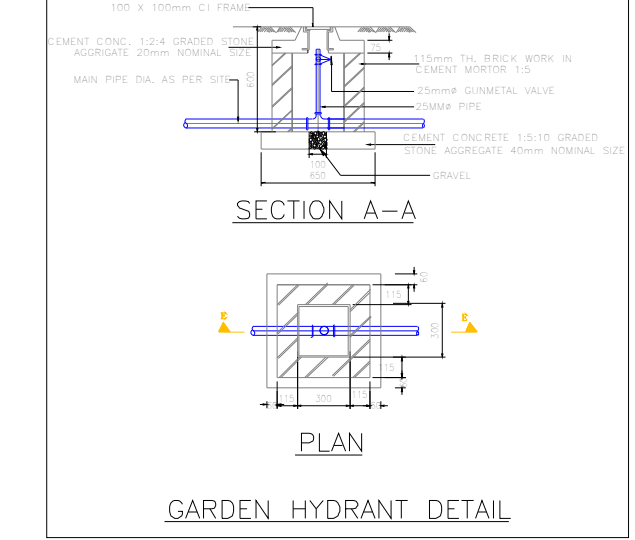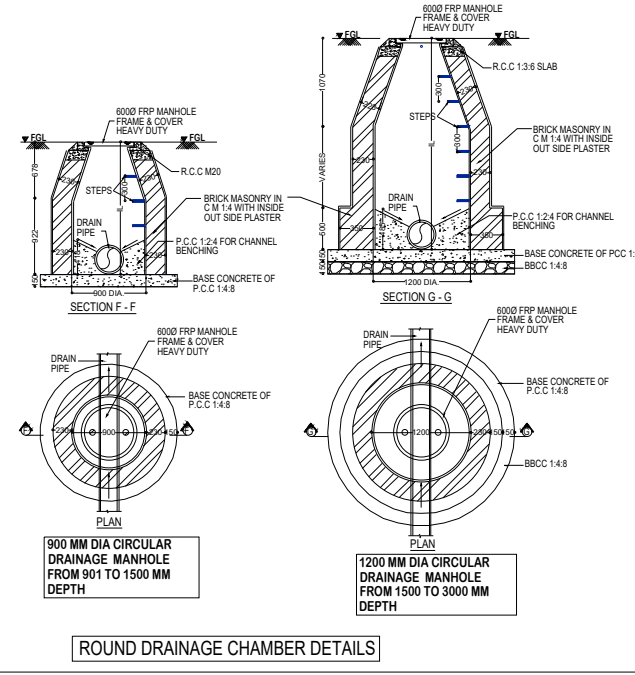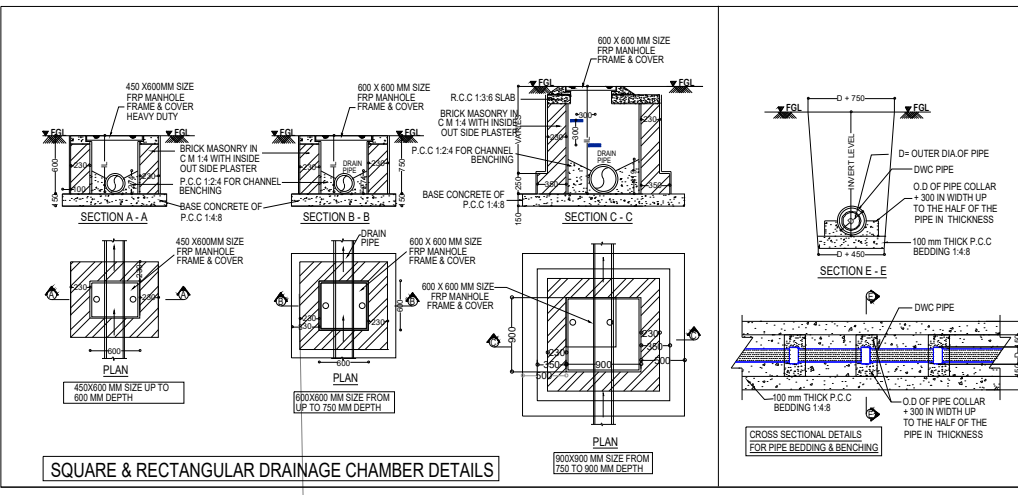

SITE PLAN DEVELOPMENT PLAN

PROJECT:-
APPROVAL OF BUILDING PLAN OF COMMERCIAL SITE
AT PLOT NO. H-6, SECTOR -97, NOIDA.
M/S MAYFAIRSKY ESTATES PRIVATE LIMITED.

TITLE:- SITE PLAN

Prepared by	Checked by	Approved by
Drawn by	Reviewed by	Authorized by
Scale	Sheet	Page

SCALE: 1:200 SHEET: 01