


FOR SANCTION

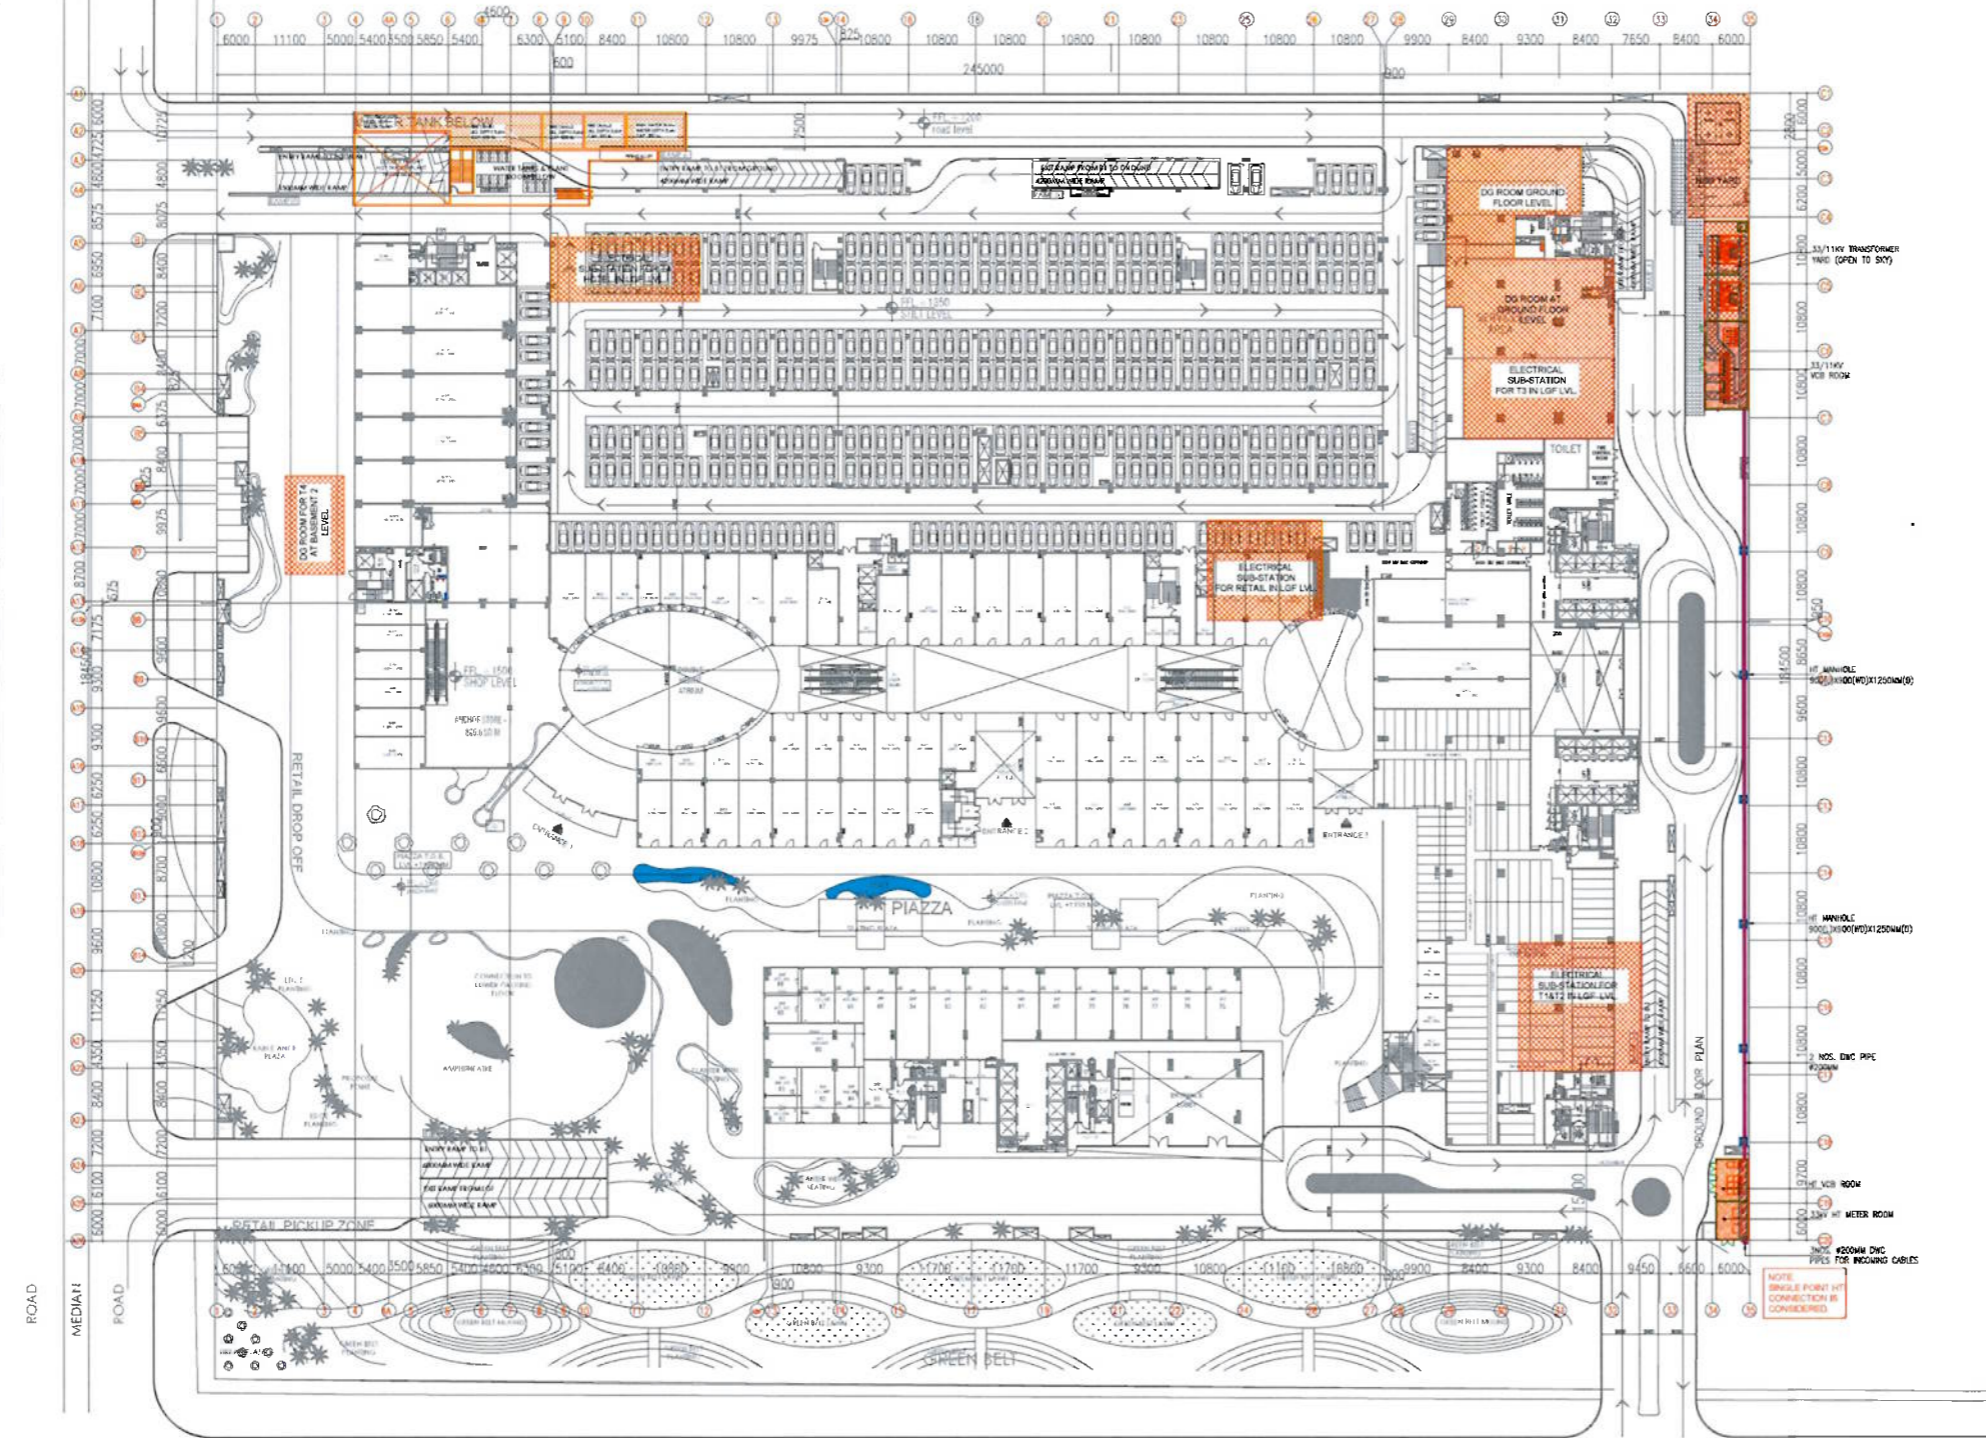

ELECT. LEGEND
 ■ HT MANHOLE
 — DWC PIPE FOR HT SYSTEM



IT INFRASTRUCTURE PARK PRIVATE LTD.
Cropal Goyal

Authorised Signatory

IT INFRASTRUCTURE PARK PVT.LTD.
 OFFICE: 82, Sukhdev Vihar, New Delhi 110 025, India. Tel: 26524400, www.proion.net

VASTUNIDHI
 Vastunidhi
 82, Sukhdev Vihar, New Delhi 110 025, India. Tel: 26524400, www.proion.net

Proion Consultants Private Limited
 Building Services - MEP Consulting
 82, Sukhdev Vihar, New Delhi 110 025, India. Tel: 26524400, www.proion.net

ARCHITECT'S SIGNATURE: _____ OWNERS SIGNATURE: _____

ELECTRICAL LAYOUT		NORTH	
SUBMISSION DRAWING			
DRAWN BY: _____	DESIGNED BY: _____	CHECKED BY: _____	D.O. DATE: _____
SHEET NO: _____	SCALE: _____	SHEETS: _____	1 of 40
PROJECT NUMBER: PCL/CG-140A-EL-100	REV. NO. _____		RI