


SITE PLAN

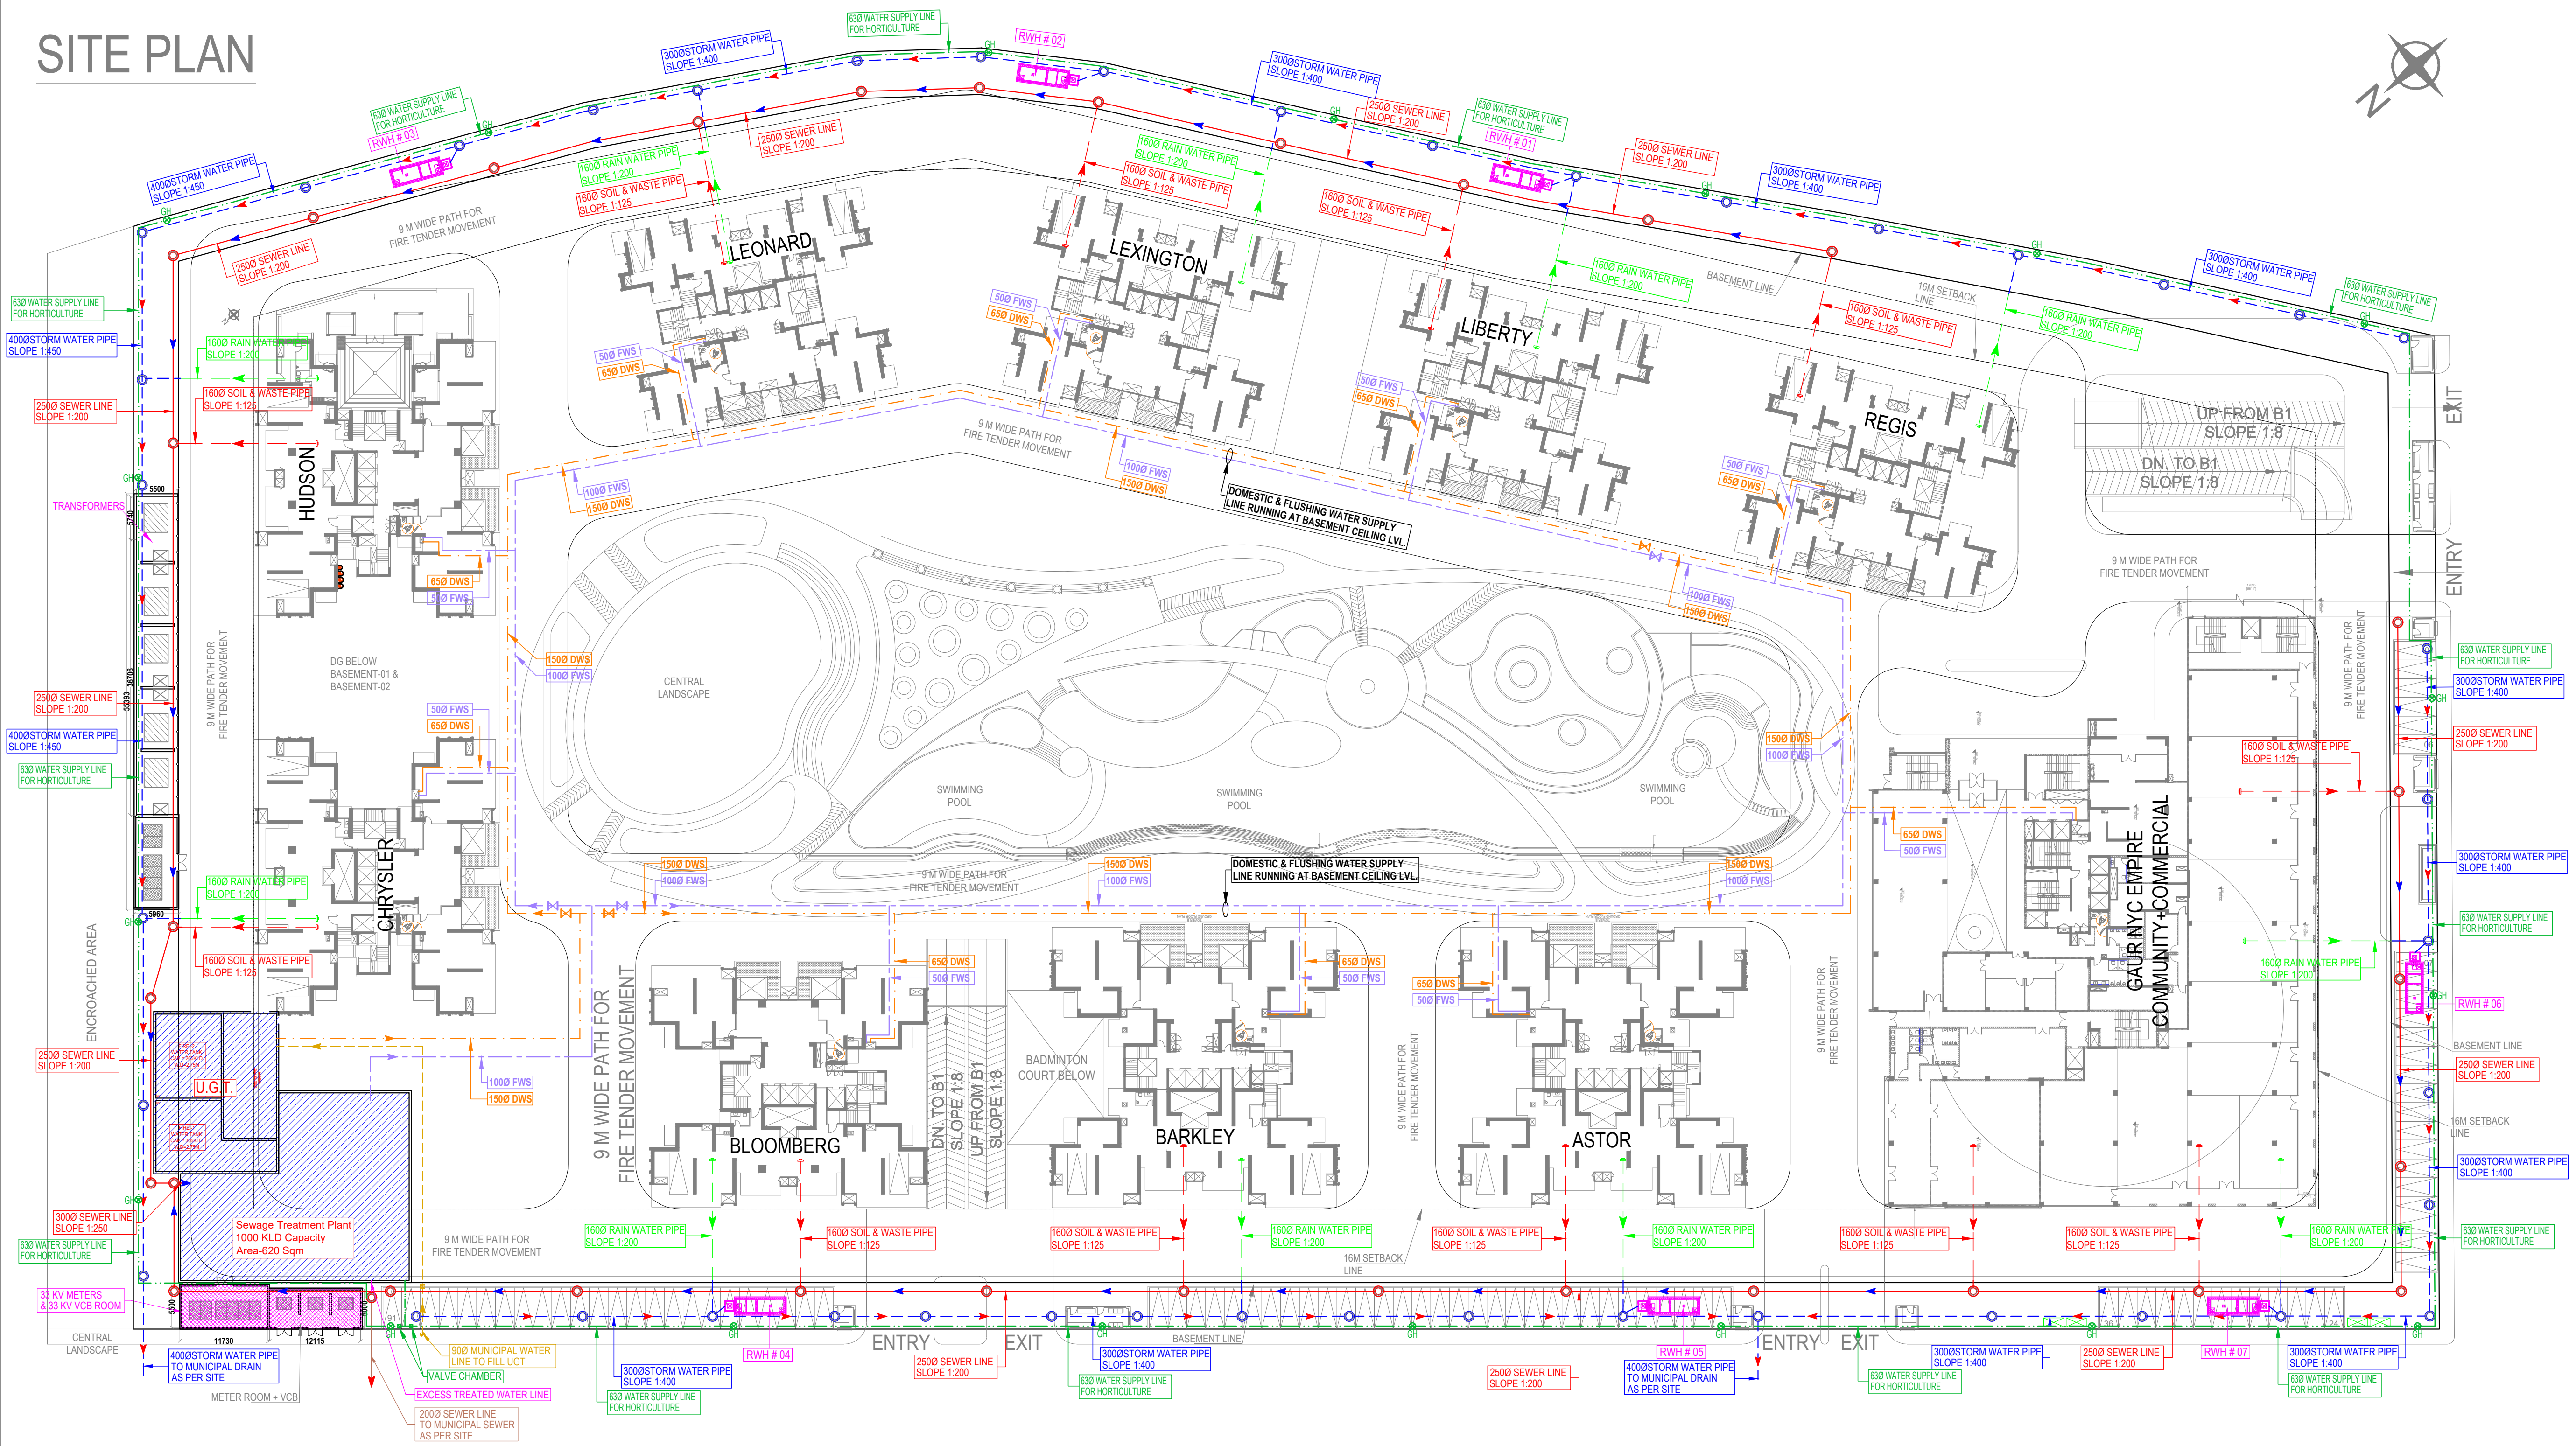

LEGEND :		
S. No.	SYMBOL	DESCRIPTION
1.		MANHOLE
2.		SEWER LINE
3.		CATCH PIT
4.		UNDER GROUND PIPE DRAIN
5.		RAIN WATER HARVESTING
6.		DOMESTIC WATER SUPPLY (DWS)
7.		FLUSHING WATER SUPPLY (FWS)
8.		MUNICIPAL WATER SUPPLY PIPE LINE
9.		MASONRY CHAMBER FOR ISOLATING VALVE
10.		RECYCLED WATER SUPPLY LINE FOR HORTICULTURE
11.		GARDEN HYDRANT
12.		VALVE CHAMBER

project **PROPOSED GAUR NYC RESIDENCES.**
AT PLOT NO 6, GROUP HOUSING AT SEC 3, NH-24,
WAVE CITY, GHAZIABAD. (U.P.)

title
SITE PLAN

subtitle
EXTERNAL SERVICES LAYOUT

drawing released for
☐ APPROVAL ☒ SUBMISSION
☐ ADVANCE COPY ☐ CONSTRUCTION

drwg. no. CES / SP / PL-04 drawn by S.Bhandari

scale 1:500@ A1 designed by Shakir Shabbir

date 01.06.2024 checked by Anand Havela

architects
Confluence
NEW DELHI, INDIA
B-421,NFC Ph-91-11-26925684 ccs@inconfluence.com Member of IGC
N.D-65,INDIA Ph-91-11-40564768 www.inconfluence.com ISO-9001:2000
architecture urban design hospitality interiors

services consultant
Consummate Engineering Services (P) Ltd.
Noida Office : B - 67, Sector - 67, Noida - 201 301
Tel. : (0120) 2303500 (30 Lines)
Lko. Office : R 006, Rohtas Plumeria, Gomti Nagar, Lucknow
e mail : mail@cespl.in, website : www.cespl.in