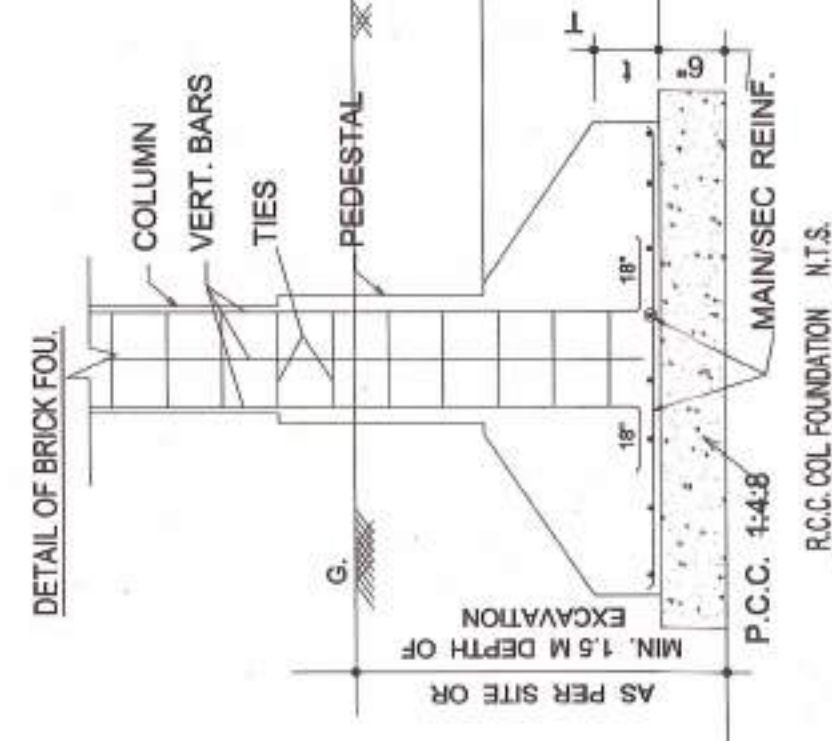




FOR BUILDING HT. PARKING FLOOR, GROUND, +3TH FOLLOWING SYSTEM SHOULD BE PROVIDED.

1. A O.H. TANK OF 70,000 Lts.
2. AN UNDER GROUND WATER STORAGE TANK OF 50,000 Lts.
3. ONE FIRE PUMP NEAR GROUND FLOOR.
4. ONE RISING MAIN 4" DIA FOR WET RISER CUM DOWN INDUCT WITH END VALVE ETC.
5. TWO KEY FIRE SERVICE INLETS NEAR GROUND.
6. ADEQUATE NUMBER OF FIRE HYDRANTS NEAR GROUND.

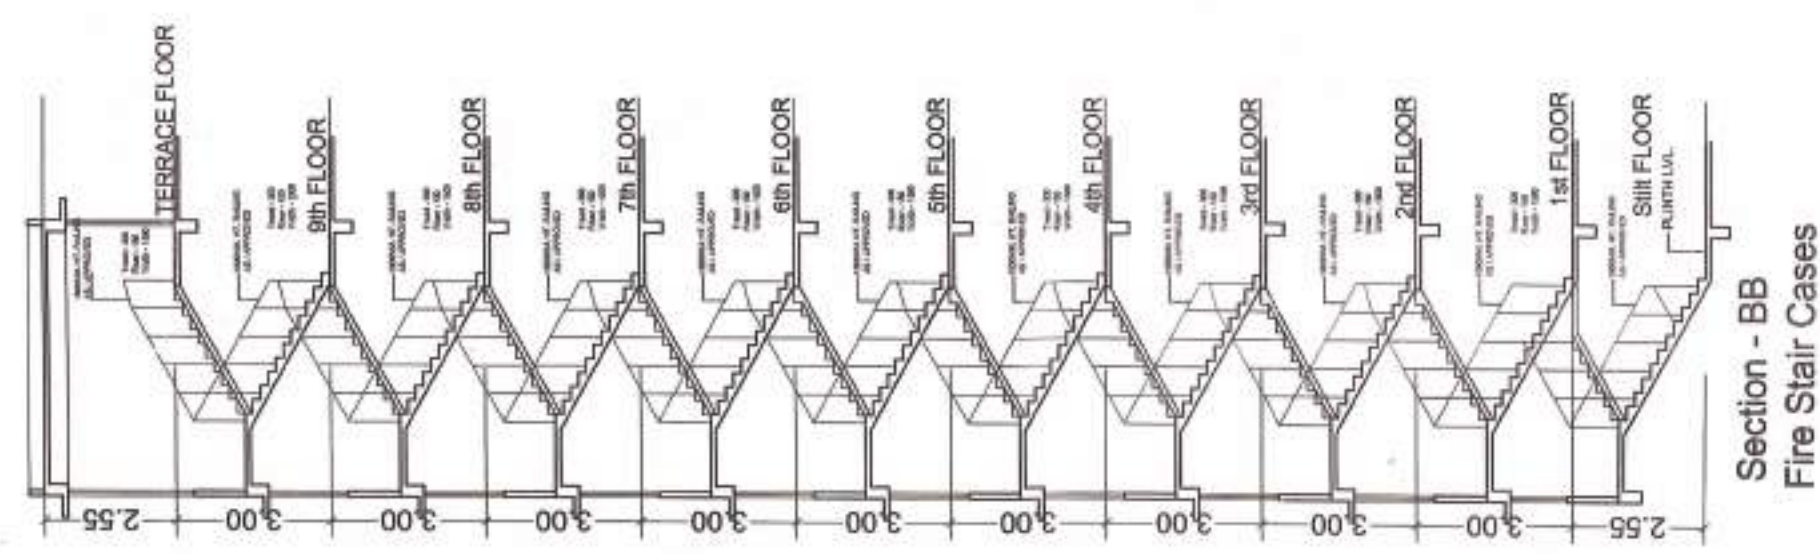
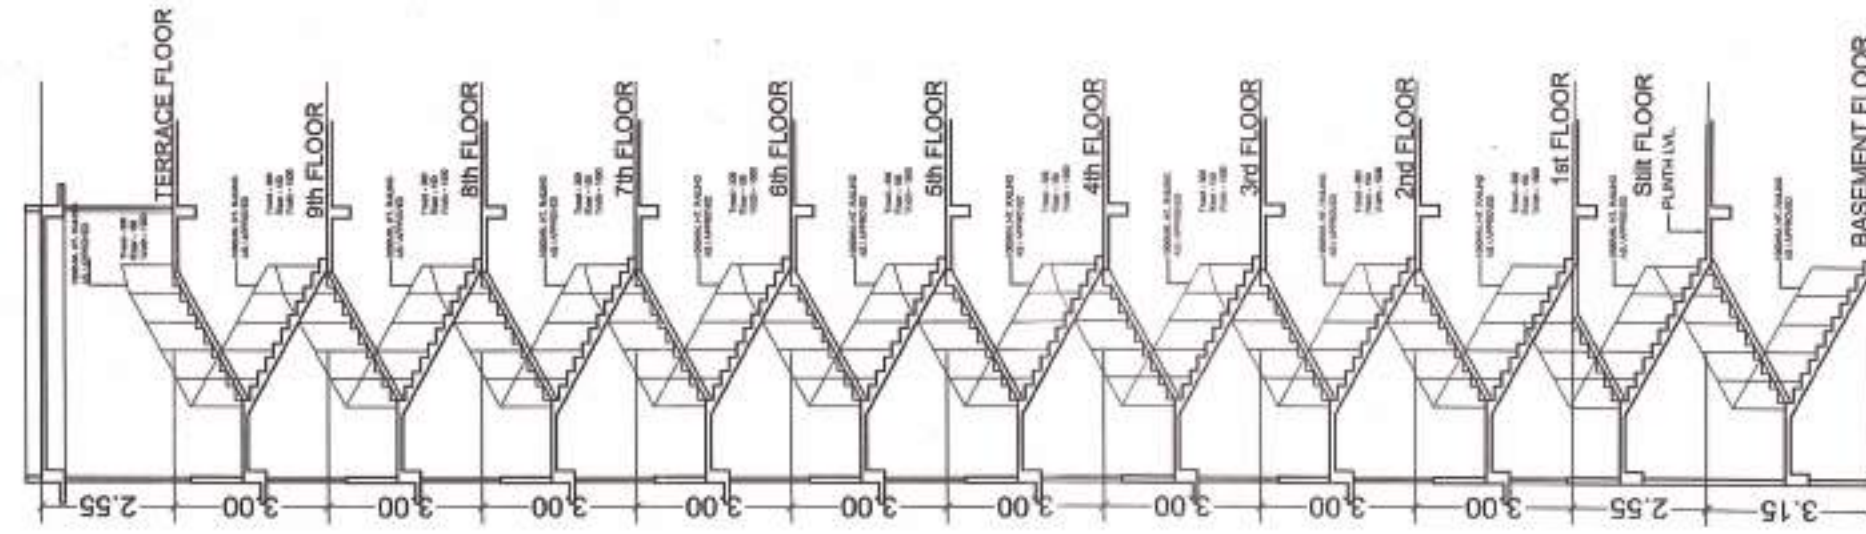
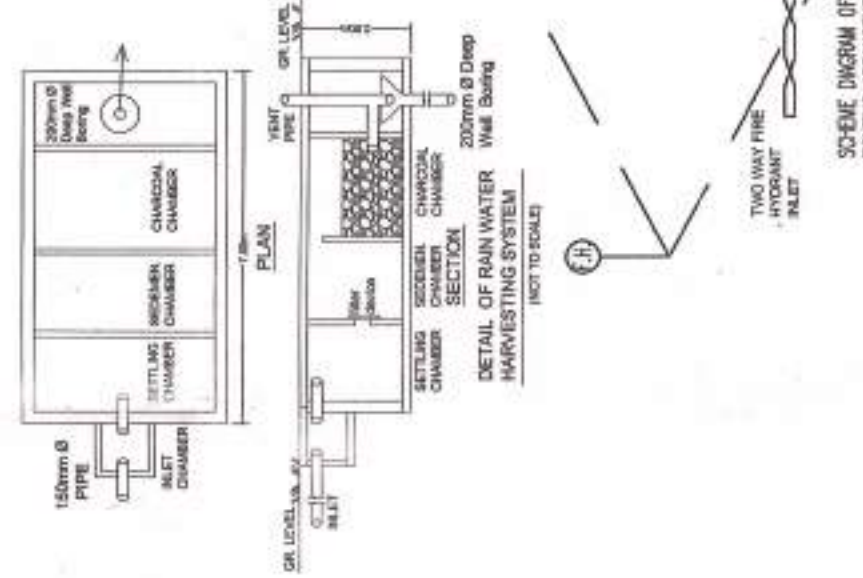
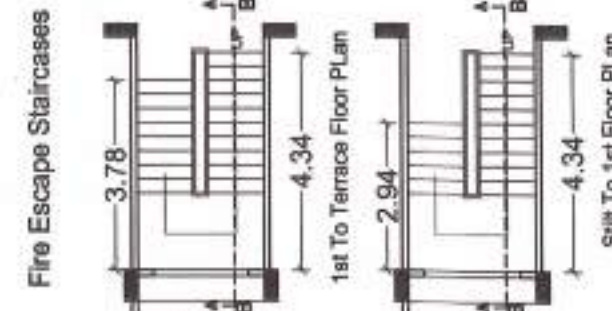
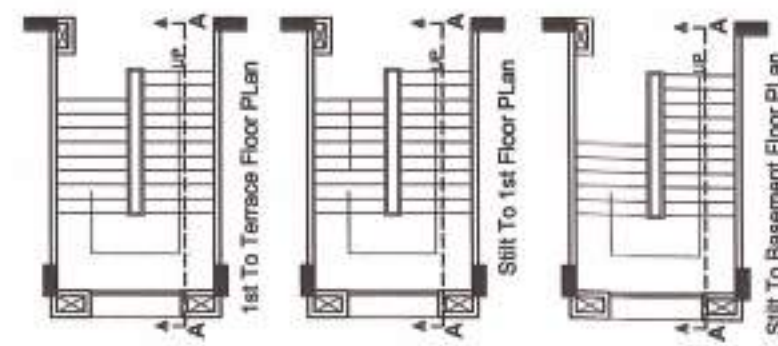
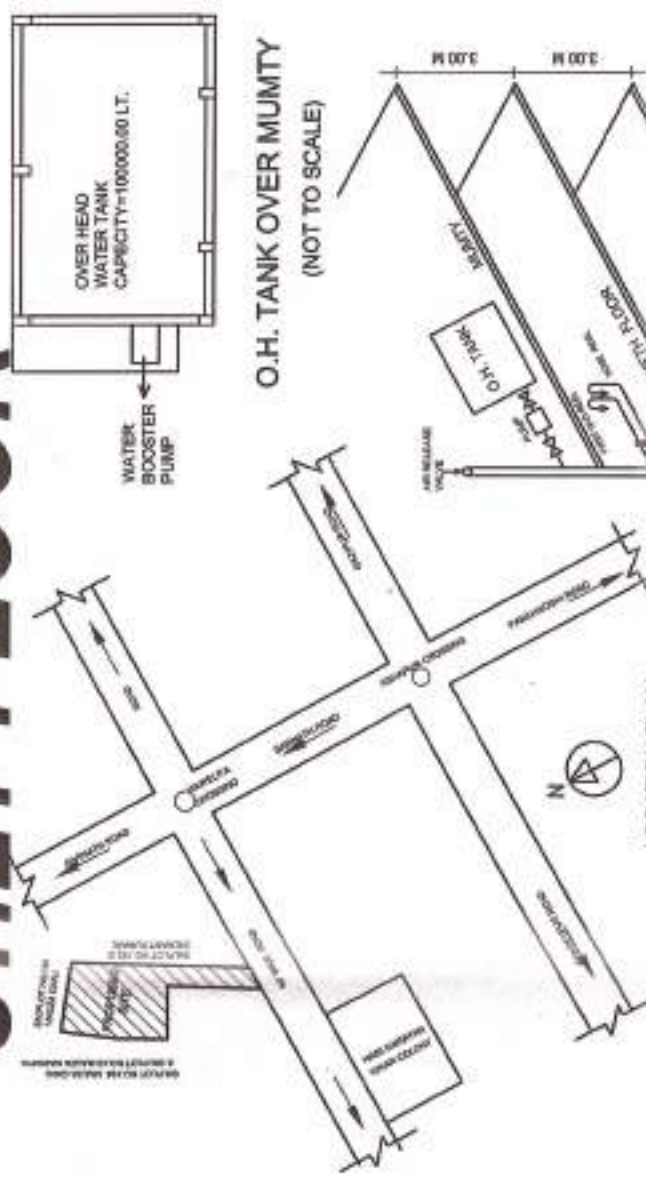
FIRE LEGEND	
NO	SYMBOL DESCRIPTION
1	 FIRE EXTINGUISHER (CO2 4.5KG)
2	 FIRE EXTINGUISHER (DCP 5.0KG)
3	 MANUAL CALL POINT
4	 HOOTER
5	 FIRE HOSE CABINET
6	 SPRINKLER RISER
7	 FIRE HYDRANT
8	 WET RISER

LEGEND—ELECTRICAL	
1.	CABLE TRAY
2.	CABLE PIPE
3.	WALL LIGHT WITH C.F. (1 X 8 WATT)
4.	DOWN LIGHT RECESS UTABLE FOR C.F. (1 X 28 WATT)
5.	POLE LIGHT (12 FT. LONG) WITH 1X18 W.C.F.
6.	BRACKET LIGHT SUITABLE FOR C.F. (1 X 18 WATT)
7.	FLOOR LIGHT ON WALL
8.	UNDER GROUND CABLE PVC INSULATED
9.	ARMOURD ALUMINIUM
10.	E.M.H.
11.	E.S. GEN SET AS PER SITE LOCATION

LEGEND - (SANITARY)	
SL. SYMBOL	DESCRIPTION
1.  I.L.	INLET LEVEL
2.  DOWNSLOPE	DOWN SLOPE
3.  SEWER MANHOLE	SEWER MANHOLE
4.  SEWER PIPE NETWORK	SEWER PIPE NETWORK
5.  RAIN WATER HARVESTING TANK	RAIN WATER HARVESTING TANK
6.  RAIN WATER HARVESTING PIT	RAIN WATER HARVESTING PIT
7.  GATE VALVE	GATE VALVE
8.  CHECK VALVE	CHECK VALVE
9.  FIRE HYDRANT	FIRE HYDRANT
10.  M.S. PIPE	M.S. PIPE

EXISTING
BORING
AS/SITE

STILT FLOOR

Section - BB
Fire Stair Cases

Section - AA

PROJECT:

COMPOUNDING & COMPLETION FOR
EXISTING RESIDENTIAL GROUP HOUSING
ON SM PLOT NO.198 & 199/2 MAUZA-GANU,
AND SM PLOT NO 43 MAUZA- MAWAIYA,
H.NO. 58A, TOLU52 MAUZA-MAWAIYA,
WARD- SARNATH, PAGANA-SHIVPUR,
DISTT- VARANASI.

OWNED BY:

MR.-AJAY KUMAR KHETAN
S/O.-LATE JEEVAN LAN KHETAN &
SMT.- RATAN DEVI
W/O.-LATE JEEVAN LAN KHETAN
R/O.-H.NO.SA.10/92,MAUZA MAUWAIYA,
WARD.-SARNATH,VARANASI.

DEVELOPERS
M/S. RUDRA REAL ESTATE LTD.
60, JAI NARAYAN SANTRALEN, GROUND 03, HAWDA
711101 WEST BANGAL.

through his authorized singtary--
MR. ANAND KUMAR AGARWAL
S/O. LATE ASHOK KUMAR AGARWAL
C.K. 65/159A, PIYARI KALA, CHOWK,
VARANASI

DRG. TITLE
SERVICE PLAN, STAIRCASE SECTION,
GATE DETAIL , FOUNDATION DETAIL &
LOCATION PLAN

1-100	<u>NORTH</u>
-------	--------------

5011

DRN.BY: ANKIT

ARCHITECT: ASEEM SANRACHANA
5 UGF, Himalaya House,
23 Kasturba Gandhi Marg,
Connaught Place
New Delhi - 110001

OWNER'S SIGNATURE/INITIALS	ARCHITECT'S SIGNATURE
----------------------------	-----------------------

 ∞ Section - BB
Fire Stair Cases

Section - AA

SHEET NO.