




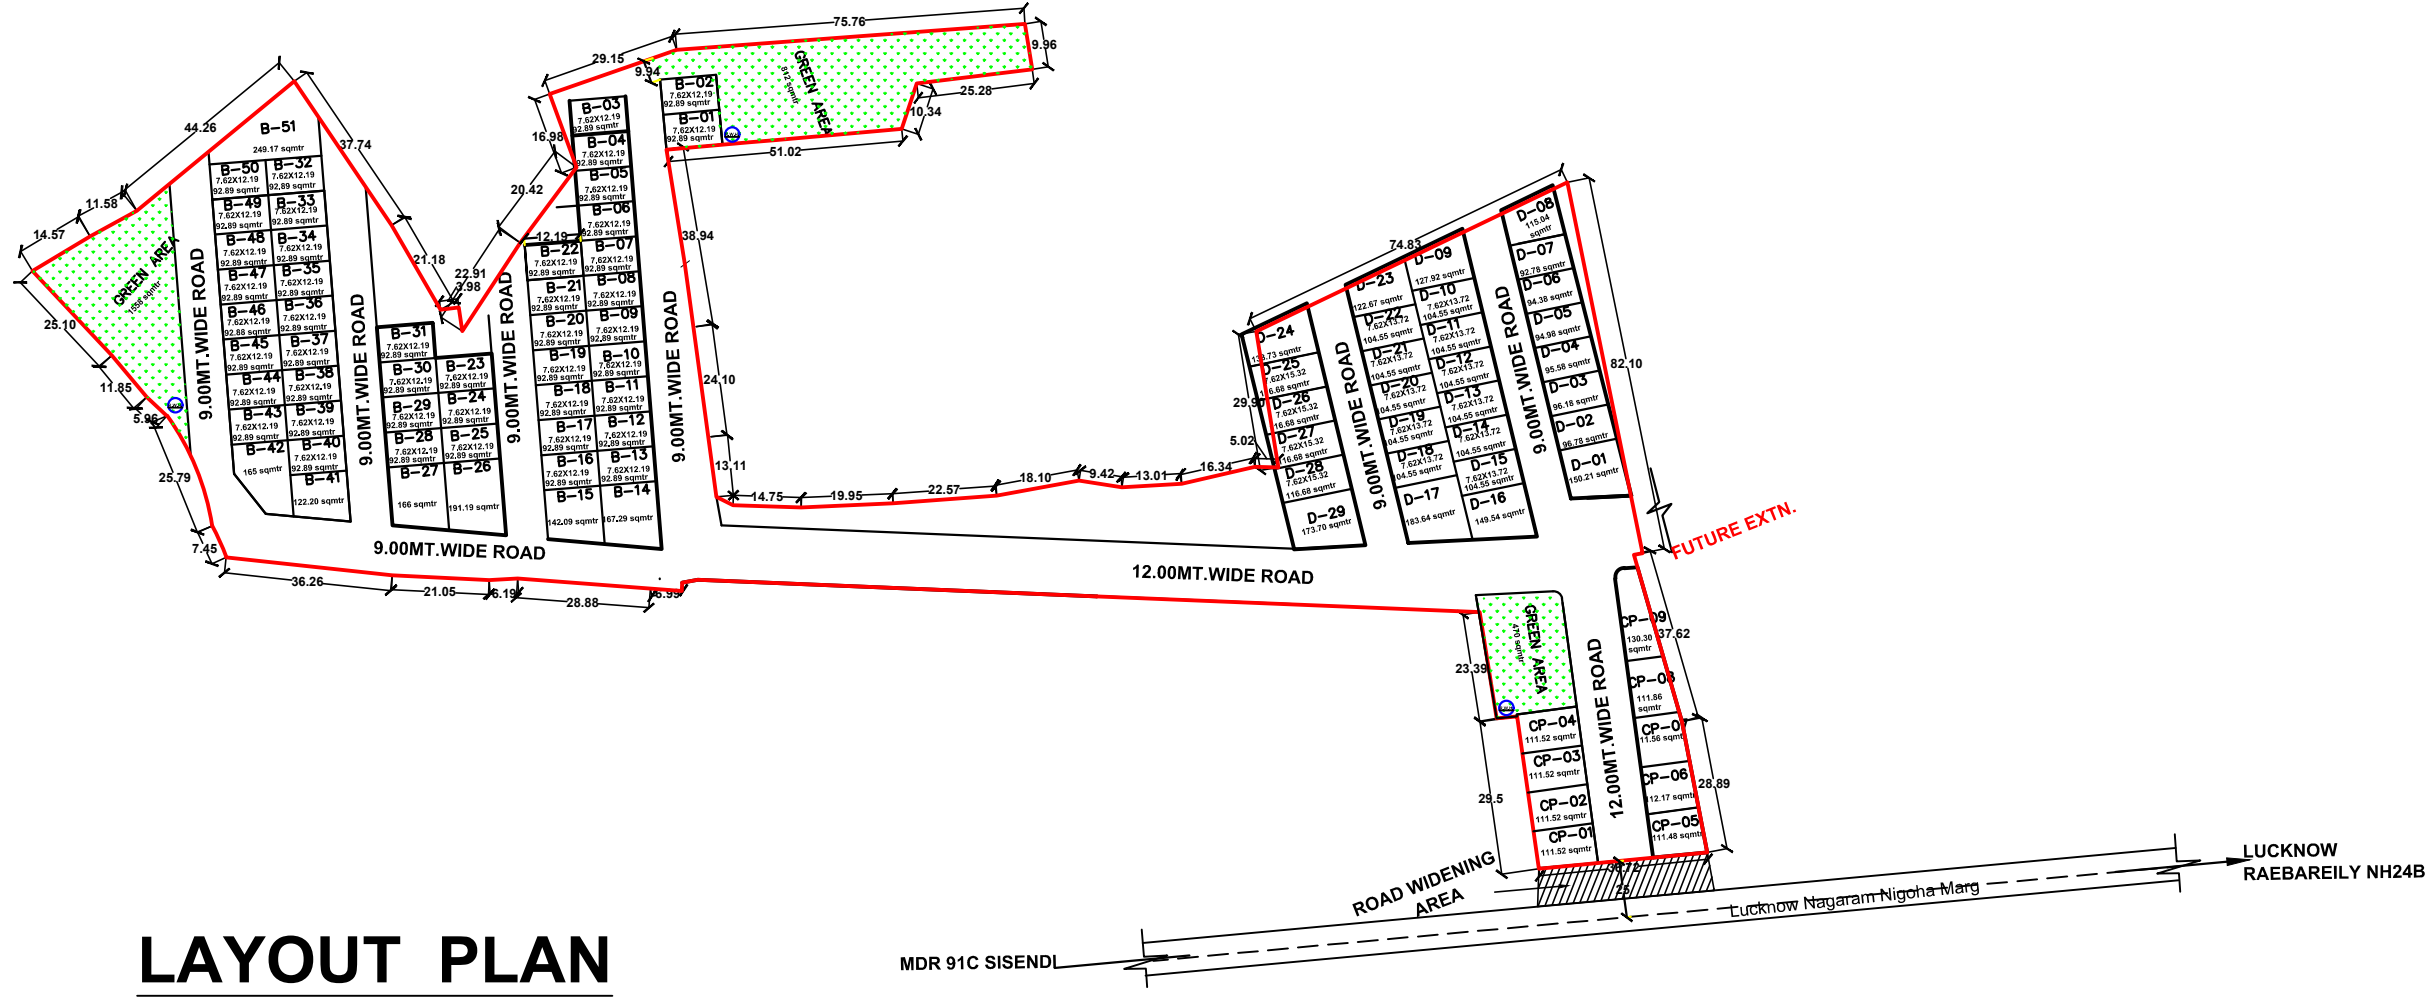


LAYOUT PLAN
SCALE: 1:100

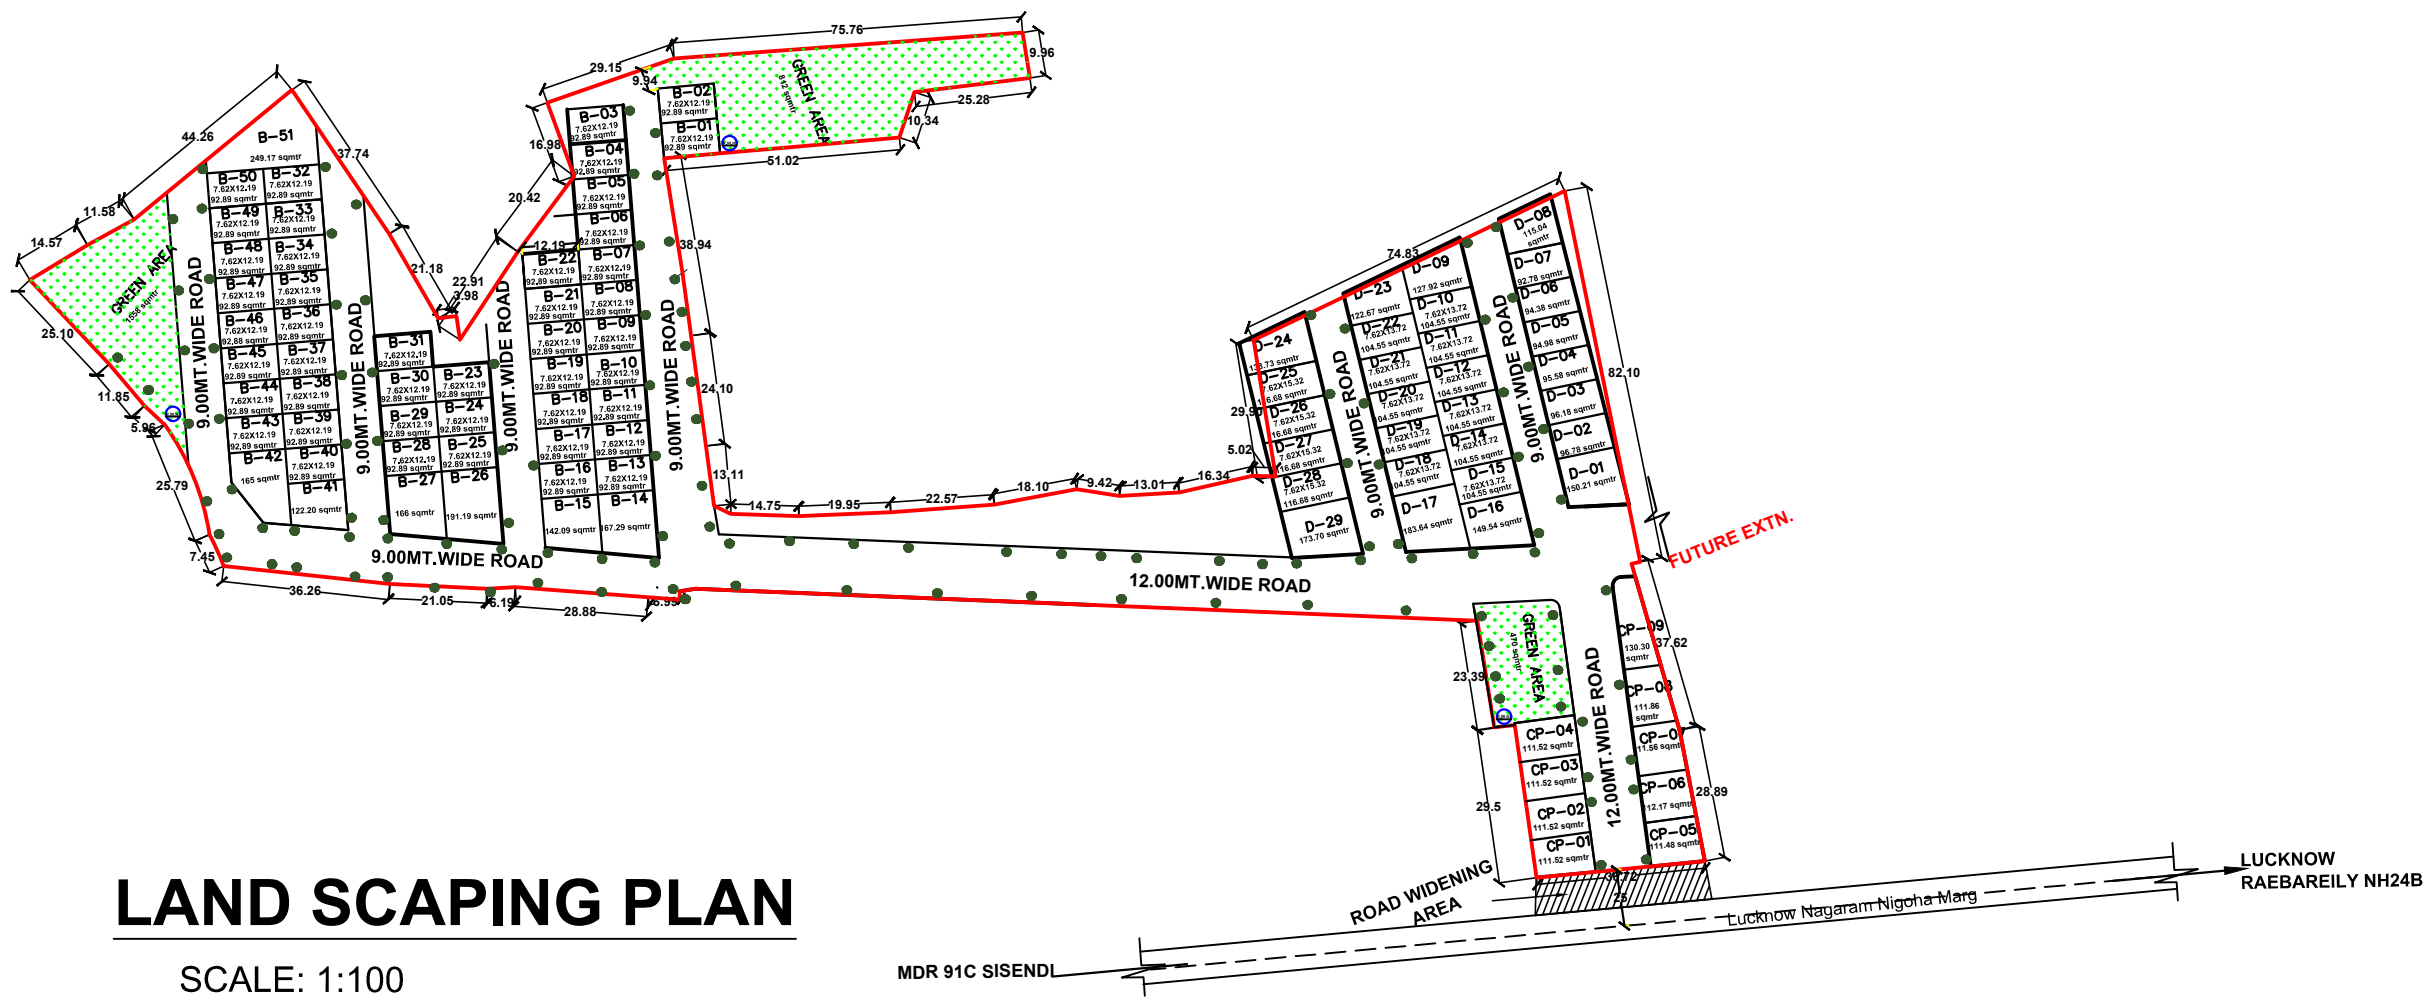


LAND SCAPING PLAN
SCALE: 1:100

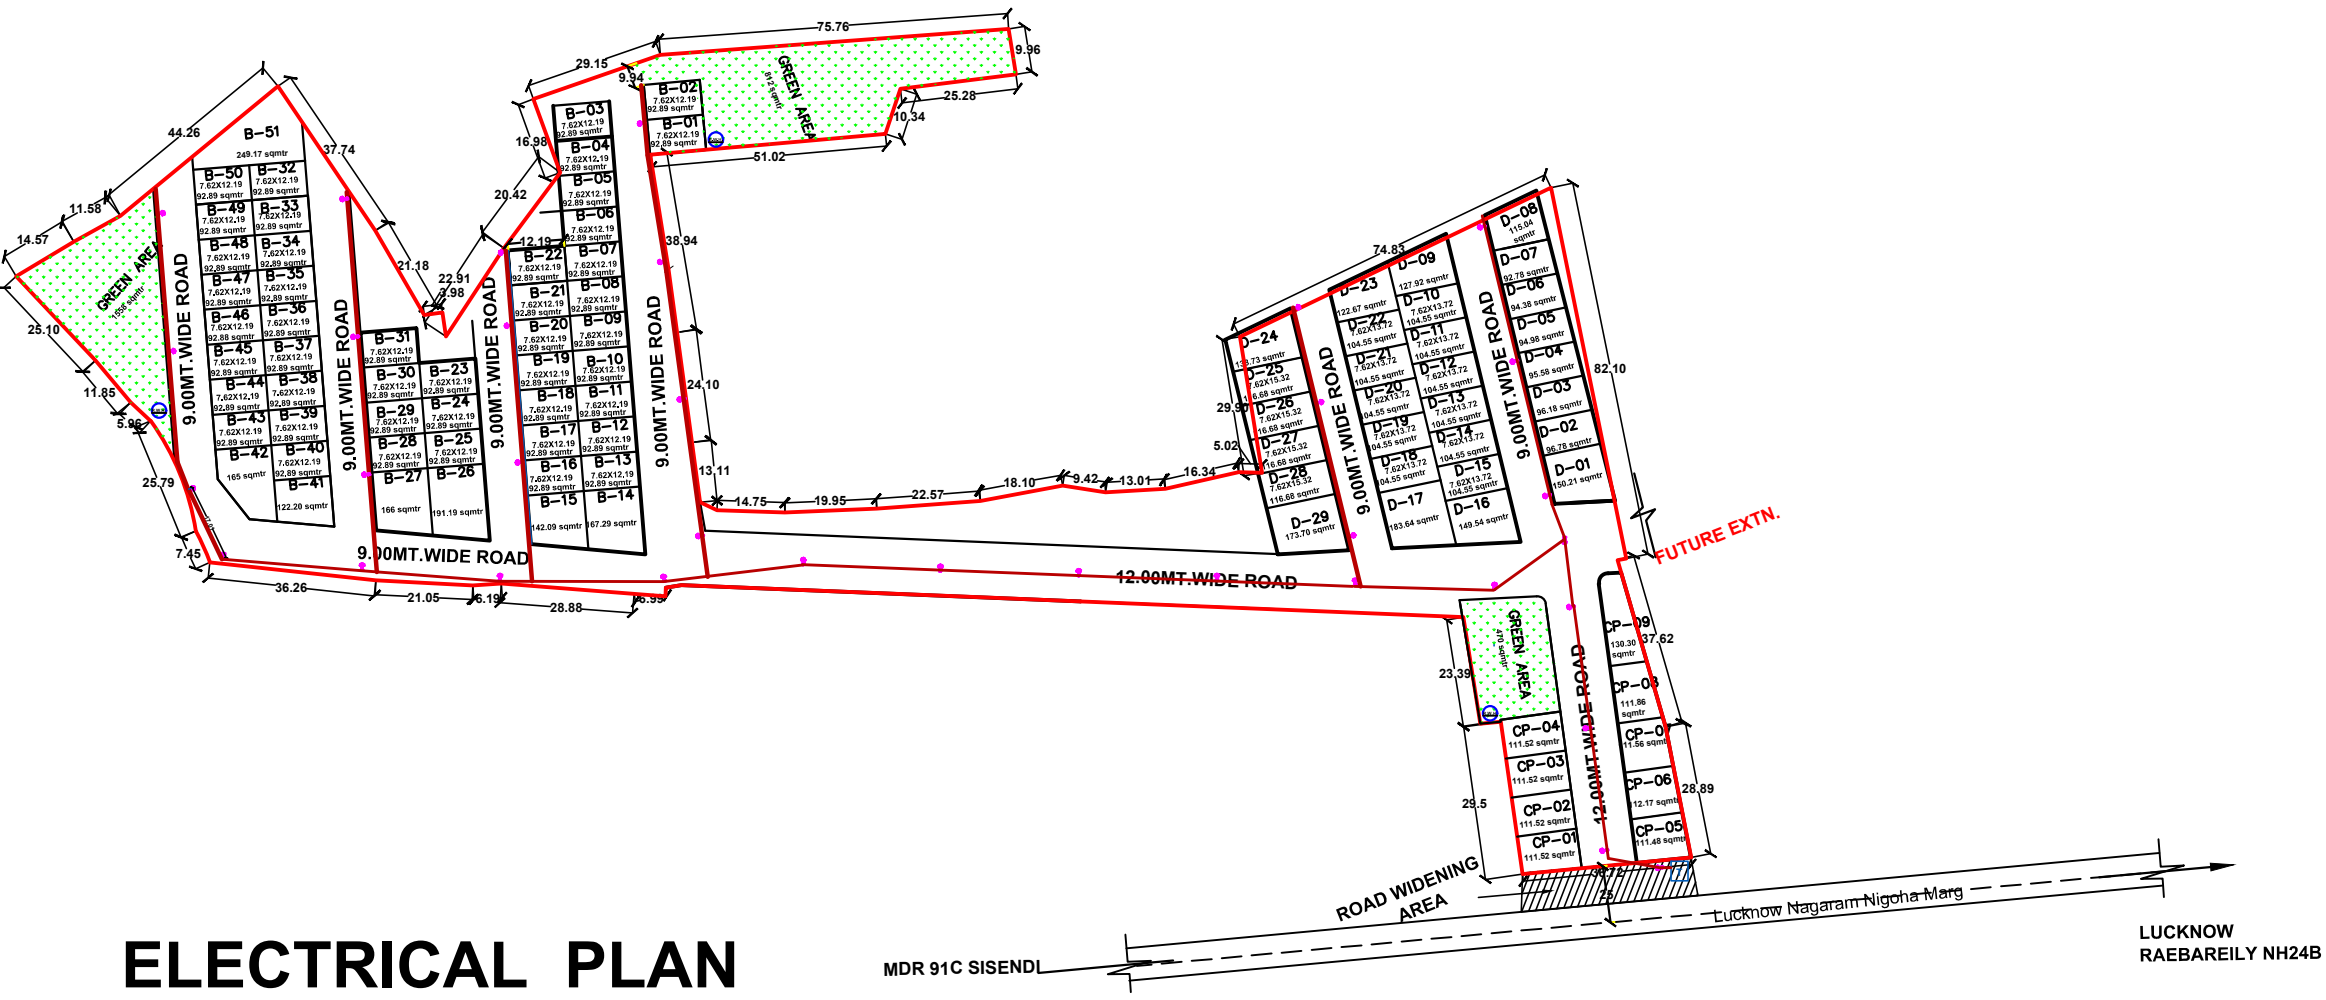

ELECTRICAL PLAN
SCALE: 1:100

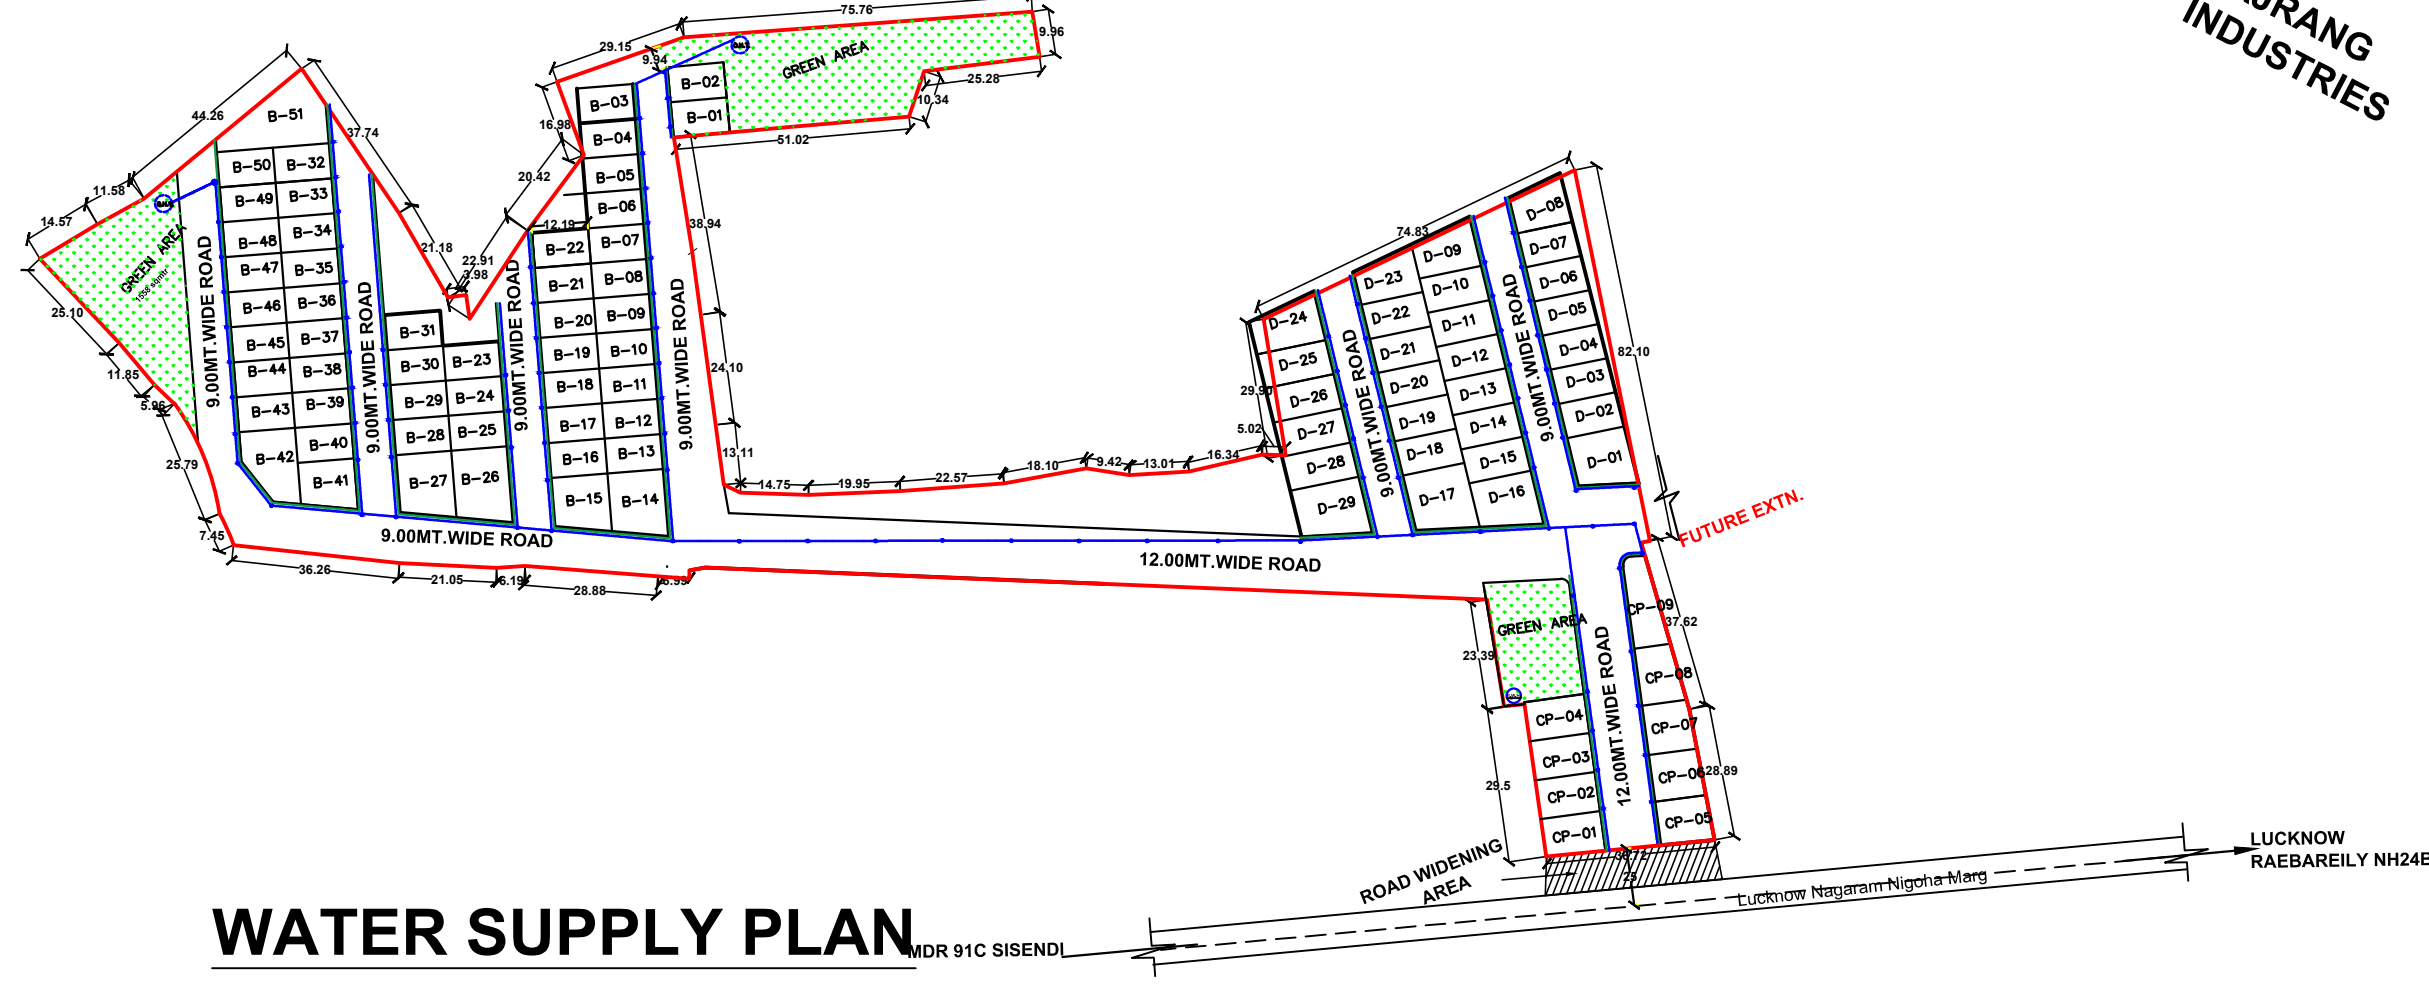

WATER SUPPLY PLAN
SCALE: 1:100


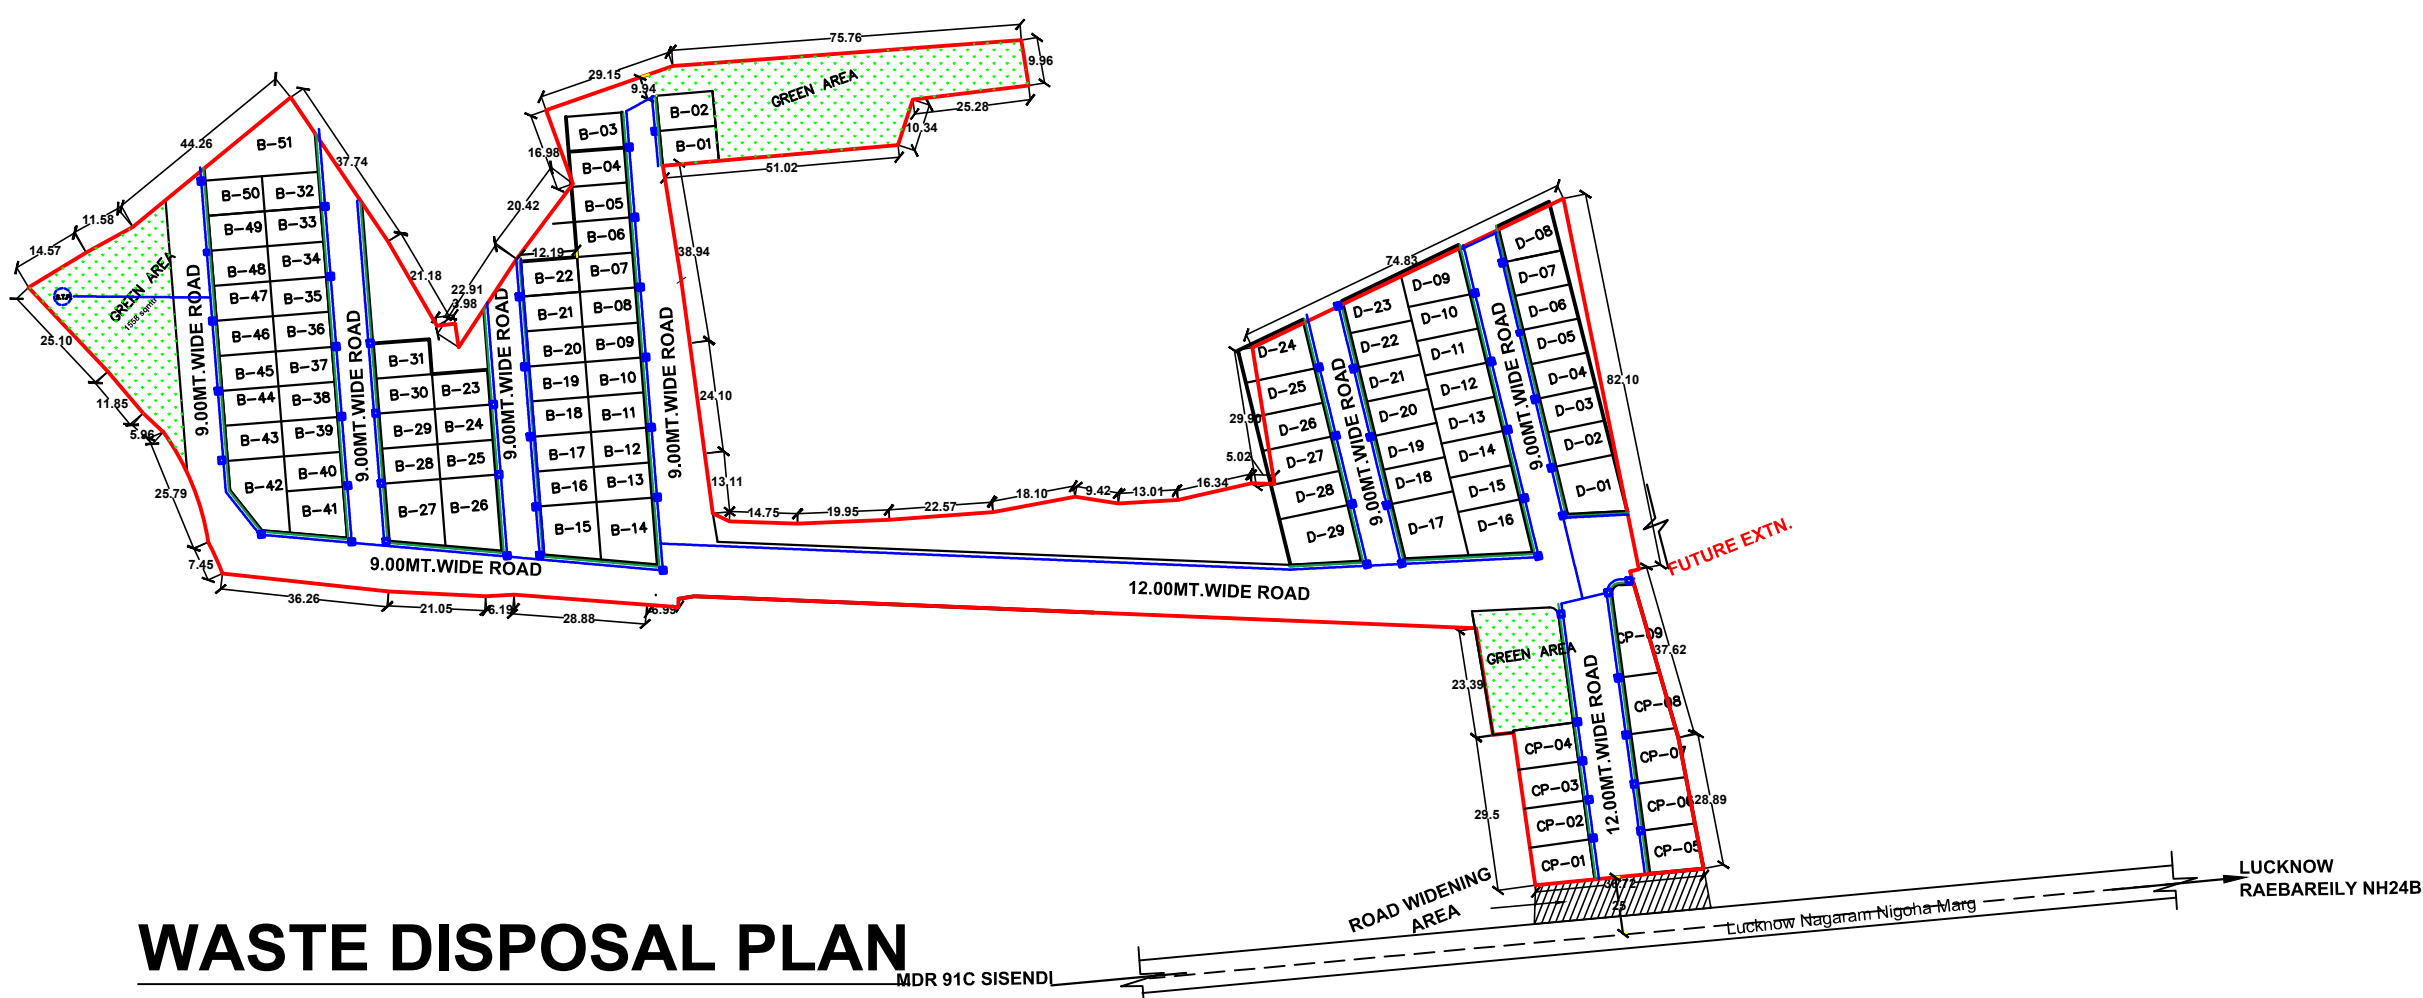


WASTE DISPOSAL PLAN
SCALE: 1:100

S.NO.	PLOT NO.	NO. OF PLOTS	DIM. OF PLOTS	SINGLE PLOT AREA	AREA OF PLOTS
1.	CP-01 TO CP-04	04	As Per Site	111.52 sqmtr	446.08 sqmtr
2.	CP-05	01	As Per Site	111.48 sqmtr	111.48 sqmtr
3.	CP-06	01	As Per Site	112.17 sqmtr	112.17 sqmtr
4.	CP-07	01	As Per Site	111.56 sqmtr	111.56 sqmtr
5.	CP-08	01	As Per Site	111.86 sqmtr	111.86 sqmtr
6.	CP-09	01	As Per Site	130.30 sqmtr	130.30 sqmtr
COMMERCIAL PLOTTED AREA					1023.45 sqmtr
7.	D-01	01	As Per Site	150.21 sqmtr	150.21 sqmtr
8.	D-02	01	As Per Site	96.78 sqmtr	96.78 sqmtr
9.	D-03	01	As Per Site	96.18 sqmtr	96.18 sqmtr
10.	D-04	01	As Per Site	95.58 sqmtr	95.58 sqmtr
11.	D-05	01	As Per Site	94.98 sqmtr	94.98 sqmtr
12.	D-06	01	As Per Site	94.38 sqmtr	94.38 sqmtr
13.	D-07	01	As Per Site	92.66 sqmtr	92.66 sqmtr
14.	D-08	01	As Per Site	115.04 sqmtr	115.04 sqmtr
15.	D-09	01	As Per Site	127.92 sqmtr	127.92 sqmtr
16.	D-10 TO D-15	06	7.62X13.72	104.55 sqmtr	627.30 sqmtr
17.	D-16	01	As Per Site	149.54 sqmtr	149.54 sqmtr
18.	D-17	01	As Per Site	183.64 sqmtr	183.64 sqmtr
19.	D-18 TO D-22	05	7.62X13.72	104.55 sqmtr	522.75 sqmtr
20.	D-23	01	As Per Site	122.67 sqmtr	122.67 sqmtr
21.	D-24	01	As Per Site	138.73 sqmtr	138.73 sqmtr
22.	D-25 TO D-28	04	7.62X15.32	116.74 sqmtr	466.96 sqmtr
23.	D-29	01	As Per Site	173.70 sqmtr	173.70 sqmtr
24.	B-01 TO B-13	13	7.62X12.19	92.89 sqmtr	1207.57 sqmtr
25.	B-14	01	As Per Site	167.29 sqmtr	167.29 sqmtr
26.	B-15	01	As Per Site	142.09 sqmtr	142.09 sqmtr
27.	B-16 TO B-25	10	7.62X12.19	92.89 sqmtr	928.9 sqmtr
28.	B-26	01	As Per Site	191.19 sqmtr	191.19 sqmtr
29.	B-27	01	As Per Site	166 sqmtr	166 sqmtr
30.	B-28 TO B-40	13	7.62X12.19	92.89 sqmtr	1207.57 sqmtr
31.	B-41	01	As Per Site	122.20 sqmtr	122.20 sqmtr
32.	B-42	01	As Per Site	165 sqmtr	165 sqmtr
33.	B-43 TO B-50	08	7.62X12.19	92.89 sqmtr	743.12 sqmtr
34.	B-51	01	As Per Site	249.17 sqmtr	249.17 sqmtr
RESIDENTIAL PLOTTED AREA					8639.12 SQMTR.



PROPOSED SITE
LAT.-26.610225,
LONG.-80.985481

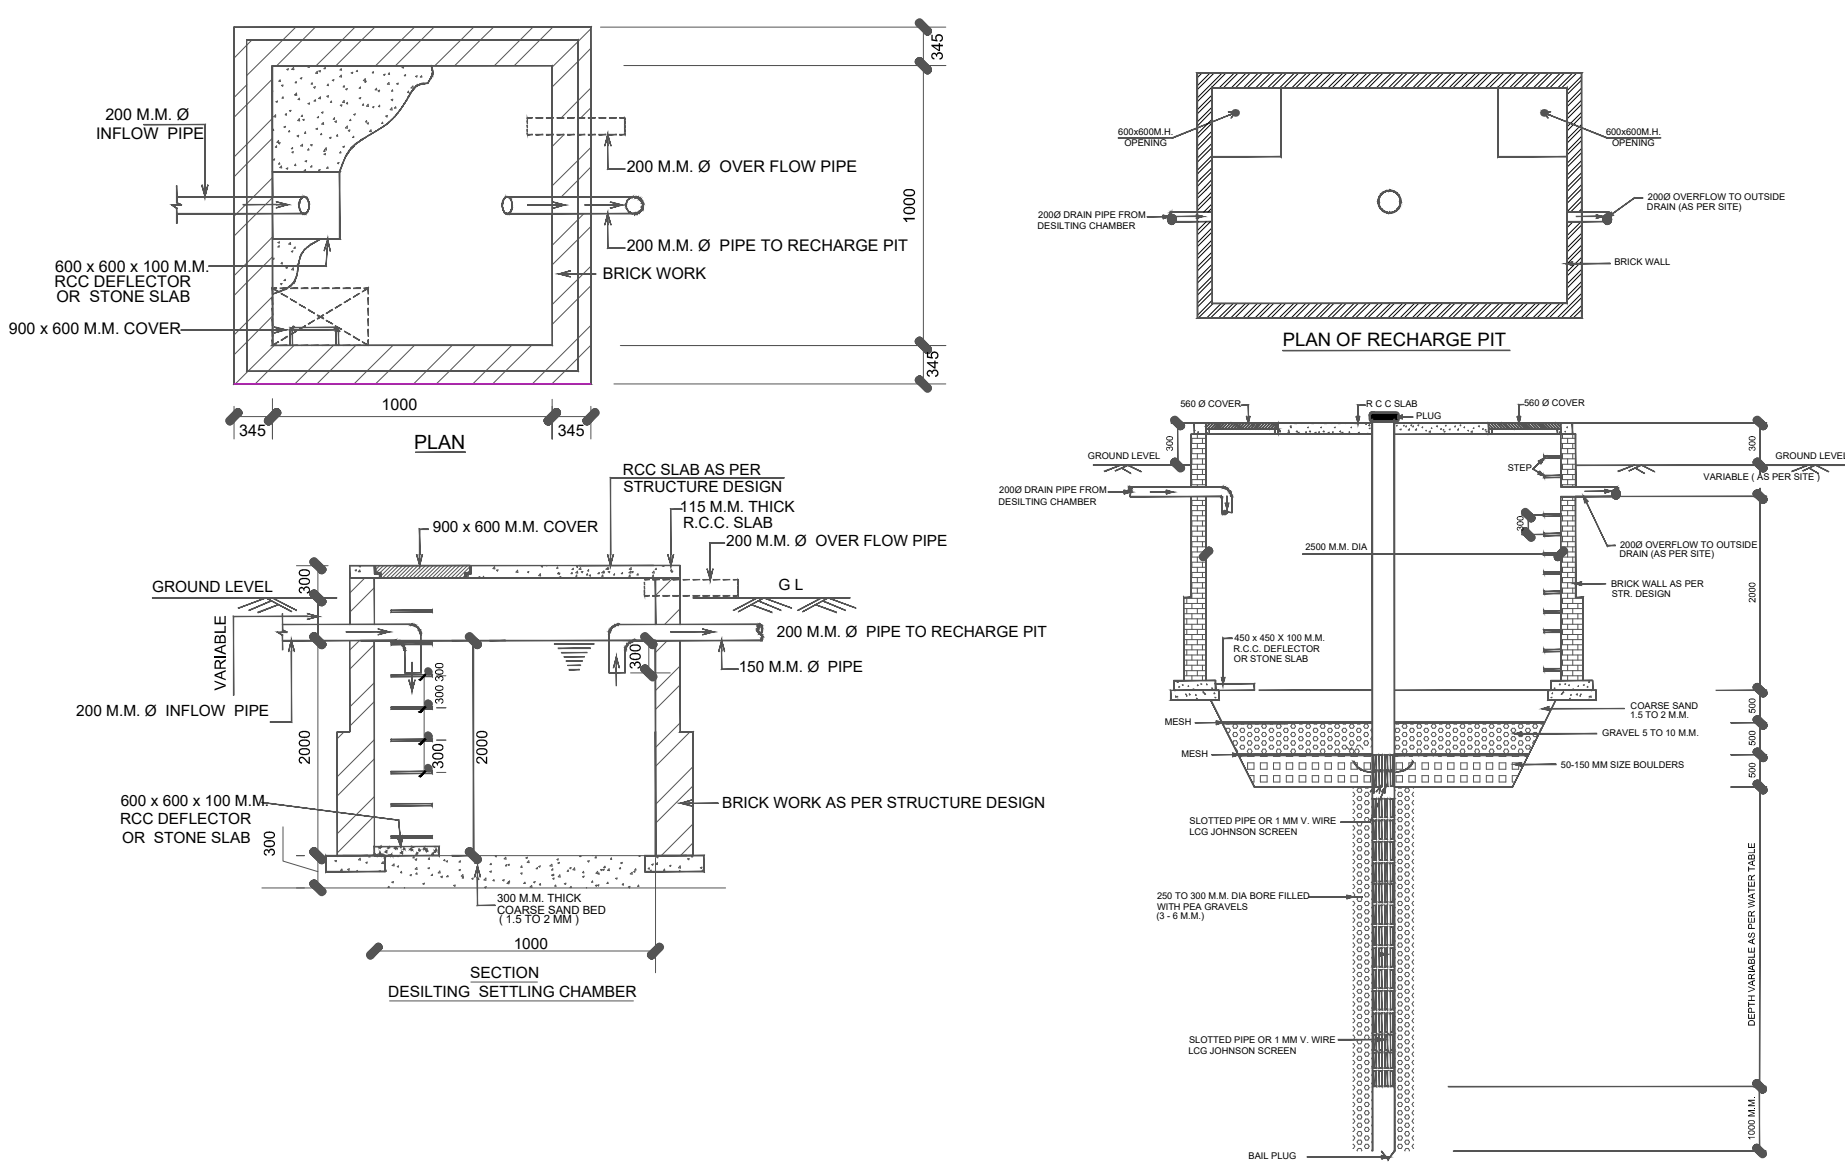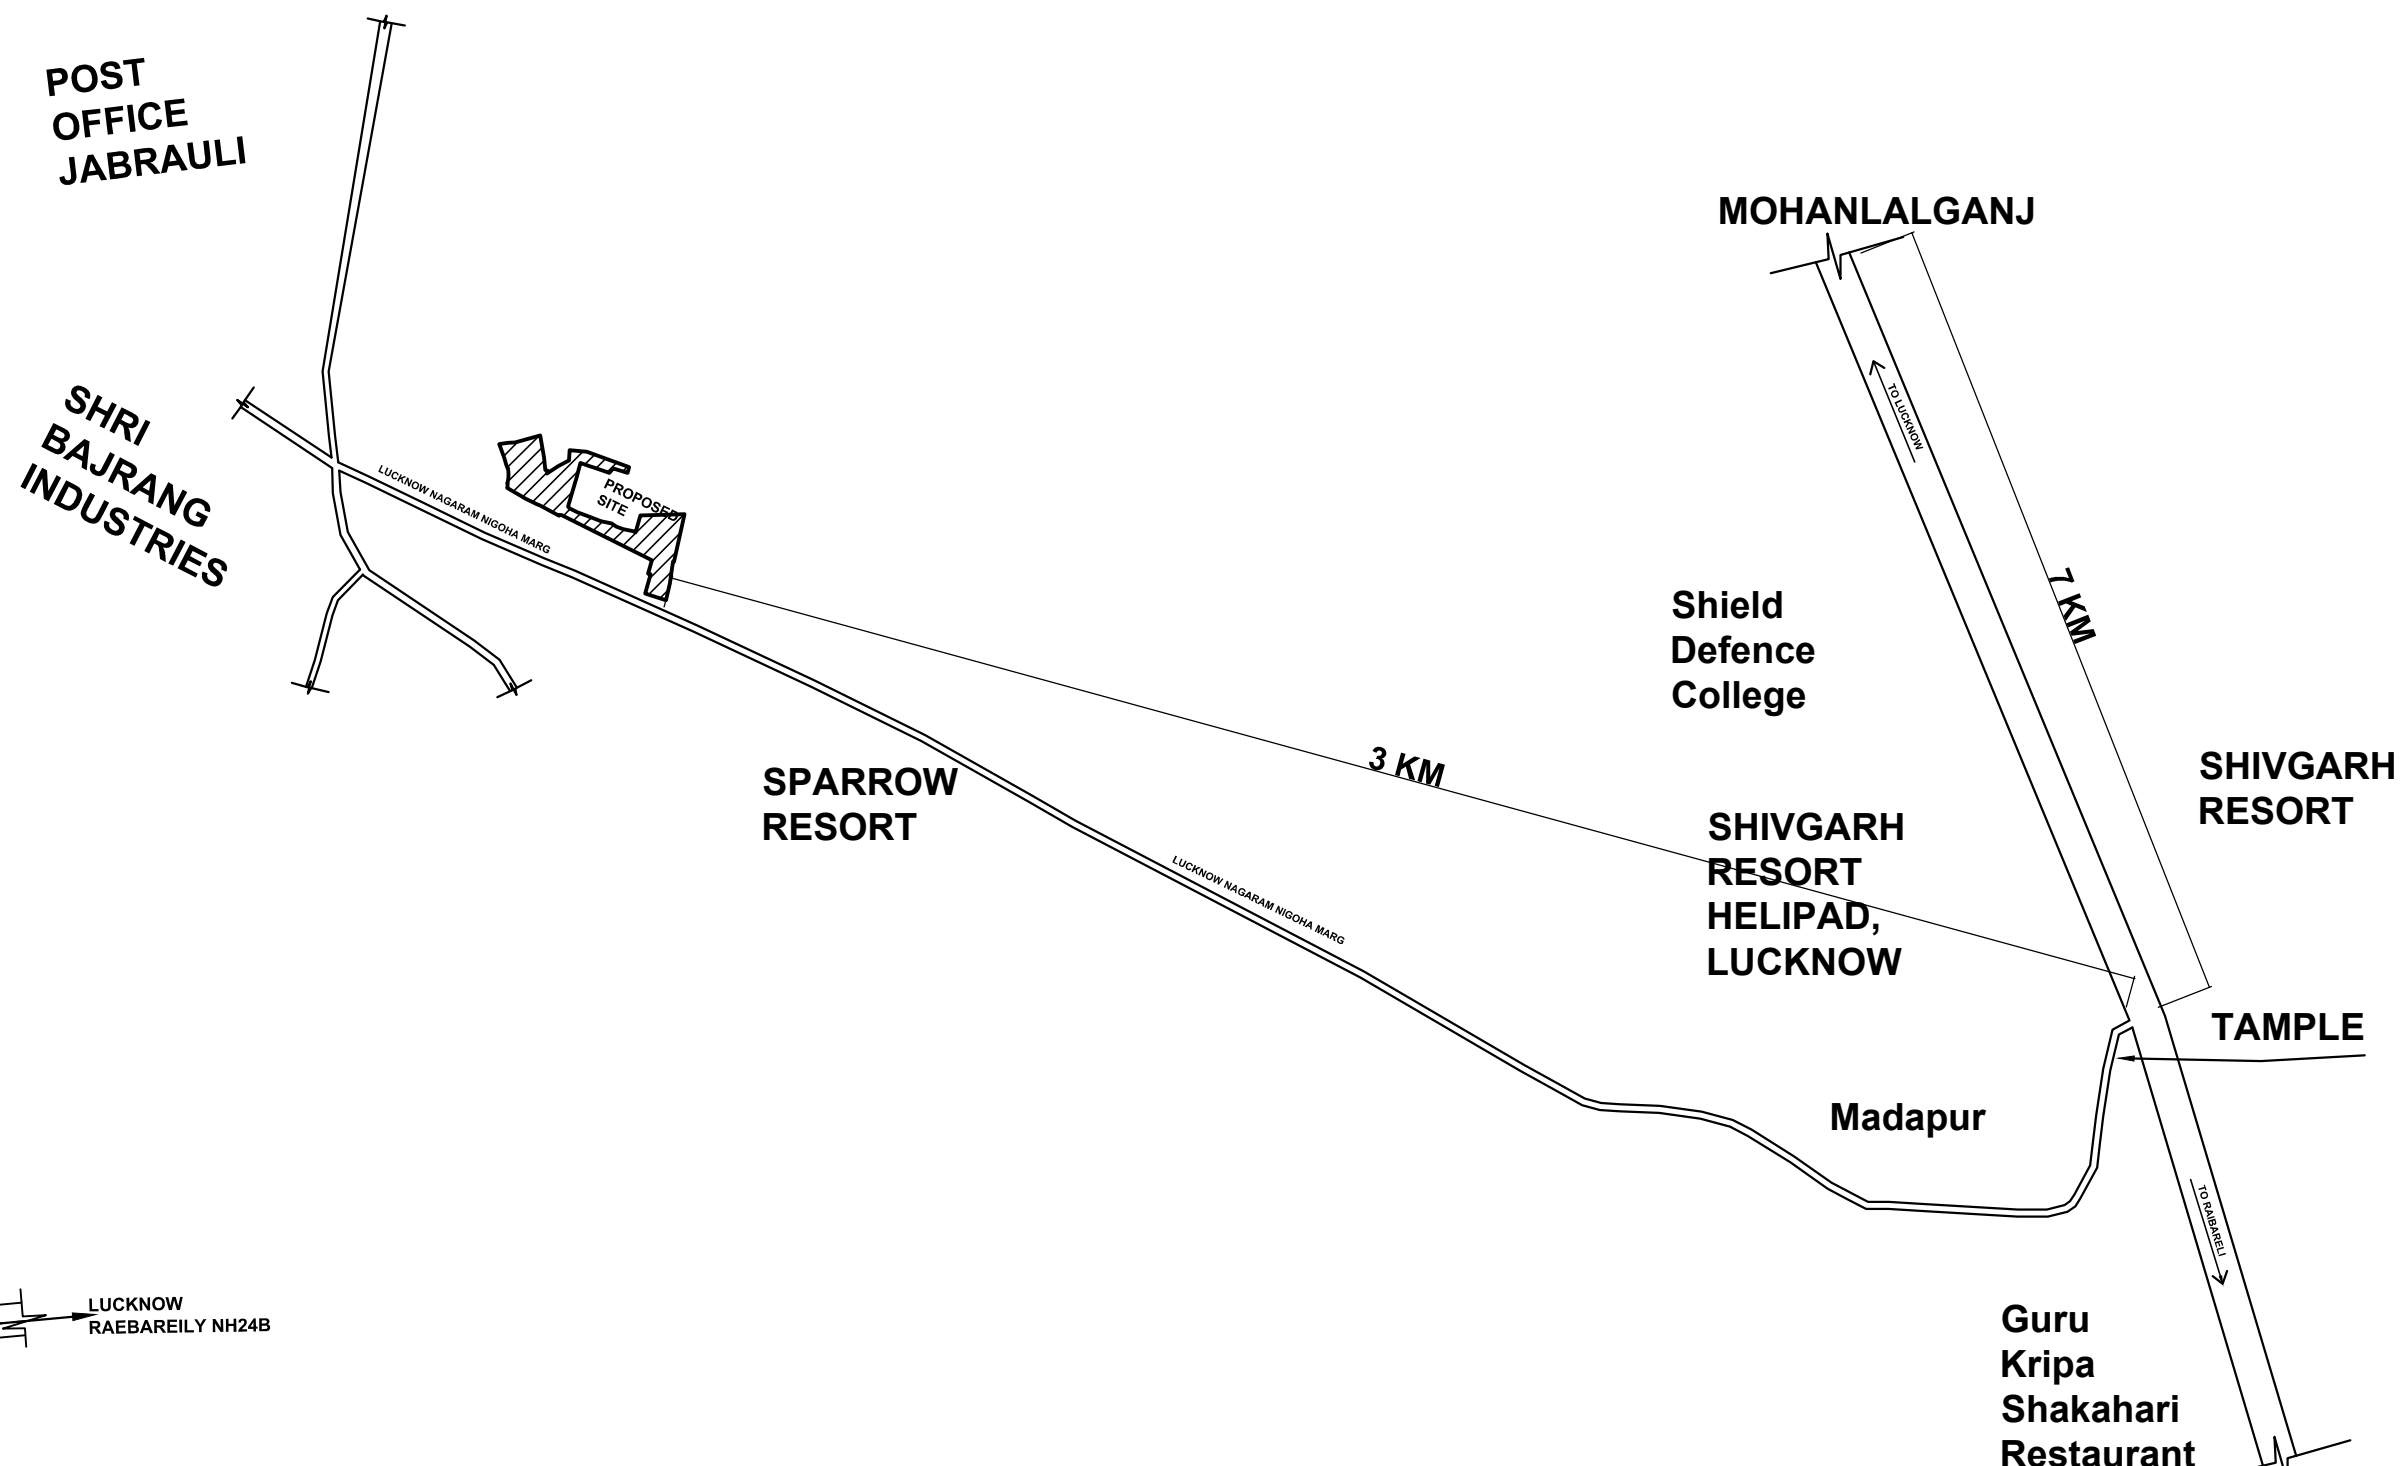

WATER RECHARGING PIT
SCALE: (N.T.S.)

PROJECT :-

PROPOSED LAYOUT FOR
"ARSH ENCLAVE"
A PROJECT BY "AARYA GROUP"
Director: Mr. Arun Pandey, Located at:
JABARAULI Post-MOHANLAL GANJ
District - LUCKNOW 226301 (U. P.)
ON KHASRA
NO./2522, 2518 KA, 2517, 2519, 2502,
2505, 2508, 2499, 2500, 2501, 2504, 2509

KHASRA NO.	NAME	AREA(IN SQMTR)
2522	AARYAVISION VENTURES PVT LTD	1289
2518 KA	AARYAVISION VENTURES PVT LTD	890
2517	AARYAVISION VENTURES PVT LTD	5370
2519	ARUN PANDEY	1410
2502	AARYAVISION VENTURES PVT LTD	630
2505	AARYAVISION VENTURES PVT LTD	510
2508	AARYAVISION VENTURES PVT LTD	380
2499	AARYAVISION VENTURES PVT LTD	5060
2500	AARYAVISION VENTURES PVT LTD & ARUN(1/2) in favour of both	820
2501	AARYAVISION VENTURES PVT LTD & ARUN(1/2) in favour of both	890
2504	AARYAVISION VENTURES PVT LTD	950
2509	AARYAVISION VENTURES PVT LTD	760
TOTAL LAND		18959

:-AREA STATEMENT :-

TOTAL AREA= 18959 SQMTR.
ROAD WIDENING AREA = 208 SQMTR
NET LAND AREA = 18751 SQMTR.
RESIDENTIAL PLOTTED AREA= 8639.12 SQMTR.(46.07%)
COMMERCIAL PLOTTED AREA= 1023.45 SQMTR.(5.46%)
GREEN AREA= 2840 SQMTR.(15.14%)
ROAD AREA= 6248.43 SQMTR.(33.33%)

BOUNDARY WALL LENGTH= 1303.75 MTR
BOUNDARY WALL HEIGHT= 2.1 MTR
WALL AREA= 2737.9 SQMTR

LEGENDS

	SEWERAGE TREATMENT PLANT
	ELECTRICAL POLE
	SEWERAGE CHAMBER
	TRANSFORMER
	TREES
	WATER SUPPLY
	OVER HEAD TANK

*ALL DIMENSIONS ARE IN METERS

DRAWING TITLE:-

1. AREA STATEMENT
2. KEY PLAN
3. LAYOUT PLAN
4. SATELLITE LOCATION PLAN
5. SERVICES PLAN
6. WATER RECHARGING PIT

OWNER -

ARCHITECT -

SCALE :-	SHEET NO. -	NORTH -
DATED :-	01/01	

SUBMISSION DRAWING