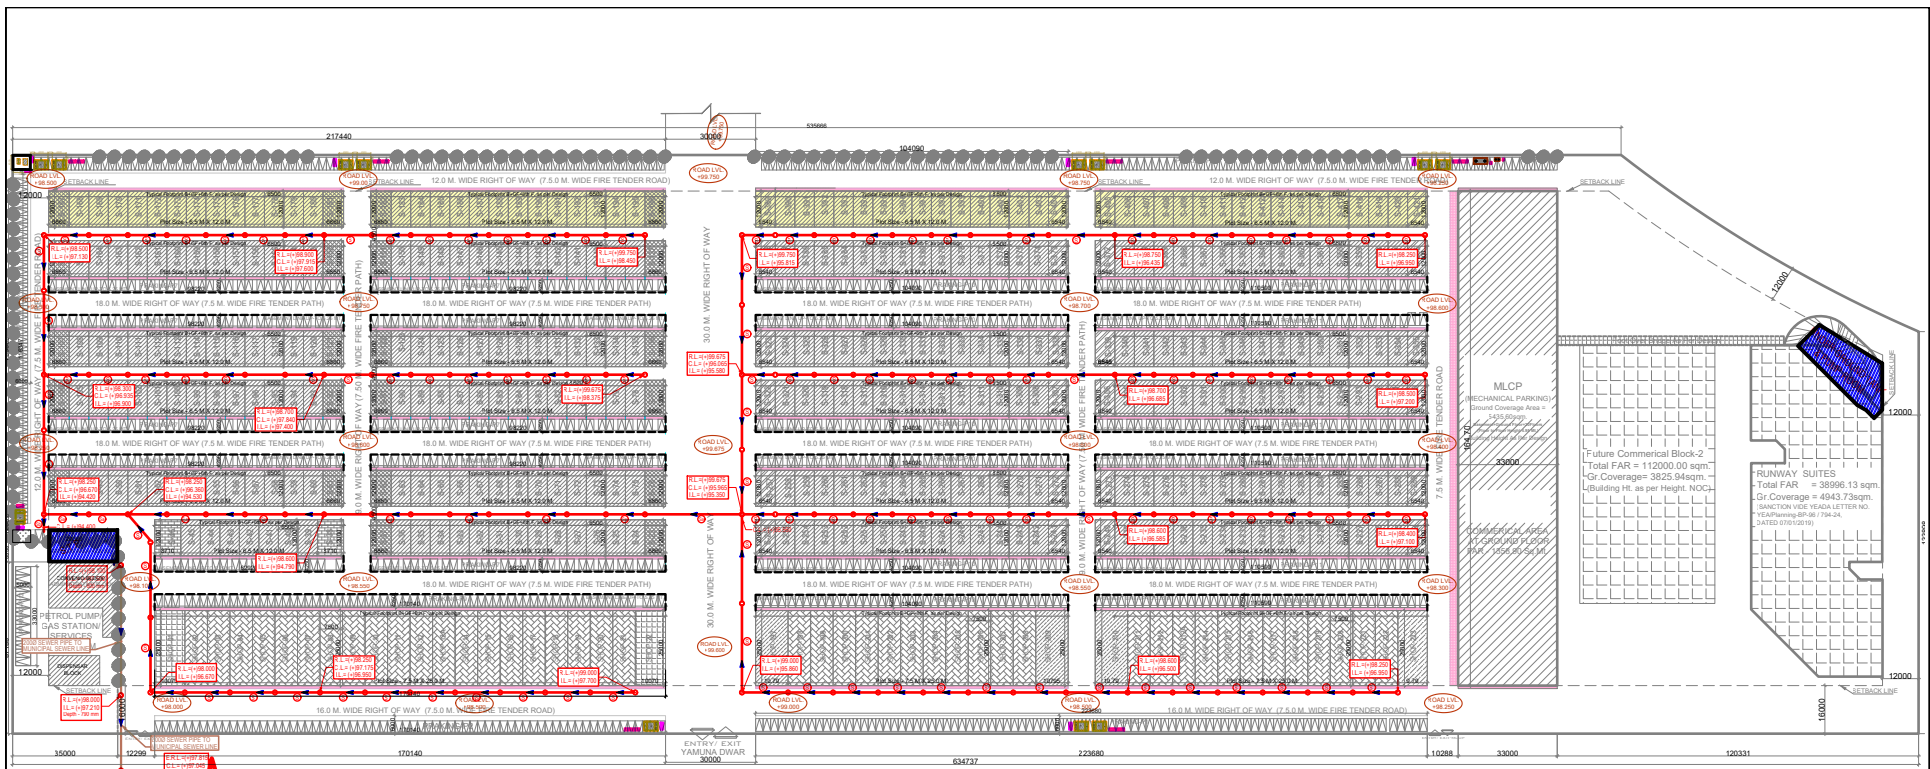


KEY PLAN, GAUR YAMUNA CITY
(Pocket-3), Mirzapur Site
(LFD-3), Sector-19, YEIDA, GREATER NOIDA, U.P.

LEGEND :		
S.No.	SYMBOL	DESCRIPTION
1.	M.H. O	MANHOLE
2.	—	SEWER LINE
3.	○	2000 SEWER PIPE (SLOPE 1:200)
4.	○	2000 SEWER PIPE (SLOPE 1:200)
5.	○	2000 SEWER PIPE (SLOPE 1:200)
6.	S.L.	ROAD LEVEL
7.	I.L.	INVERT LEVEL
8.	C.L.	CONNECTION LEVEL

Drg. No. - MPC-01

PROJECT : -
PROPOSED BUILDING FOOT PRINTS AT
MASTER PLAN COMMERCIAL GAUR YAMUNA
CITY (POCKET-3), MIRZAPUR SITE (LFD-3),
SECTOR-19, YEIDA, GREATER NOIDA, U.P.

Title :

SITE PLAN

Subtitle :

EXTERNAL SEWERAGE LAYOUT

Drawing Released For :

- ☐ APPROVAL
☐ ADVANCE COPY
☒ SUBMISSION
☐ CONSTRUCTION

Drg. No : GYC / MC / SP - 01

Date : 23.07.2020

Scale : A1@1:800

Drawn By : S.Bhandari

Design By : Shakir Shabbir

Ckd By : Anand Havella

architects

BRJ (INDIA) ARCHITECTS
F-89, GREEN PARK, NEW DELHI -16.
Ph. +91-11-26853815, 26858307, Fax : +91-11-26850788
E-mail : brjarch.atwin@gmail.com
Website : www.atwin.in

services consultant

Consummate Engineering Services (P) Ltd.

Noida Office : B - 67, Sector - 67, Noida - 201 301
Tel : (0120) 26843500 (24 Lines)
Lko. Office : R 006, Rohtas Plumeria, Gomti Nagar, Lucknow
e mail : mail@cespl.in, website : www.cespl.in