




UPPER GROUND FLOOR PLAN
(SCALE 1:200)



LOWER GROUND FLOOR PLAN
(SCALE 1:200)

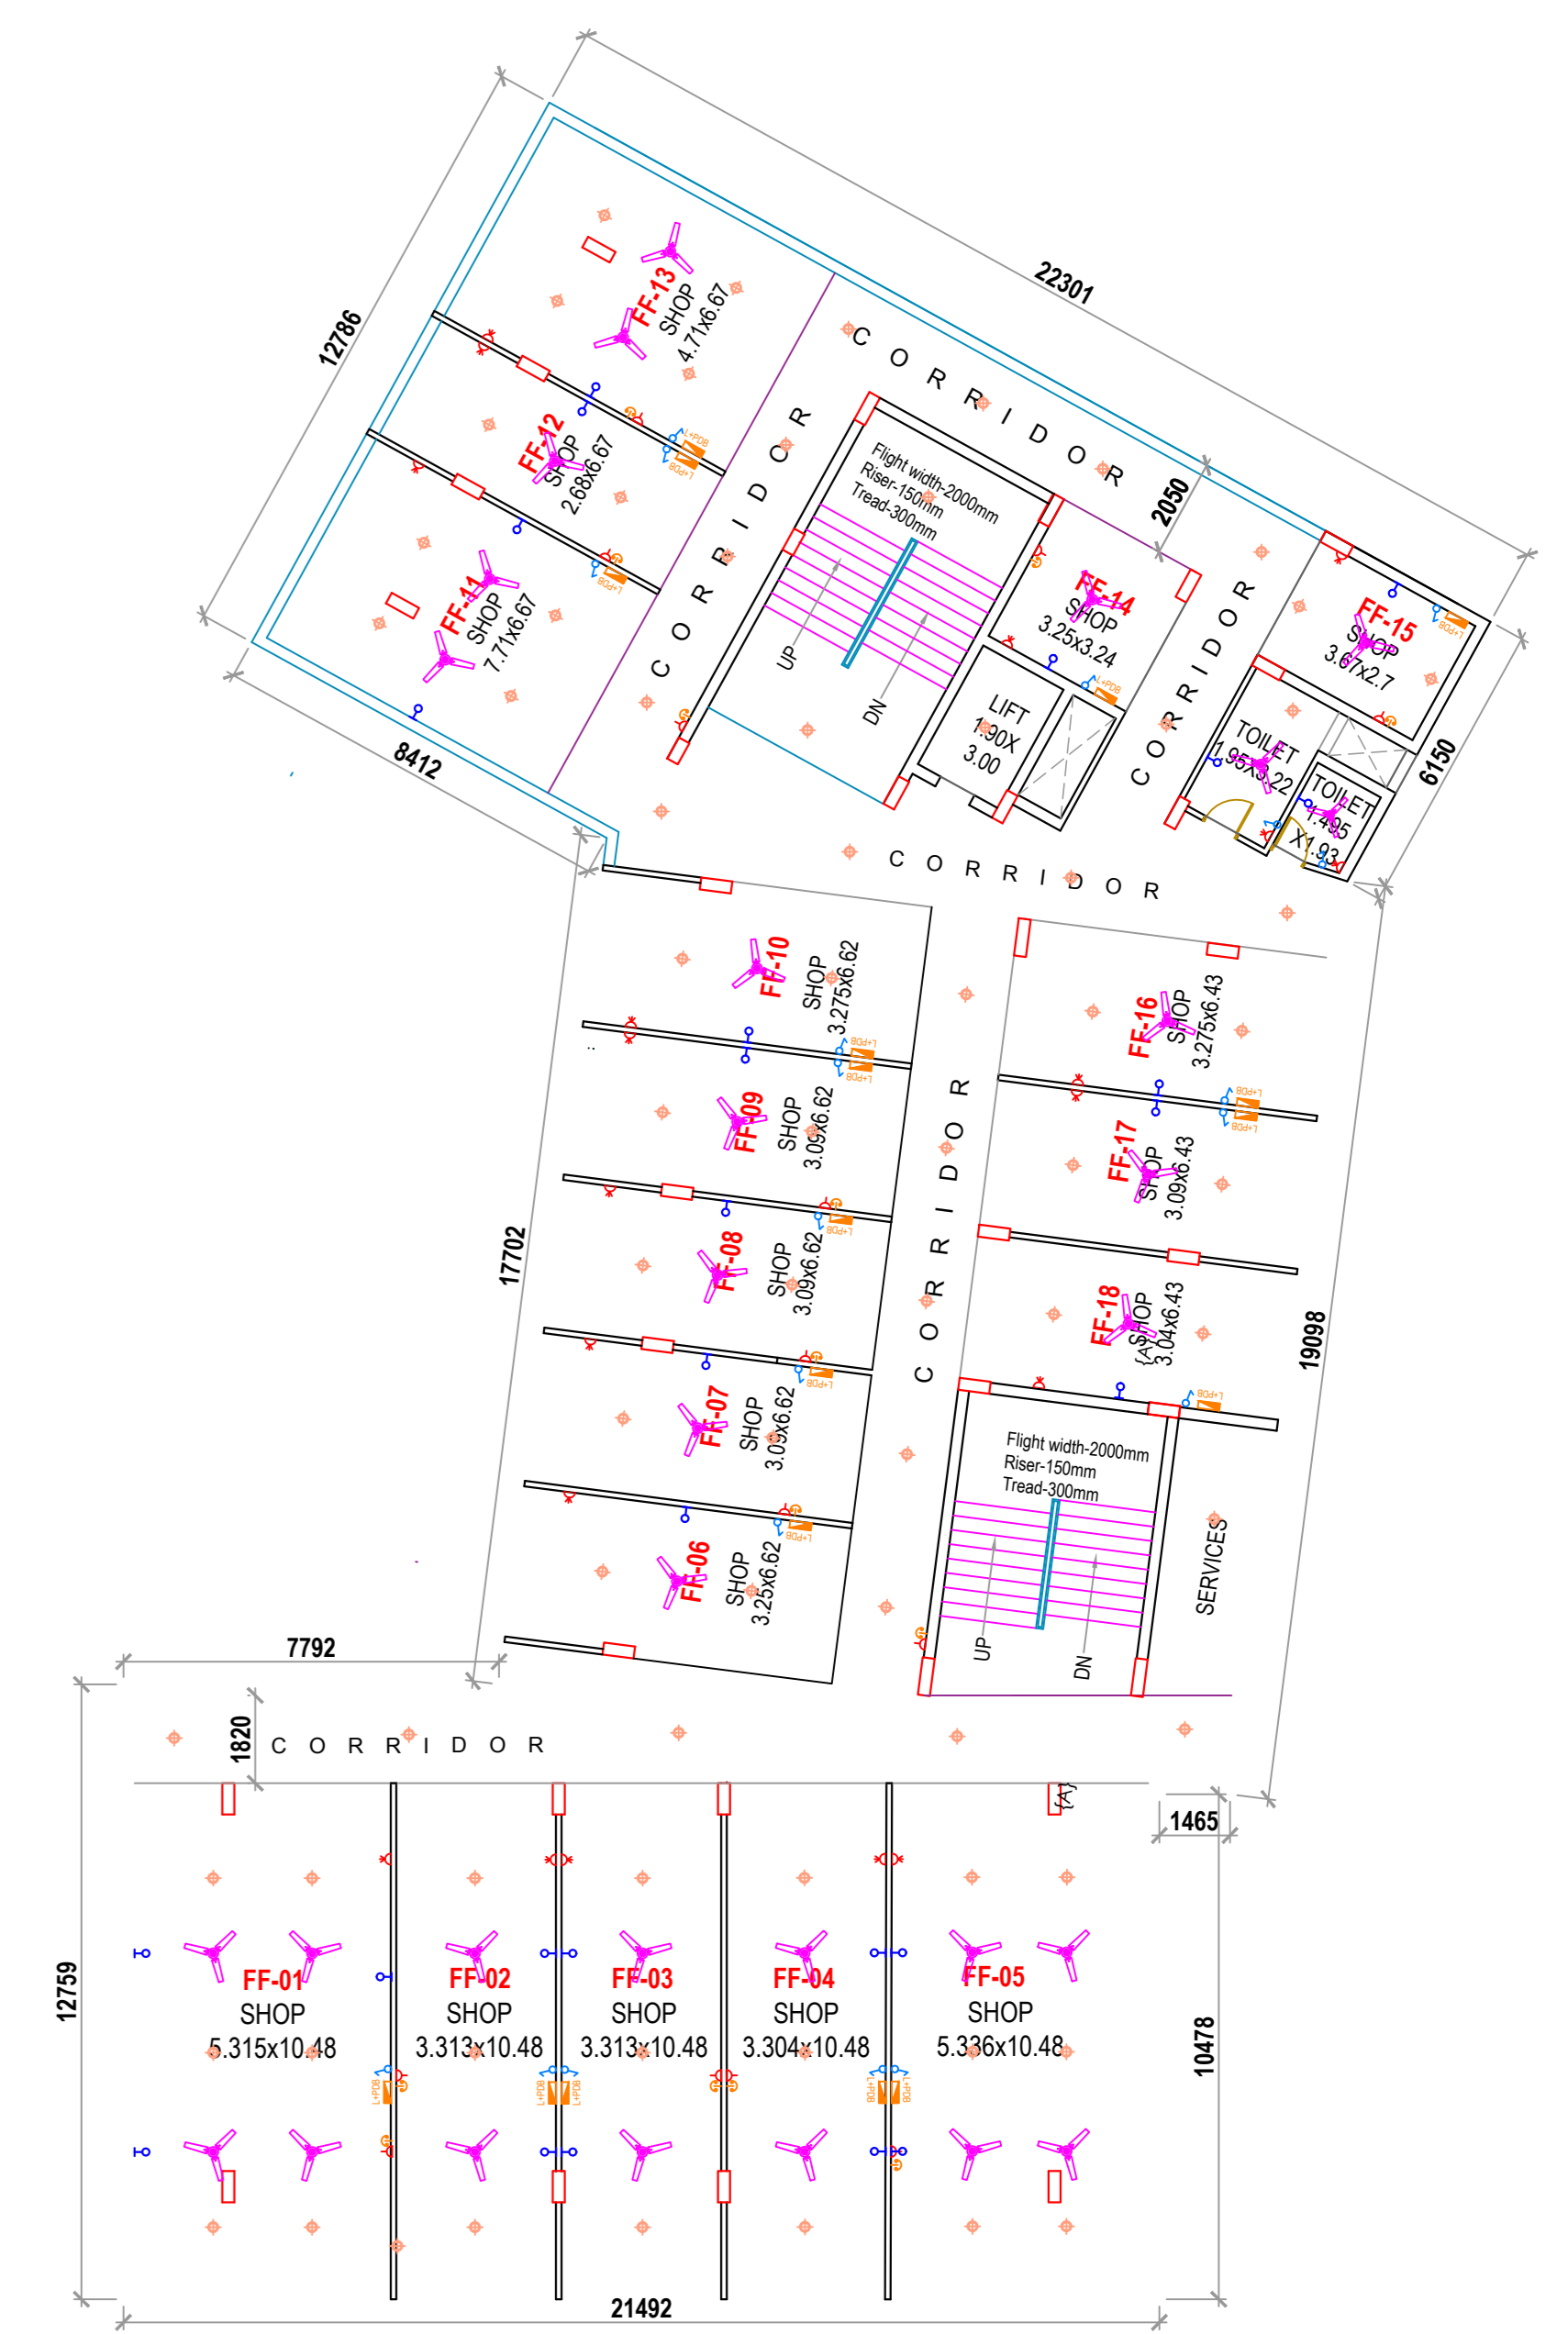

FIRST FLOOR PLAN
(SCALE 1:200)

LEGEND :

SYMBOL	DESCRIPTION	MOUNTING HEIGHT ABOVE FL. LVL.
	8 Way SPN DB	1100
	LIGHT POINT	2100
	5A/15A POWER	300
	15A POWER	300
	CEILING FAN	-
	CEILING LIGHT	-

ELECTRICAL LAYOUT

PROJECT:
**LOCAL SHOPPING AT COMMERCIAL-01,
RESIDENTIAL TOWNSHIP ELDECO IMPERIA,
JAITIKHERA, LUCKNOW.**

DRG.NO.:
SERVICES/04

SCALE:
1:200

DATED:
23.09.2025

DEVELOPER/PROMOTER:

ELDECO HOUSING & INDUSTRIES LTD.

ARCHITECT:

espaces