


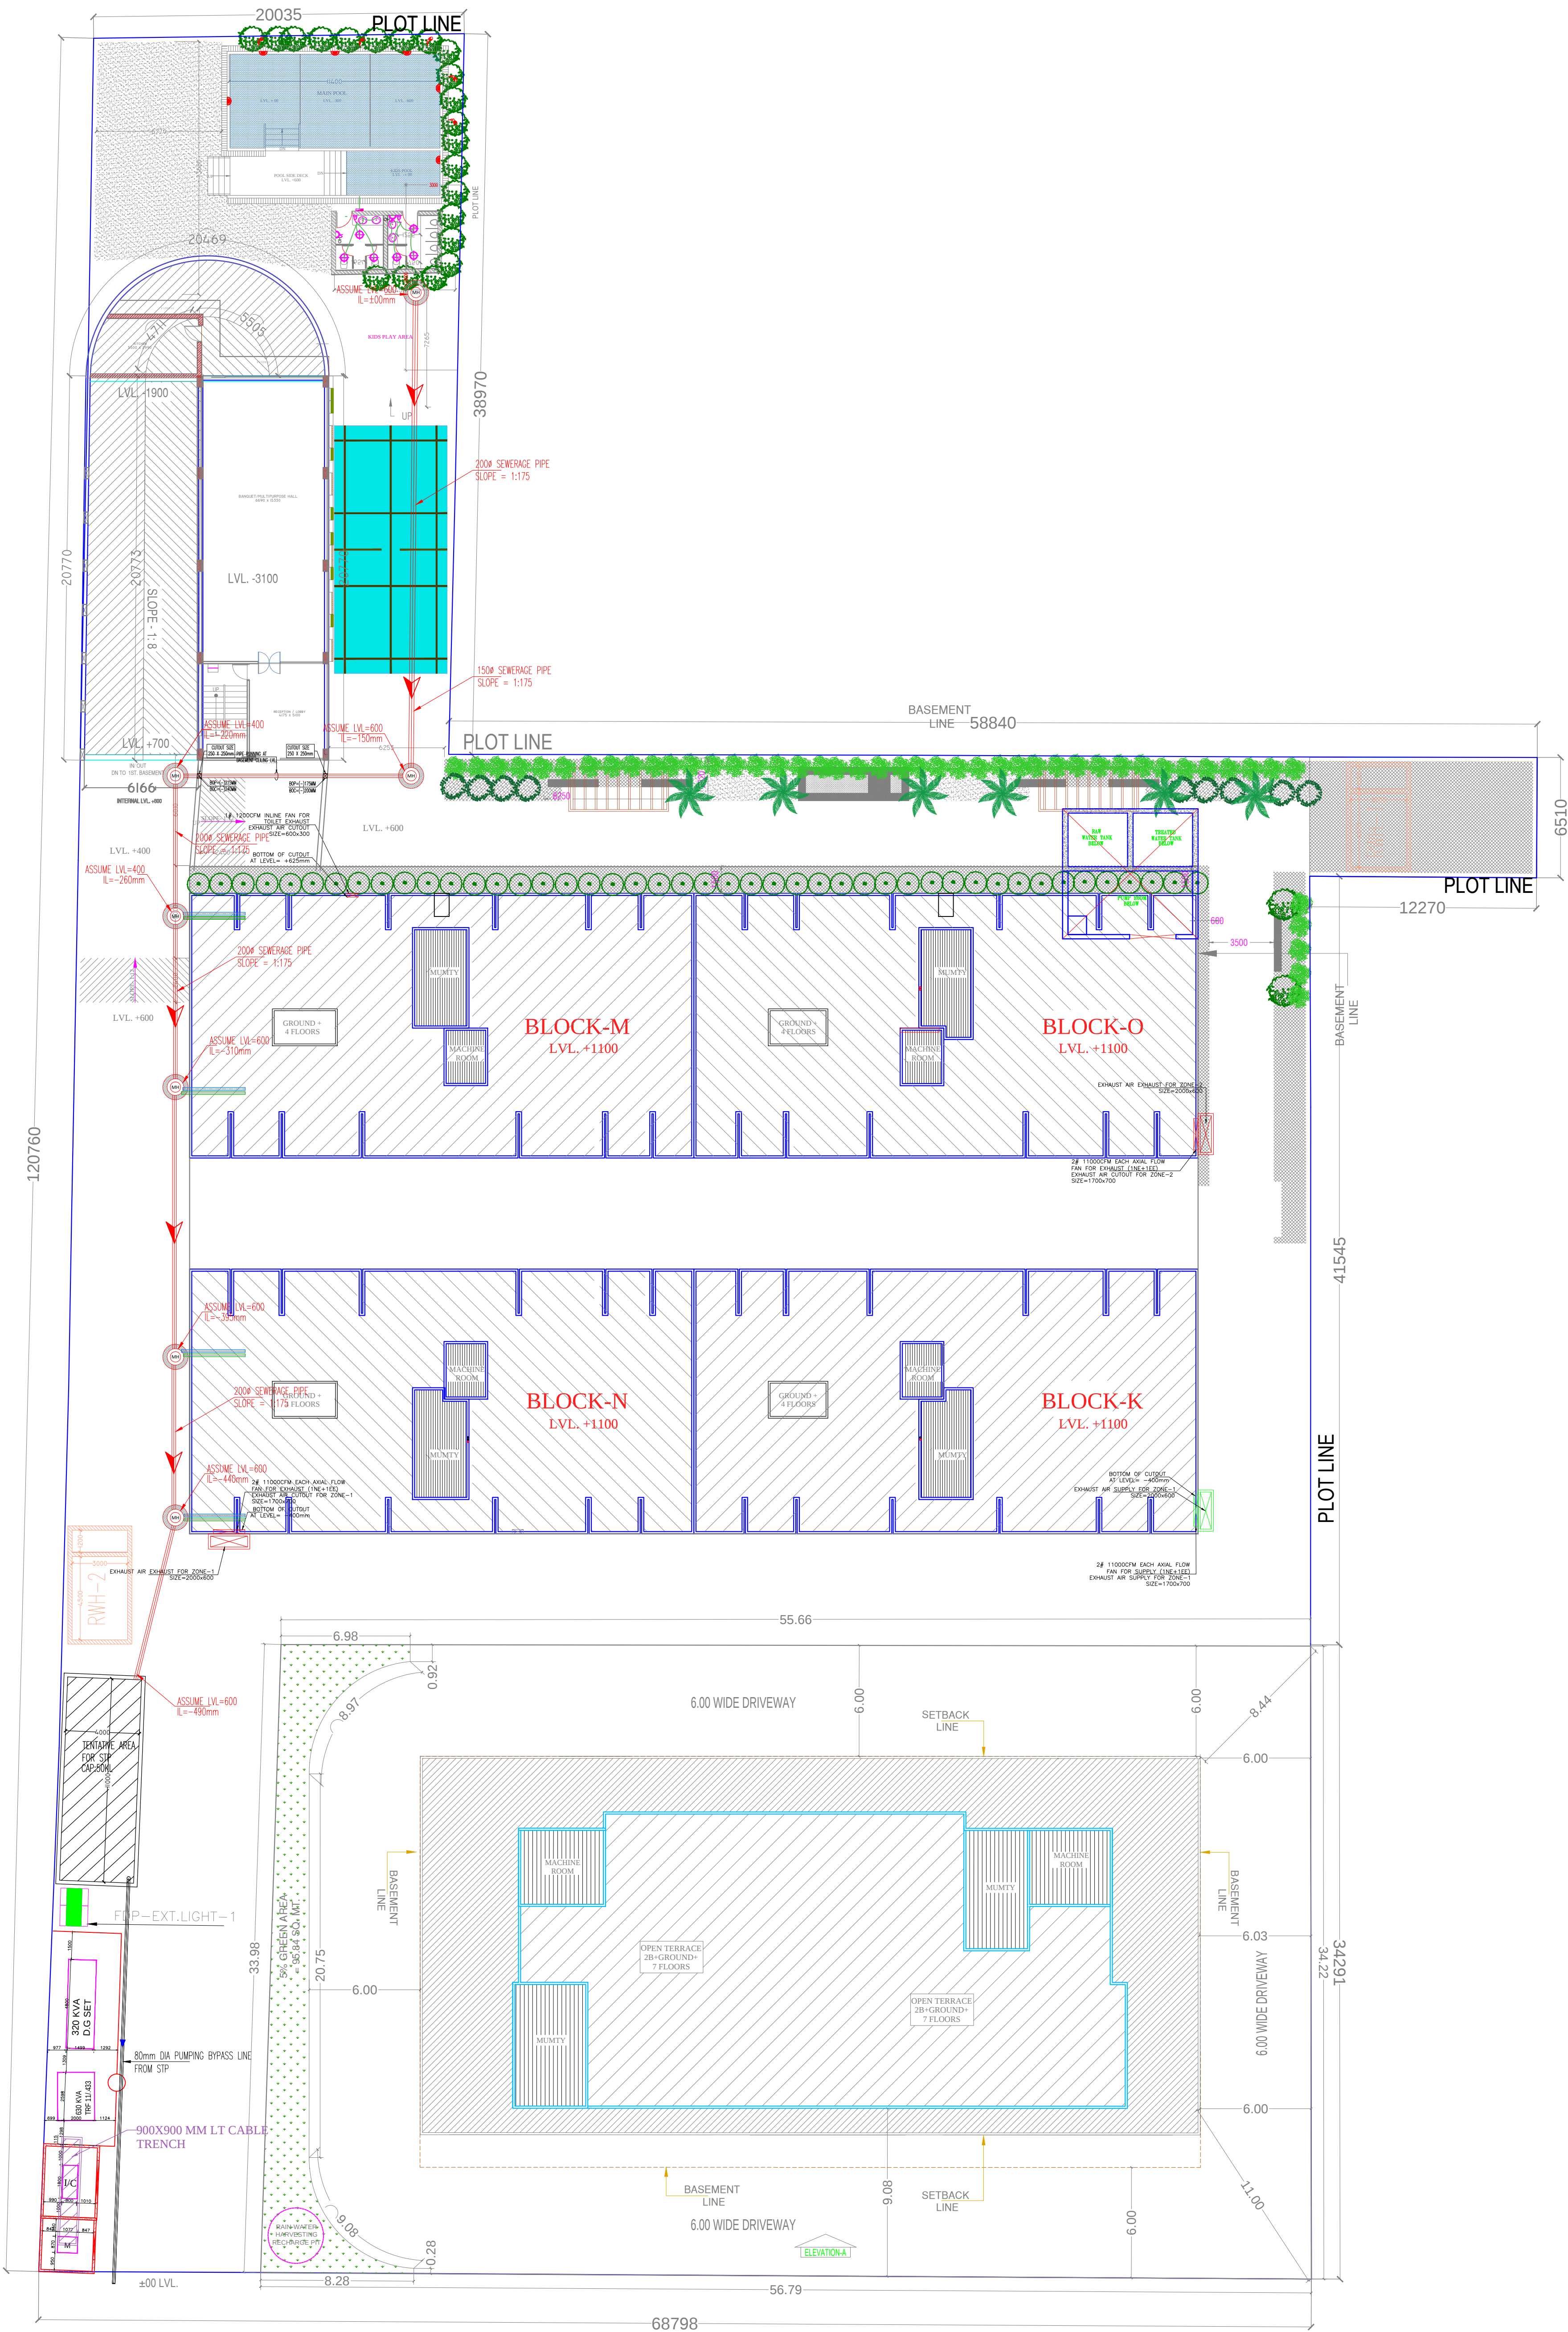

IMPORTANT NOTES:-
1 DRAINAGE PLAN OF NON TOWER AREA SHALL BE PREPARED BASED ON LANDSCAPE PLAN.
2 FOR LOCATION OF MANHOLE/RECHARGE WELL, FIRE HYDRANT,GARDEN HAYDRANT.PLEASE REFER SETTING OUT PLAN ISSUED BY LANDSCAPE CONSULTANT.

LEGENDS FOR PLUMBING:-	
	MH MANHOLE FOR SEWERAGE
	MH MANHOLE FOR WATER SUPPLY
	SEWERAGE LINE

S.No.	SIZE OF MANHOLE	DEPTH OF MANHOLE
	600x600mm	UPTO 600mm
	900x800mm	BELOW 900mm
	910mm DIA	900mm TO 1235mm

PROJECT -
PROJECT NAME- MONK MONASTERY
KHASRA NO.1144M,1146M VVIP ADDRESSES
ALONG - VILL. NOORNAGAR GHAZIABAD (U.P.)
OWNER -
FOR M/s. MAHESHA INFRAVALLEY PVT. LTD.
DRAWING TITLE :-
EXTERNAL SEWERAGE
LAYOUT

OWNER SIGN **ARCHITECT SIGN**
ARCHITECTS & PLANNERS:
SINGLA ARCHITECTS & ASSOCIATES
EROS MARKET PLACE, PLOT NO- 02, SHOP - 87 1ST. FLOOR
SHAKTI KHAND - 2, INDIRAPURAM, GHAZIABAD (U.P.)
Mob: 9971998445
e-mail : gsingla32@gmail.com,

MEP Consultant:

WeDESIGN Associates
"Engineered to perfection"
Email - wedesignconsultancy@gmail.com
Mob. - 9999288416, 9999288407, 9882244495
DRAWN BY:- SAURAV
CHECKED BY:- D.K.
SCALE:- 1 : 100
DATE:- 22/07/2023
DRG. No.:- PL-EXT-02