

MEP Consultant:-  
**M.S ASSOCIATES**  
MEP CONSULTANT ENGINEERS  
New Delhi



**SEAL & SIGN  
OF ARCHITECT**

**ARCHITECT  
JITENDRA JAIN  
(B.Arch.) C.O.A.**  
REGD. NO. CA/97/21516  
COUNCIL OF ARCHITECTURE  
Mob. 9616499432  
6332001999 18/04/2025

ELECTRICAL FEEDER  
PILLAR PANEL

NOTE-1: THIS DRAWING IS THE PROPERTY  
OF "ASHAROOP" ARCHITECTS,  
PLANNERS AND ITS AGAIN USE IN ANY  
MANNER, BY ANY PERSON IS  
LEGALLY STRICTLY PROHIBITED.

2: THE DRAWING (STRUCTURAL &  
ARCHITECTURAL) MAY BE IMMEDIATE  
CHANGE AS PER ON PRESENT SITE  
WORKING CONDITIONS. IF REQUIRED,  
ONLY AFTER THE WRITTEN PERMISSION  
OF THE ARCHITECT.

**SHEET TITLE: SITE PLAN, (EXTERNAL-  
ELECTRIFICATION LIGHTING LOOPING,  
LAYOUT PLAN.**

DATE:	30.05.2025.
DEALT BY:	
CHECKED BY:	J.J.
PROJECT CODE:	
DRAWING SET NO:	02
SHEET SIZE:	A1



ASHAROOP ARCHITECTS

## SITE PLAN ELECTRICAL LIGHTING LOOPING LAYOUT PLAN

**ARCHITECT  
JITENDRA JAIN  
(B.Arch.) C.O.A.**  
ARCHITECTS, ENGINEERS, PLANNERS,  
VALUERS, BUILDERS, CONSULTANTS  
AND INTERIOR DESIGNERS  
99-C, South Malaka, (Jain Market)  
ALLAHABAD  
Mob. 9616499432, PH. 2564132  
6332001999 18/04/2025



S. NO.	SYMBOL	SPECIFICATION	Nos.
1.		150W X 6, 10MTR. HIGH MAST FLOOD LIGHT FIXTURE SET	03
2.		30W LED STREET LIGHT (POLE HT.-6 MTR.) (MAKE:- BAJAJ, TYPE/MODEL NO:- BRITG 60W LED)	09
3.		24W Solar LED Street light (Pole Ht.- 6.0 Mtr.) (Make:- Bajaj, Model No:- 21W LED solar streetlight system (3 day Backup)	08
4.		FEEDER PILLAR PANEL	01

**PROJECT**  
**PROPOSED "AFFORDABLE GROUP HOUSING**  
**BUILDING" ON ARAZI No. 147, 467, 468/2, 469 &**  
**471, AT MAUZA BARAUNDHA ANDAR, TAPPA -84,**  
**PARAGNA KANTIT, TEHSIL SADAR, DISTT.**  
**MIRZAPUR, U.P.**

DRG. NO.	EL-01
SHEET NO.	
SIZE	A1
DETAILED BY:	RITU
MEASUREMENTS :	ALL DIMENSION IN M.
CHECKED BY:	AJAY KUMAR
SCALE	1:100
DATE-	18.04.2025

**ASHAROOP**  
**ARCHITECTS, PLANNERS, ENGINEERS, VALUERS,**  
**CONSULTANTS, BUILDERS, ESTIMATORS, INTERIOR DESIGNERS**  
**& VASTU CONSULTANTS.**  
99-C, SOUTH MALAKA, (JAIN MARKET), PRAYAGRAJ (211003) (U.P.), INDIA.  
E-mail: asharooparchitects@gmail.com jitendra.jain23@rediffmail.com  
Mobile: 6392001999, 8178125856, 9616499432  
**ARCHITECT**  
**RISHABH JAIN**  
(B. ARCH.) Honours, C.O.A.  
BACHELOR OF ARCHITECTURE, REGISTERED WITH COUNCIL OF ARCHITECTURE.

<b>OWNER -</b> <b>M/s. KUNJBEHARIL REALTY PRIVATE LIMITED</b> DIRECTOR - SRI VISHWANATH PRASAD AGRAWAL SRI RADHEY SHYAM AGRAWAL	<b>SIGN. OF OWNER</b> <b>SEAL &amp; SIGN. OF ENGINEER</b> S/O
--	---

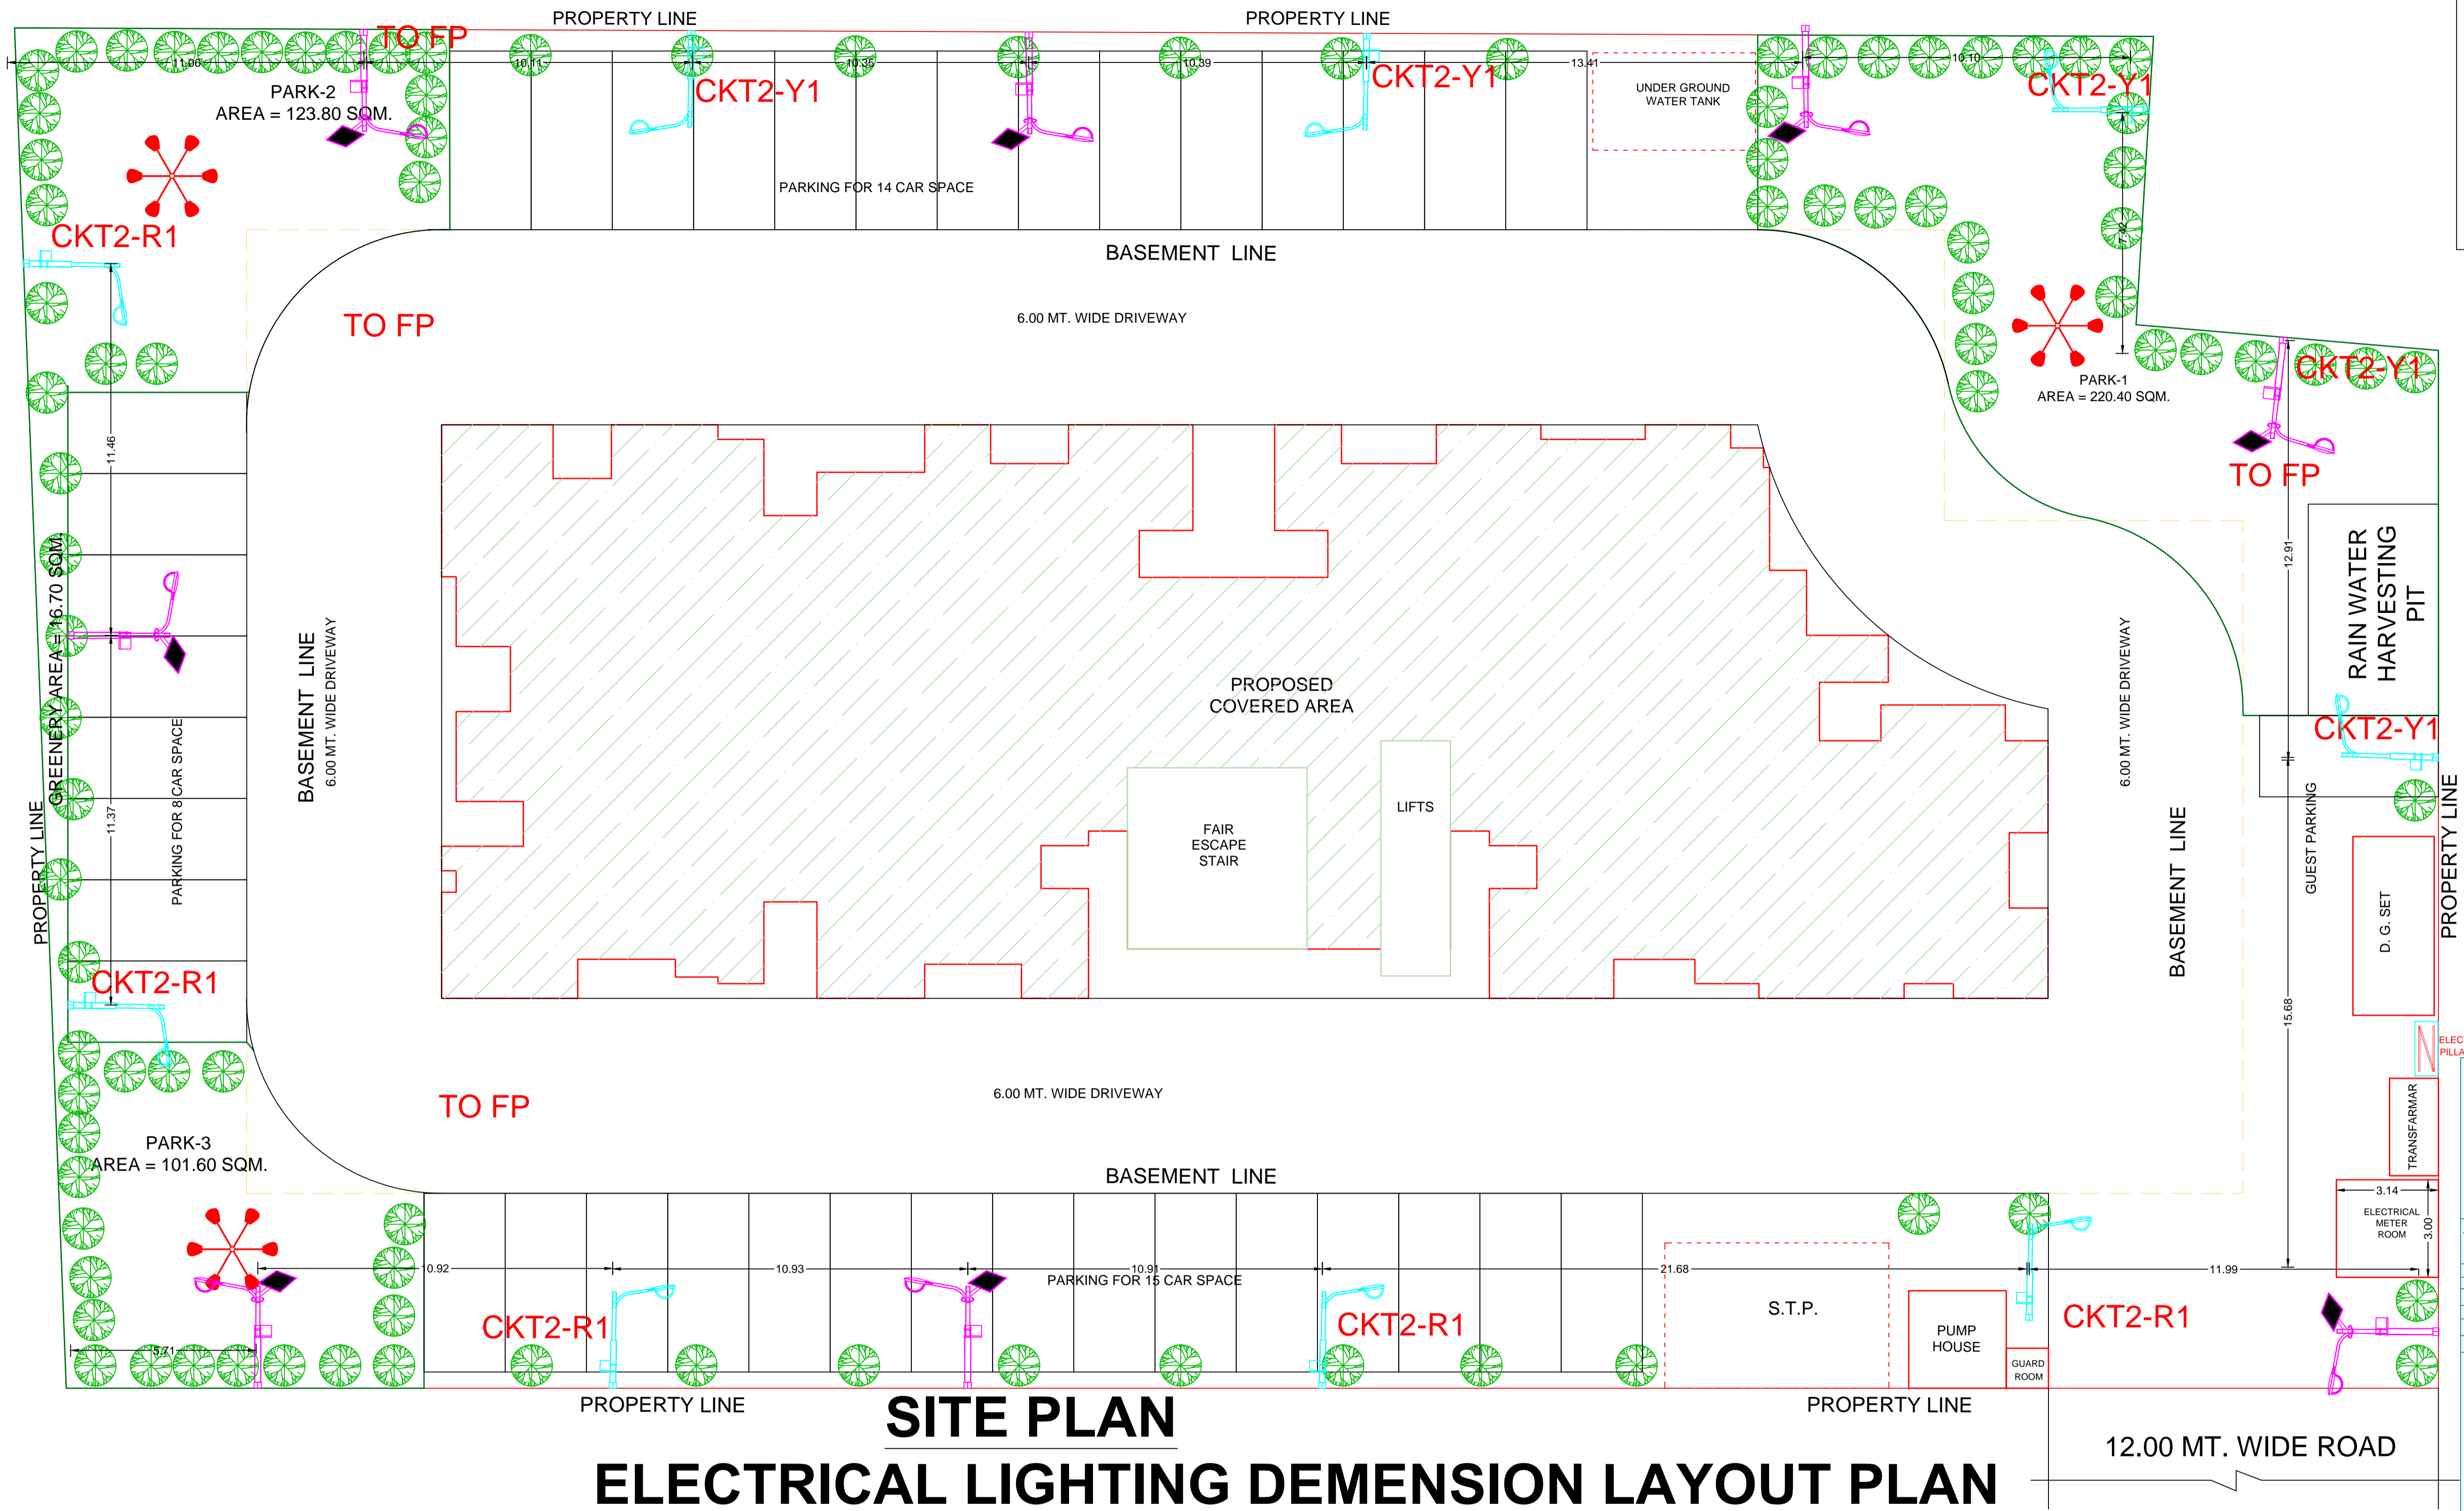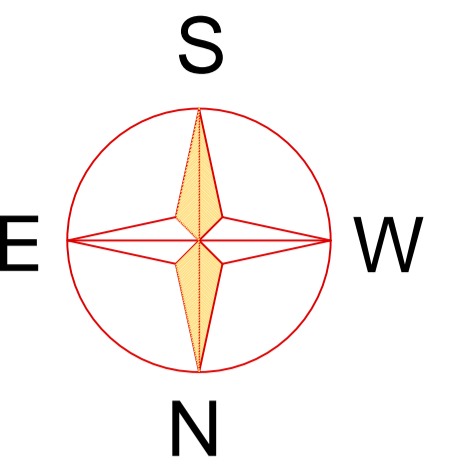

# SITE PLAN

## ELECTRICAL LIGHTING DEMENSION LAYOUT PLAN

ARCHITECT  
**JITENDRA JAIN**  
(B.Arch.) C.O.A.  
ARCHITECTS, ENGINEERS, PLANNERS,  
VALUERS, BUILDERS, CONSULTANTS,  
AND INTERIOR DESIGNERS  
99-C, South Malika, (Jain Market)  
ALLAHABAD  
Mob. 9616499432, PH. 2564132  
6392001999

S. NO.	SYMBOL	SPECIFICATION	Nos.
1.		150W X 6, 10MTR. HIGH MAST FLOOD LIGHT FIXTURE SET	03
2.		30W LED STREET LIGHT (POLE HT.-6 MTR.) (MAKE:- BAJAJ, TYPE/MODEL NO:- BRTEG 60W LED)	09
3.		24W Solar LED Street light (Pole Ht.- 6.0 Mtr.) (Make:- Bajaj, Model No:- 21W LED solar streetlight system (3 day Backup)	08
4.		FEEDER PILLAR PANEL	01

**PROJECT**  
**PROPOSED "AFFORDABLE GROUP HOUSING BUILDING" ON ARAZI No. 147, 467, 468/2, 469 & 471, AT MAUZA BARAUNDHA ANDAR, TAPPA -84, PARAGNA KANTIT, TEHSIL SADAR, DISTT. MIRZAPUR , U.P.**

DRG. NO.	EL-01
SHEET NO.	
SIZE	A1
DETAILED BY:	RITU
MEASUREMENTS :	ALL DIMENSION IN M.
CHECKED BY:	AJAY KUMAR
SCALE	1:100
DATE:-	18.04.2025

ARCHITECTS, PLANNERS, ENGINEERS, VALUERS, CONSULTANTS, BUILDERS, ESTIMATORS, INTERIOR DESIGNERS & VASTU CONSULTANTS.  
99-C, SOUTH MALIKA, (JAIN MARKET), PRAYAGRAJ (211003) (U.P.), INDIA.  
E-mail: asharooparchitects@gmail.com, jitendra.jain23@rediffmail.com  
Mobile: 6392001999, 8178125856, 9616499432  
ARCHITECT  
**RISHABH JAIN**  
(B. ARCH.) Honours, C.O.A.  
1996  
BACHELOR OF ARCHITECTURE, REGISTERED WITH COUNCIL OF ARCHITECTURE.

SIGN. OF OWNER  
**OWNER -**  
M/s. KUNJBEHARILAL REALTY PRIVATE LIMITED  
DIRECTOR -SRI VISHWANATH PRASAD AGRAWAL  
S/O SRI RADHEY SHYAM AGRAWAL

MEP Consultant:-  
**M.S ASSOCIATES**  
MEP CONSULTANT ENGINEERS  
New Delhi



SEAL & SIGN  
OF ARCHITECT

ARCHITECT  
**JITENDRA JAIN**  
(B.Arch.) C.O.A.  
REGD. NO. CA/9721516  
COUNCIL OF ARCHITECTURE  
Mob. 9616499432  
6392001999

NOTE-1: THIS DRAWING IS THE PROPERTY OF "ASHAROOP" ARCHITECTS, PLANNERS AND ITS AGAIN USE IN ANY MANNER, BY ANY PERSON IS LEGALLY STRICTLY PROHIBITED.  
2: THE DRAWING (STRUCTURAL & ARCHITECTURAL) MAY BE IMMEDIATE CHANGE AS PER ON PRESENT SITE WORKING CONDITIONS, IF REQUIRED, ONLY, AFTER THE WRITTEN PERMISSION OF THE ARCHITECT.

SHEET TITLE: SITE PLAN, (EXTERNAL-ELECTRIFICATION LIGHTING DIMENSION LAYOUT PLAN).

DATE:	30.05.2025.
DEALT BY:	
CHECKED BY:	J.J.
PROJECT CODE:	
DRAWING SET NO:	01
SHEET SIZE:	A1

