




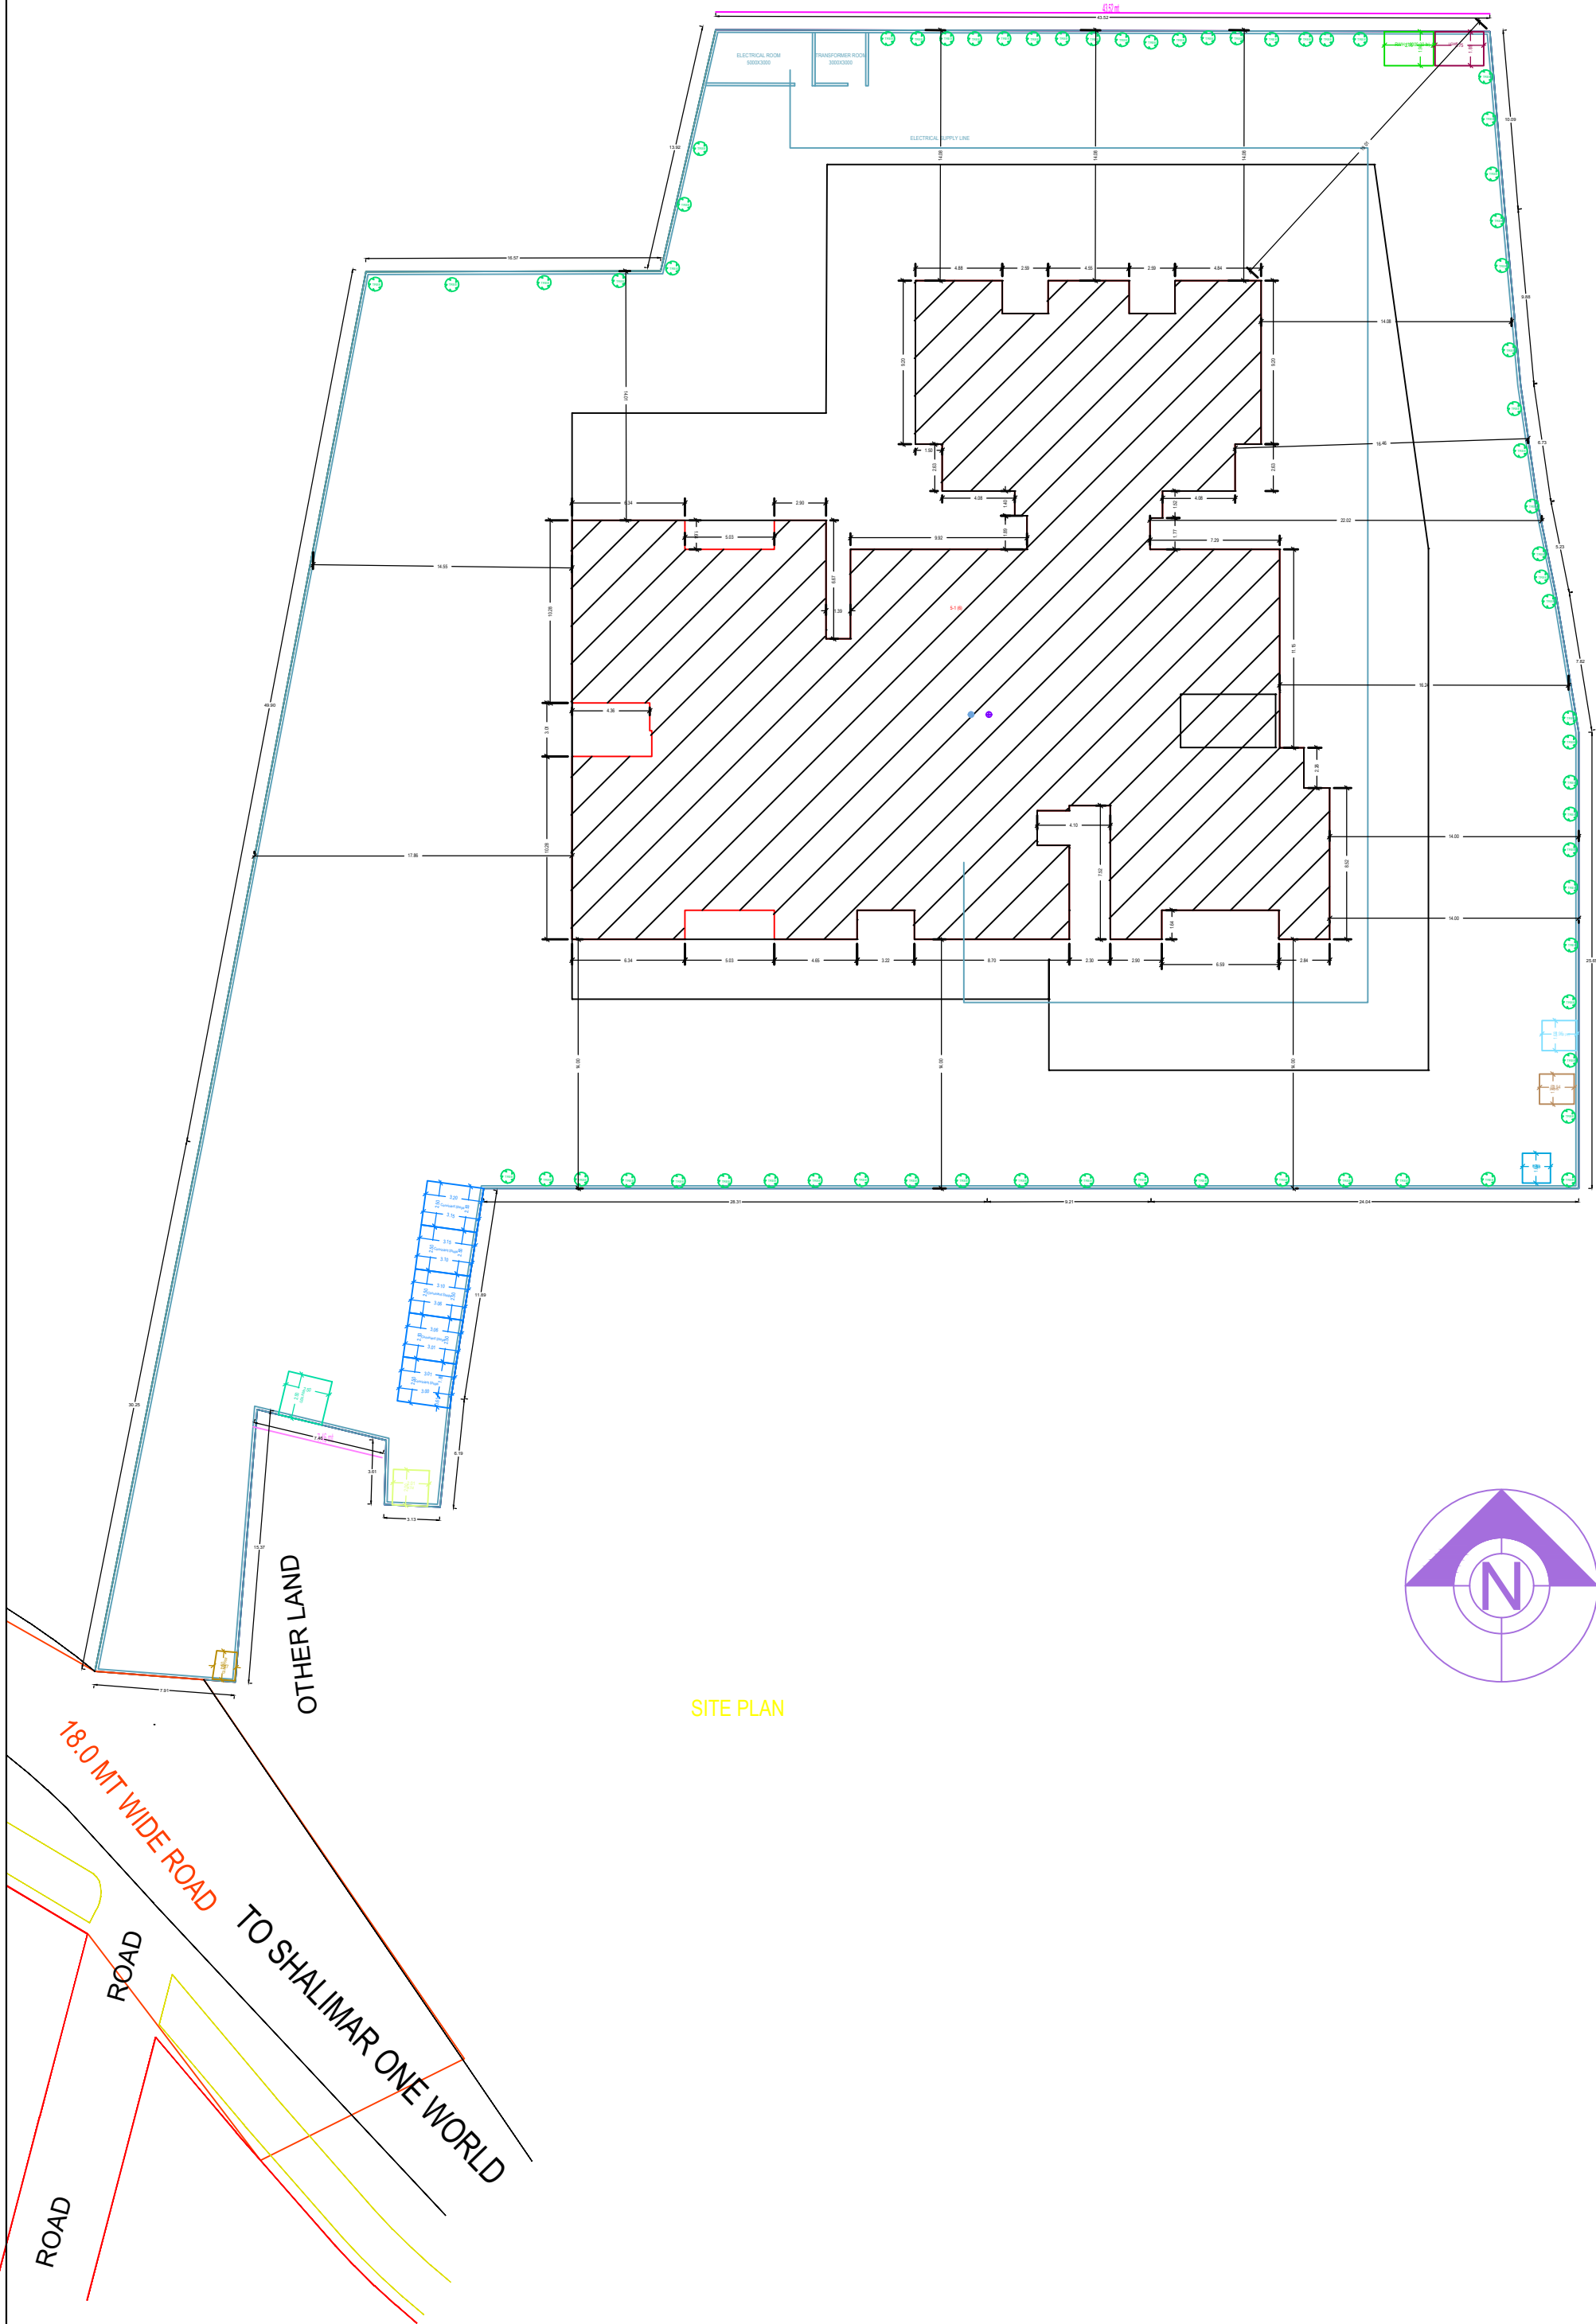

SITE PLAN

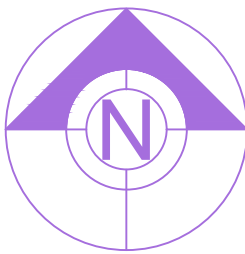

CLIENT : MR. SHARAD SINGH	
ARCHITECT : AR. FARAZ A SIDDIQUI	
TITLE :	
DRAWING : ELECTRICAL LAYOUT PLAN	
DEALT BY : AMAR YADAV	
DATE :	DIRECTION :
SCALE : N.T.S.	
SHEET NO. : 01	RIVISIONS : 00
REMARKS :	

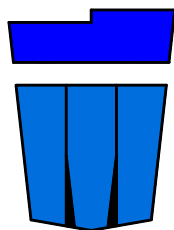

**CREDENCE
DESIGNERS**

WEB. -
WWW.CREDENCEDESIGNERS@GMAIL.CO
CONT. - +91-8808888846