


LEGEND		
S.NO.	DESCRIPTION	SYMBOL
1.	MANHOLE (600X600mm)	
2.	GULLY TRAP (300X300mm)	
3.	CATCH BASIN (600X600mm)	

LEGEND		
S.NO.	DESCRIPTION	SYMBOL
1.	110mm OD PVC SOIL PIPE	
2.	110mm OD PVC WASTE PIPE	
3.	160/200mm OD PVC SEWER PIPE (SLOPE 1:100)	
4.	150/200mm OD RCC SEWER PIPE (SLOPE 1:125)	
5.	160/200mm OD PVC RAIN WATER PIPE (SLOPE 1:135)	
6.	150/200mm OD RCC RAIN WATER PIPE (SLOPE 1:150)	

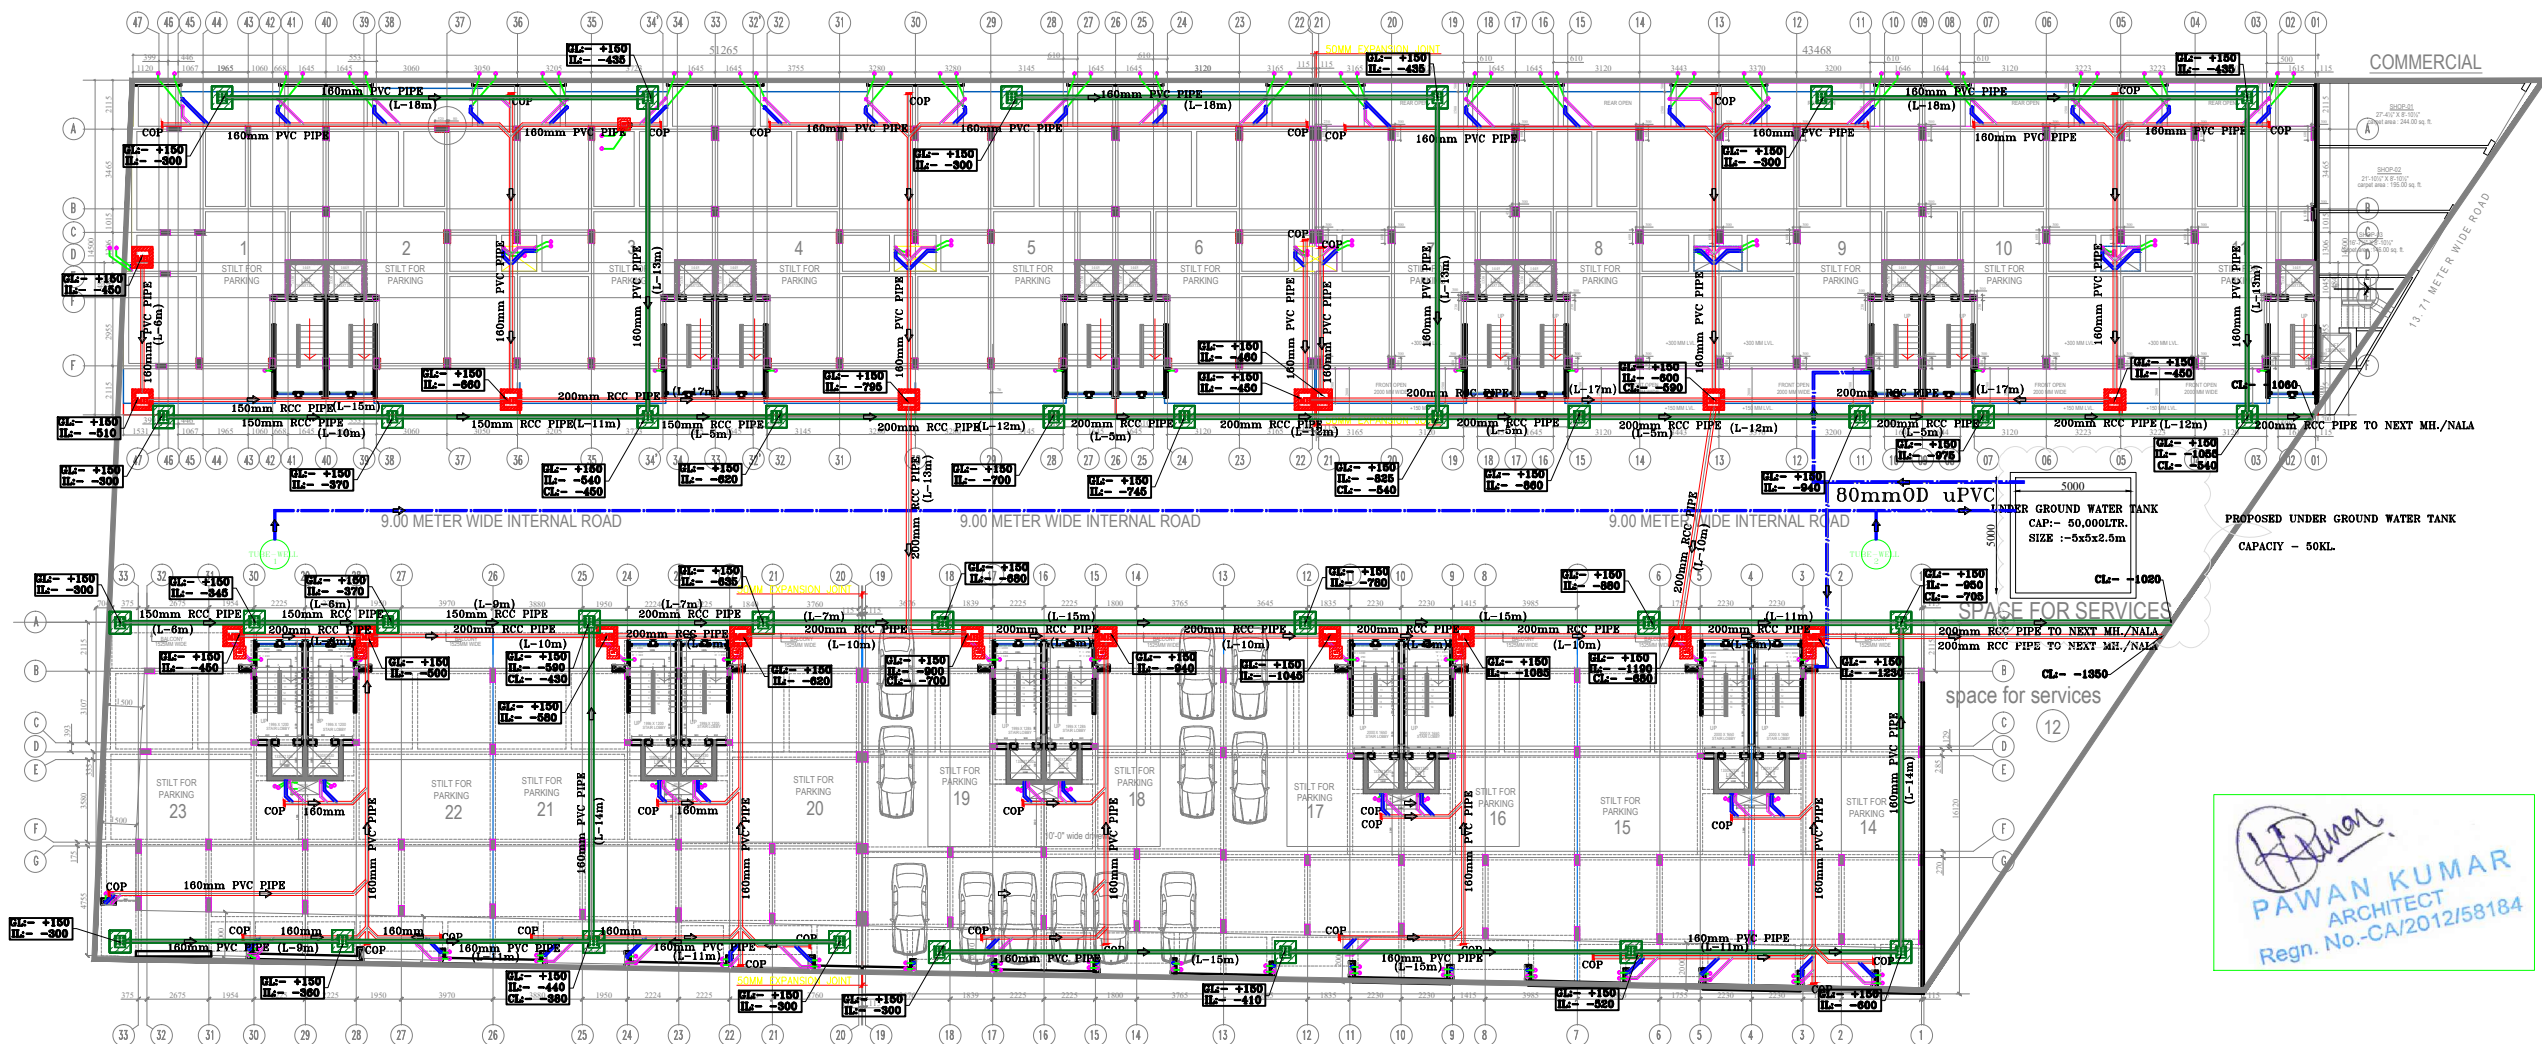


PAWAN KUMAR
ARCHITECT
Regn. No.-CA/2012/58184

STILT FLOOR PLAN

Rev. No.	Date	Revision
..	..	..

Project :
PROPOSED ROW HOUSING AT "ROYCE VAISHALI"
PLOT NO.18B,SECTOR-3,
VAISHALI, GHAZIABAD

Title :
WORKING DRG. SEWER LINE

Subtitle :
WORKING DRG. STILT FLOOR PLAN

Drawing Released For :
☒ APPROVAL ☐ SUBMISSION
☐ ADVANCE COPY ☐ CONSTRUCTION

Drg. No :
WD. S.P. - 02

Scale :
1:1000

Date :
24th Apr. 2019

Ckd By :
Pawan Kumar

Drawn By :
Deepak

Design By :
Dushyant Kumar

Architects :
D+P ASSOCIATES
DESIGNERS & PLANNERS
architects,engineers,interior designers,landscape & vastu consult.
L-11, HIMALAYA LEGAND, F.F., NYAY KHAND-1,
INDIRAPURAM, GHAZIABAD Mobile: 98 10888916 , 9 873326241
Email Id: dpassociates2015@gmail.com, dparchitects2015@gmail.com

