


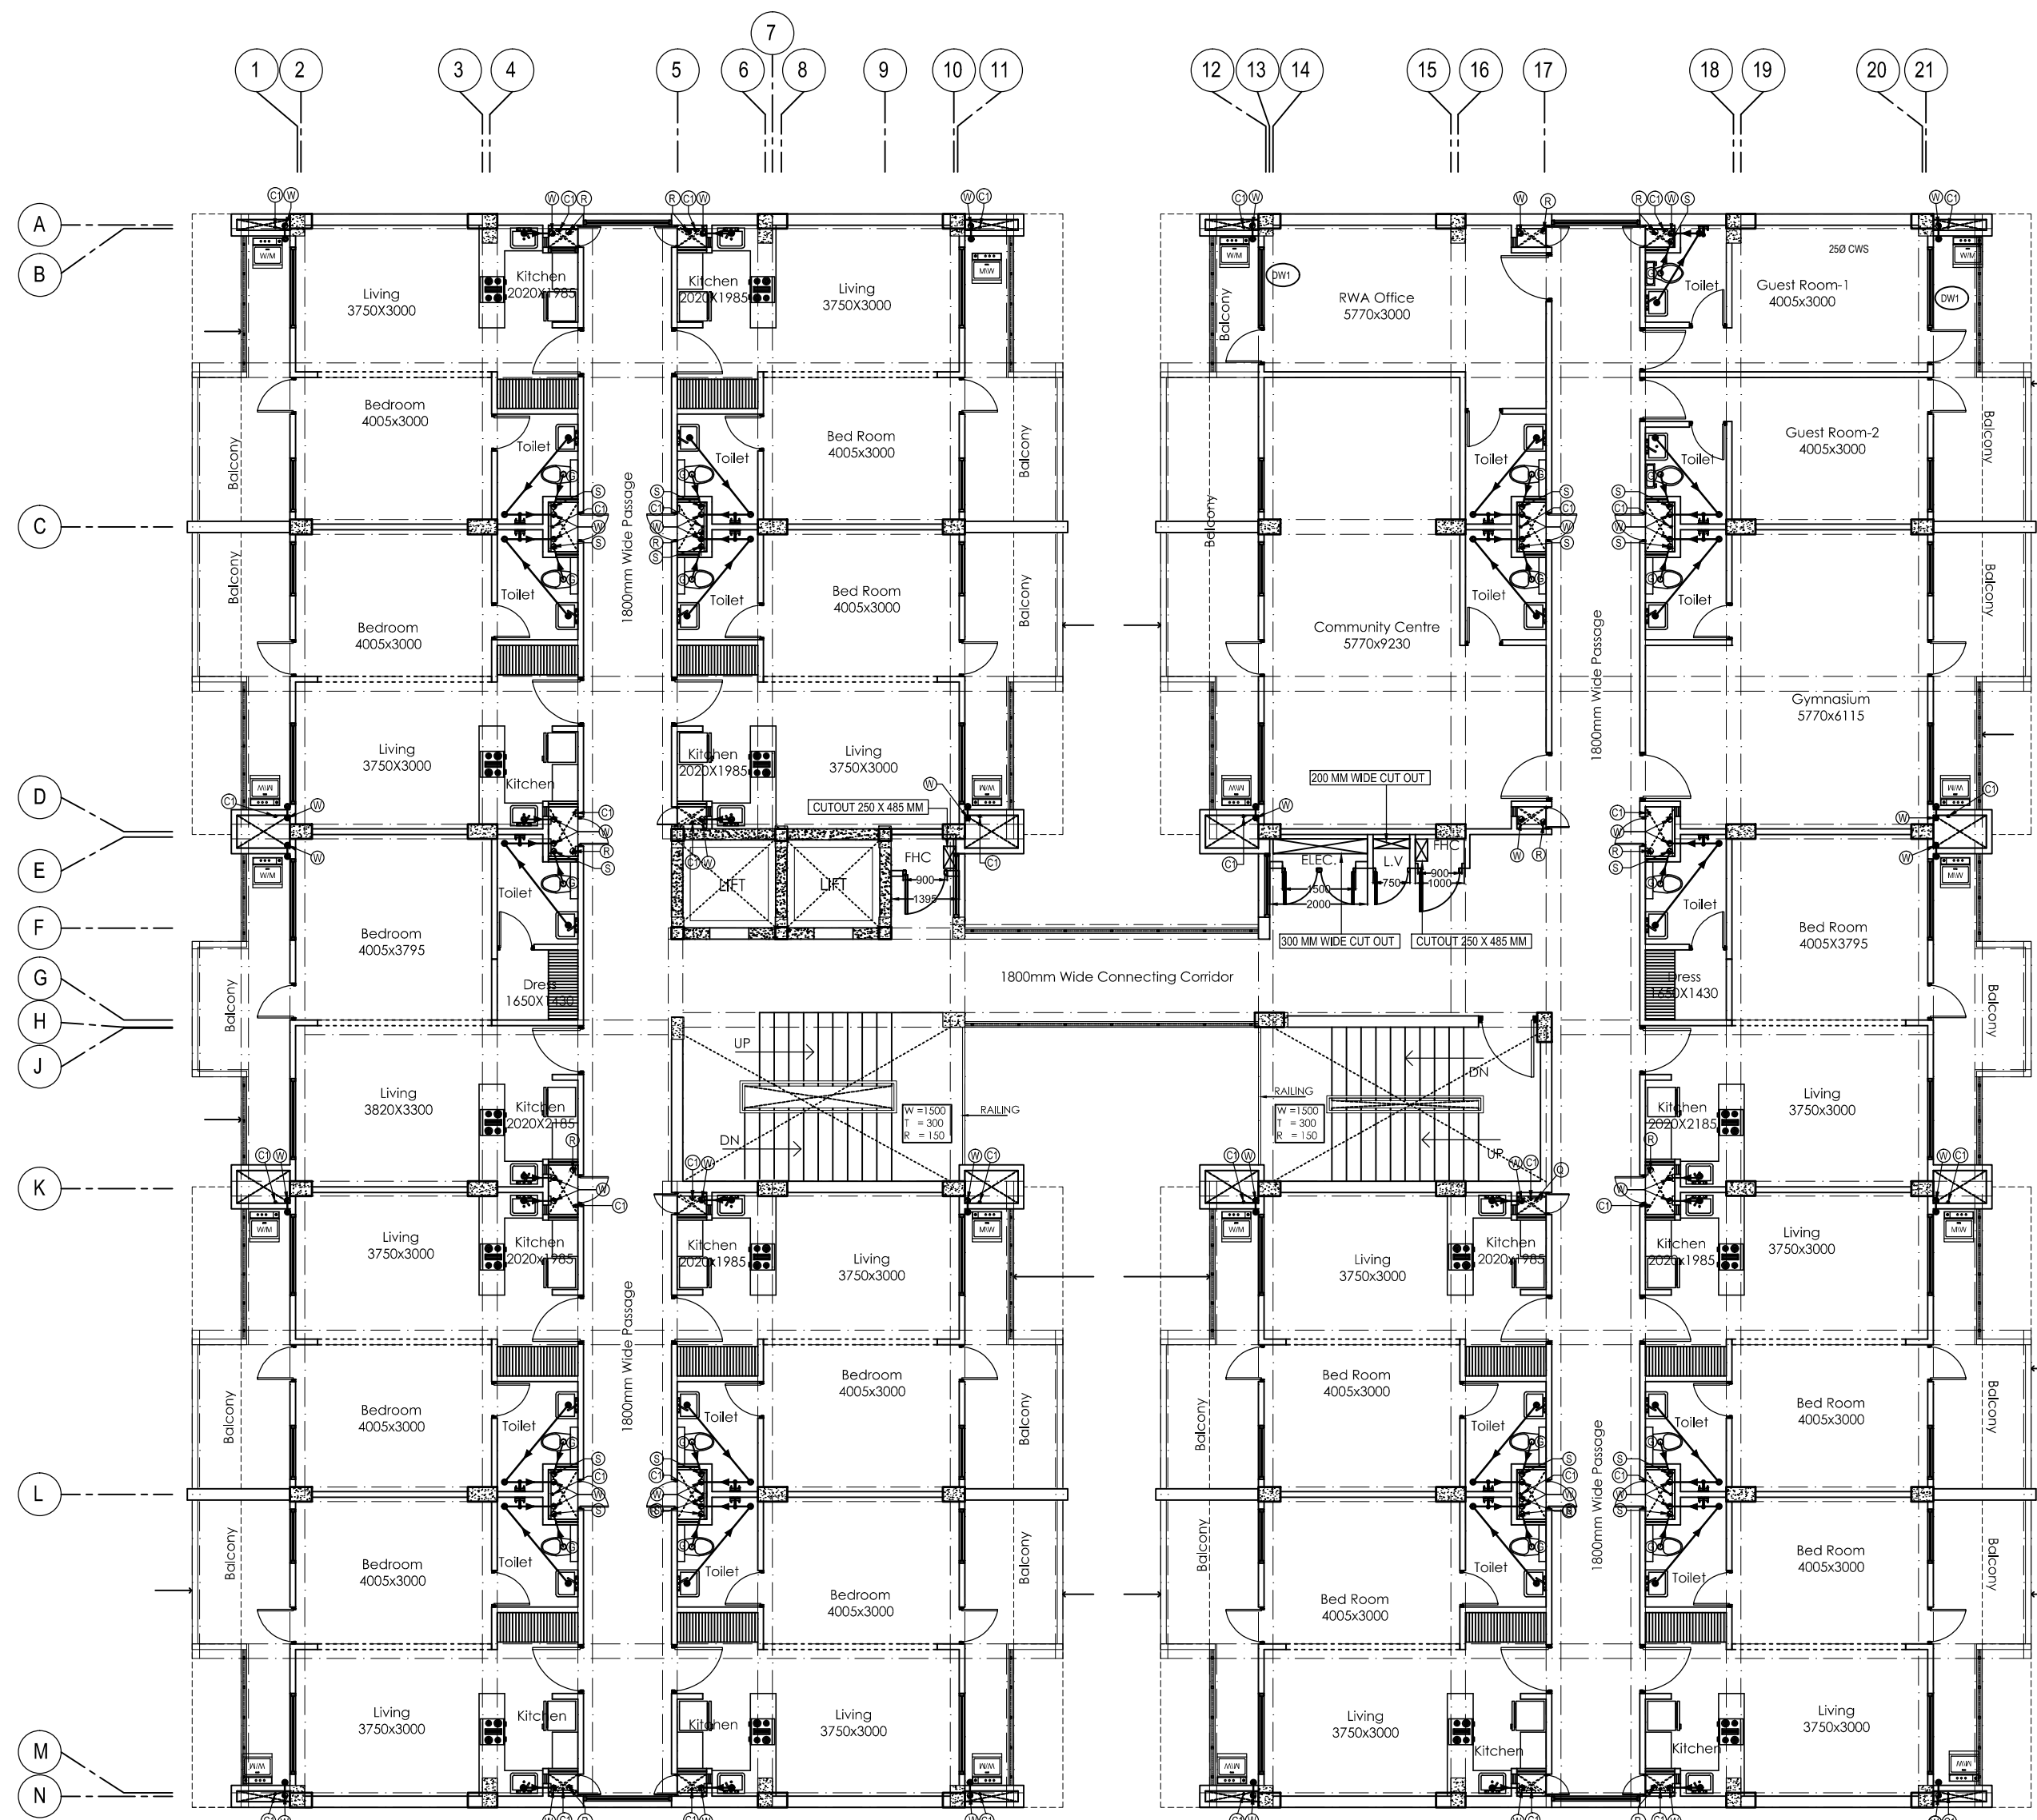

FIRST FLOOR PLAN

LEGEND : (Plumbing)		
S. No.	SYMBOL	DESCRIPTION
1.	(S)	1100 UPVC SOL AND VENT PIPE
2.	(W)	1100 UPVC WASTE AND VENT PIPE
3.	(R)	1100 UPVC RAIN WATER / BALCONY DRAIN PIPE
4.	(B)	750 UPVC F.H.C. / CORRIDOR WASTE PIPE
5.	(C)	DOMESTIC WATER SUPPLY DROP FROM TANK TO TOILET / KITCHEN FOR ALL FLOOR EXCEPT TOP TWO FLOORS
6.	(G)	GEYSER
7.	(W.M.)	WASHING MACHINE
8.	(P.U.)	WATER PURIFIER
9.	(A.T.)	ABLUTION TAP
10.	(H.S.)	HEALTH SPRAY WITH ANGLE VALVE
11.	(T)	TAP
12.	(M.S.)	MIXTURE & SHOWER
13.	(C.W.S.)	COLD WATER SUPPLY PIPE (CWS)
14.	(I.V.)	ISOLATING VALVE
15.	(I.V.M.C.)	ISOLATING VALVE IN MASONRY CHAMBER
16.	(N.R.V.)	NON RETURN VALVE
17.	(D.P.)	DRAIN POINT
18.	(M.F.T.)	MULTI FLOOR TRAP - 6" deep (50 mm seal)
19.	(P.T.)	P TRAP (110 X 110 MM) - long type (50 mm seal)
20.	(S.T.)	S TRAP (110 X 110 MM) (50 mm seal)
21.	(E.W.C.)	EUROPEAN W. C.
22.	(F.B.W.B.)	FLAT BACK WASH BASIN
23.	(C.W.B.)	COUNTER WASH BASIN
24.	(S.D.B.)	SINK WITH DRAIN BOARD
25.	(S.W.D.B.)	SINK WITHOUT DRAIN BOARD

R2	01.03.2016	Issued for approval
R1	03.11.2014	Issued as advance copy for approval
R0	25.06.2014	Issued as advance copy for approval
rev. no.	date	revision

project
PROPOSED GROUP HOUSING AT
Sector-H, KANPUR ROAD SCHEME, LUCKNOW

title
PLUMBING DRAWING

sub title
FIRST FLOOR PLAN

drawing released for
☒ APPROVAL ☐ SUBMISSION
☐ ADVANCE COPY ☐ CONSTRUCTION

dra. no. **P-02** drawn by **Nand Lal**
scale **1:80** designed by **Shakir Shabir**
date **25.06.2014** checked by **Anand Havela**

architects
rajesh & associates
architects, engineers, planners & interior designers
magma house, first floor, D-5, Indira Park, Gurgaon-122 001, India
tel : +91-124-4626666 fax: +91-124-4626668
2, G.N. Road, Sahasrabhoga, Lucknow-226 001, India
Tel : +91-522-2626838 +91-522-2626850

services consultant
Consummate Engineering Services (P) Ltd.
Noida Office - B-67, Sector - 67, Noida - 201 301
Tel : (0120) 2589300 (30 Lines)
Lko. Office - R 006, Rohtas Plumeria, Gomti Nagar, Lucknow
Tel : (0522) 6515455
e mail : mail@cespl.in, website : www.cespl.in