


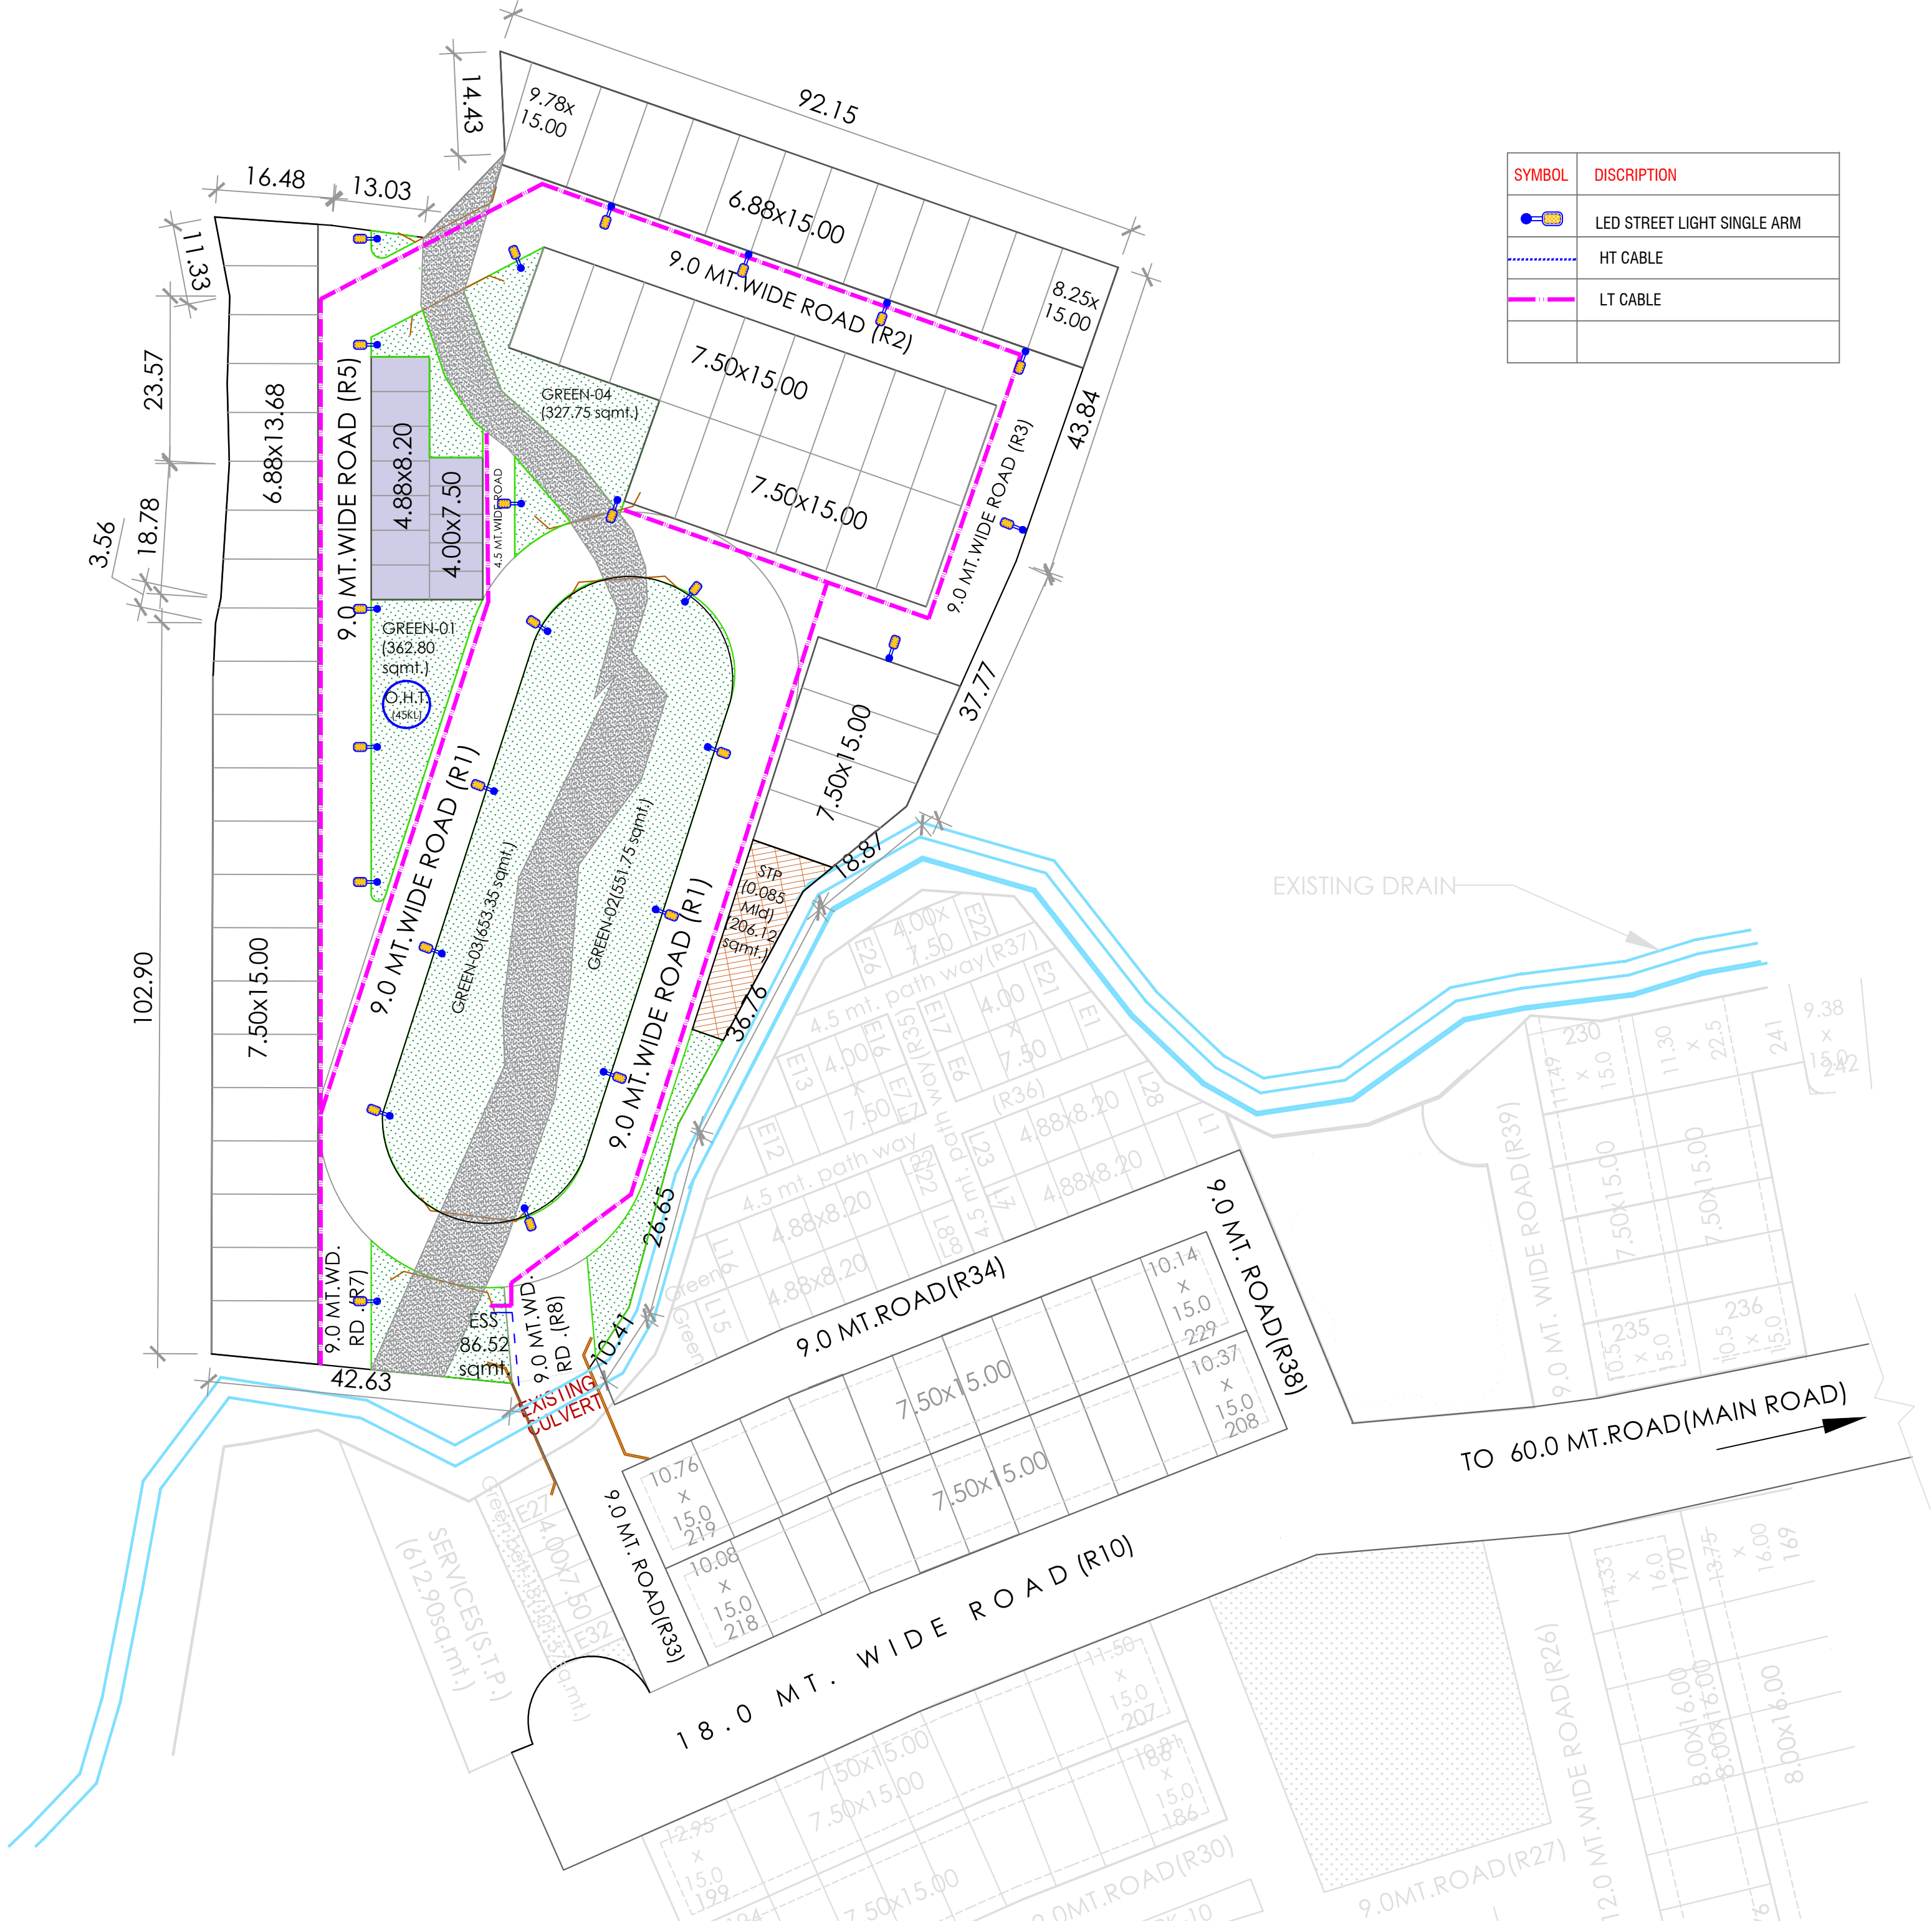

SYMBOL	DISCRIPTION
	LED STREET LIGHT SINGLE ARM
	HT CABLE
	LT CABLE

EXTERNAL ELECTRICAL LAYOUT

PROJECT TITLE:

PROPOSED HOUSING SCHEME **EIDECO EAST END** AT VILLAGE-CHANDRAWAL, VILLAGE- NATKUR, VILLAGE-NOOR NAGAR BHADARSA, VILLAGE- BIJNORE, LUCKNOW INDUSTRIAL DEVELOPMENT AUTHORITY AREA, LUCKNOW

SCALE:

1:1000

DRAWING NO.

services/05

DATE:

09.03.2021

LAND DETAIL:

KHASRA NOS.:
VILLAGE NOOR NAGAR BHADARSA- 41,42,43,51, & 52

TITLE:

LAYOUT PLAN

ARCHITECT:

Ar. SANJAY KR. GUPTA
108, CORPORATE CHAMBER-I,
VIBHUTI KHAND, GOMTI NAGAR,
LUCKNOW
ph. no.- 0522-4065958, 09415114589

DEVELOPER: