
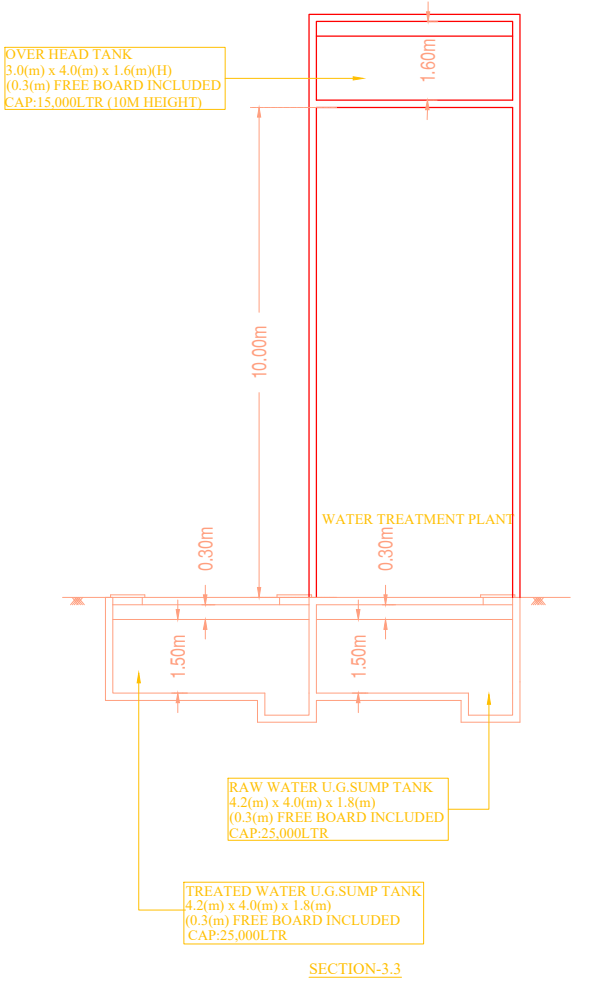


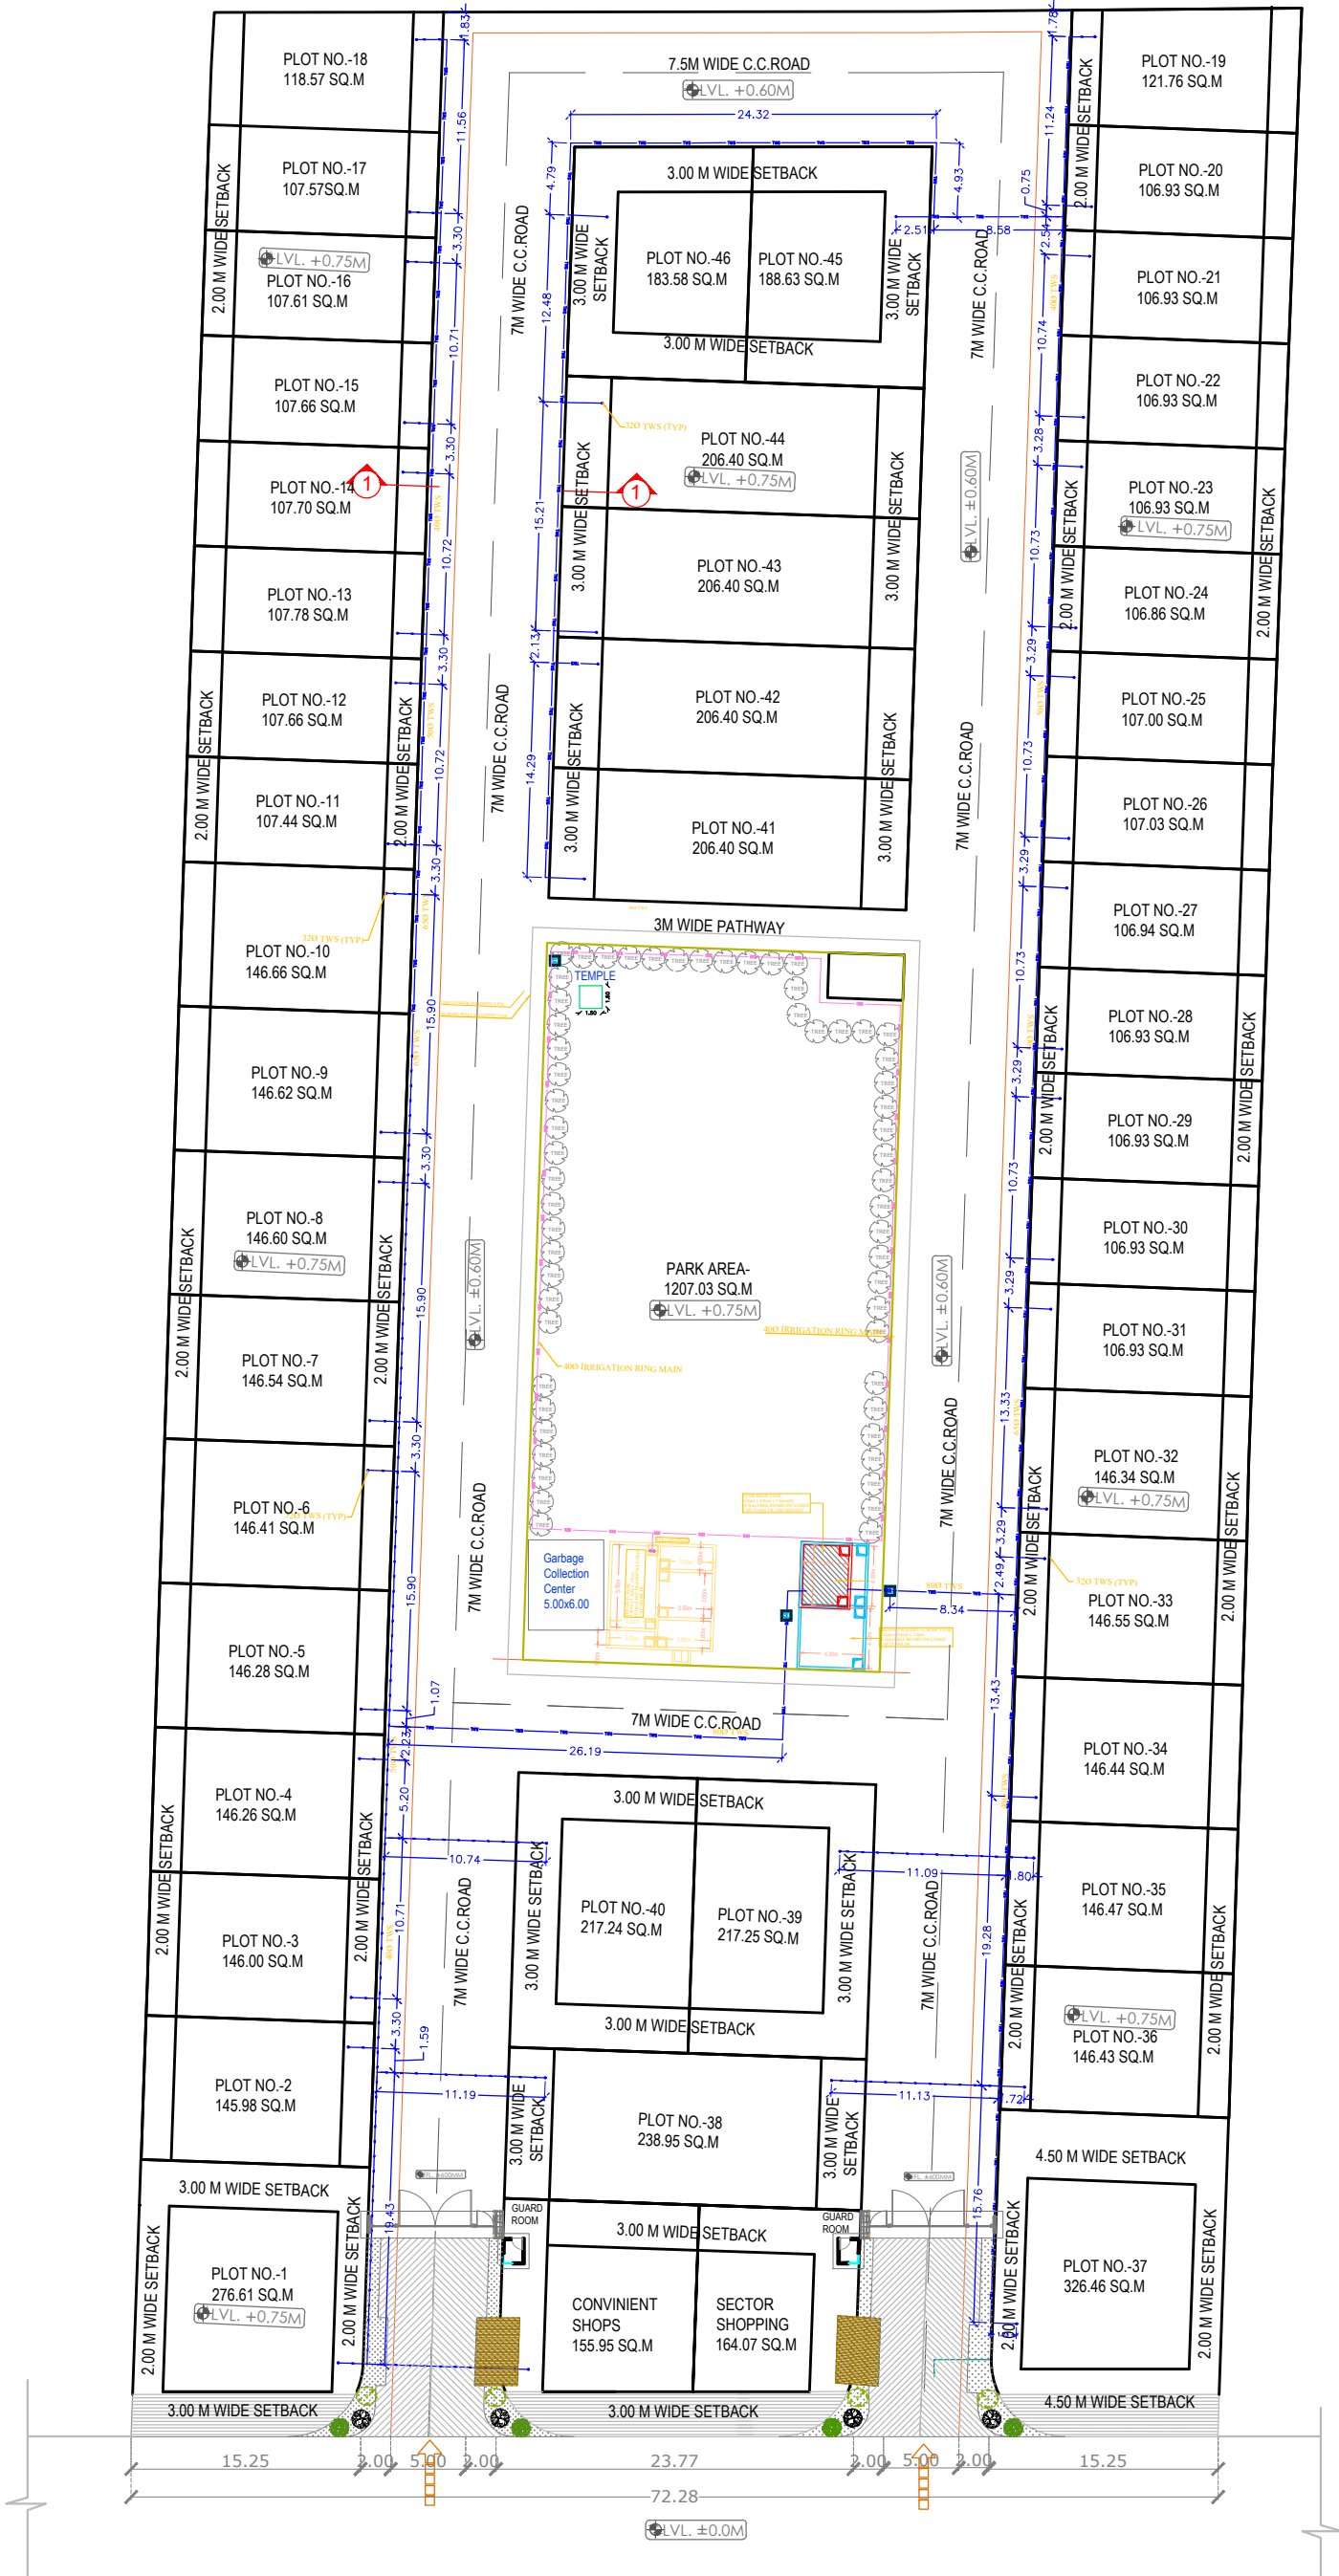

LEGEND		
1.	IL	INVERT LEVEL
2.	GL	GROUND LEVEL
3.		450 X 450MM VALVE CHAMBER
4.	HT HT	HIGH TENSION WIRE
5.	LT LT	LOW TENSION WIRE
6.		TELEPHONE CABLE
7.	SWG	150Ø ECODRAIN PIPE
8.	TWS	TREATED WATER SUPPLY PIPE LINE
9.		1200Ø DIA MANHOLE CHAMBER
10.		600X700MM ELECTRIC CHAMBER
11.		RAIN-WATER SOAK PIT
12.		STREET LIGHT
13.		RAIN WATER DRAIN

ARCHITECTURE CONSULTANT	
Drawn By	SONAL GUPTA
Checked By	AR. ANKUR CHHABRA / AR. PREETI BHATNAGAR
Drawing Status	IN PROCESS

PROJECT TITLE
GROUP HOUSING

CLIENT NAME MR.	DWG. REFERENCE SS-105	DRAWING NUMBER 13	REV ORIENTATION
DRAWING TITLE SITE PLAN WATER SERVICE LAYOUT			
DATE 26.07.2021	SCALE 1:100	UNIT MILLIMETERS	STATUS IN PROCESS