


LEGEND:- (sanitary)

S.NO.	SYMBOL	DESCRIPTION
1.	(R)	110 OD uPVC RAIN WATER PIPE
2.	(S)	110 OD uPVC SOIL AND VENT PIPE
3.	(W)	110 OD uPVC WASTE AND VENT PIPE
4.		WASHING MACHINE LOCATION

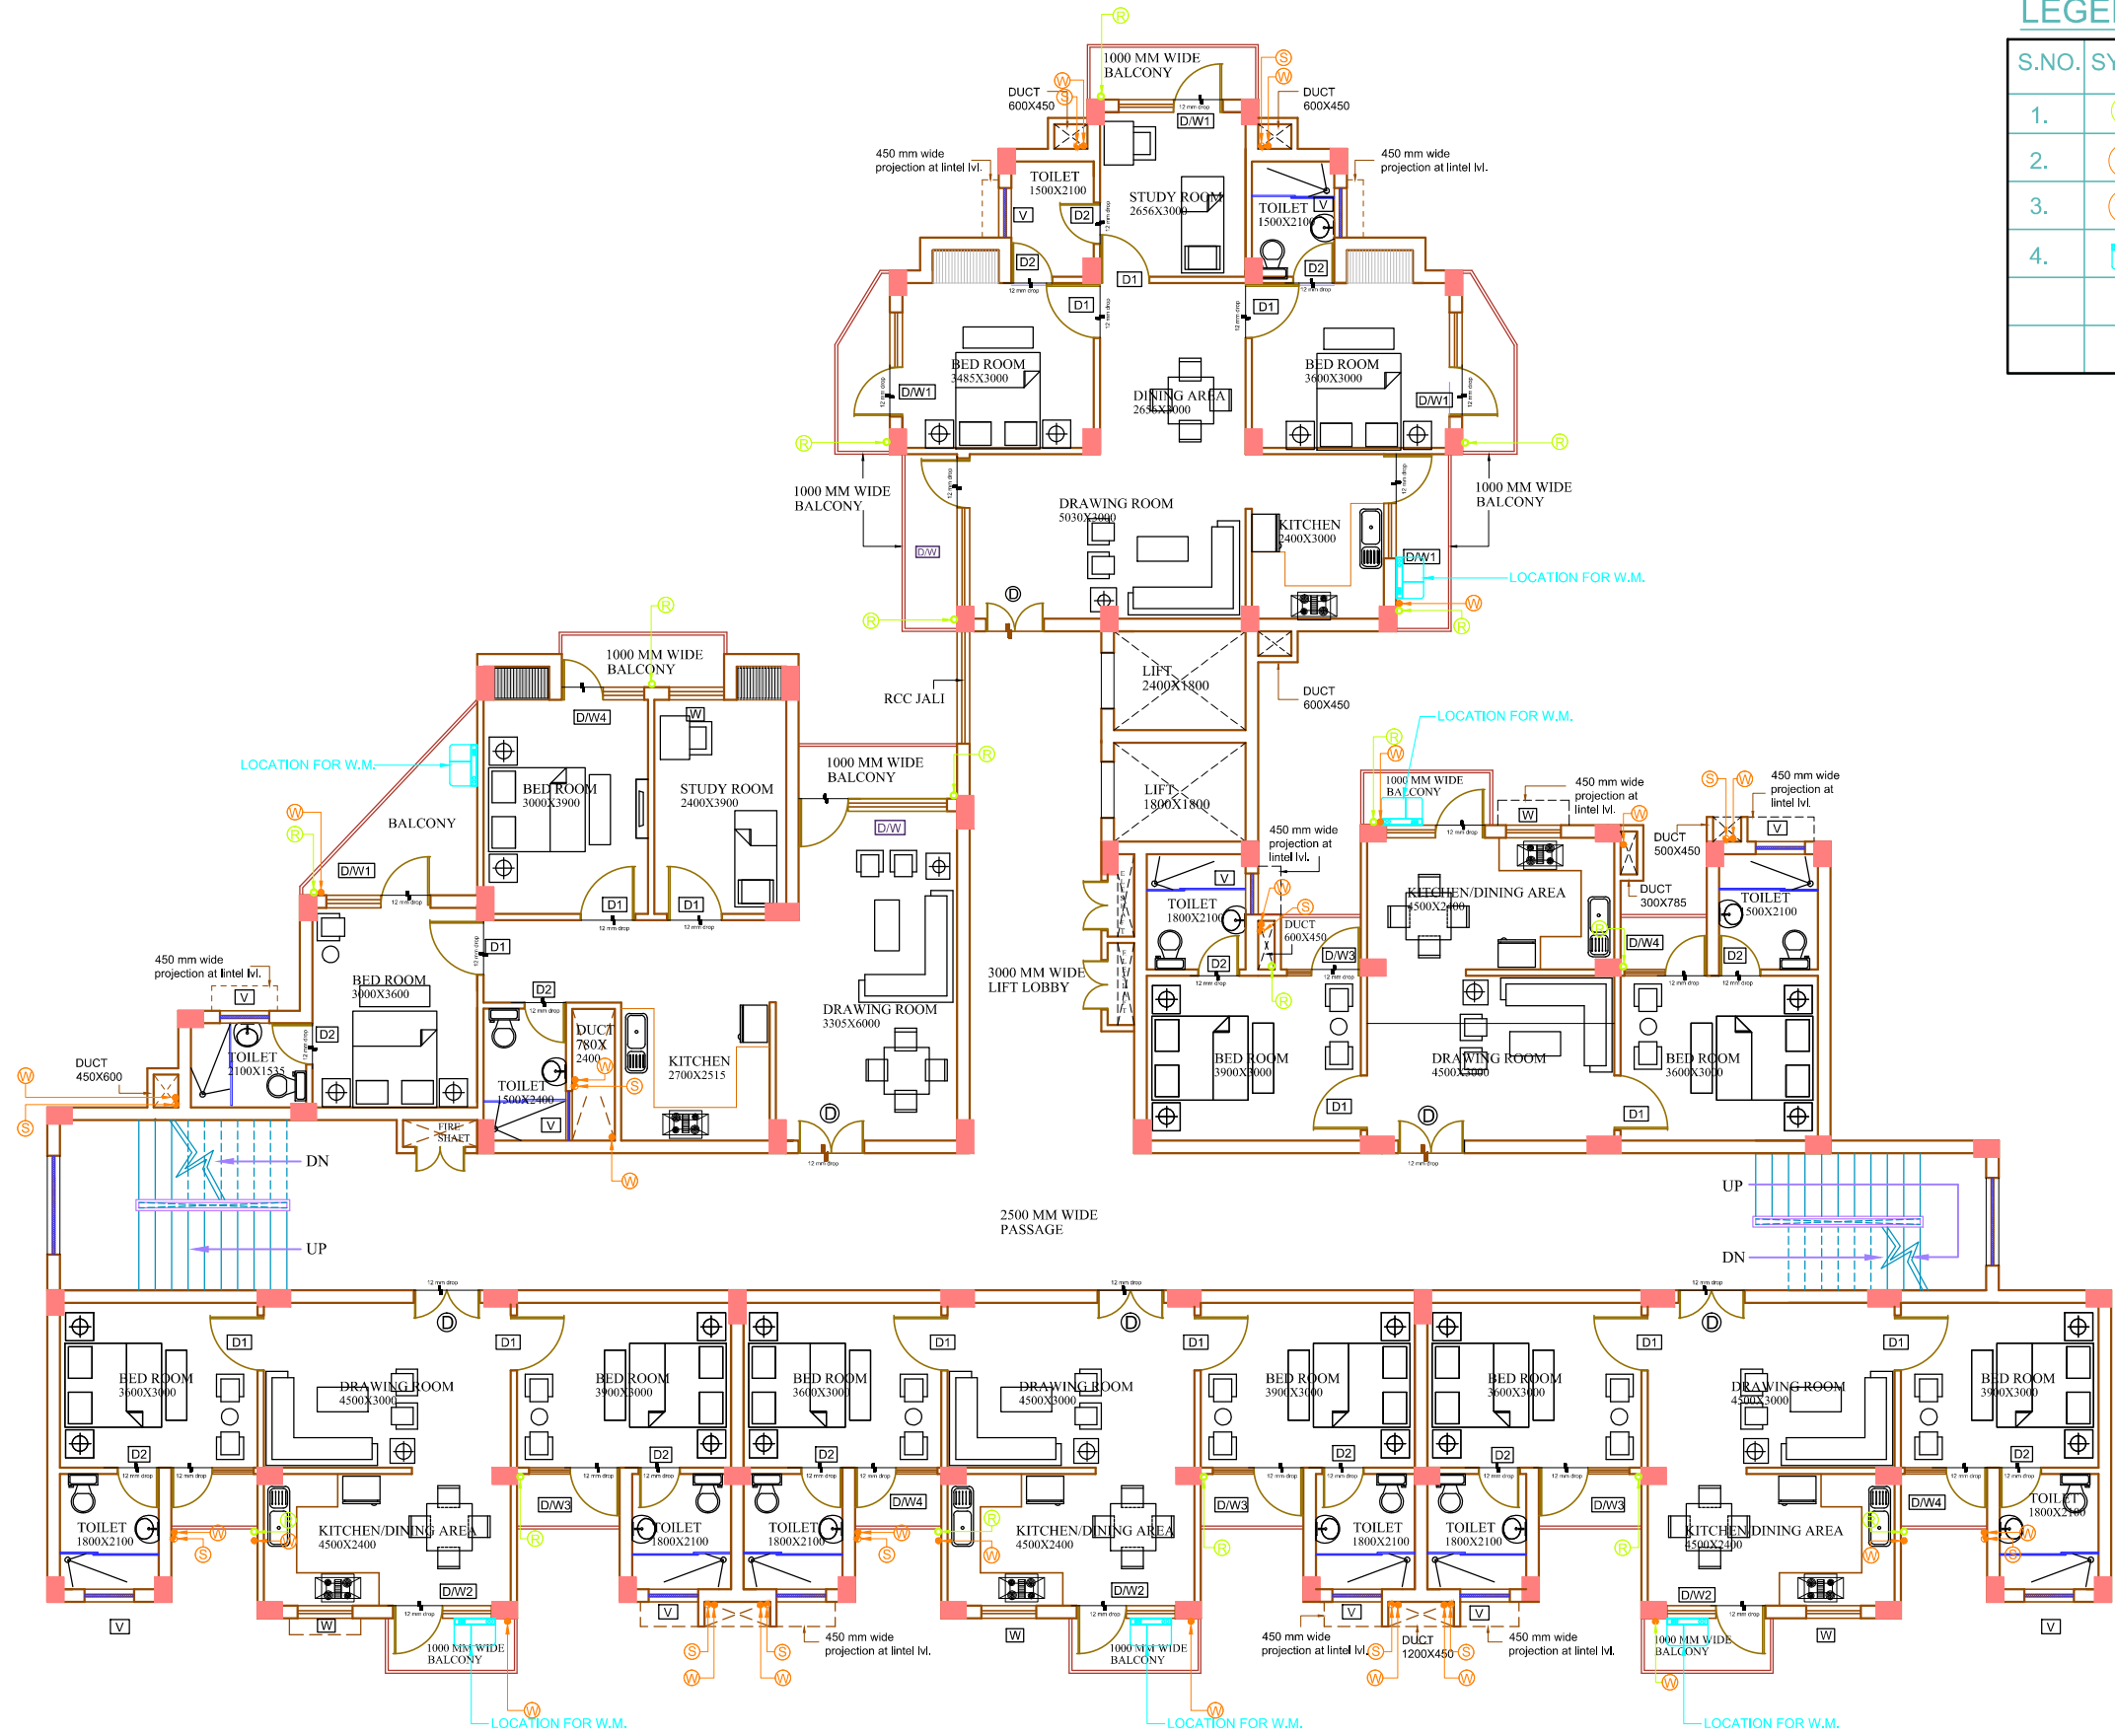

PROJECT: PROPOSED GROUP HOUSING FOR LUCKNOW DEVELOPMENT AUTHORITY AT SHAHEED PATH.	CLIENT :- LUCKNOW DEVELOPMENT AUTHORITY	AREA STATEMENT:- 			ARCHITECT :- SHUBHENDRA BAJPAI		ARCHITECTURAL CONSULTANTS :- ARCH DOT CREATION (LUCKNOW OFFICE):- 4/404,VIVEK KHAND, GOMTI NAGAR LUCKNOW. Ph.-4071522,9415021936. e-mail add.-adcreation1@yahoo.co.in	
	BUILDING :- TYPICAL FLOOR PLAN 'BLOCK -A'		DATE :- MARCH- 2015	DRG. NO. :- GH/LKO/SEP-01	SCALE :- N.T.S.	NORTH :-	(GHAZIABAD OFFICE):- 2160-2161 Romano Mahagun Mascot,Crossing Republic ,Ghazyabad. Ph. : 09871599836 e-mail add.-adcreation2@yahoo.co.in	
DRG. TITLE:- PIPE & WASHING MACHINE LOCATION PLAN								