


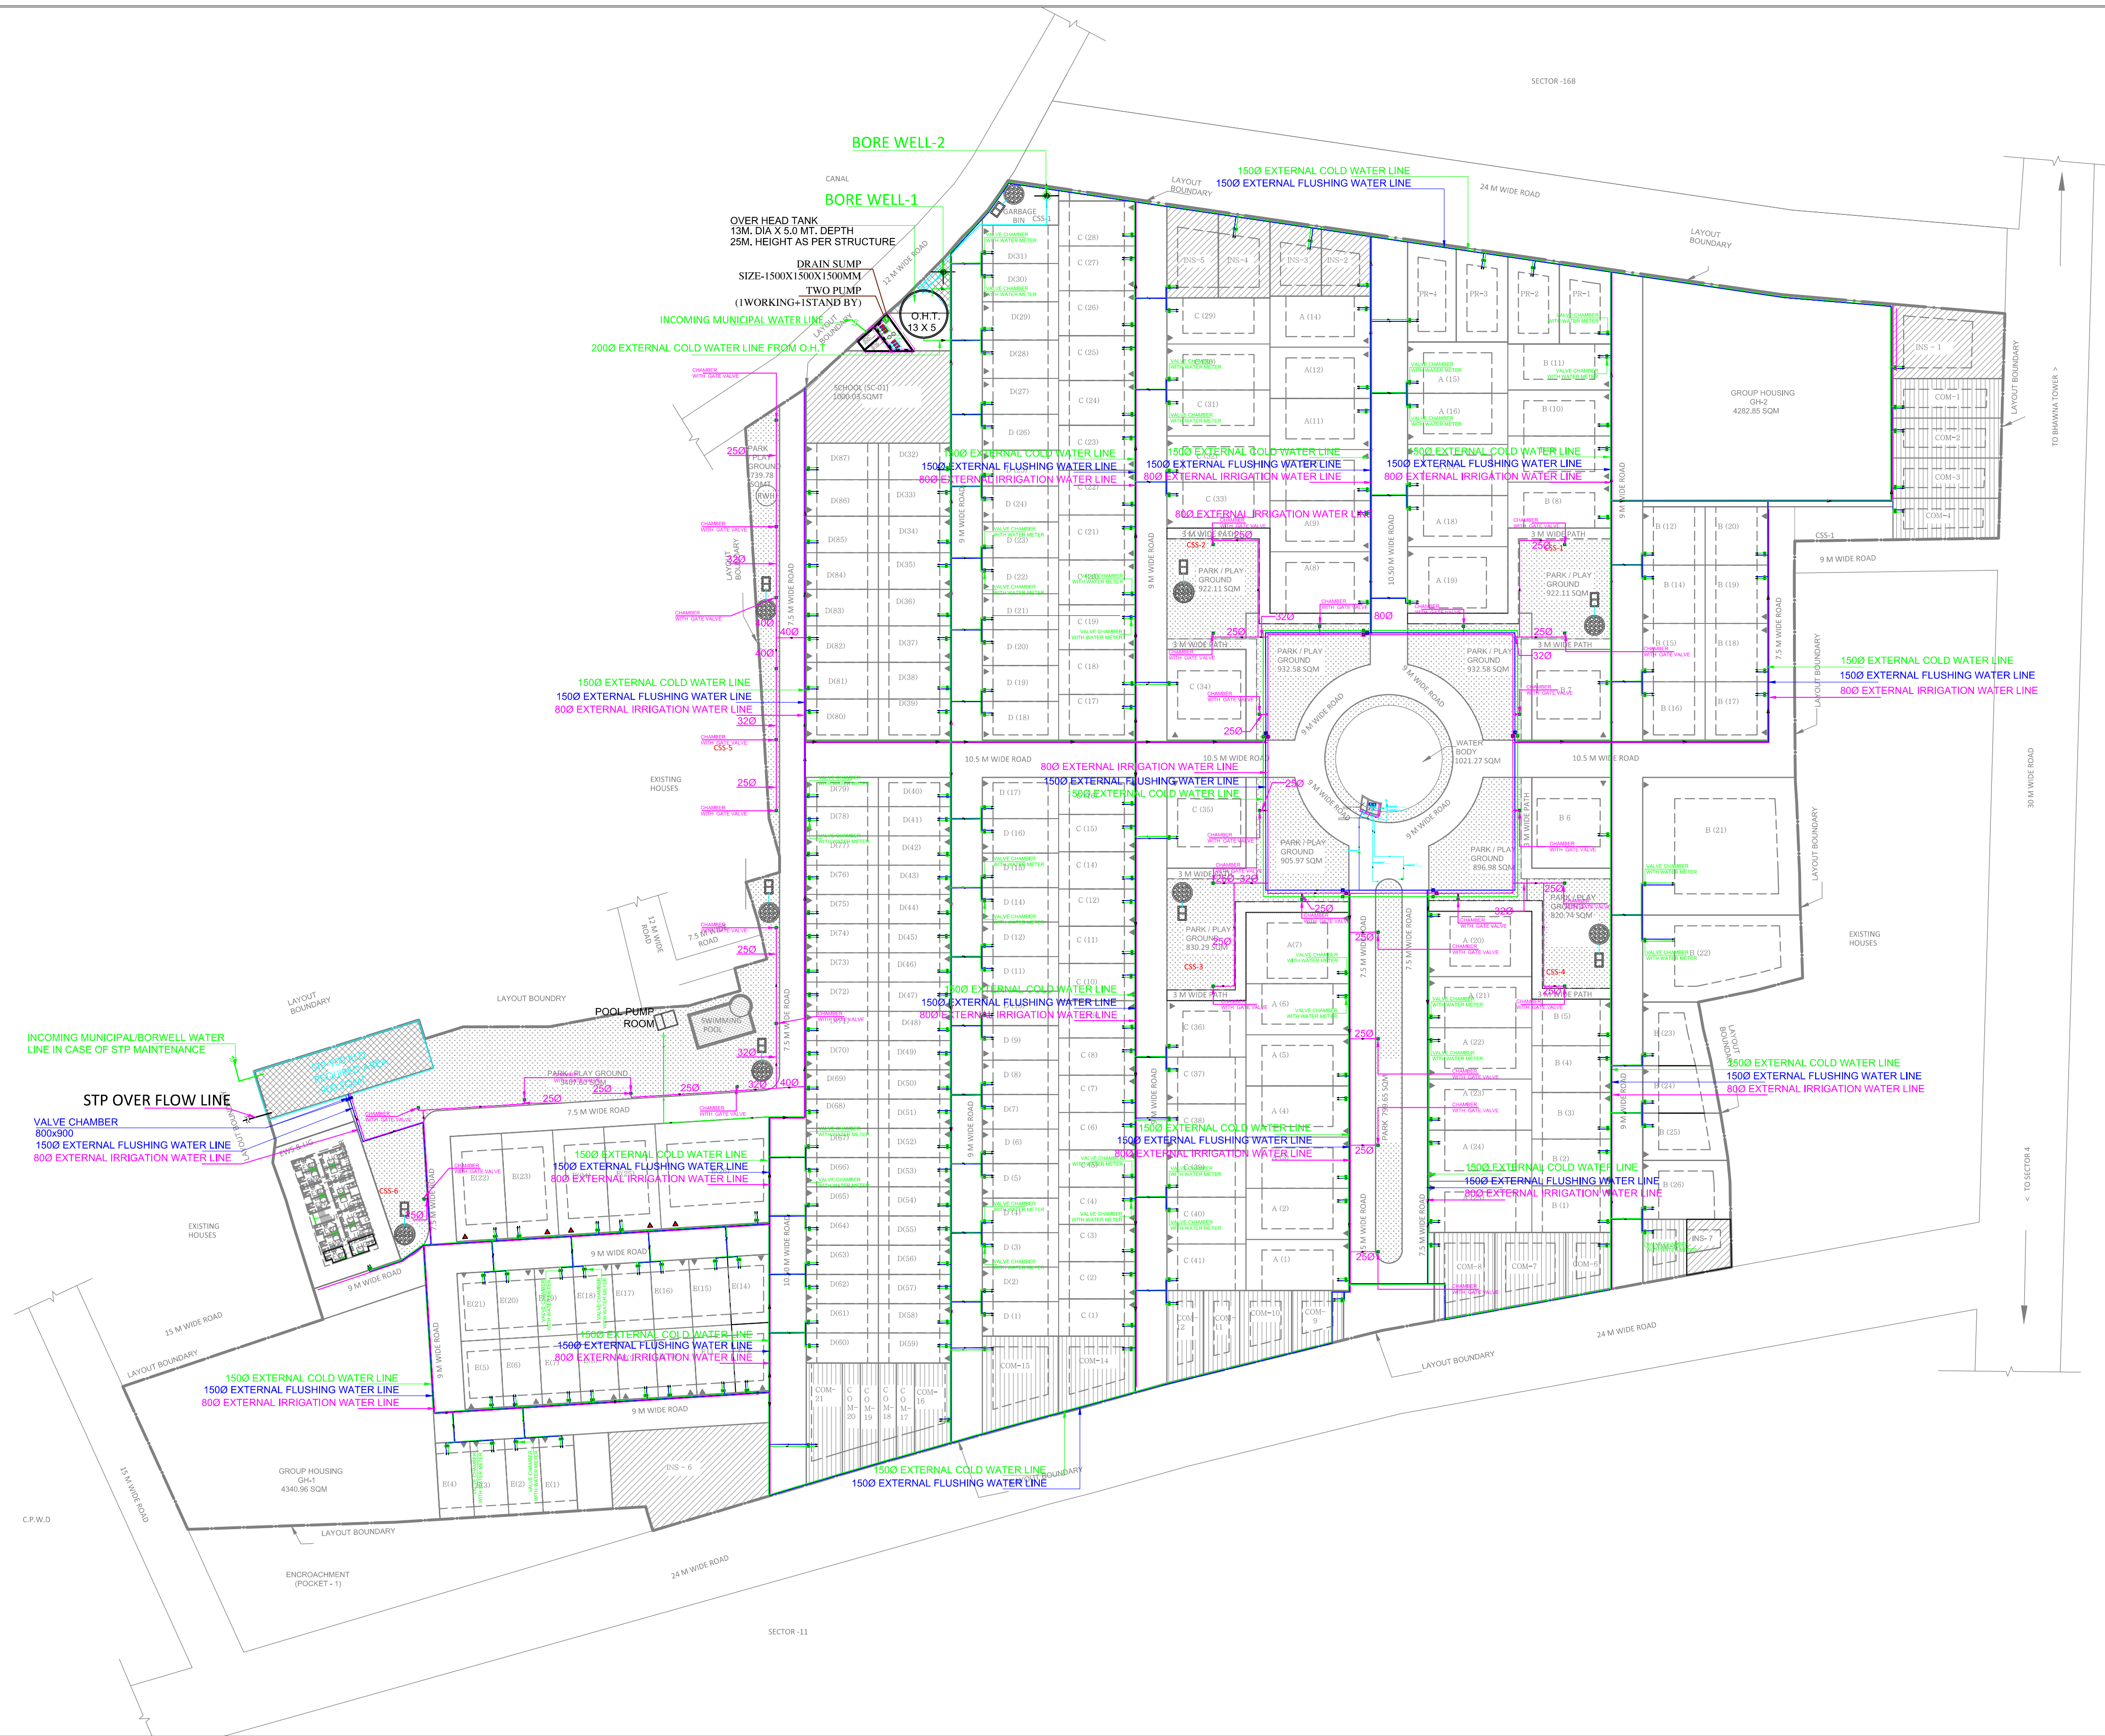

PLUMBING LEGENDS :-

| SYMBOL | DESCRIPTION                     |
|--------|---------------------------------|
|        | EXTERNAL COLD WATER LINE        |
|        | EXTERNAL FLUSHING WATER LINE    |
|        | EXTERNAL GARDEN IRRIGATION LINE |

MEP CONSULTANT :-



**SK.INNOVATION  
ENGINEERING PVT.LTD.**

Address:-C-15 Ground Floor, Jaipuria  
Apartment, Seemant Vihar,  
Kaushambi(Ghaziabad)  
MOB.NO.:-9718536912,9650901083,9650030116.  
email:- info@skiepl.com  
web:-www.skiepl.com

ARCHITECTS :-

Nexusplus consultant  
B-116, Second Floor,  
Sector-50, Noida.

|                                                                  |                      |                         |                    |
|------------------------------------------------------------------|----------------------|-------------------------|--------------------|
| CLIENT :<br>BHARAT NAGAR HOUSING<br>SHOBHIK GOYAL                | DRAWN BY<br>R.K.     | ENGINEER<br>S.S.        | CHECKED BY<br>R.R. |
| PROJECT :-<br>ANTHEM, SEC-15 POCKET -A,<br>SIKANDRA YOJNA , AGRA | DRAWING NO.          |                         |                    |
| COMPANY :<br>BHARAT NAGAR HOUSING                                | SK/BNH/SP/PL-02      |                         |                    |
| DRAWING TITLE :-<br>PLUMBINT LAYOUT<br>SITE PLAN                 | DATE:-<br>25/07/2017 | SCALE:-<br>A1 ,1 : 1000 |                    |

|                  |
|------------------|
| FOR REFERENCE    |
| FOR APPROVAL     |
| FOR ESTIMATION   |
| FOR TENDER       |
| FOR CONSTRUCTION |
| AS-BUILT         |