
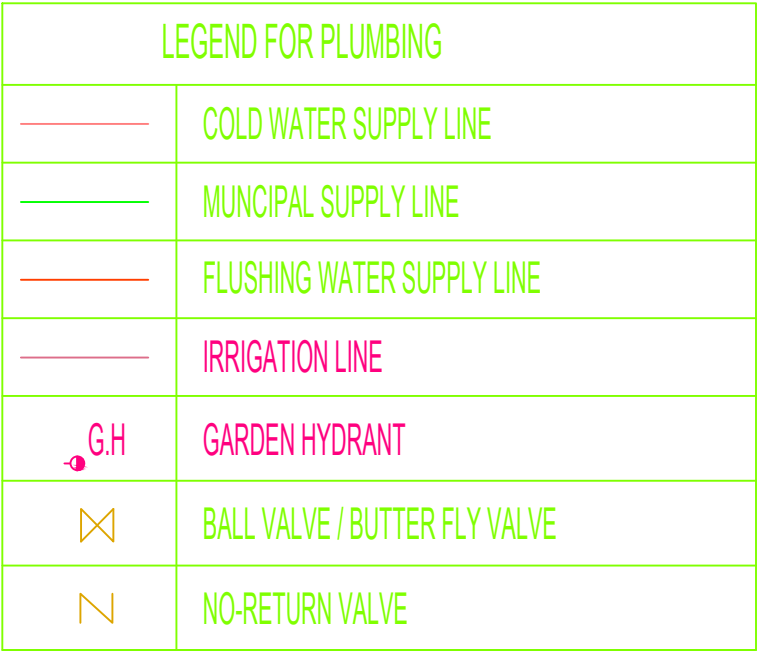
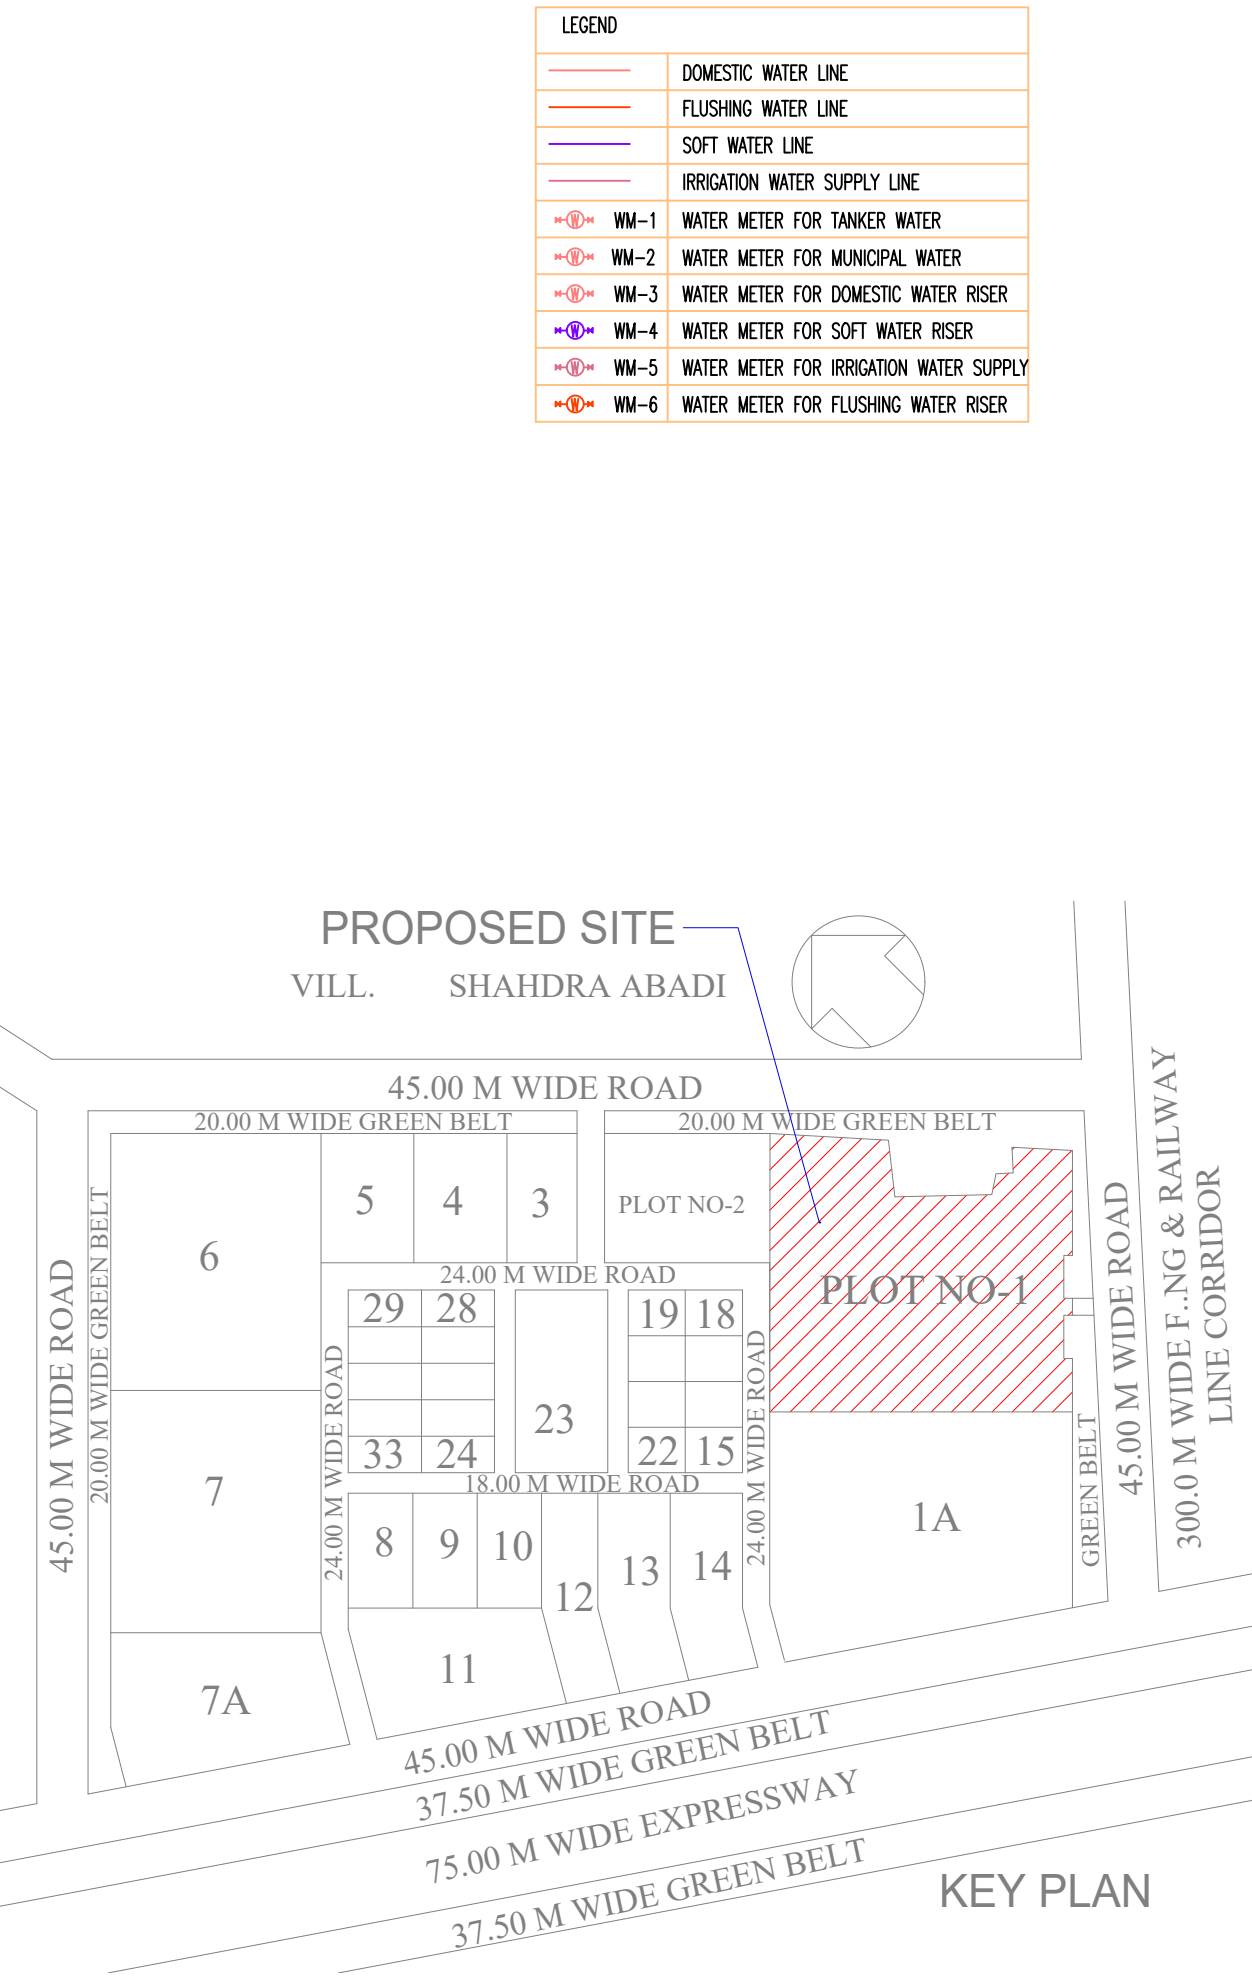


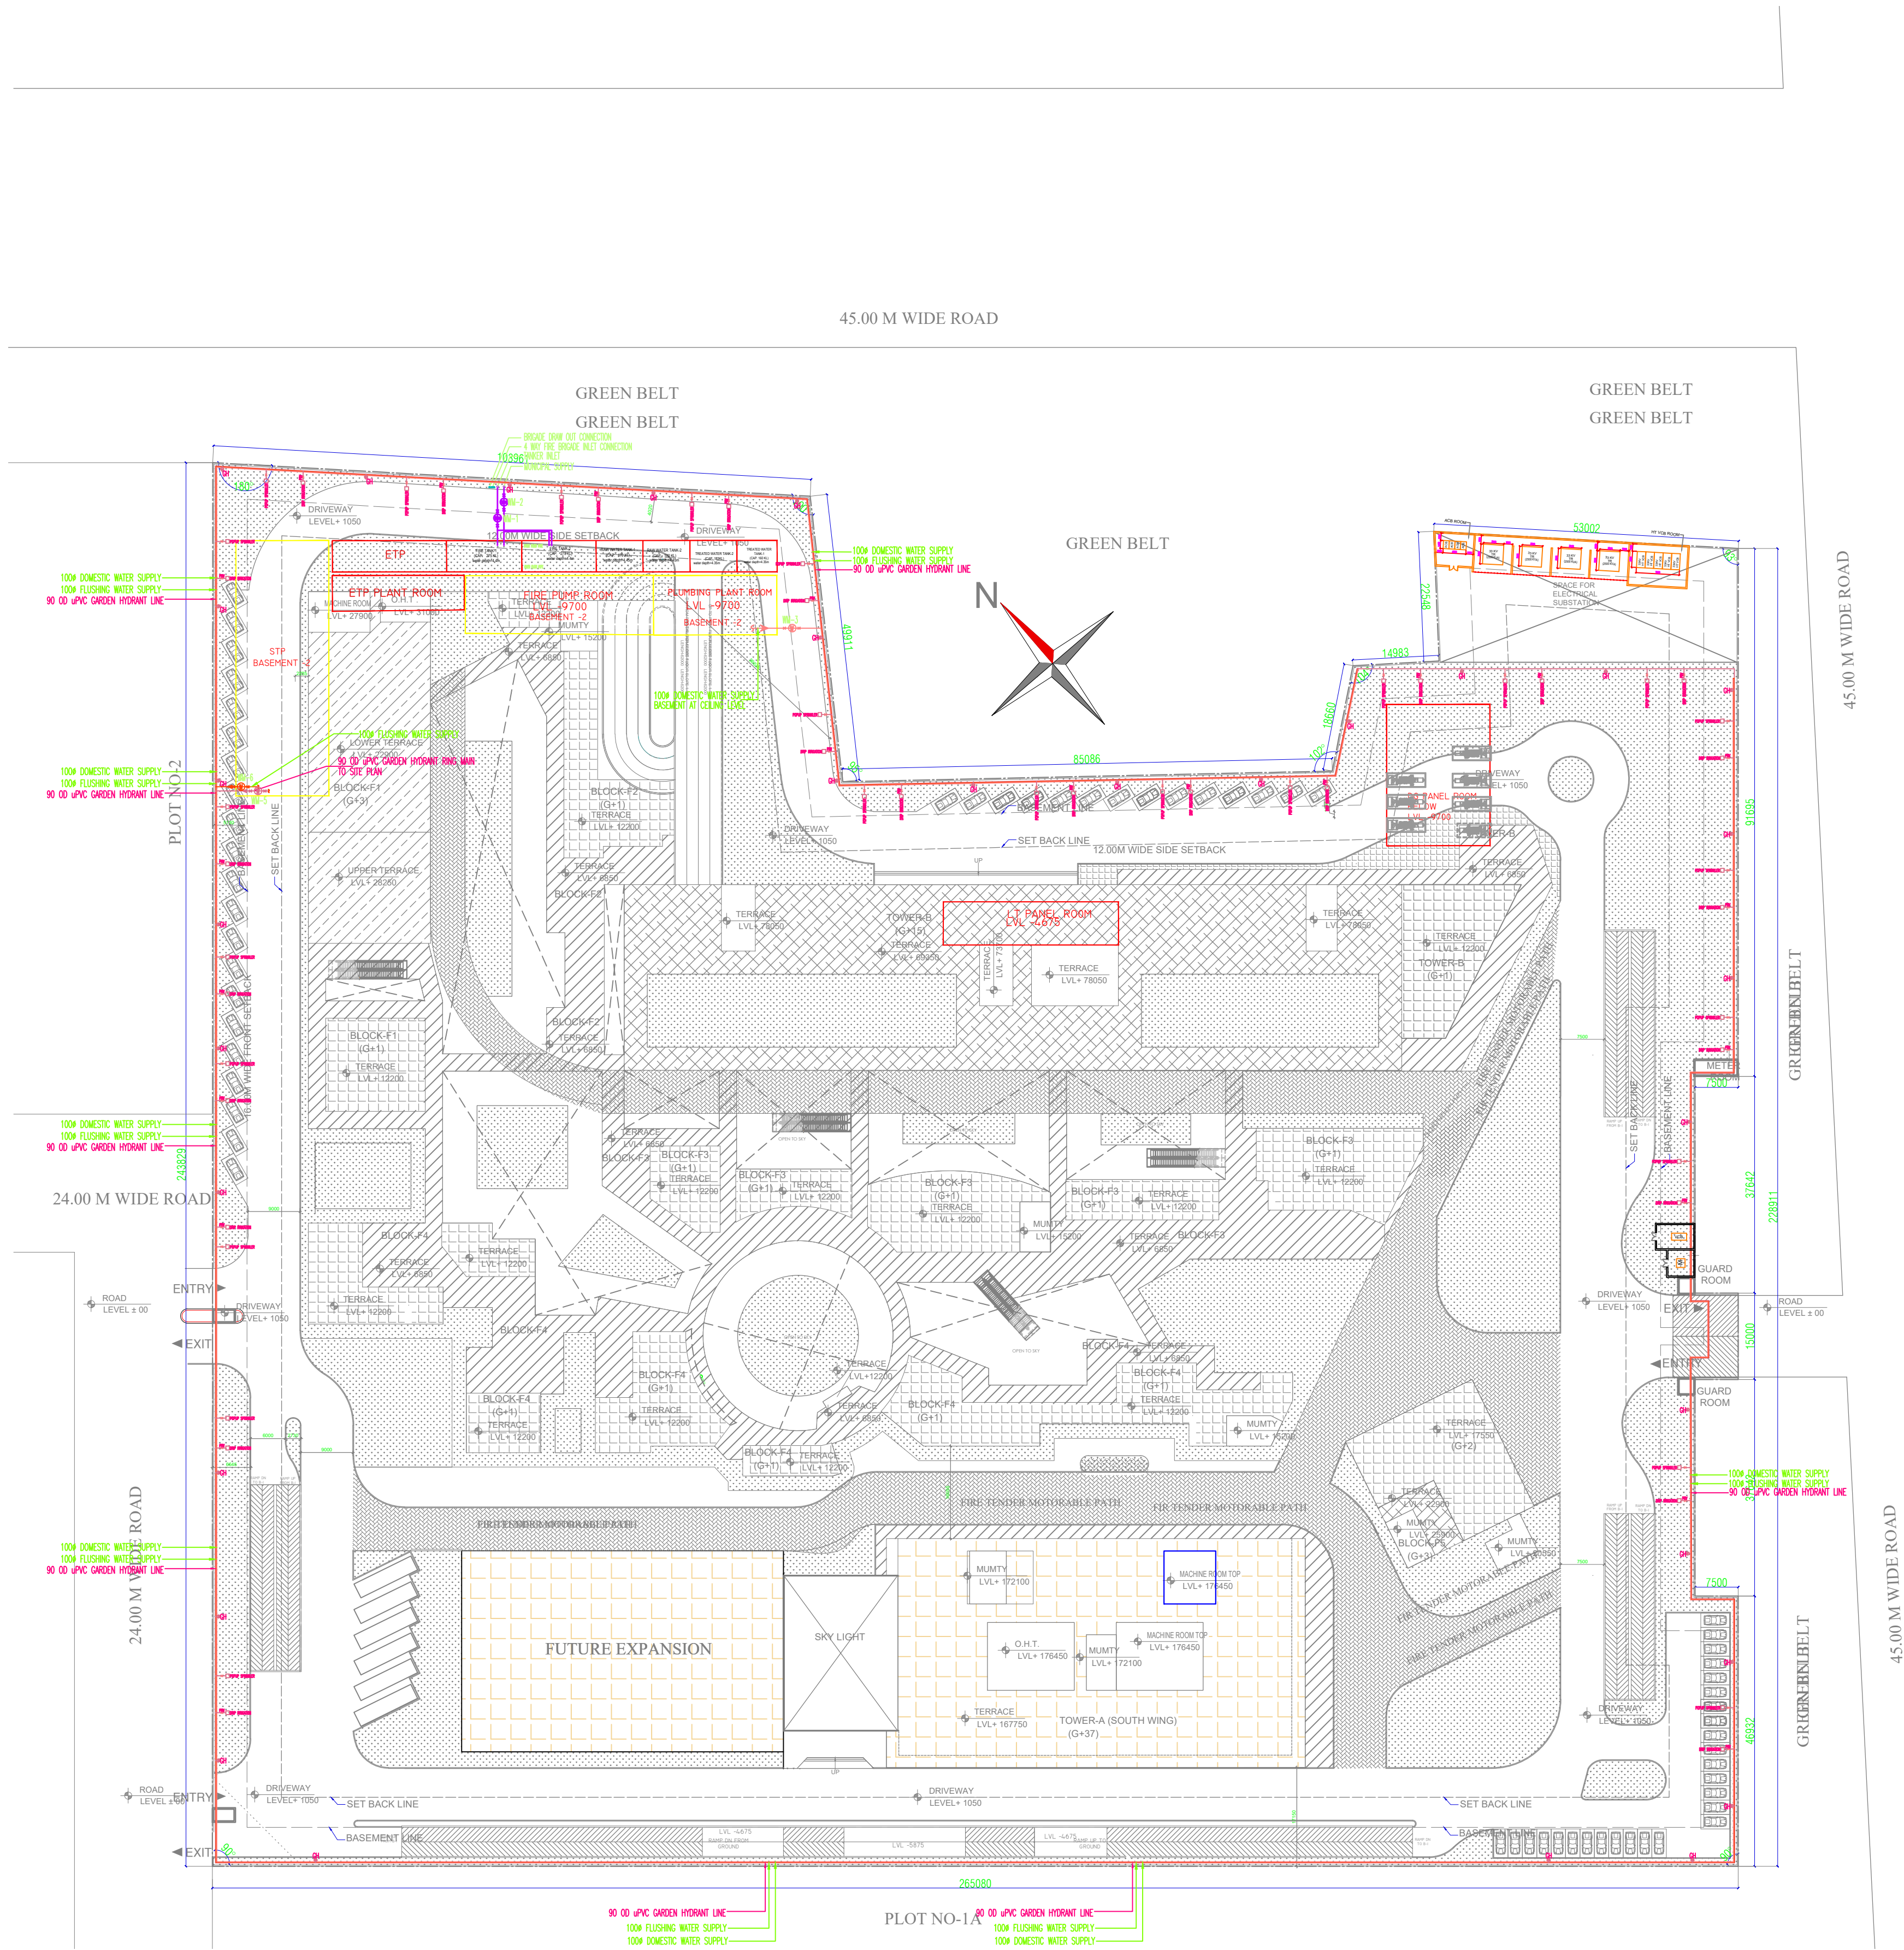

SUBMISSION

PROJECT:
PROPOSED INSTITUTIONAL BUILDING
ON PLOT -1 SECTOR - 142, NOIDA
FOR SS TECHNOPARK PRIVATE LIMITED

DRAWING TITLE :
SITE PLAN
WATER SUPPLY LAYOUT

ARCHITECT
ACPL Design Ltd.
NEW DELHI
INDIA

CLIENT

OWNER'S SIGN
ARCHITECT :
ACPL Design Ltd.
C-34, Sector 142, Noida
New Delhi 201305, India
P: +91 11 24647338
F: +91 11 24647339
E: contact@acplindia.com

ARCHITECT'S SIGN
150 9001:2008
NORTH
ACPL
Architecture
Management
Planning
P: +91 11 24647338
F: +91 11 24647339
E: contact@acplindia.com

SCALE
1:500

DEALT BY
CHECKED BY

DATE
DRG. No.
PL-04