
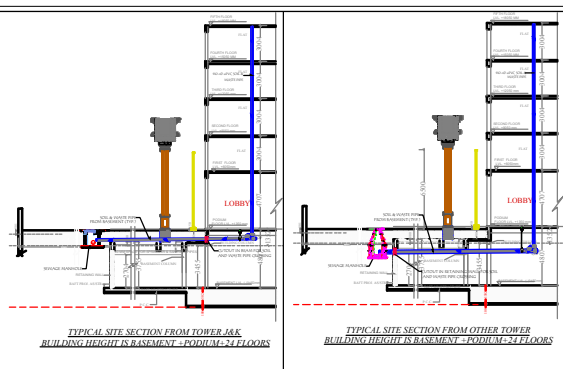


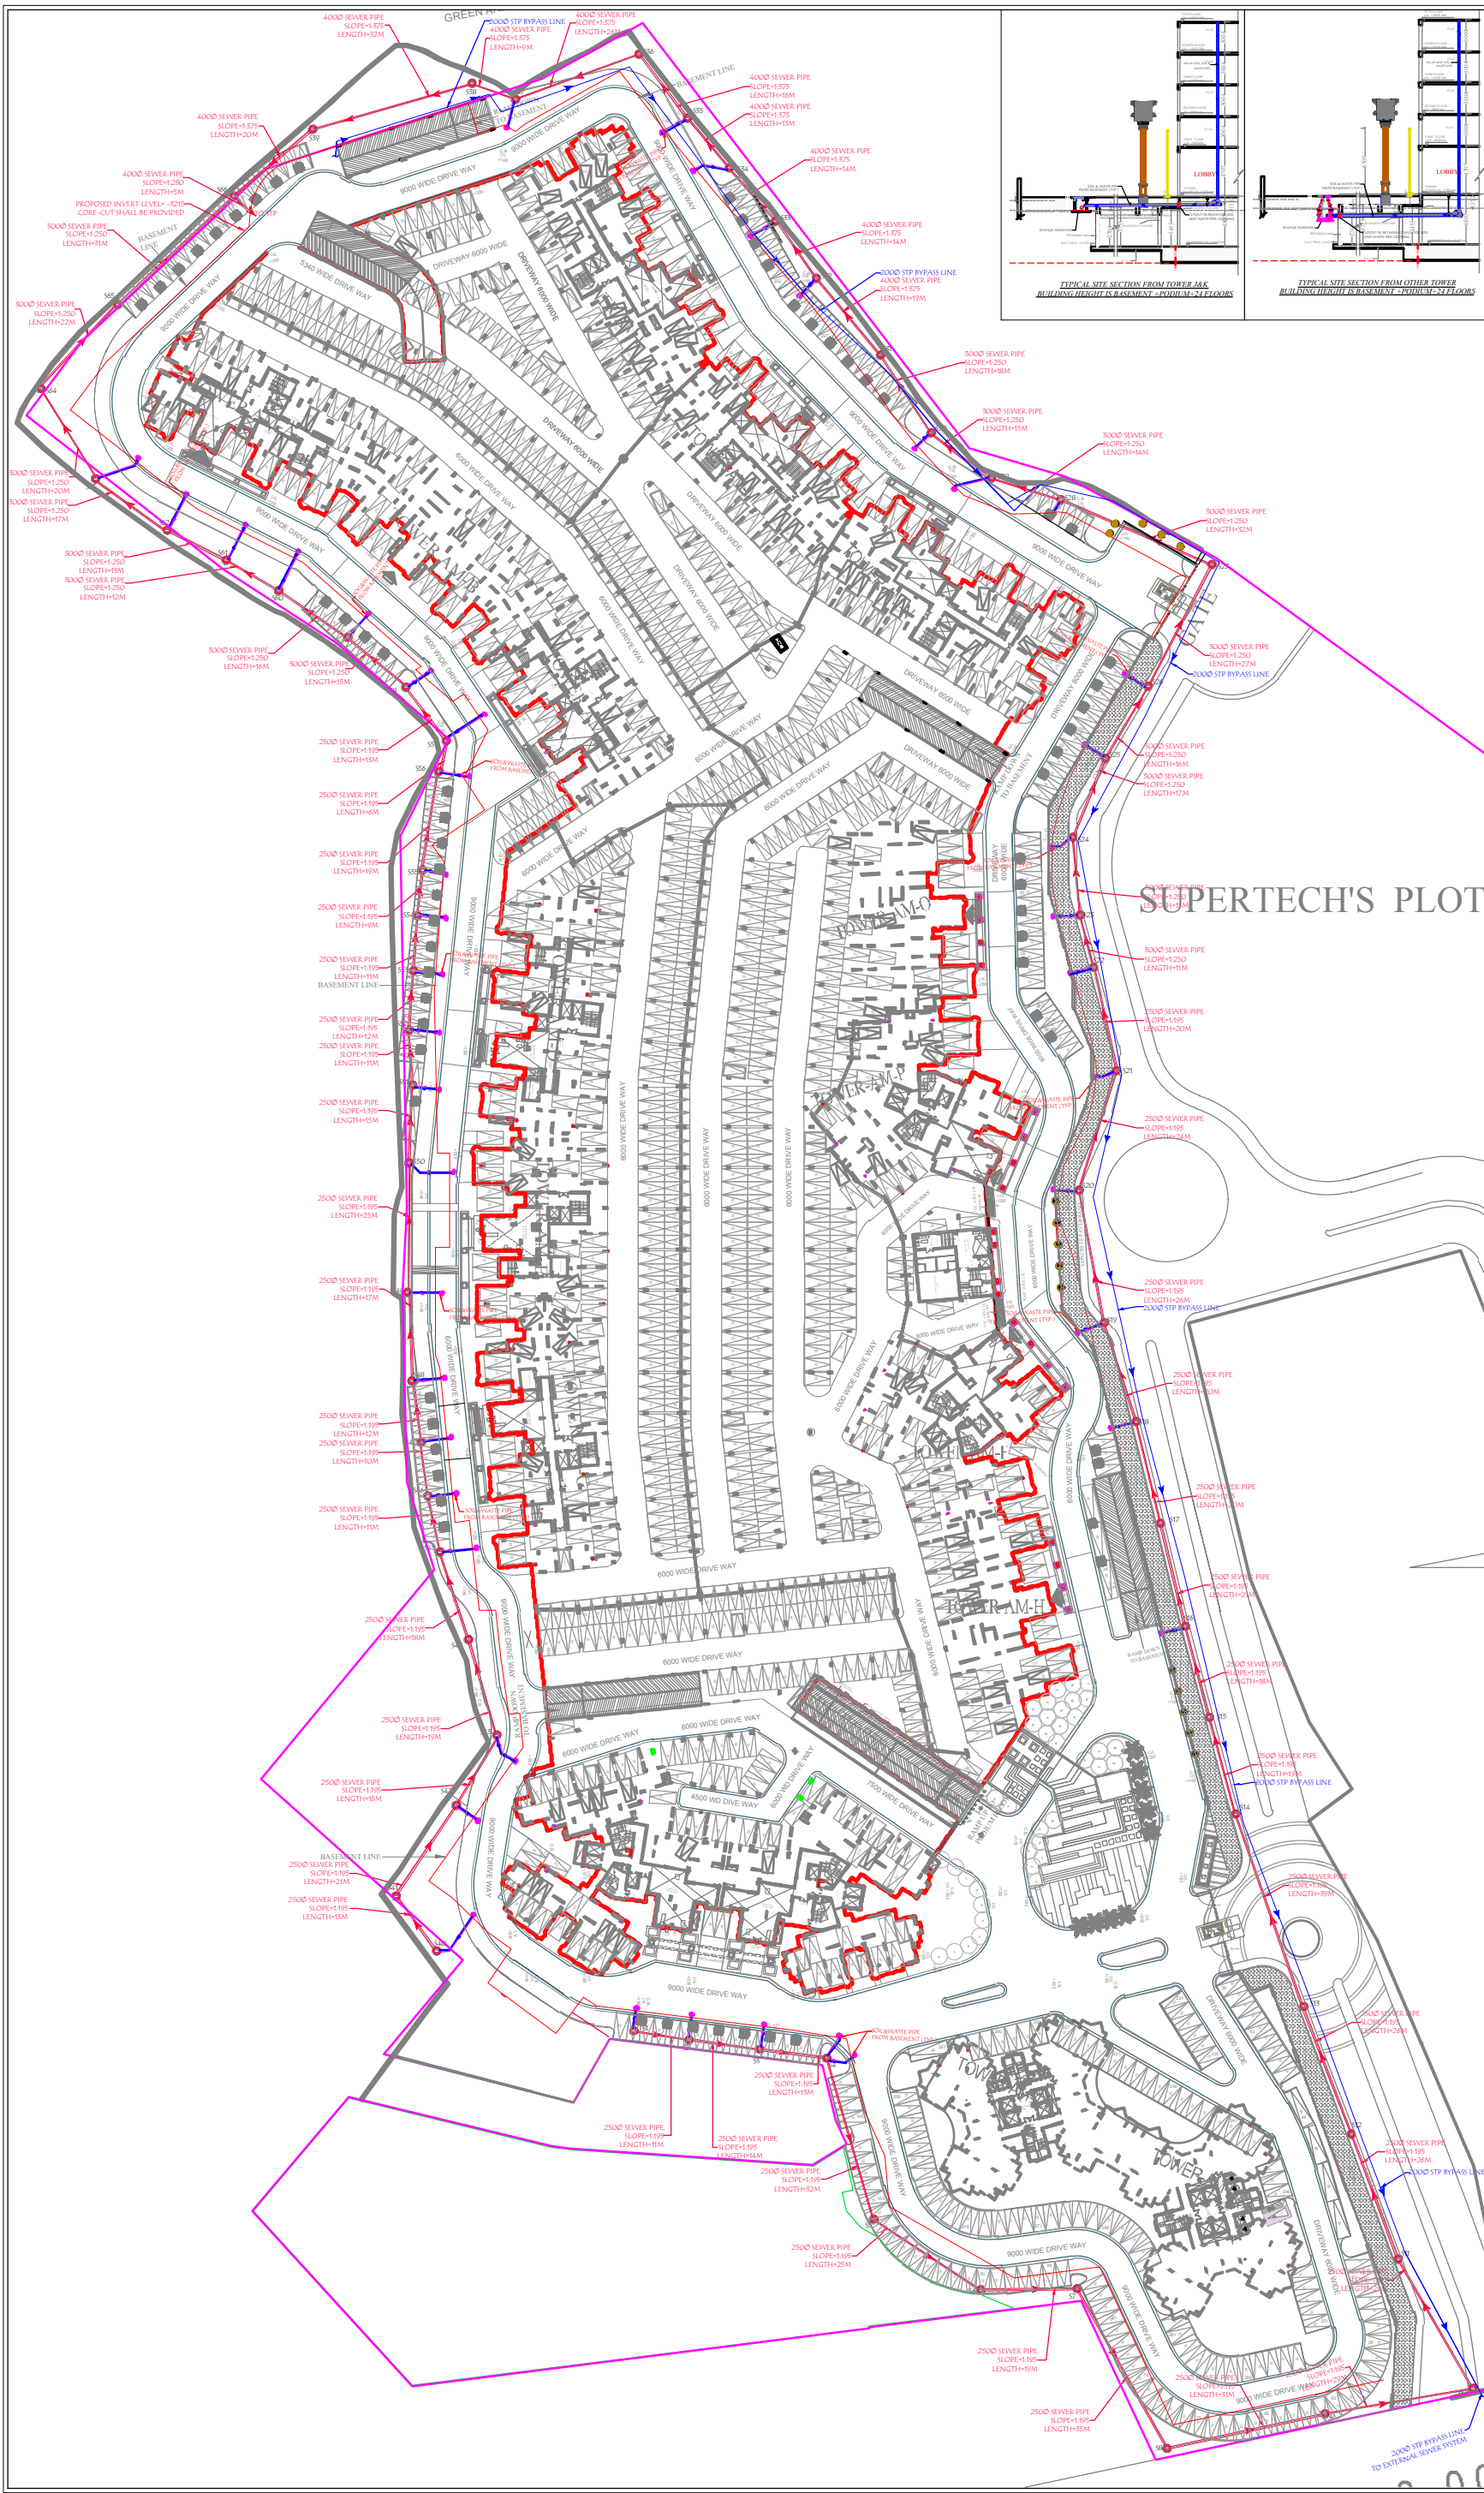

KEY PLAN

PLUMBING LEGEND		
SNO	DESCRIPTION	SYMBOL
1	SEWER PIPE	—
2	SEWER MANHOLE	⊙
3	GROUND LEVEL	GL
4	INVERT LEVEL	IL
5	CONNECTION LEVEL	CL
6	TRENCH	—

NOTE - REFER DRAWING NO-PC-AJ-AM-MISC-DTL-500 FOR TYPICAL DETAIL & INVERT LEVELS OF MANHOLE

REV. NO.	DATE	DESCRIPTION

PROJECT

"AMBROSIA"
PROPOSED GROUP HOUSING
SECTOR-118 NOIDA

BUILDING & PROMOTER

AJINARA INDIA LTD.

ARCHITECT

Space Designers International
Architects Pvt. Ltd.
E / 138B, VASUNDHARA, GHAZIABAD
PH: 0120-4120214, 4120215, 4120216, 4120217
E-MAIL: sdi@sdil.com, www.sdil.com

LANDSCAPE CONSULTANTS

S. BOSE LANDSCAPE CONSULTANTS
D-21, CENTRALIGHT PLACE
NEW DELHI - 110001
PH: 23418500

SERVICES CONSULTANTS

Proion Consultants
Building Services - MEP Consulting
Pocket 1, Plot No 108, Isola,
New Delhi 110 025, India.
Phone: 011.4659.1188, www.proion.net

DRAWING TITLE

**SEWER SITE PLAN
PLUMBING LAYOUT**

DRWN	Valued	DATE	01-10-2019	☐ CONCEPTUAL DRAWING
CHKD	Rep1	SCALE	1:400	☐ WORKING DRAWING
APPD	GL	SHEET	A0	☐ TENDER DRAWING
DRG. No.	PC-AJ-AM-SITE-BB-100	REV. No		☐ USED FOR CONSTRUCTION