



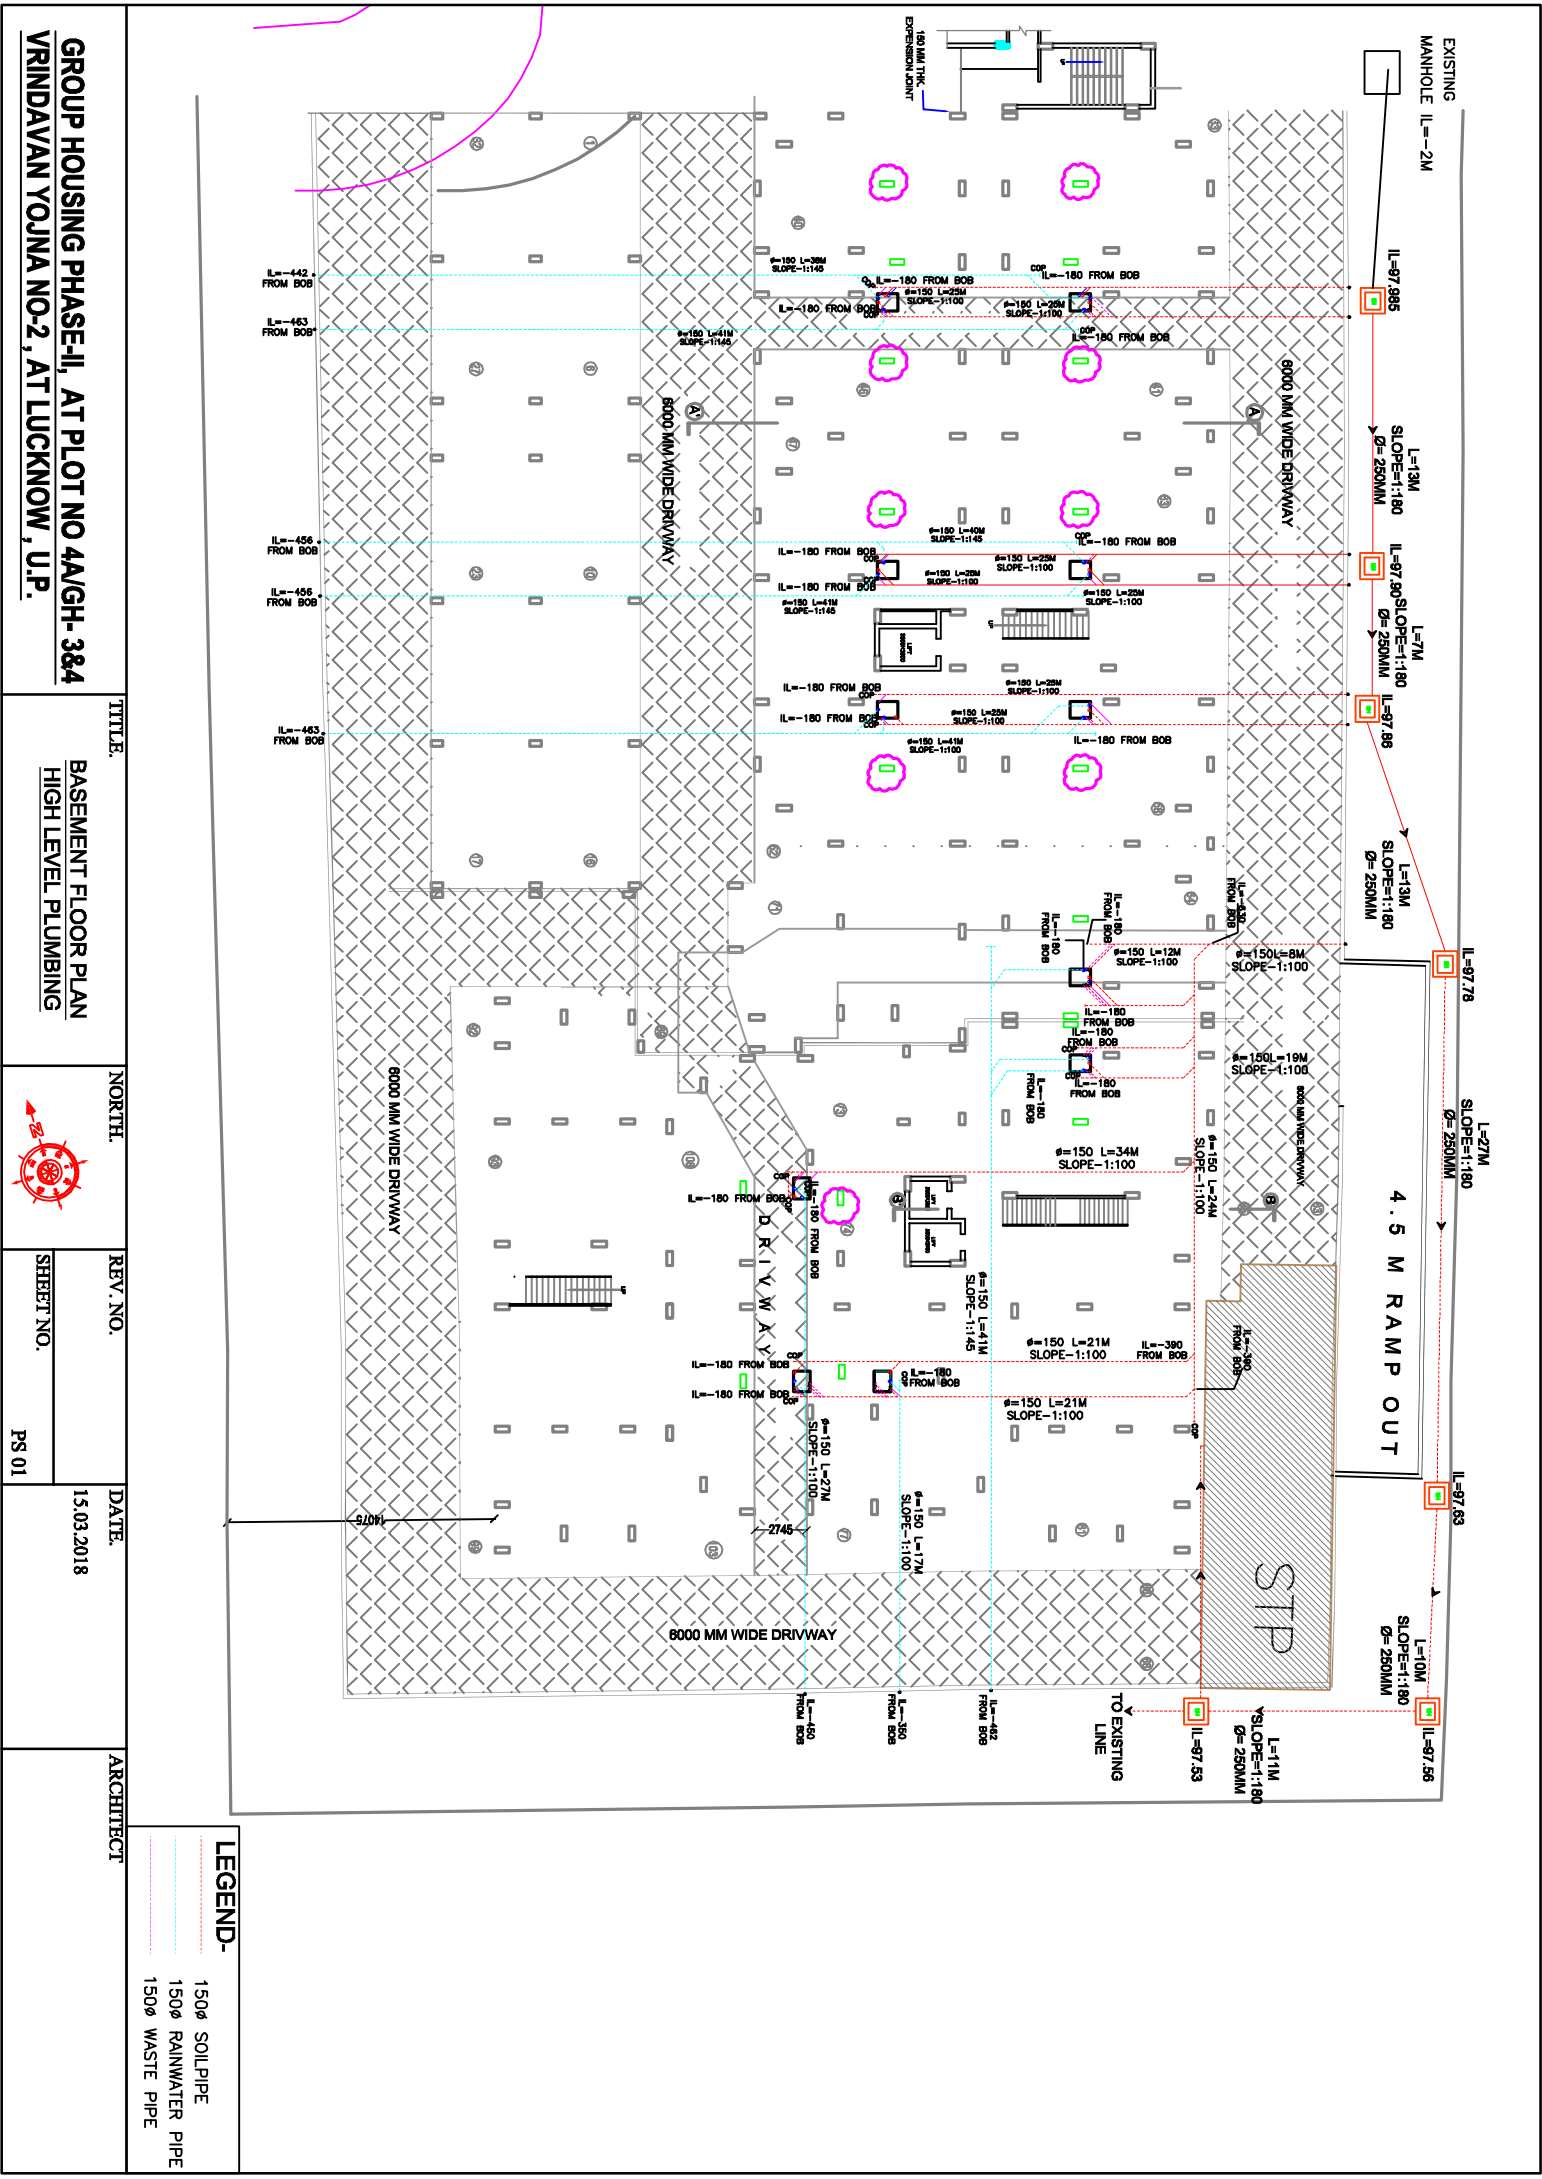

GROUP HOUSING PHASE-II, AT PLOT NO 4A/GH-3&4
VRINDAVAN YOJNA NO-2, AT LUCKNOW, U.P.

TITLE
BASEMENT FLOOR PLAN
HIGH LEVEL PLUMBING

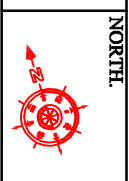

REV. NO.
SHEET NO.
PS 01

DATE
15.03.2018

ARCHITECT

LEGEND-
1500 SOIL PIPE
1500 RAINWATER PIPE
1500 WASTE PIPE