
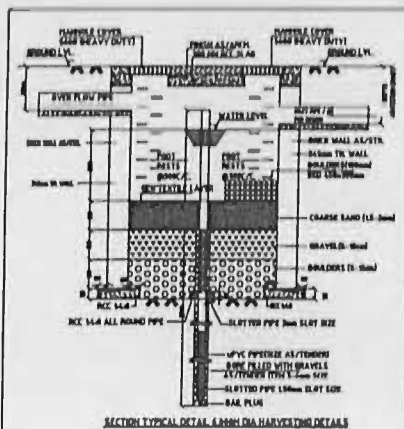


NO.	DESCRIPTION	REMARKS
1.	PROPOSED WLL	ALL GRAY CHANNELS WILL BE DRIVEN WITH BLADE WLL TO 100mm STAYERS SHIP TO WLL, 100mm ALL LEVEL POSITION FROM 100mm
2.	GRAY CHANNELS WITH WLL	

ALL GRAY CHANNELS WILL BE DRIVEN WITH
BLADE WLL TO 100mm
STAYERS SHIP TO WLL, 100mm
ALL LEVEL POSITION FROM 100mm

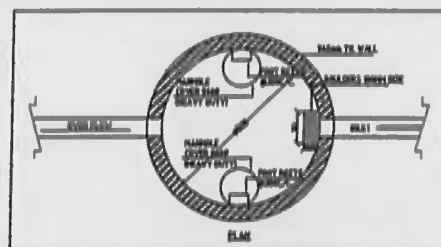

The drawing is for reference only and is not to be used for any other purpose without the written permission of SPACE COMBINE.

rev. no.	date	revision

prints. no.	date	issued to

SITE PLAN

DRAINAGE SITE LAYOUT PLAN

PROPOSED IT PARK / ITES
Plot No. 1, Sector- 90, Noida

Client:-
C B S INTERNATIONAL PROJECTS Pvt. Ltd.
Plot No. 1, Sector-90, Noida Expressway, Noida. Tel. 0552707070
Email: info@cbsonline.com - Website: www.cbsonline.com

architects:-
SPACE COMBINE
(An ISO 9001:2000 Certified)
Architects, Engineers, Planners
project management consult.
A1/112 SAFDARJUNG ENCLAVE,
NEW DELHI - 110029
PH : 011-46150000
E-mail: spacecombine
@rediffmail.com

 

 
FIRE & PLUMBING CONSULTANT :-
PKV CONSULTING ENGINEERS (P) LTD.
D-1, 1st Floor Sector-7
Noida - 201301
PH. : 011-22816297
email :- pramod@pkv.co.in
nrcons@gmail.com

drawing released for:-
☐ APPROVAL ☐ SUBMISSION
☐ ADVANCE COPY ☐ CONSTRUCTION

drg. no.: SC/ITS/PL/01

scale: N.T.S. **date:** 06.06.2018

drawn by: Raju **ckd by:** Anoop

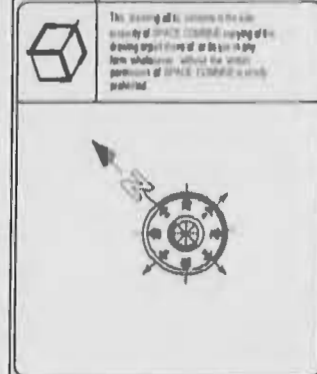

drawing released for:-	
☐ APPROVAL	☐ SUBMISSION
☐ ADVANCE COPY	☐ CONSTRUCTION
drg. no.: SC/ITS/FF/81	
scale: N.T.S	date: 06.06.2018
drawn by: Raju	ckd by: Anoop

