

DRG. NO.


FILE. NO.

NOTES:-

- 1) All Dimensions are in MM.
- 2) The site staff should coordinate this Arch. drwg. with the relevant Str. & Services drwg. before the start of the work.
- 3) In case any discrepancy is found in the drwg. the same shall be brought to the notice of the E.I. Charge / consultant. The work shall not be carried out without clarification from the consultant.
- 4) For details of the sect. 1-1 & 2-2 ref. drawing no. -211.AR.00.03

SCHEDULE OF PIPES

PIPE NO.	DESCRIPTION	
⑤	DOMESTIC WATER RISER PIPE	
⑥	DOMESTIC WATER SUPPLY PIPE	
Ⓜ	VALVE CHAMBER	
E.S.P.	EXTERNAL SEWERAGE PIPE	
R.W.P.	EXTERNAL DRAINAGE PIPE	
W.S.P.	WATER SUPPLY PIPE	
	INTERNAL	
SEWERAGE	U.P.V.C SWR PIPE	EXTERNAL
WATER SUPPLY	C.P.V.C PIPE	U.P.V.C SWR PIPE
		C.P.V.C PIPE/D.I.

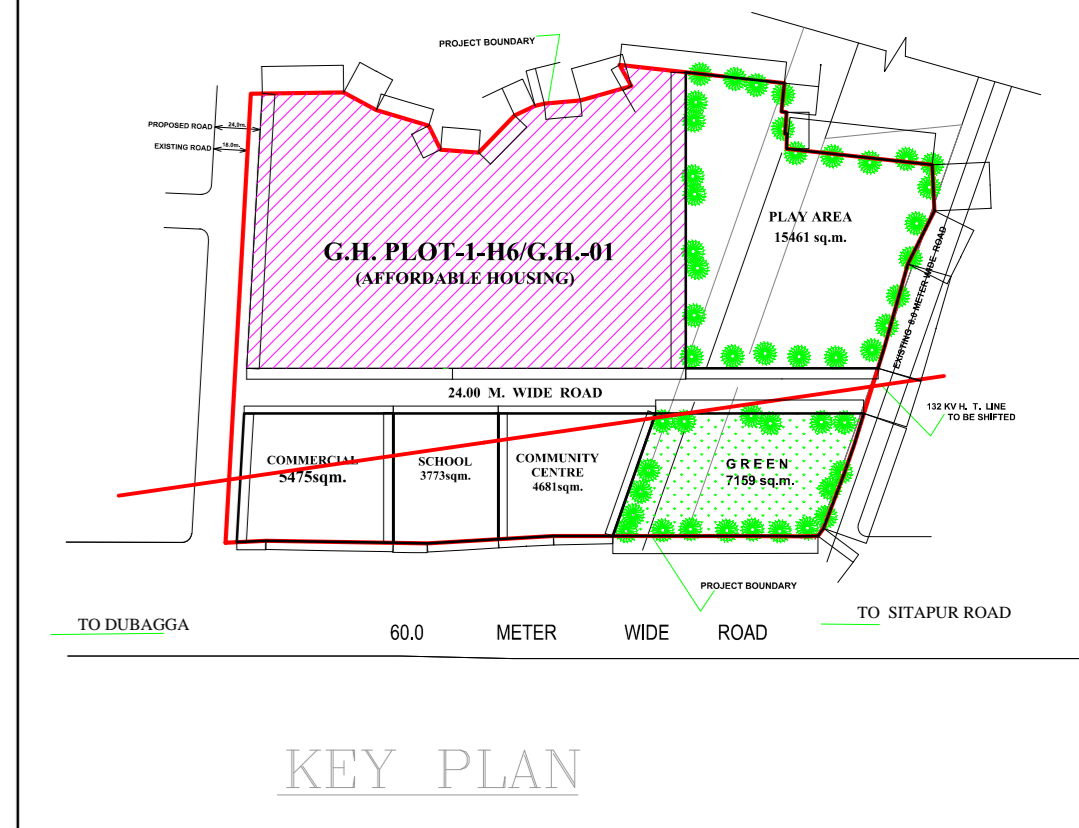

DATE	NO.	ISSUED TO	INITIAL
08.09.16	R1	SITE PLAN REVISED A/P REVISION IN DIMENSION OF THE PLOT.	
		BRIEF RECORD	

REVISION

CONSULTANTS:
SAJAG CONSULTANTS
C-146 KILOKRI
NEAR MAHARANI BAGH CROSSING
NEW DELHI-110014
TELEPHONE-26343059,9868848054

DIVISION	DRAWN	CHECKED	APPD	UNIT
PL	VIKRAM	VIJAY	R.B.	M.M.

DRG. NO. : 211.WS.00.03

SCHEME:
AMRAPALI YOJNA, HARDOI ROAD,
LUCKNOW.

DRG. TITLE:

EXTERNAL WATER SUPPLY LAYOUT
PLAN

PROJECT: **GROUP HOUSING ON
PLOT NO. H6/G.H-1**

DATE: 21-04-2017

SCALE: 1:250

24.0 M WIDE ROAD

PLAY AREA

24.0 M WIDE ROAD

LEGEND:-

	GARDEN HYDRANT	⑥	DOMESTIC WATER SUPPLY PIPE
	4WAY CONNECTION	INTERNAL	EXTERNAL
	NON RETURN VALVE	SEWERAGE	U.P.V.C SWR PIPE
	ISOLATION VALVE BUTTER FLY VALVE)	WATER SUPPLY	C.P.V.C PIPE
	EXTERNAL WATER SUPPLY LINE		C.P.V.C PIPE/D.I.
	GARDEN HYDRANT LINE	A	= 150ø FIRE DOWN COMER PIPE
	FIRE EXTINGUISHER	FS	= FLOW INDICATING SWITCH
	FIRE EXTINGUISHER	⊙	= SPRINKLER
	TYPE ABC FOR FHC, E ROOM, LIFT LOBBY & CORRIDOR	⊠	600x600mm.VALVE CHAMBER
	DOMESTIC WATER RISER PIPE	FHC	= FIRE HOSE CABINET
		Ⓜ	COMMUNICATION SYSTEM
		Ⓜ	FIREMAN SWITCH

BENCH MARK
TOP OF CULVERT
99.117 R. (113.167)

