


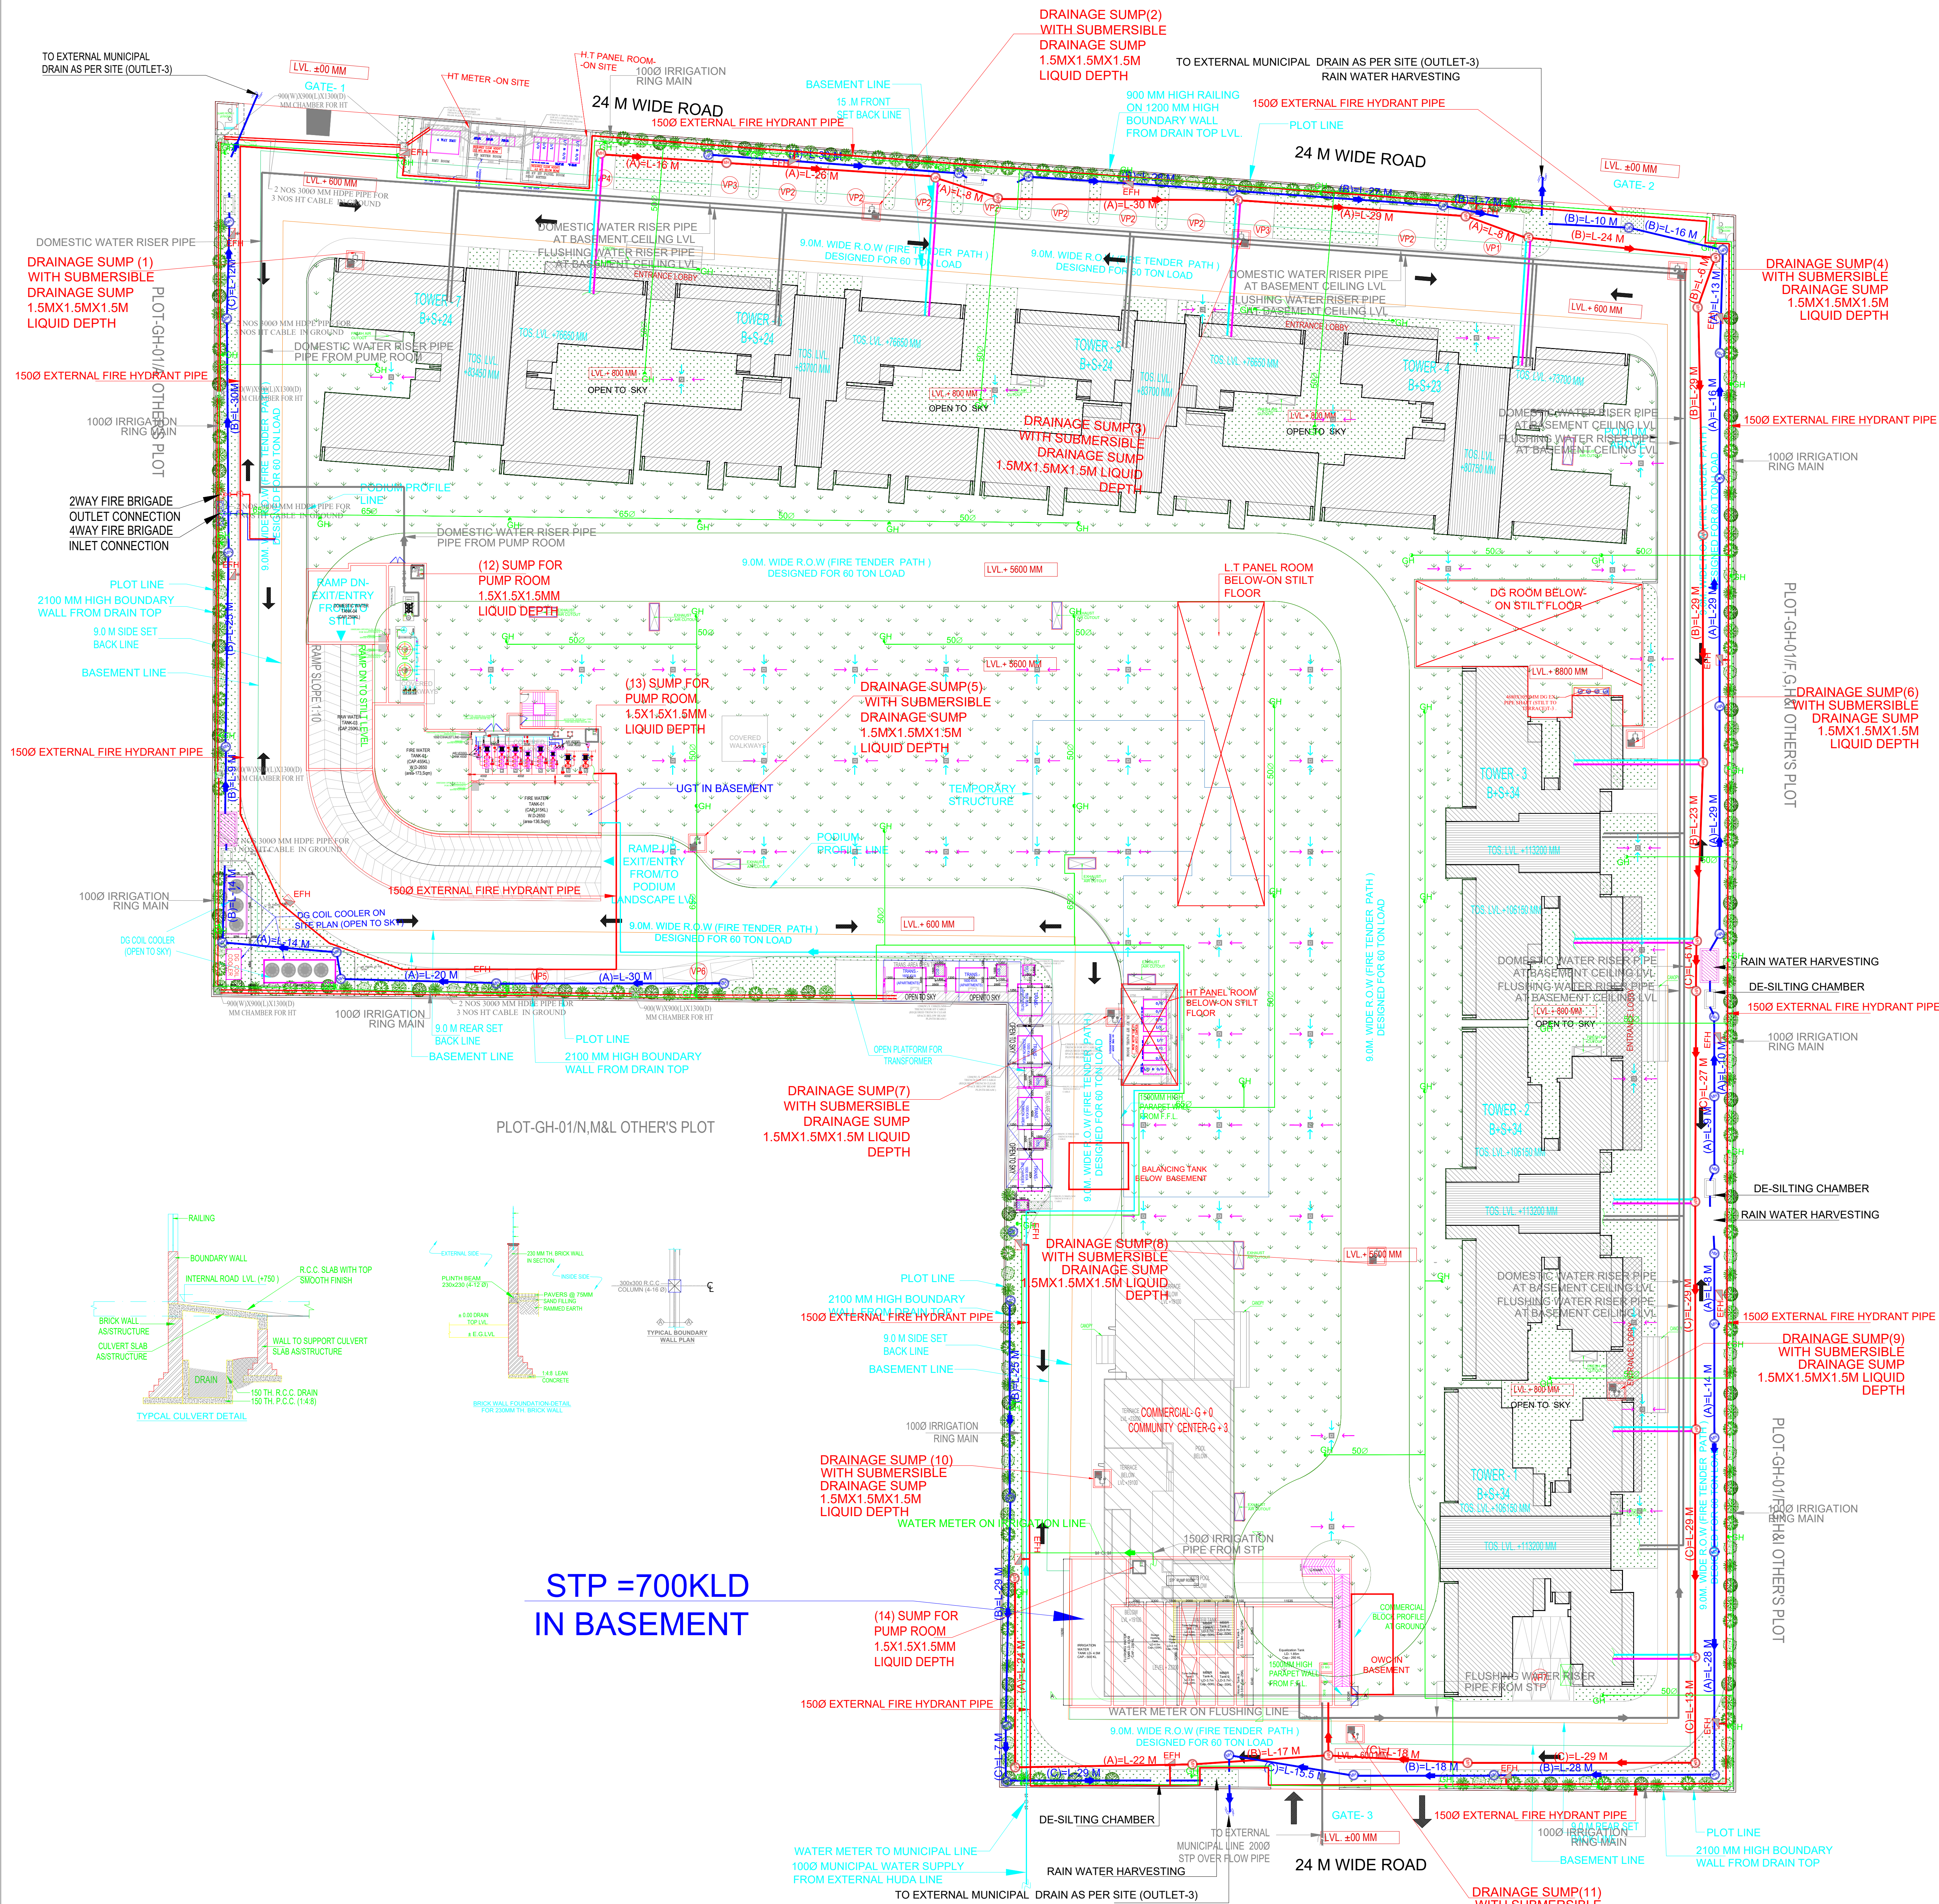

STP =700KLD
IN BASEMENT

DESCRIPTION	SYMBOL
SEWERAGE LINE	-----
SEWER MANHOLE SIZE	MH


EXTERNAL SEWER PIPES :-

A	200Ø SEWERAGE PIPE (SLOPE 1:190)
B	250Ø SEWERAGE PIPE (SLOPE 1:250)
C	300Ø SEWERAGE PIPE (SLOPE 1:320)
D	400Ø SEWERAGE PIPE (SLOPE 1:470)

DESCRIPTION	SYMBOL
RAIN WATER CHAMBER SIZE	MH
DRAIN CHAMBER	DC

EXTERNAL STORM PIPES :-

A	150Ø STORM PIPE (SLOPE 1:250)
B	250Ø STORM PIPE (SLOPE 1:350)
C	300Ø STORM PIPE (SLOPE 1:450)
D	400Ø STORM PIPE (SLOPE 1:560)
C.B.I.L	CATCH BASIN INVERT LEVEL
C.B.C.L	CATCH BASIN CONNECTION LEVEL
F.G.L	FINISH GROUND LEVEL
M.H.I.L	MANHOLE INVERT LEVEL

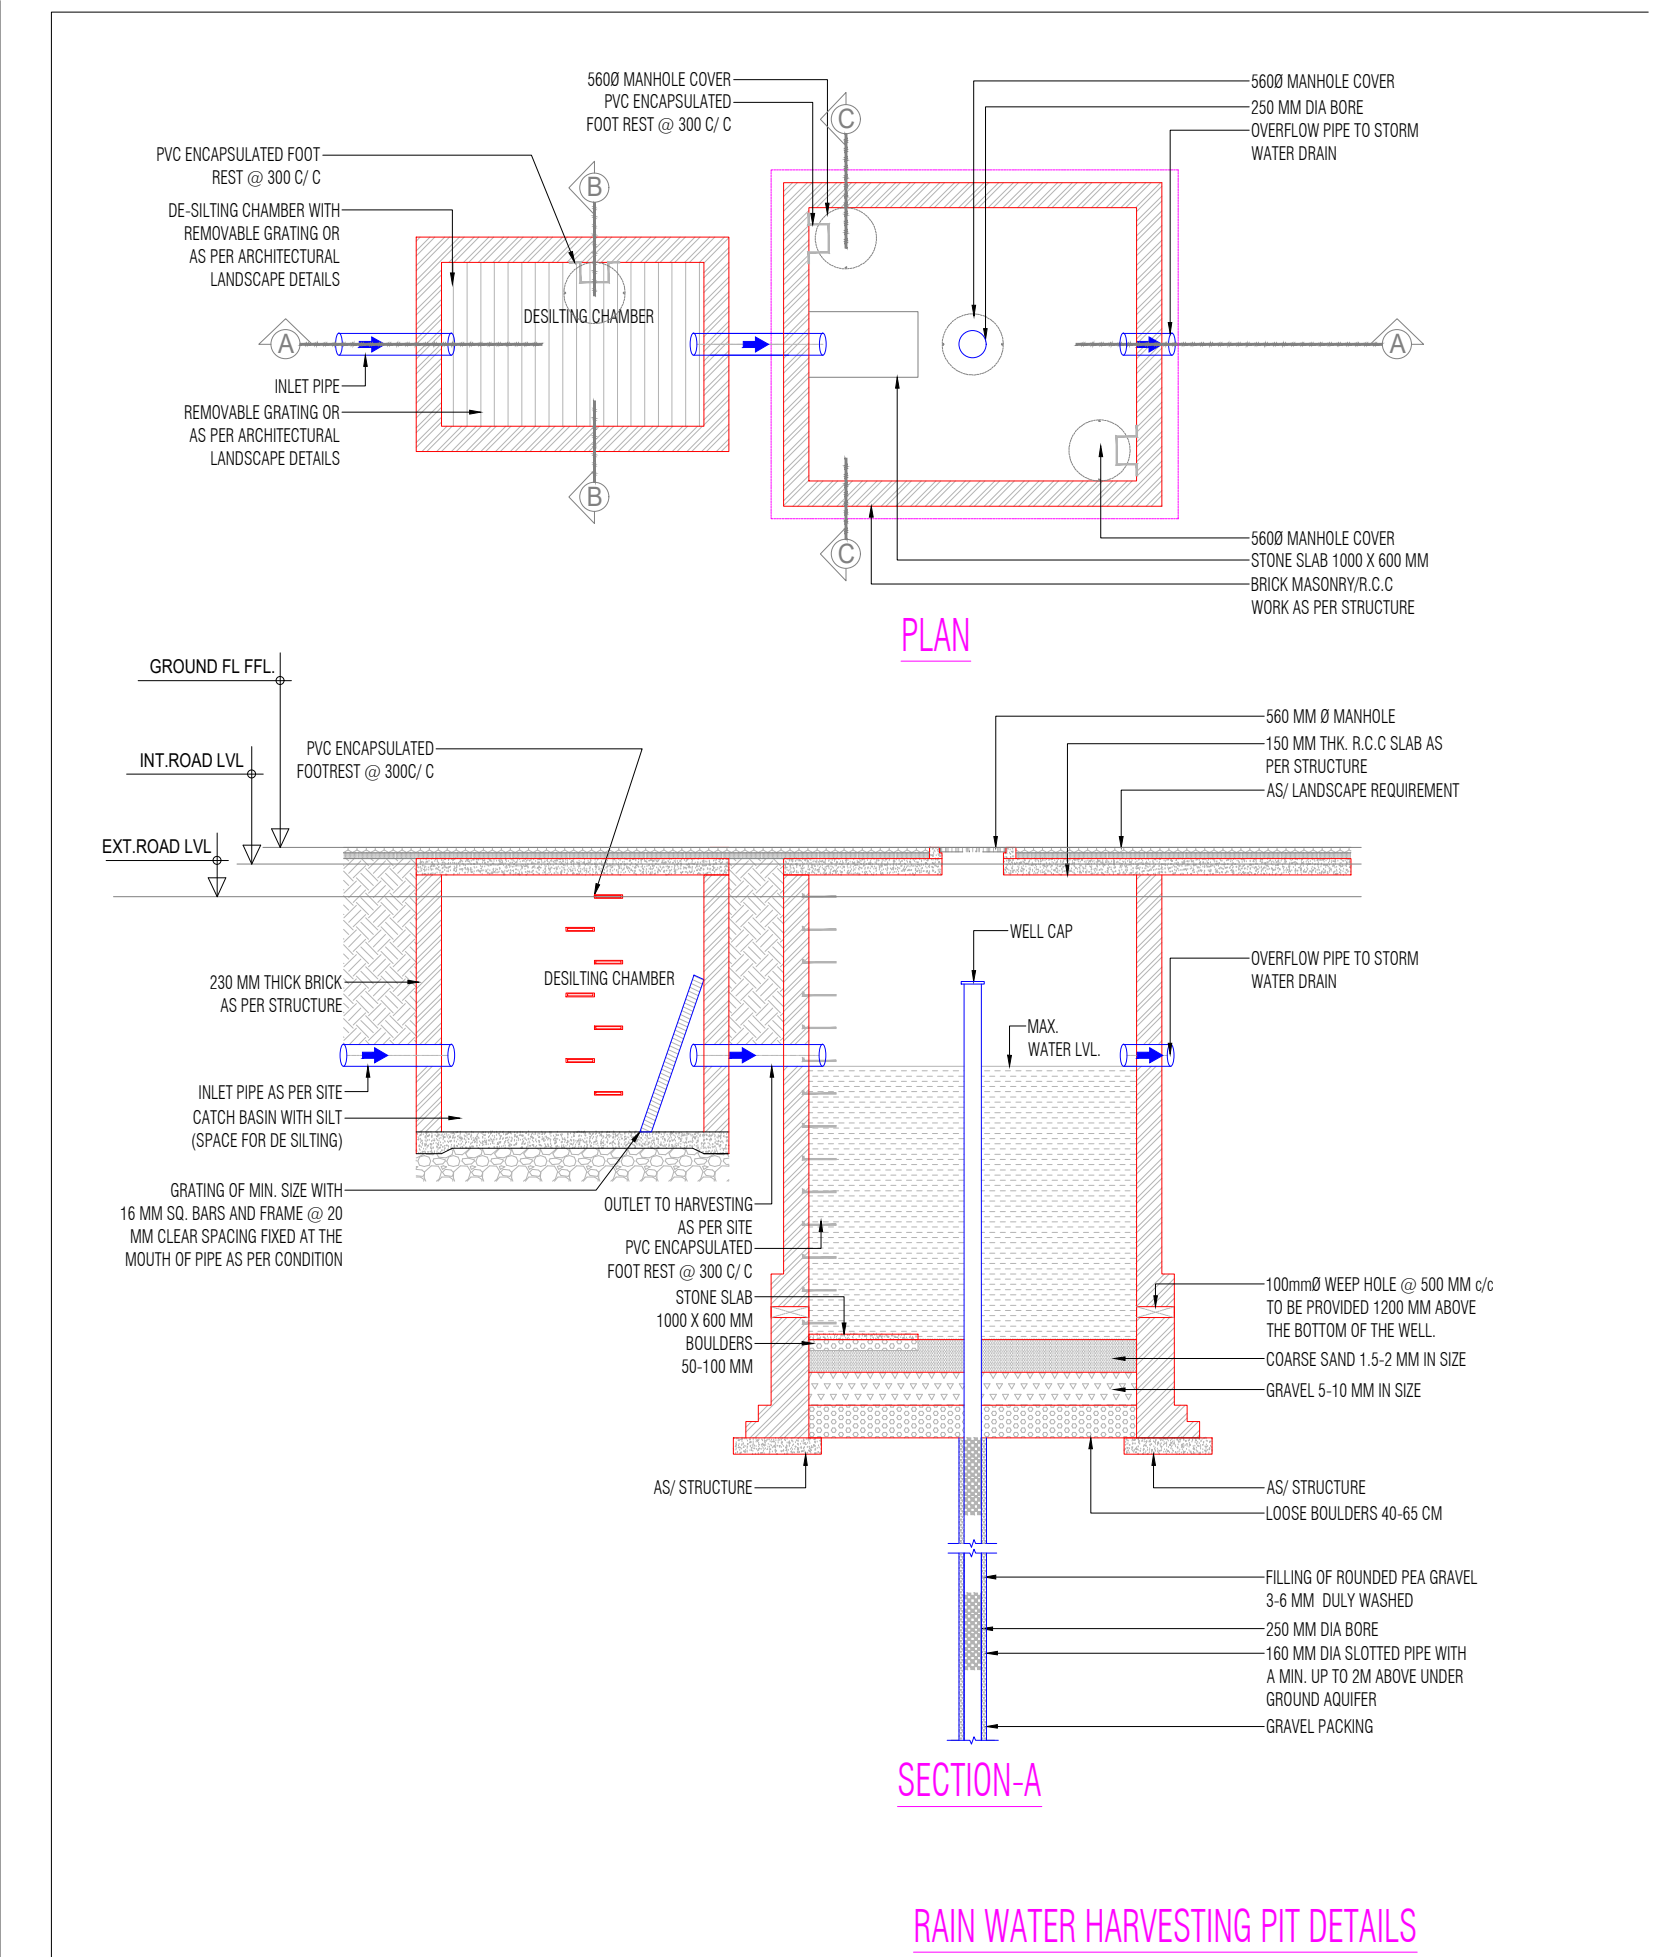

OWNER SIGN

ARCHITECT SIGN

TOWN PLANNER SIGN

MEP CONSULTANT

DESIGN CENTRE CONSULTING ENGINEERS
PVT.LTD

OFFICE NO. 44 TO 47, 4TH FLOOR
ANSAL PLAZA, DABUR CHOWK
VAISHALI, GHAZIABAD, UP
PHONE: 0120-4333451,4333452

OWNER

GODREJ PROPERTIES LIMITED

SUBMISSION DRAWING

KEY PLAN

PROJECT

PROPOSED GROUP HOUSING FOR
PLOT NO :- GH-01/B,C,D,E,J & K SECTOR -12,
GREATER NOIDA, G.B. NAGAR, (U.P.)

DATE	PROJECT INCH.	CHECKED BY
23-01-2025	BALRAJ SINGH	BALRAJ SINGH
SCALE	DEALT BY	APPROVED BY
1:100	ABDRESH JHA	VISHAL SHARMA

DRAWING TITLE

MEP LAYOUT
SITE PLAN

ARCHITECTS

GOLDEN INIDA ARCHITECTS
THE TEAM OF ARCHITECTS
FF-37, KADAMBA SHOPPING COMPLEX
GAMMA-1 GREATER NOIDA
CON...+91-941585-6777

DESIGN BY:

Confluence
NEW DELHI, INDIA

F-1, FIRST FLOOR, MIRA CORPORATE SUITES,
ISHWAR NAGAR, NEW DELHI 110065

Ph +91-11-26925684 ccs@inconfuence.com Member of IGBC

Ph +91-11-40564768 www.inconfuence.com ISO - 9001 : 2000

architecture urban design hospitality interiors

DRAWING NO. DCCE/1446/MEP-SP-01

REVISION