


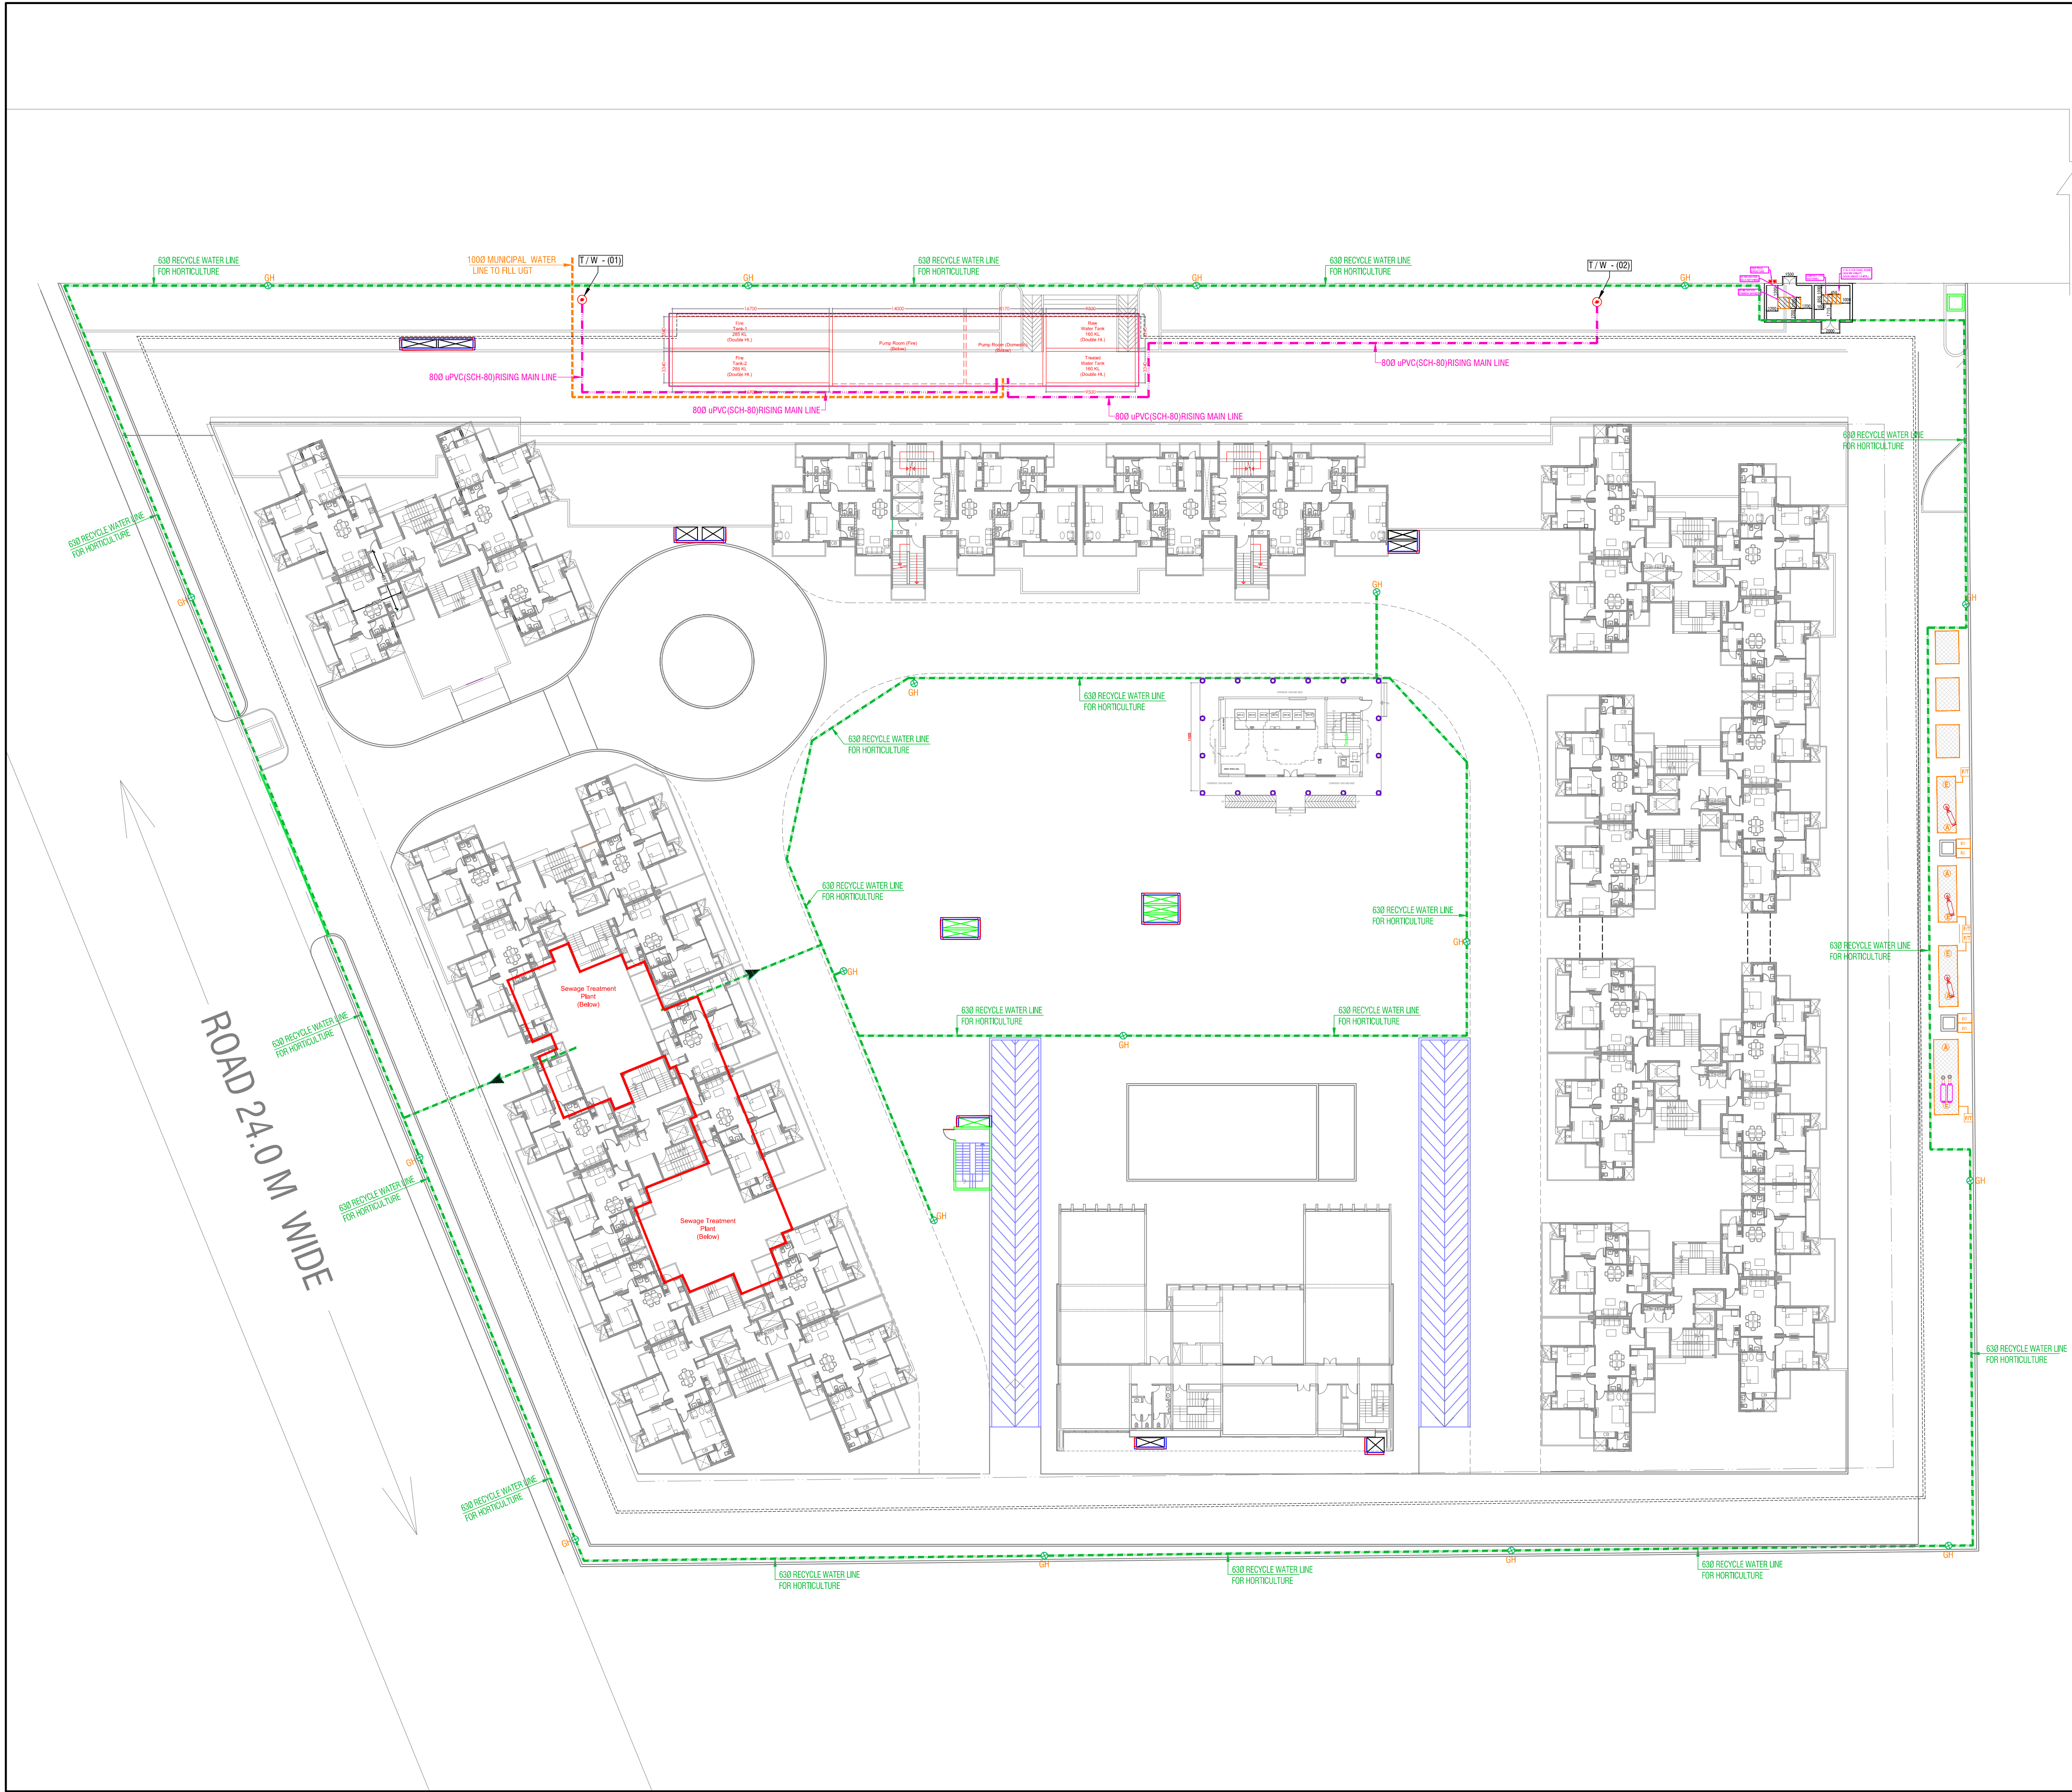

LEGEND :

S. No.	SYMBOL	DESCRIPTION
8.		RECYCLED WATER SUPPLY PIPE LINE.
9.		RISING MAIN WATER PIPE LINE.
10.		MUNICIPAL WATER SUPPLY PIPE LINE.
11.		ISOLATING VALVE
12.		PROPOSED TUBE WELL
13.		BASEMENT LINE
14.		GARDEN HYDRANT

rev. no.	date	revision

project

EXPRESS ASTRA
PLOT NO. GH-6A, SECTOR 01, GREATER NOIDA (U.P.)

title

SITE PLAN

subtitle

EXTERNAL WATER SUPPLY SYSTEM

drawing released for

☒ SUBMISSION

☐ ADVANCE COPY

☐ APPROVAL

☐ CONSTRUCTION

drg. no.

EXP. ETE. / EX / S-03

drawn by

Kulwant

scale

1 : 350

designed by

R.K

date

Aug. 2013

checked by

Anand Havella

architects

4th DIMENSION
ARCHITECTURE INTERIORS PLANNING
C-17, Basement, ANAND NIKETAN,
New Delhi - 110 021 India PHONES : +91.11.41661137 +91.9810861137
FAX : +91.11.42705425 E MAIL : mail@4d-arch.com

services consultant

Consummate Engineering Services (P) Ltd.
Noida Office : B - 67, Sector - 67, Noida - 201 301
Tel : (0120) 2985500 (30 Lines)
Lko Office : R 006, Rohas Plumeria, Gomti Nagar, Lucknow
Tel : (0522) 6515455
e mail : mail@cespln, website : www.cespln