


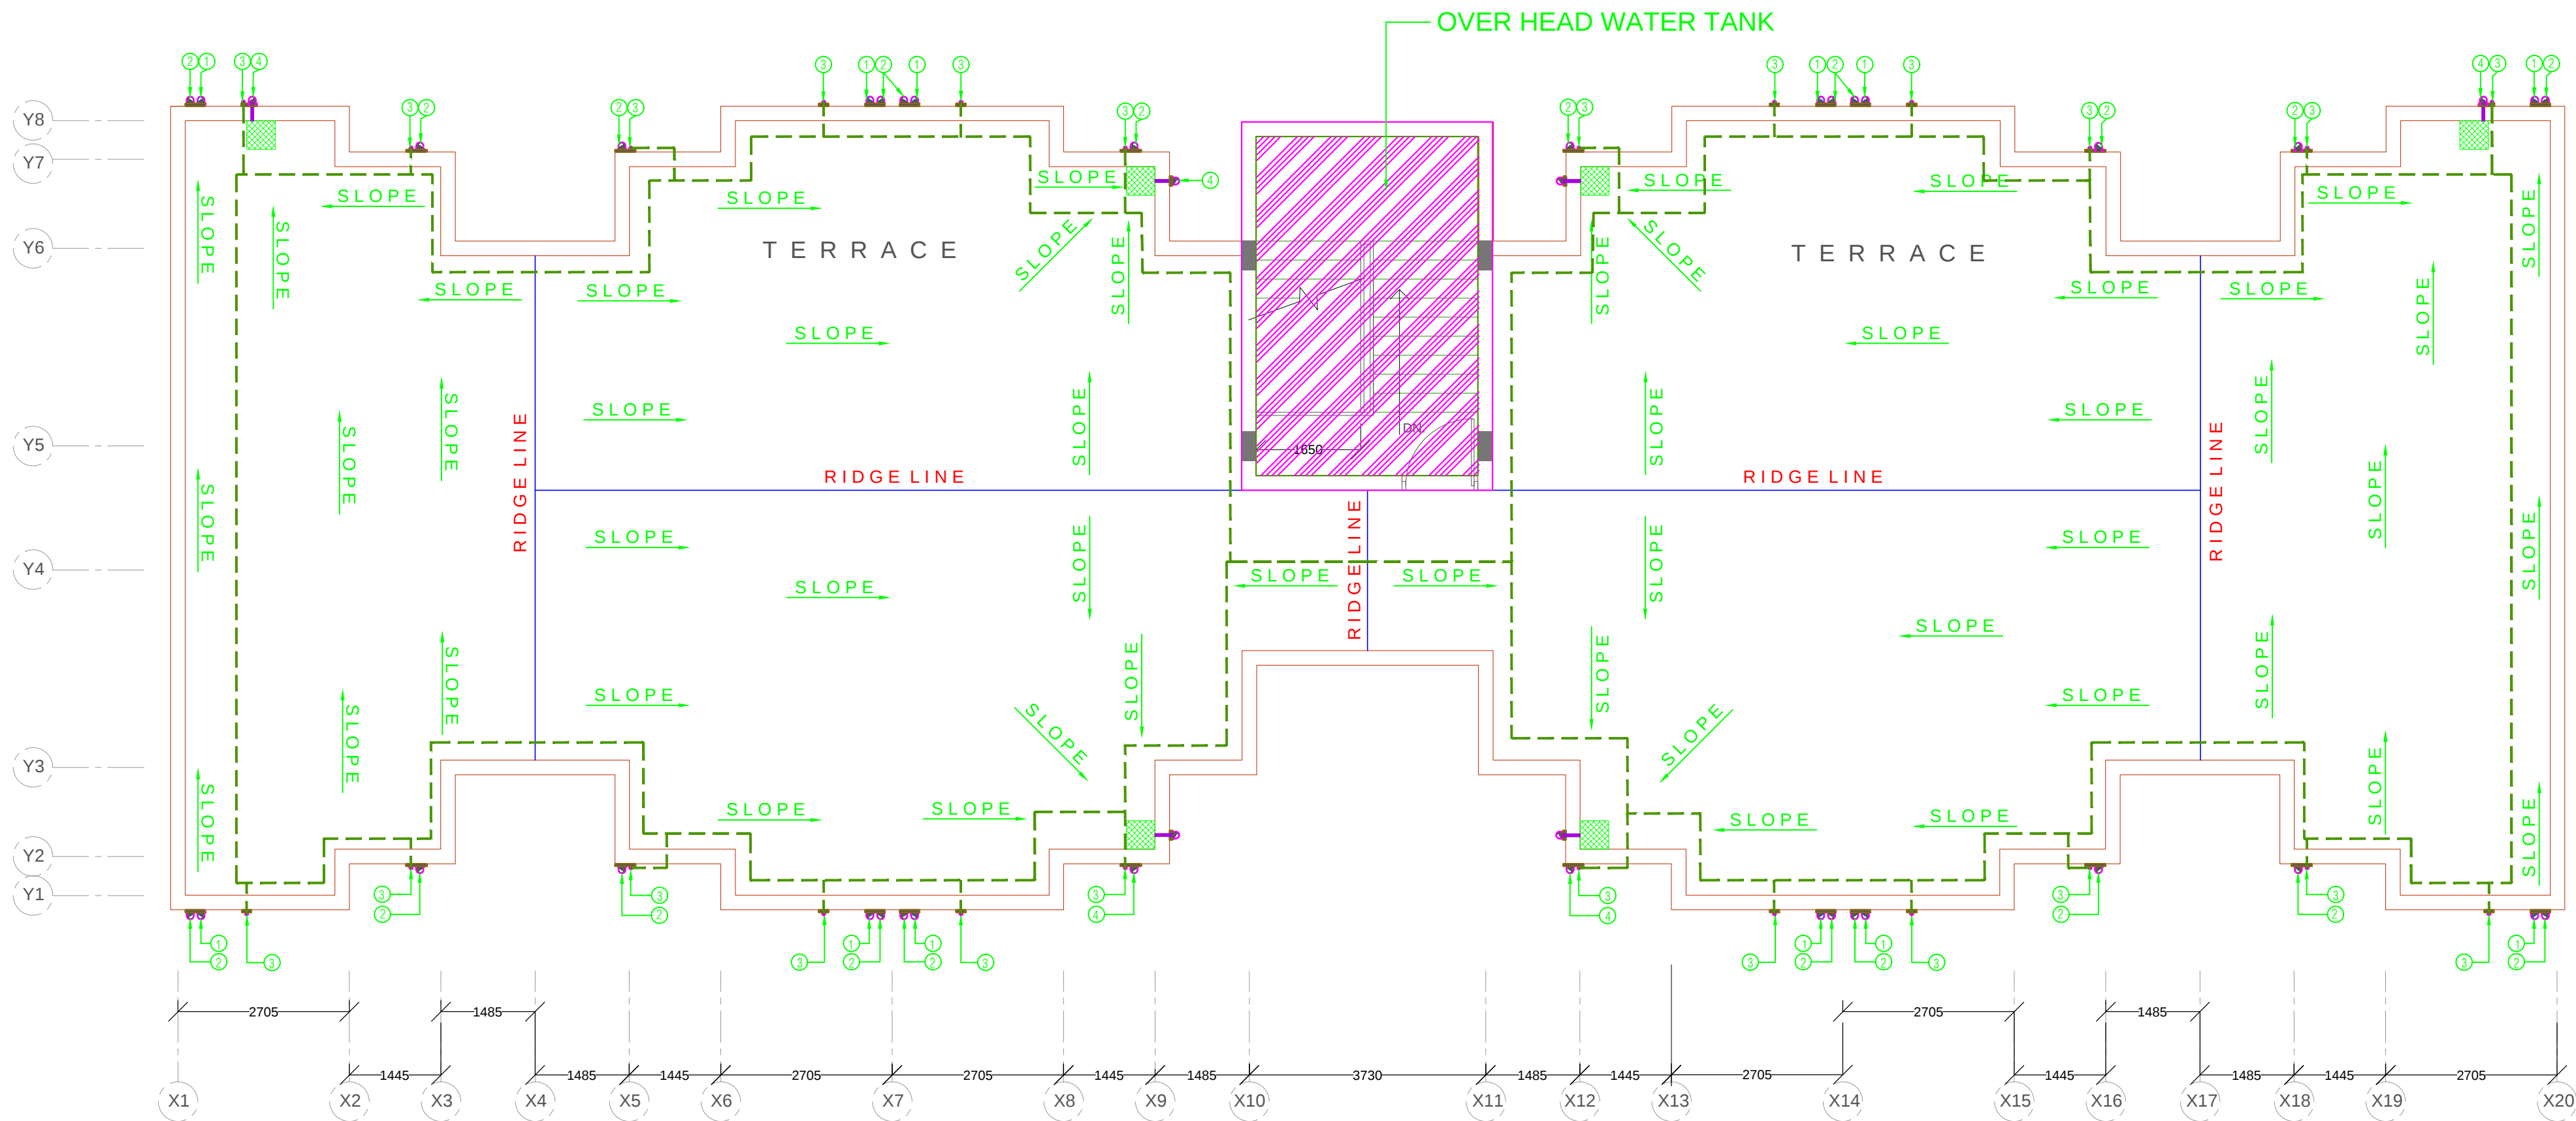

SCHEDULE OF PIPES :-	
PIPE NO.	DESCRIPTION
1	110 OD uPVC SOIL PIPE
2	110 OD uPVC WASTE PIPE
3	G.I. DOMESTIC WATER SUPPLY D/N TAKE PIPE
4	110 OD uPVC TERRACE RAIN WATER PIPE
5	90 OD uPVC BALCONY DRAIN PIPE
6	G.I. DOMESTIC WATER SUPPLY RISER *
	450x450mm KHURRA
	FLOOR TRAP
	BALCONY TRAP

						NO.	REF. DRAWING	Drg. No.	KEY PLAN 	PROJECT TITLE: AFFORDABLE HOUSING BAROLA JAFRABAD YOJNA				 ARCHITECT: DesignEvolution Pvt Ltd ARCHITECTURE, INTERIOR DESIGN & PLANNING H-25,2nd Floor, Green Park Extension, NEW DELHI 110016 TEL: 011-26115719, FAX: 011-26215718 E-MAIL: designevolutionpvtltd@gmail.com Tel:+91(11)26215718 ; Fax:+91(11)26215719
										DRAWING TITLE: TERRACE FLOOR PLAN				
										Scale :	Drawing no:	Date:	Sheet no:	
A	10.08.2018	For Information		Ar. Urooz	Ar.A.Kapoor					1:75	DE /ADA / PB-01	10.08.18		
NO.	Date.	REVISIONS	Drg.By	Chkd.By	Approved									