
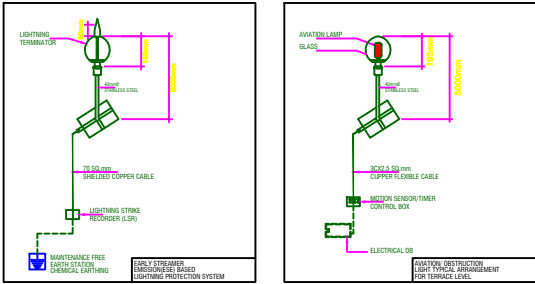
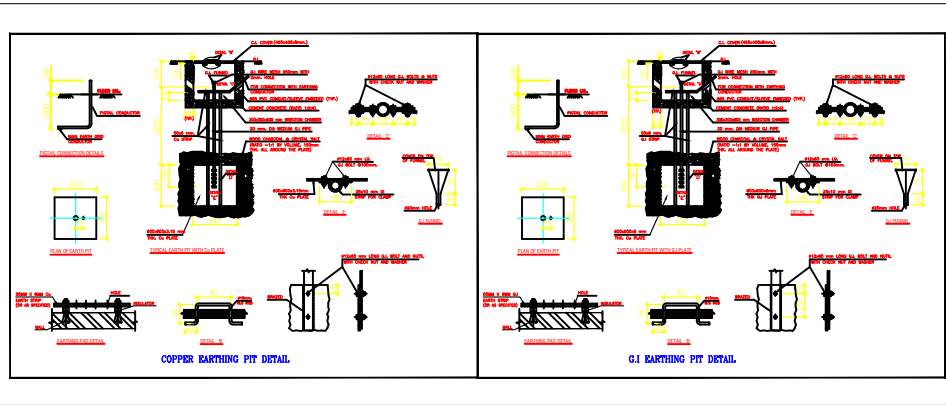


15.00 M. WIDE ROAD

BOUNDARY WALL
2400MM HIGH

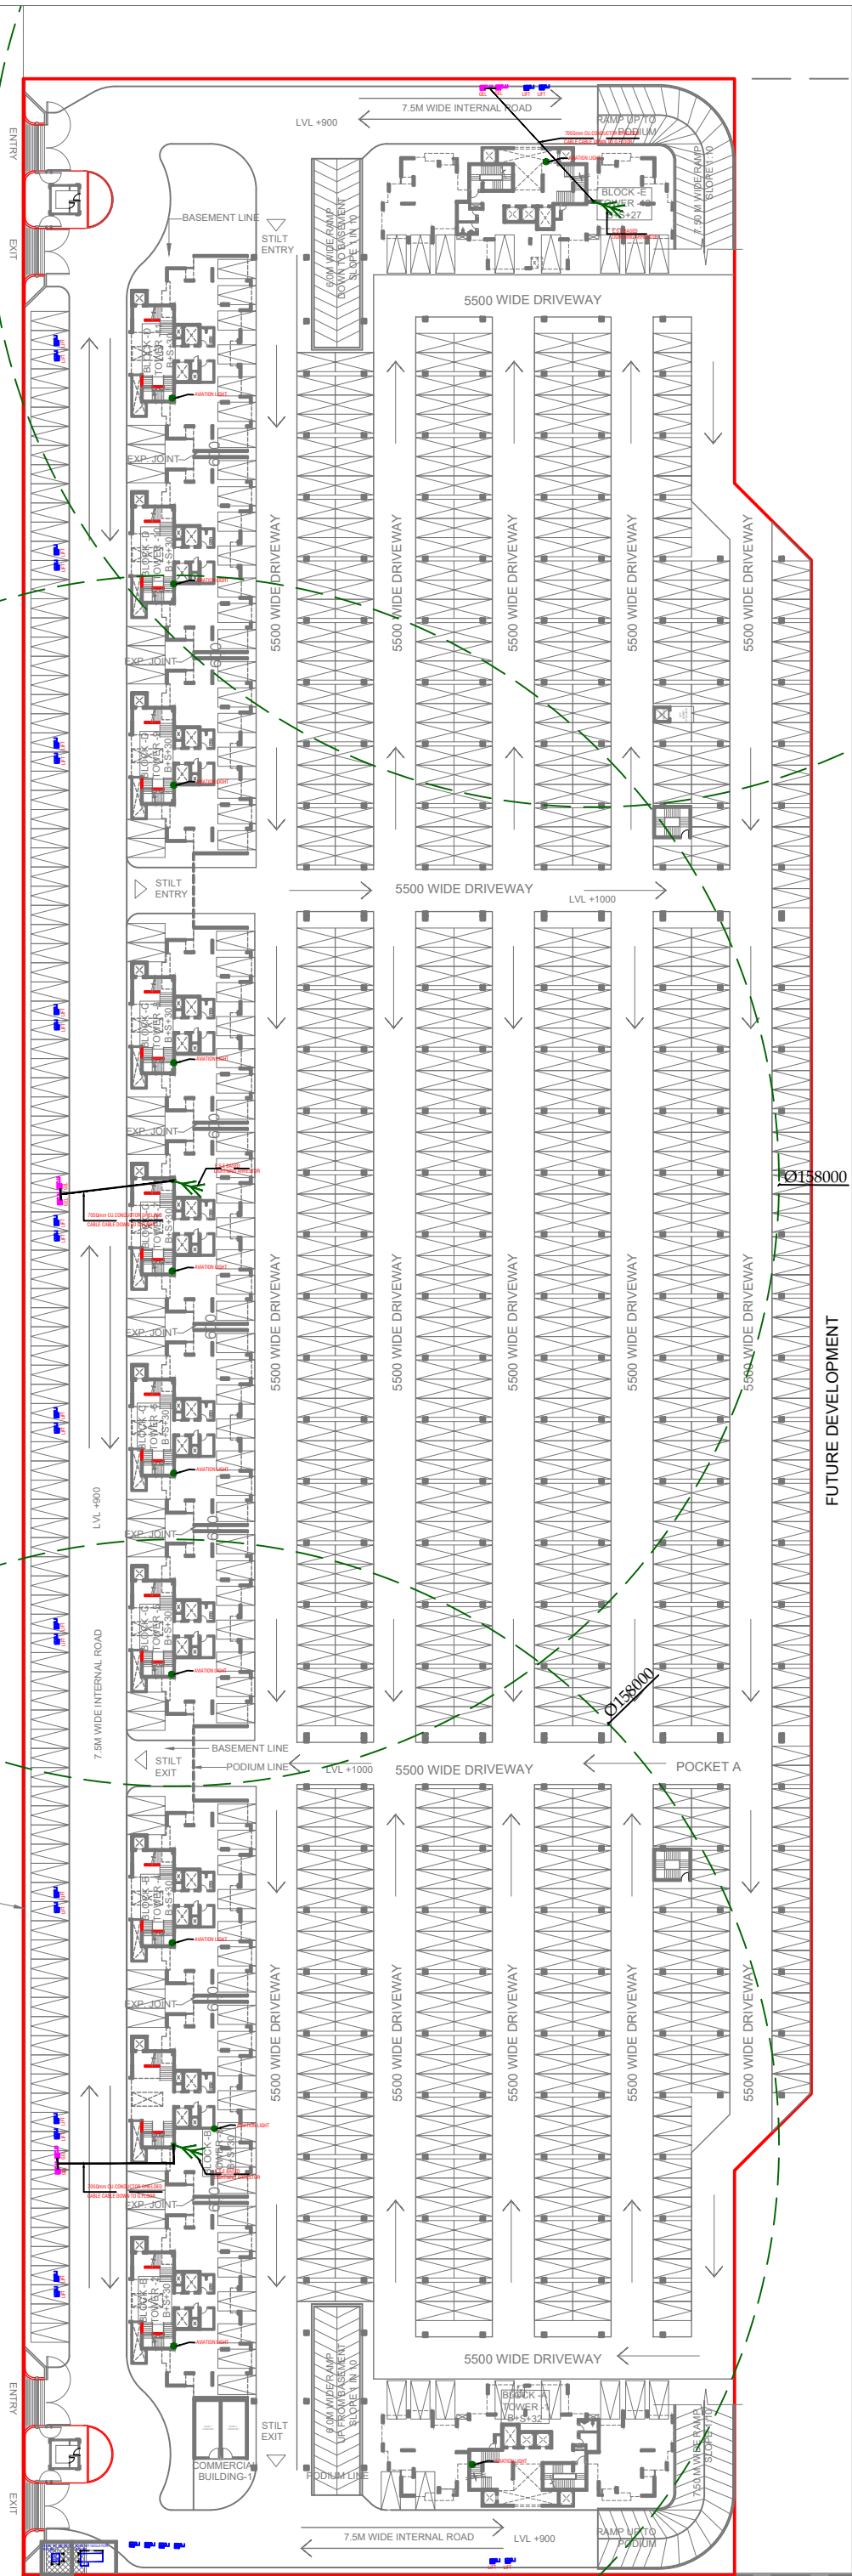

S.NO.	SYMBOL	DESCRIPTION
1.		G.I. EARTHING PIT
2.		C.U. EARTHING PIT
3.		GEL/CHEMICAL EARTHING PIT
4.		LIGHTING ARRESTOR
5.		705Qmm CU.CONDUCTOR SHIELDED CABLE

- *** NATIONAL BUILDING CODES IN ELECTRICAL:-
1. LIGHTNING PROTECTION SYSTEM-IEC-61024
 2. EARTHING STATION - IS-3043,1987
 3. ELECTRICAL SWITCHGEAR - IEC-60947 & IS-13947

SHEET TITLE

SITE ELECTRICAL LAYOUT

PROJECT

PHASE 1 OF PROPOSED PROJECT ATS
HOMEKRAFT PIOUS HIDEAWAYS AT PLOT
NO - SC-02/ J&K, SECTOR 150, NOIDA
DISTT : GAUTAM BUDDH NAGAR