


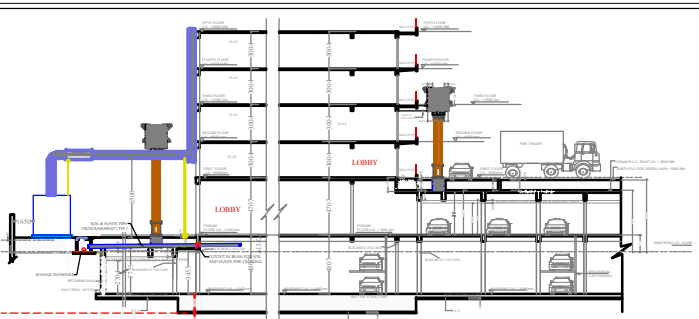
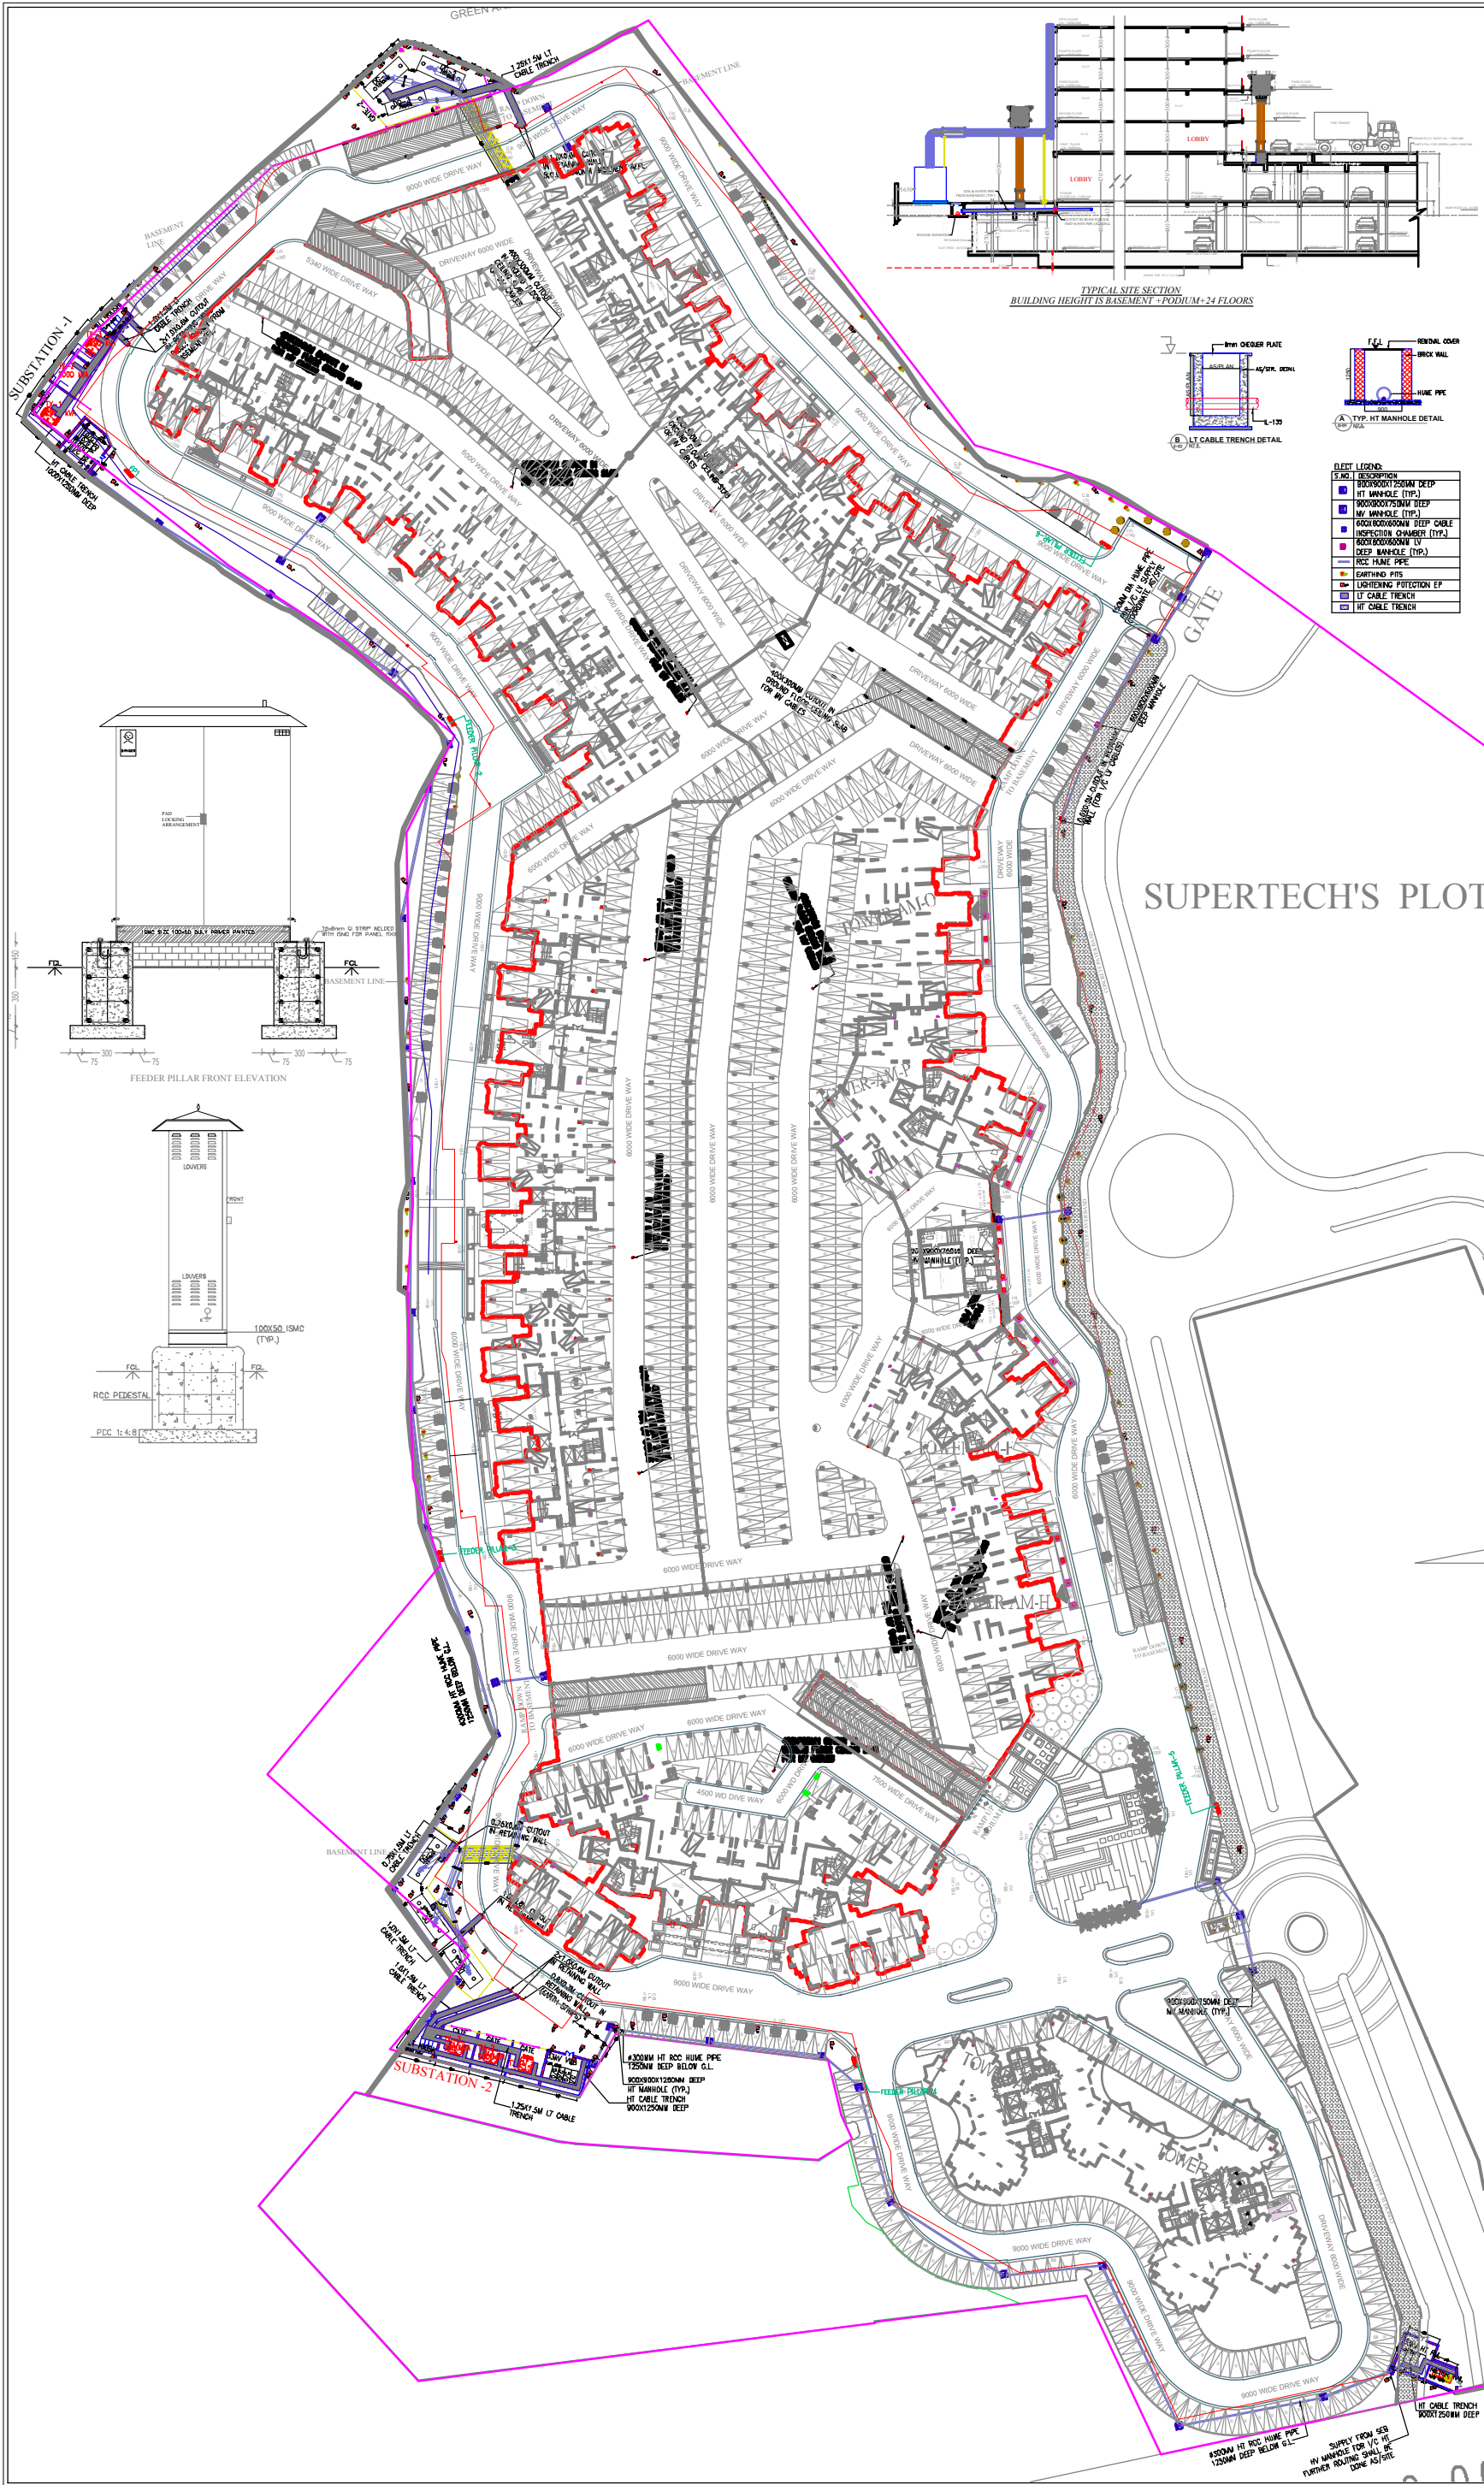
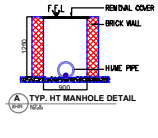


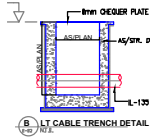

TYPICAL SITE SECTION
BUILDING HEIGHT IS BASEMENT + PODIUM + 24 FLOORS

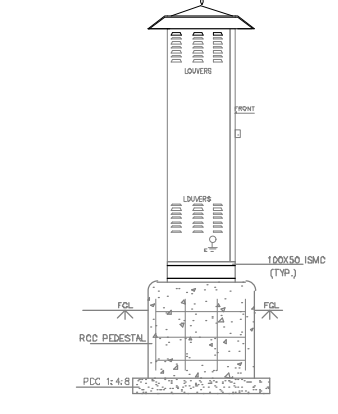

S.NO.	DESCRIPTION
1	800X800X1200MM DEEP HT MANHOLE (TYP.)
2	800X800X1200MM DEEP HT MANHOLE (TYP.)
3	800X800X1200MM DEEP CABLE INSPECTION CHAMBER (TYP.)
4	800X800X1200MM DEEP CABLE INSPECTION CHAMBER (TYP.)
5	DEEP MANHOLE (TYP.)
6	RCC MANHOLE
7	EARTHING PITS
8	LIGHTNING PROTECTION EP
9	LT CABLE TRENCH
10	HT CABLE TRENCH

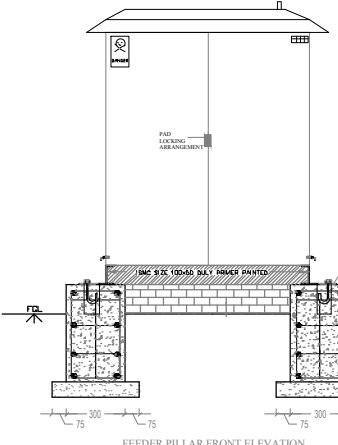

KEY PLAN

REV. NO. DATE DESCRIPTION

1		
2		
3		
100		

PROJECT "AMBROSIA" PROPOSED GROUP HOUSING SECTOR-118 NOIDA

BUILDING & PROMOTER AJNARA INDIA LTD.

ARCHITECT Space Designers International Architects Pvt. Ltd. E / 138, VASUNDHARA, GHAZIABAD Ph: 0120-412014, Mob: 9811070389, 9811082621 Email: ajnara@protonmail.com, www.ajnara.com architects & planners

LANDSCAPE CONSULTANTS S. BOSE LANDSCAPE CONSULTANTS D-21, CENTRALIGHT PLACE NEW DELHI-110001 Ph: 23418550

SERVICES CONSULTANTS Proton Consultants Building Services - MEP Consulting Pocket J, Plot No 108, Issola, New Delhi 110 025, India. Phone: 011.4659.1188, www.proton.net

DRAWING TITLE SITE PLAN ELECTRICAL LAYOUT

DATE 01-10-2019	CONCEPTUAL DRAWING
SCALE 1:400	WORKING DRAWING
SHEET A0	FINAL DRAWING
REV. NO. 01	GOOD FOR CONSTRUCTION

PC-AJ-AI-SITE-02-100