


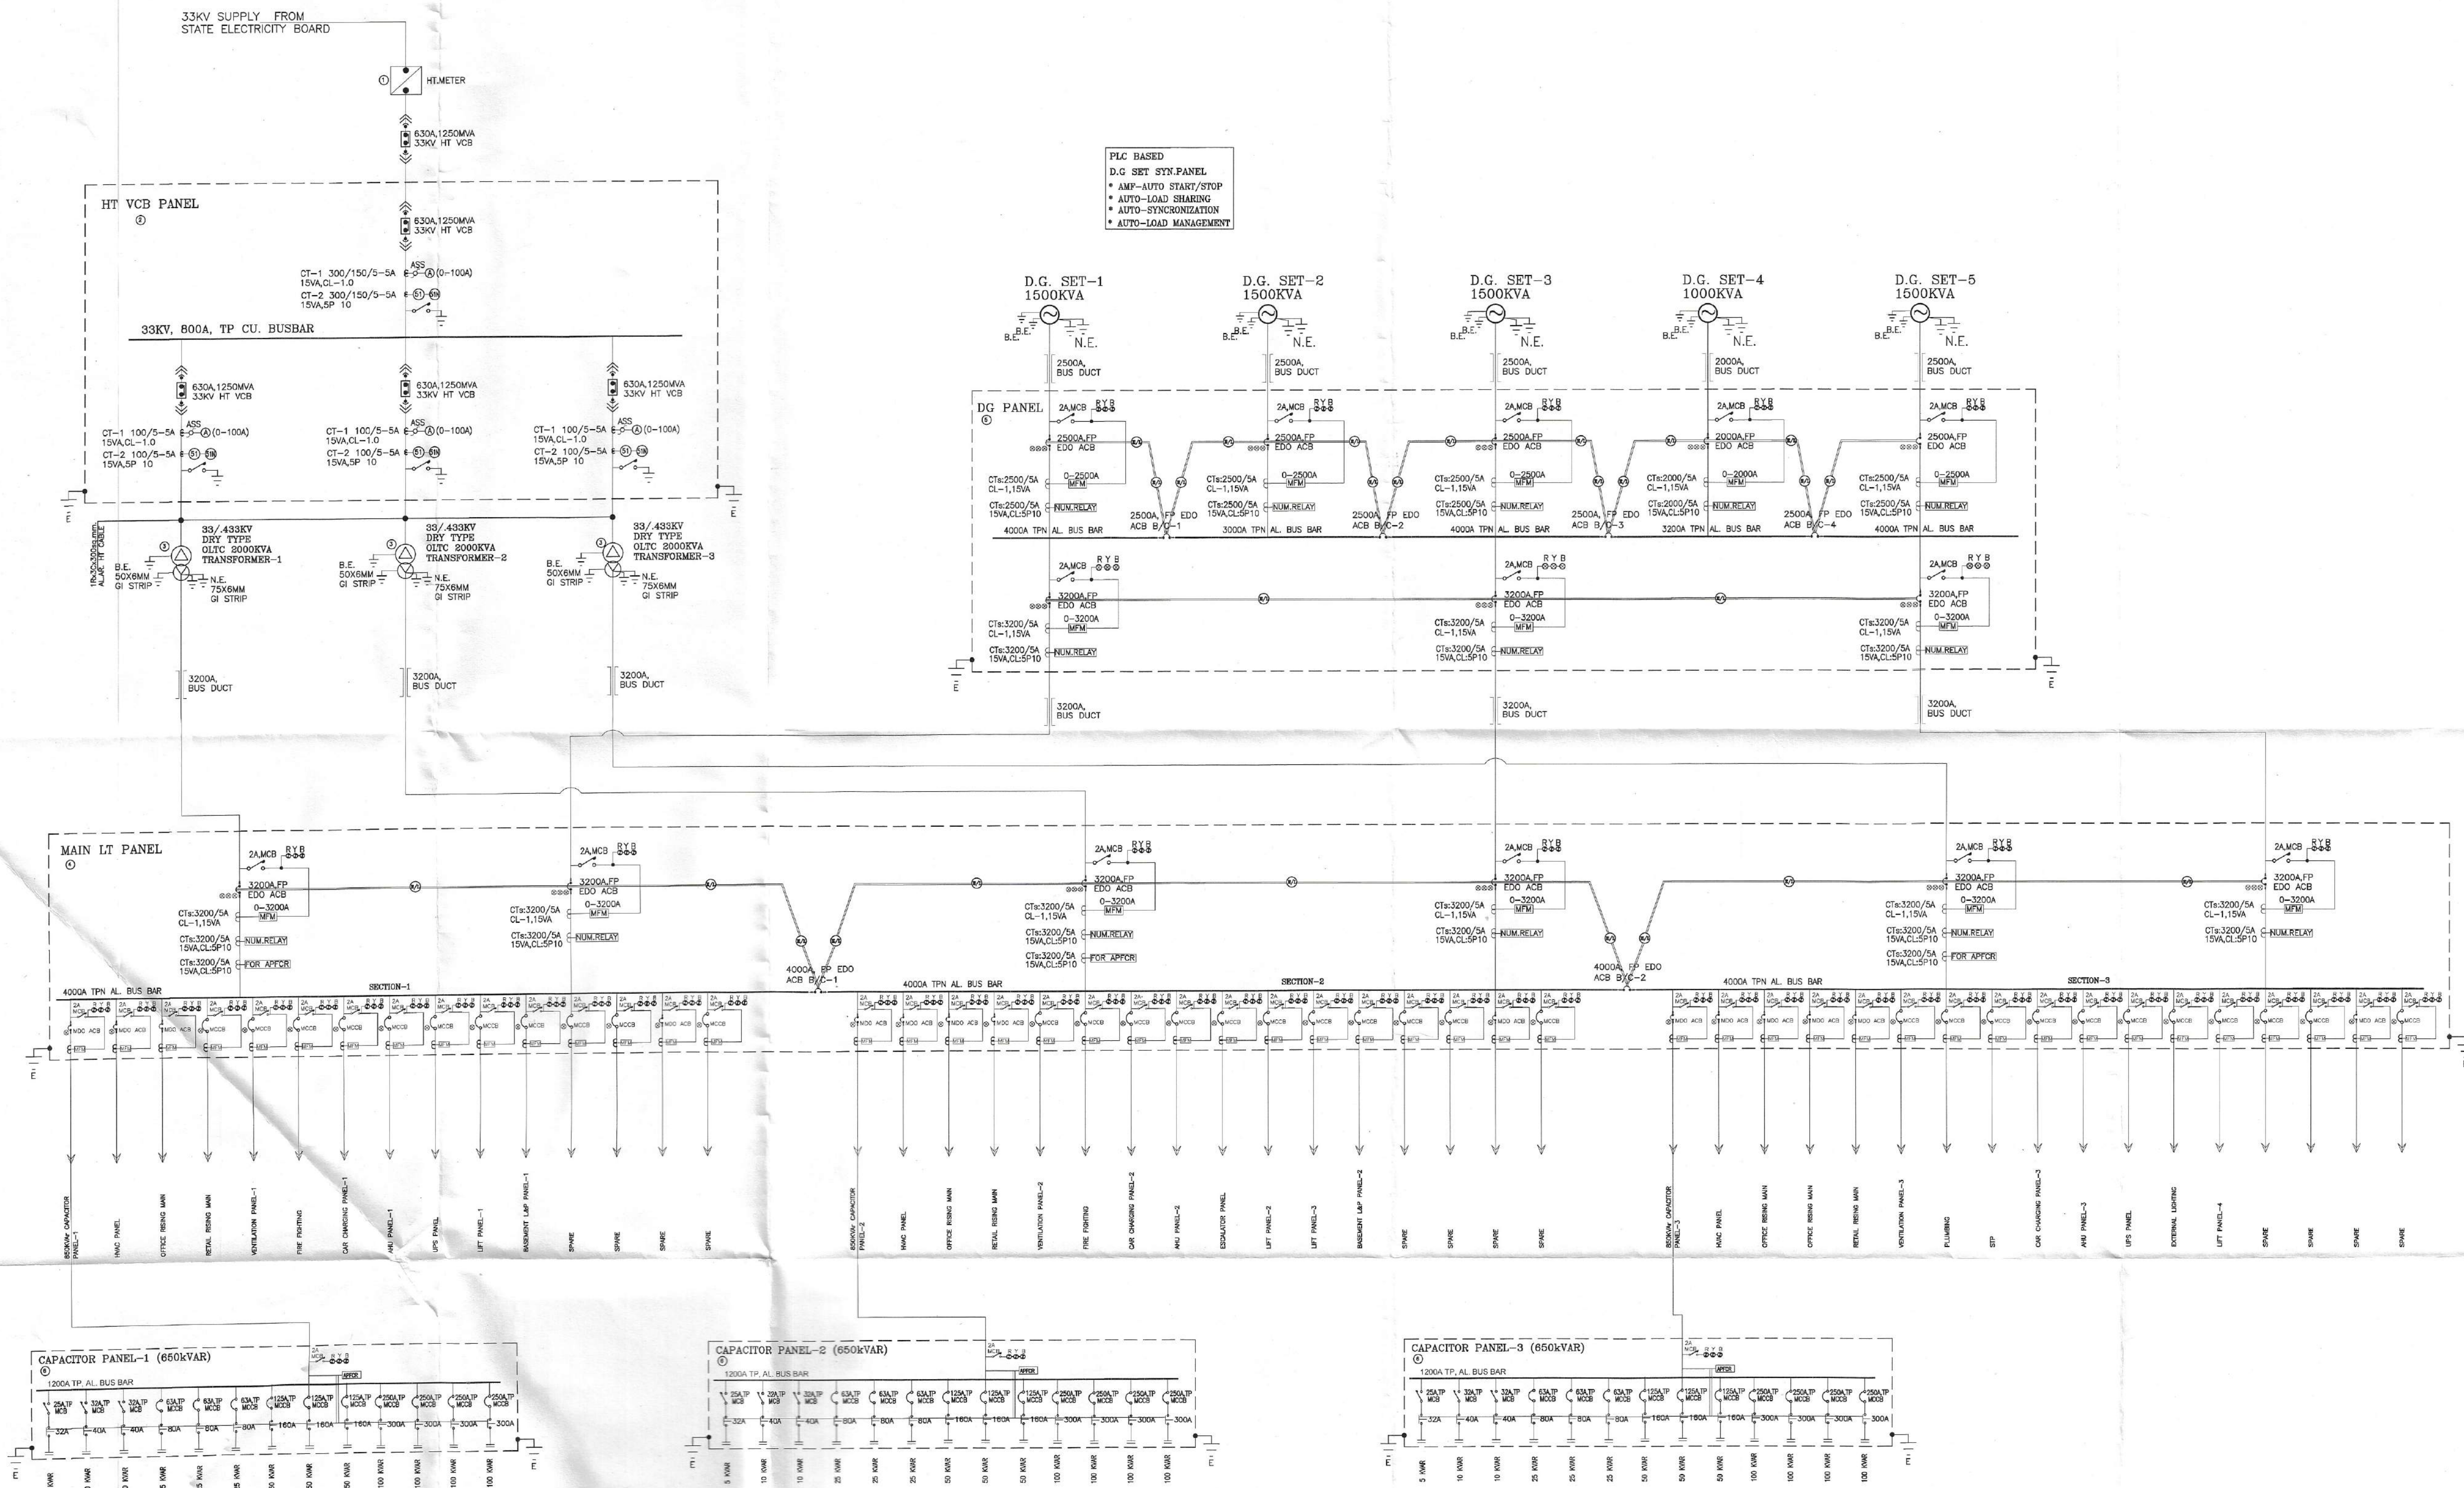

V Consulting
Fire Consultant
(Fire Fighting, Electrical & Ventilation)
B-50, Basement
Soami Nagar, New Delhi

LEGEND	
	CURRENT TRANSFORMER
	POTENTIAL TRANSFORMER
	VACUUM CIRCUIT BREAKER (VCB)
	HT FUSE
	AMMETER
	AMMETER SELECTOR SWITCH
	VOLT METER
	VOLTMETER SELECTOR SWITCH
	MOULDED CASE CIRCUIT BREAKER (MCCB)
	AIR CIRCUIT BREAKER(ACB)
	MINIATURE CIRCUIT BREAKER(MCB)
	LED INDICATING LAMPS
	KWH METER
	AUTO MANUAL SELECTOR SWITCH
	REVERSE POWER RELAY
	PHASE SEQUENCE RELAY
	CAPACITOR BANK
	TRANSFORMER
	D.G. SET
	ELECTRICALLY INTERLOCKED
	EARTHING
	MULTI FUNCTIONAL METER
	INDICATING LAMPS
	NUMERIC RELAY
OWNERS:	
SIFAL INFOTECH PVT. LTD W-111/A FIRST FLOOR, GREATER KAILASH PART-1, NEW DELHI - 110048	
PROJECT:	
SUBMISSION DRAWING FOR PROPOSED BUILDING ITHUM'S 73, ON PLOT NO.-04, AT SECTOR -73, NOIDA DISTRICT, GAUTAM BUDH NAGAR, UTTAR PRADESH.	
ARCHITECTS:	
ATWIN® BRIJ (INDIA) ARCHITECTS F-89, GREEN PARK, NEW DELHI -16. Ph. +91-11-26853815, 26858307, Fax : +91-11-26850788 E-mail : brijarch@rediffmail.com , info@atwin.in Website: www.atwin.in	
SHEET TITLE :	
ELECTRICAL LAYOUT MAIN SINGLE LINE DIAGRAM	
DEALT BY:	SCALE: N.T.S
	AR. ATRESH AGARWAL B. ARCH, DIP. REGD. (MGT) (LOND) F. I. I. V. CAT 71- A - 1879 M. C. A. - 2003 / 31212
APPLICANT'S SIGNATURE	ARCHITECT'S SIGNATURE