


NOTE-  
THIS DRAWING IS THE PROPERTY OF  
M/S RAJIVA KUMAR & ASSOCIATES AND ISSUED  
FOR THE SPECIFIC PROJECT MENTIONED FOR  
THE OTHER PROJECTS UNLESS THEREIN. THIS  
IS NOT TO BE COPIED OR USED EXPRESSLY  
PERMITTED BY THE ARCHITECT.

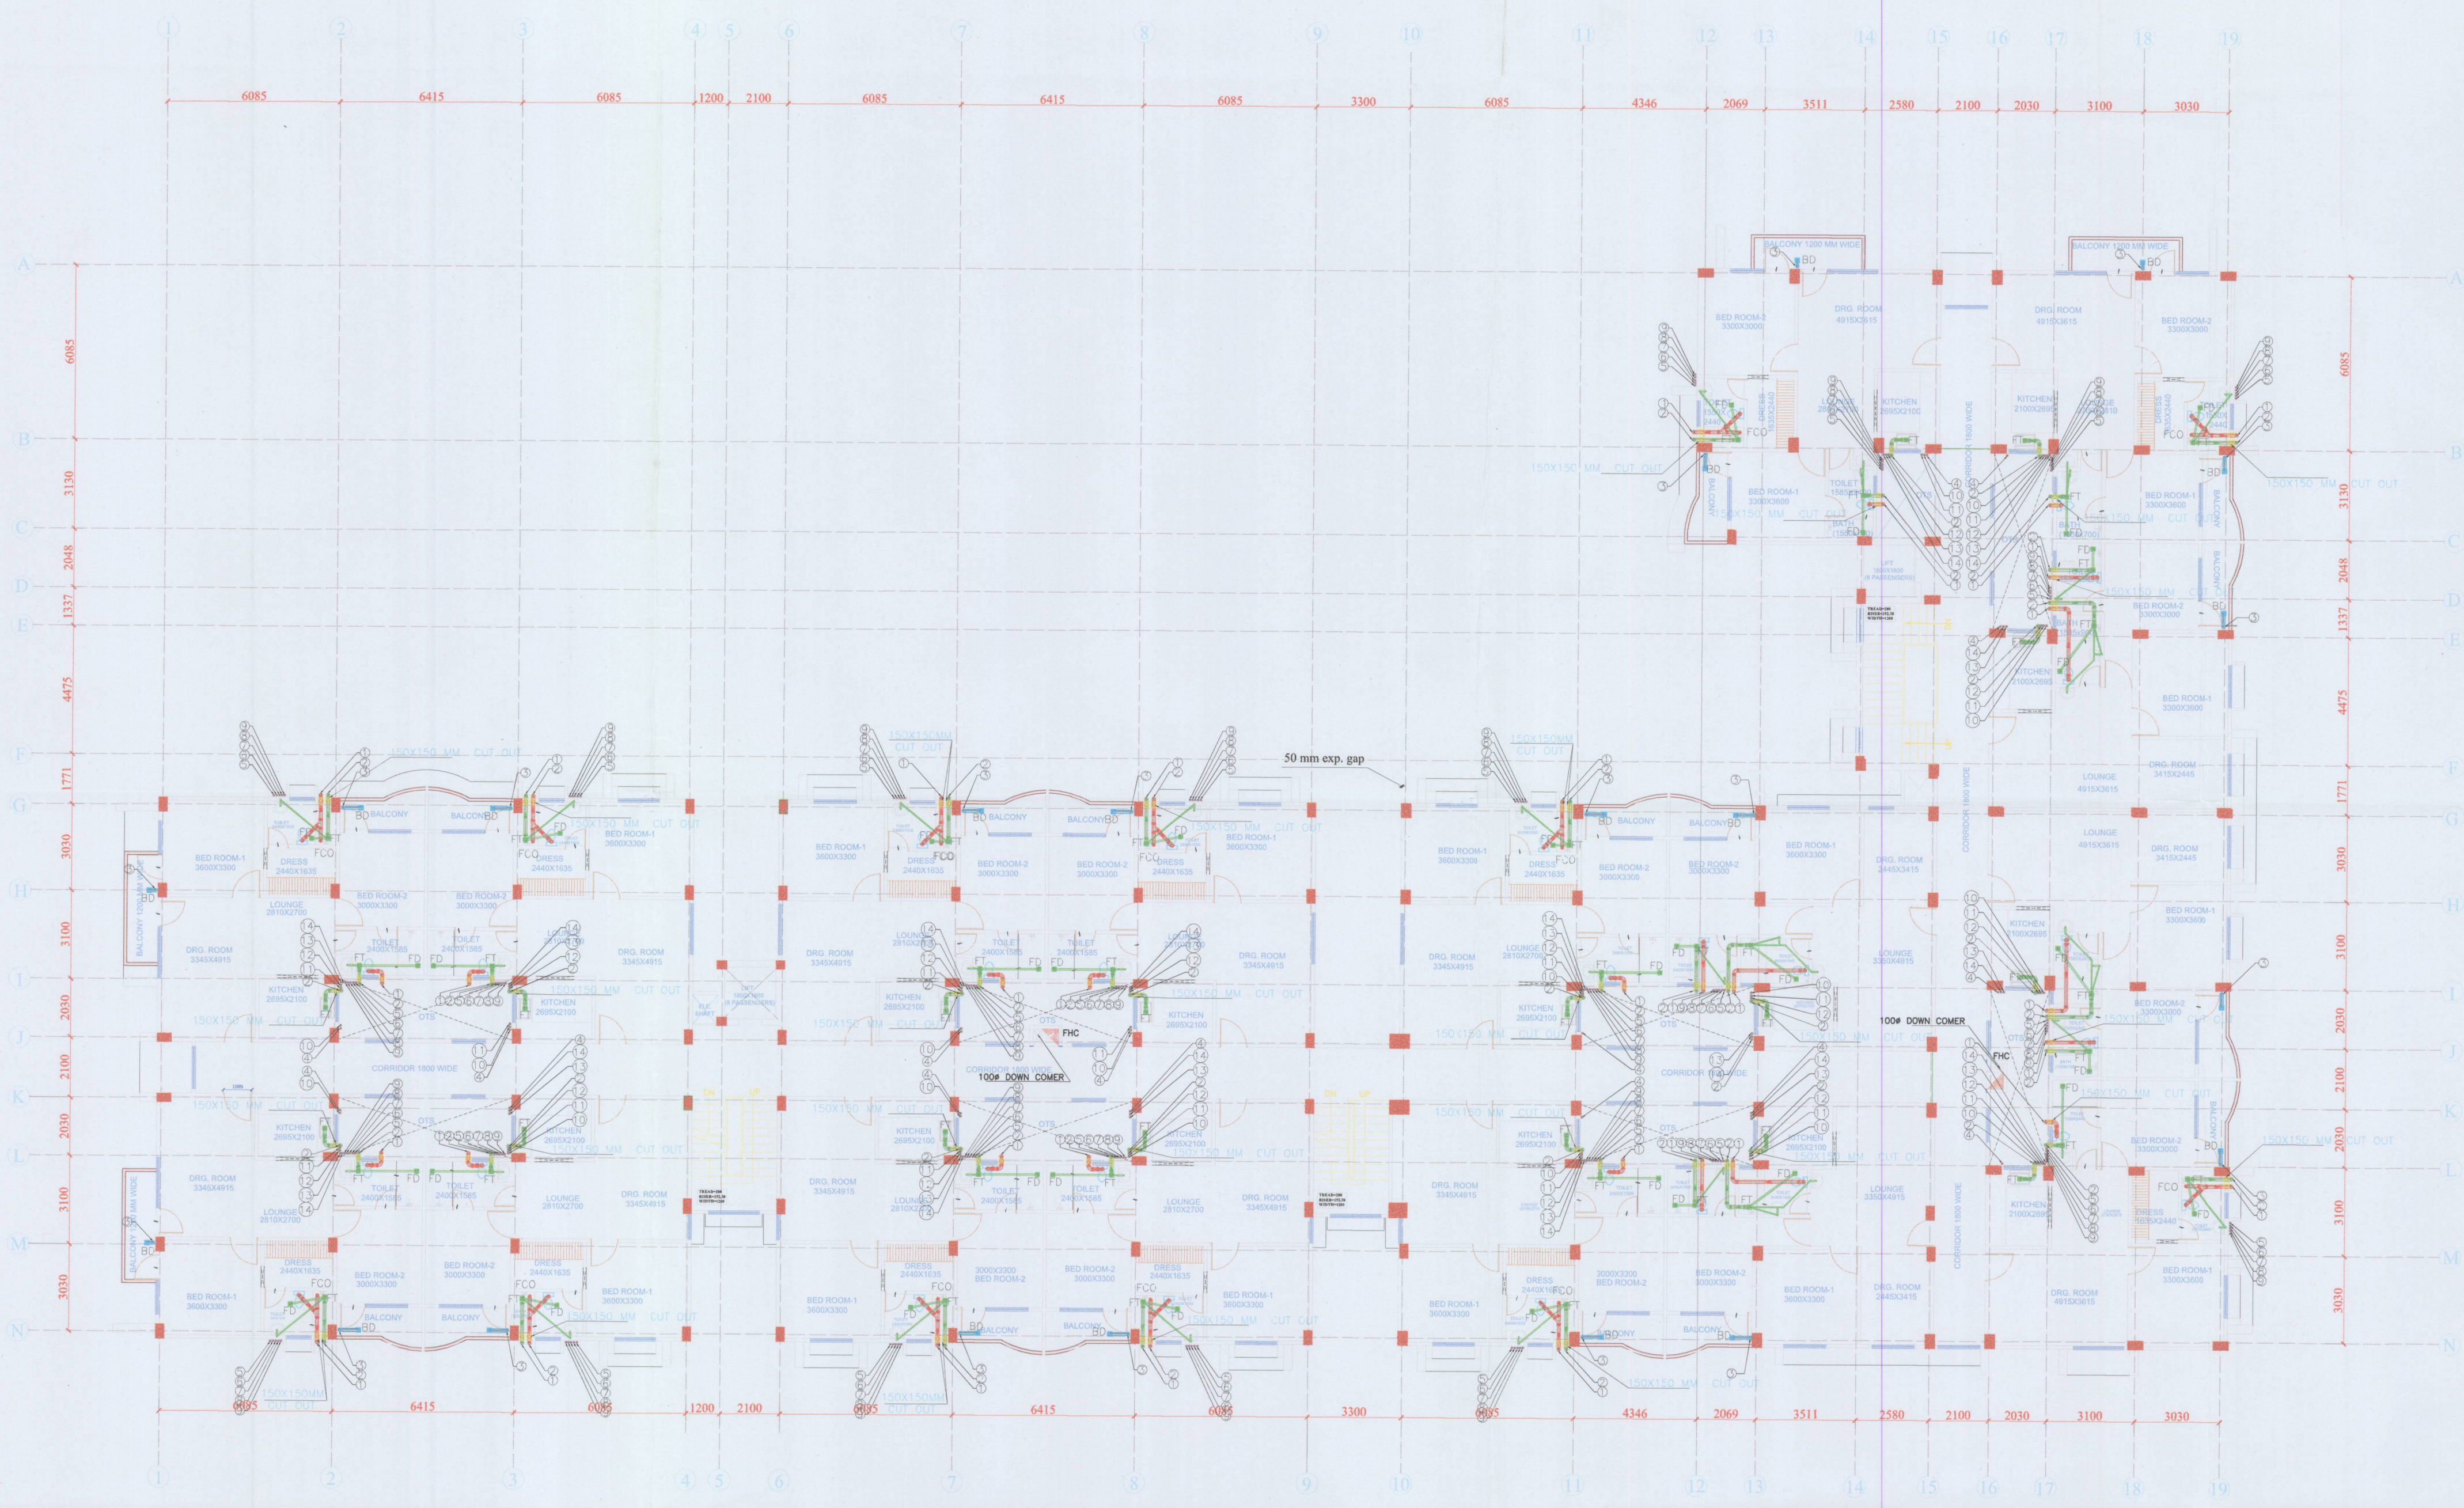

NOTES	
1.	W.C TO SOIL STACK 100Ø H.C.I PIPE
2.	F.T TO WASTE STACK 100Ø H.C.I PIPE
3.	F.D TO F.T 50Ø G.I WASTE PIPE
4.	WASH BASIN TO F.T 32Ø G.I WASTE PIPE
5.	KITCHEN SINK TO F.T 50Ø G.I WASTE PIPE
6.	F.T TO G.T 100Ø H.C.I WASTE PIPE
7.	SOIL STACK TO M.H 100Ø H.C.I PIPE
8.	WASTE STACK TO G.T 100Ø H.C.I PIPE
9.	G.T TO M.H 150Ø S.W. PIPE
10.	M.H TO M.H 250Ø R.C.C. PIPE

LEGEND	
1.	100Ø SOIL & VENT PIPE
2.	100Ø WASTE & VENT PIPE
3.	100Ø RAIN WATER PIPE
4.	Ø CWS RISER
5.	Ø CWS DN. TK. PIPE 1st FLOOR
6.	Ø CWS DN. TK. PIPE 2nd FLOOR
7.	Ø CWS DN. TK. PIPE 3rd FLOOR
8.	Ø CWS DN. TK. PIPE 4th FLOOR
9.	Ø CWS DN. TK. PIPE 5th FLOOR
10.	Ø HWS DN. TK. PIPE 1st FLOOR
11.	Ø HWS DN. TK. PIPE 2nd FLOOR
12.	Ø HWS DN. TK. PIPE 3rd FLOOR
13.	Ø HWS DN. TK. PIPE 4th FLOOR
14.	Ø HWS DN. TK. PIPE 5th FLOOR

Plumbing and Fire Protection Consulting Services  
**SYSTEM CONSULTANCY SERVICES**  
F - 1/240, 1st Floor Sector 16, Rohini  
Email: writetoscs@gmail.com

References	

Revisions	

PROPOSED  
SAMA JWADI AWAS  
YOJNA-AFFORDABLE  
HOUSING AT LOHIA  
NAGAR, MEERUT

WORKING DRAWING

Client  
**MEERUT DEVELOPMENT  
AUTHORITY**

Building Title  
M.I.G.(2 BHK FLATS)  
BLOCK-A


Drawing Title  
TYPICAL FLOOR PLAN  
PLUMBING LAY OUT PLAN

Drg. No.  
MDAH/SAY/A/PB-01

Scale  
1:100

Date  
15 JULY 2015

Drawn By  
KARAN

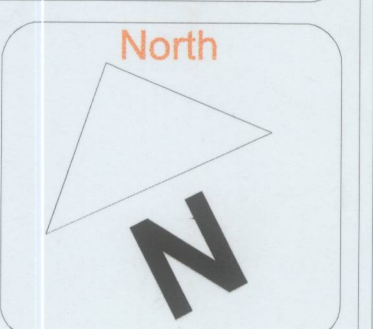

Issued To  
IMRAN

Architect  
PH. No.  
2721555, 56

**RAJIVA KUMAR  
&  
ASSOCIATES**  
B-46, VIBHUTI KHAND, GOMTI NAGAR,  
LUCKNOW.