
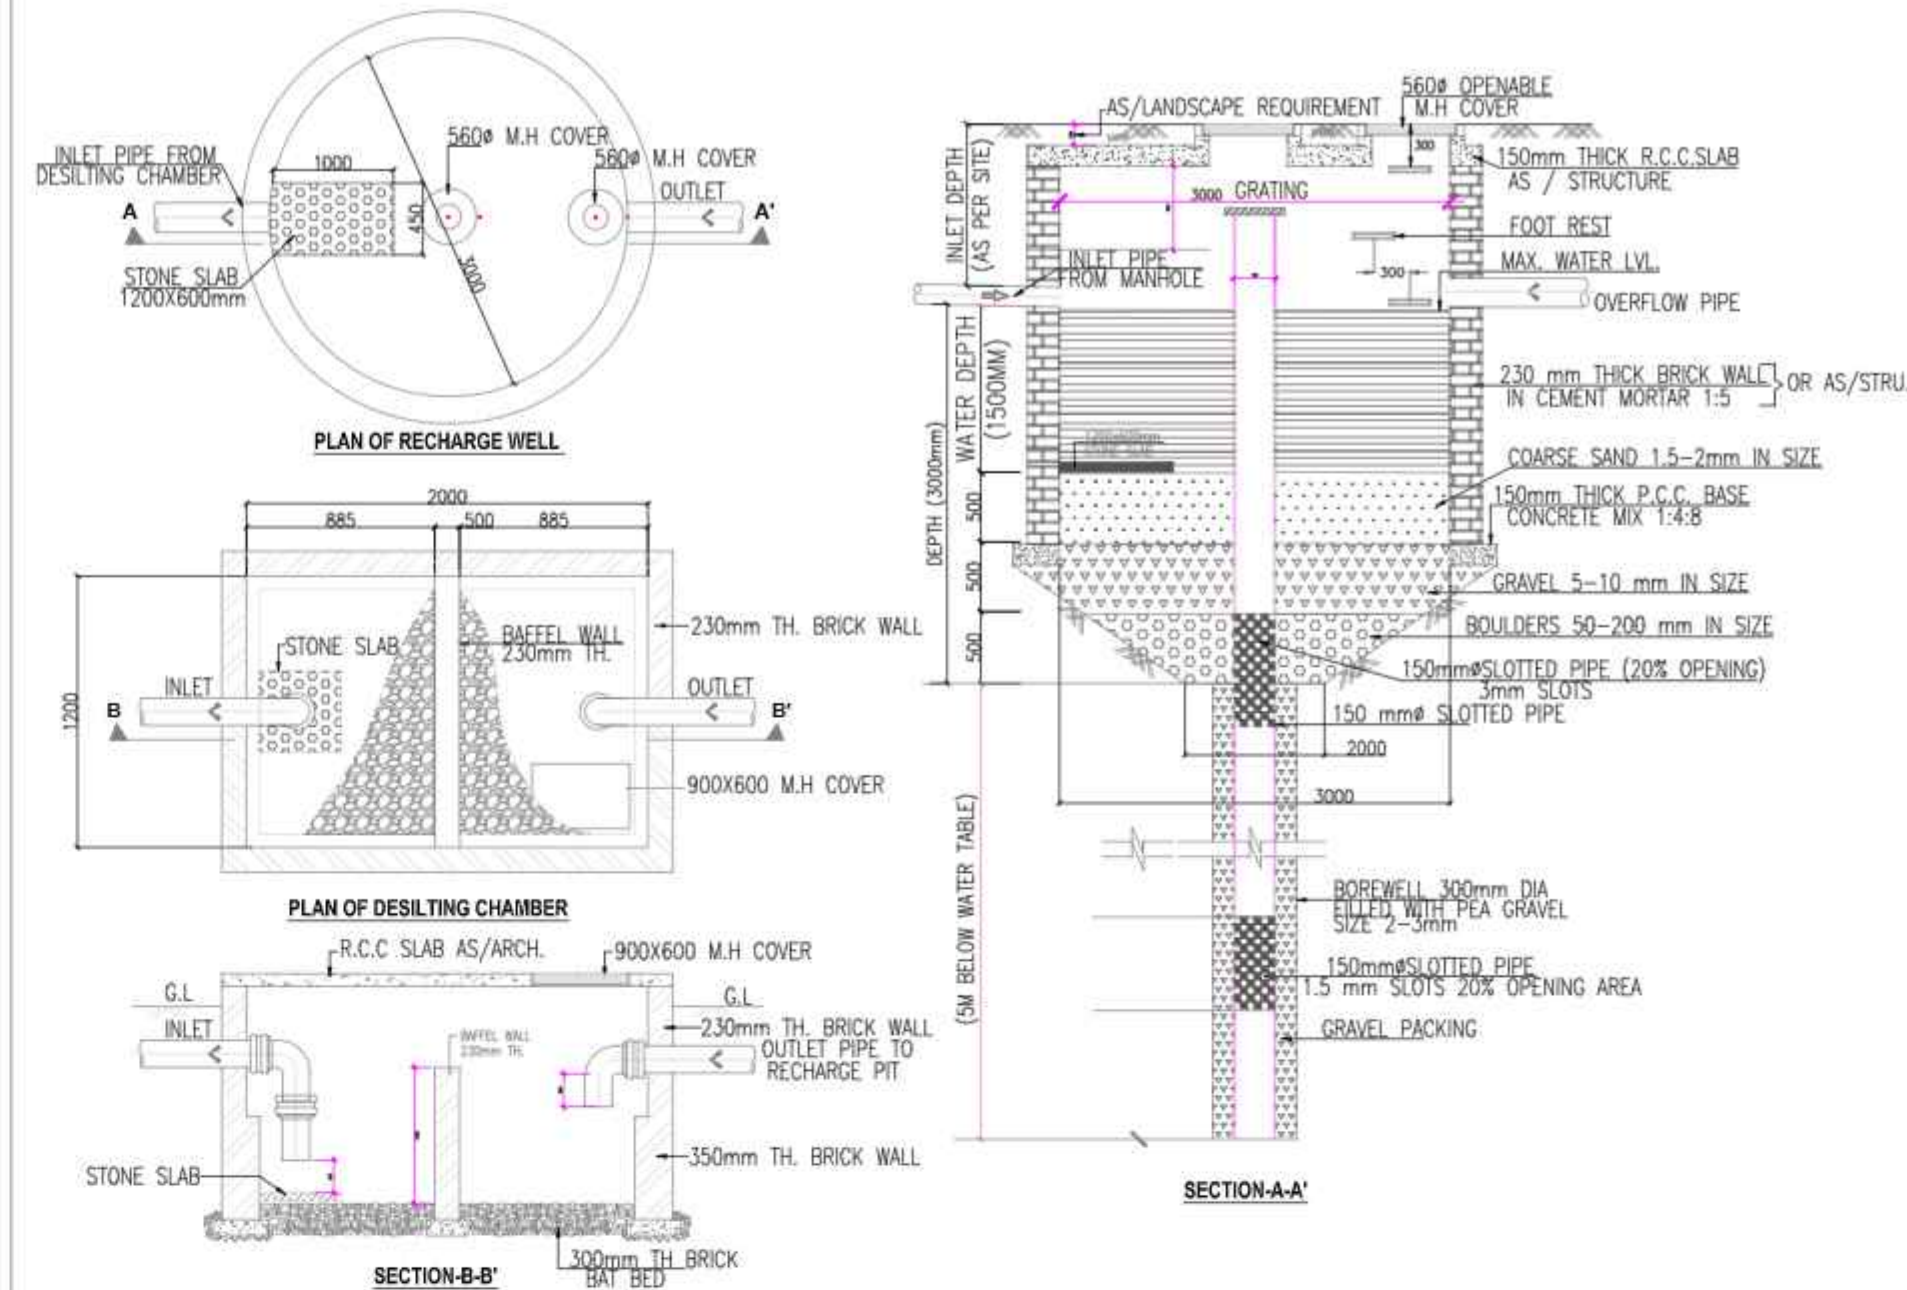


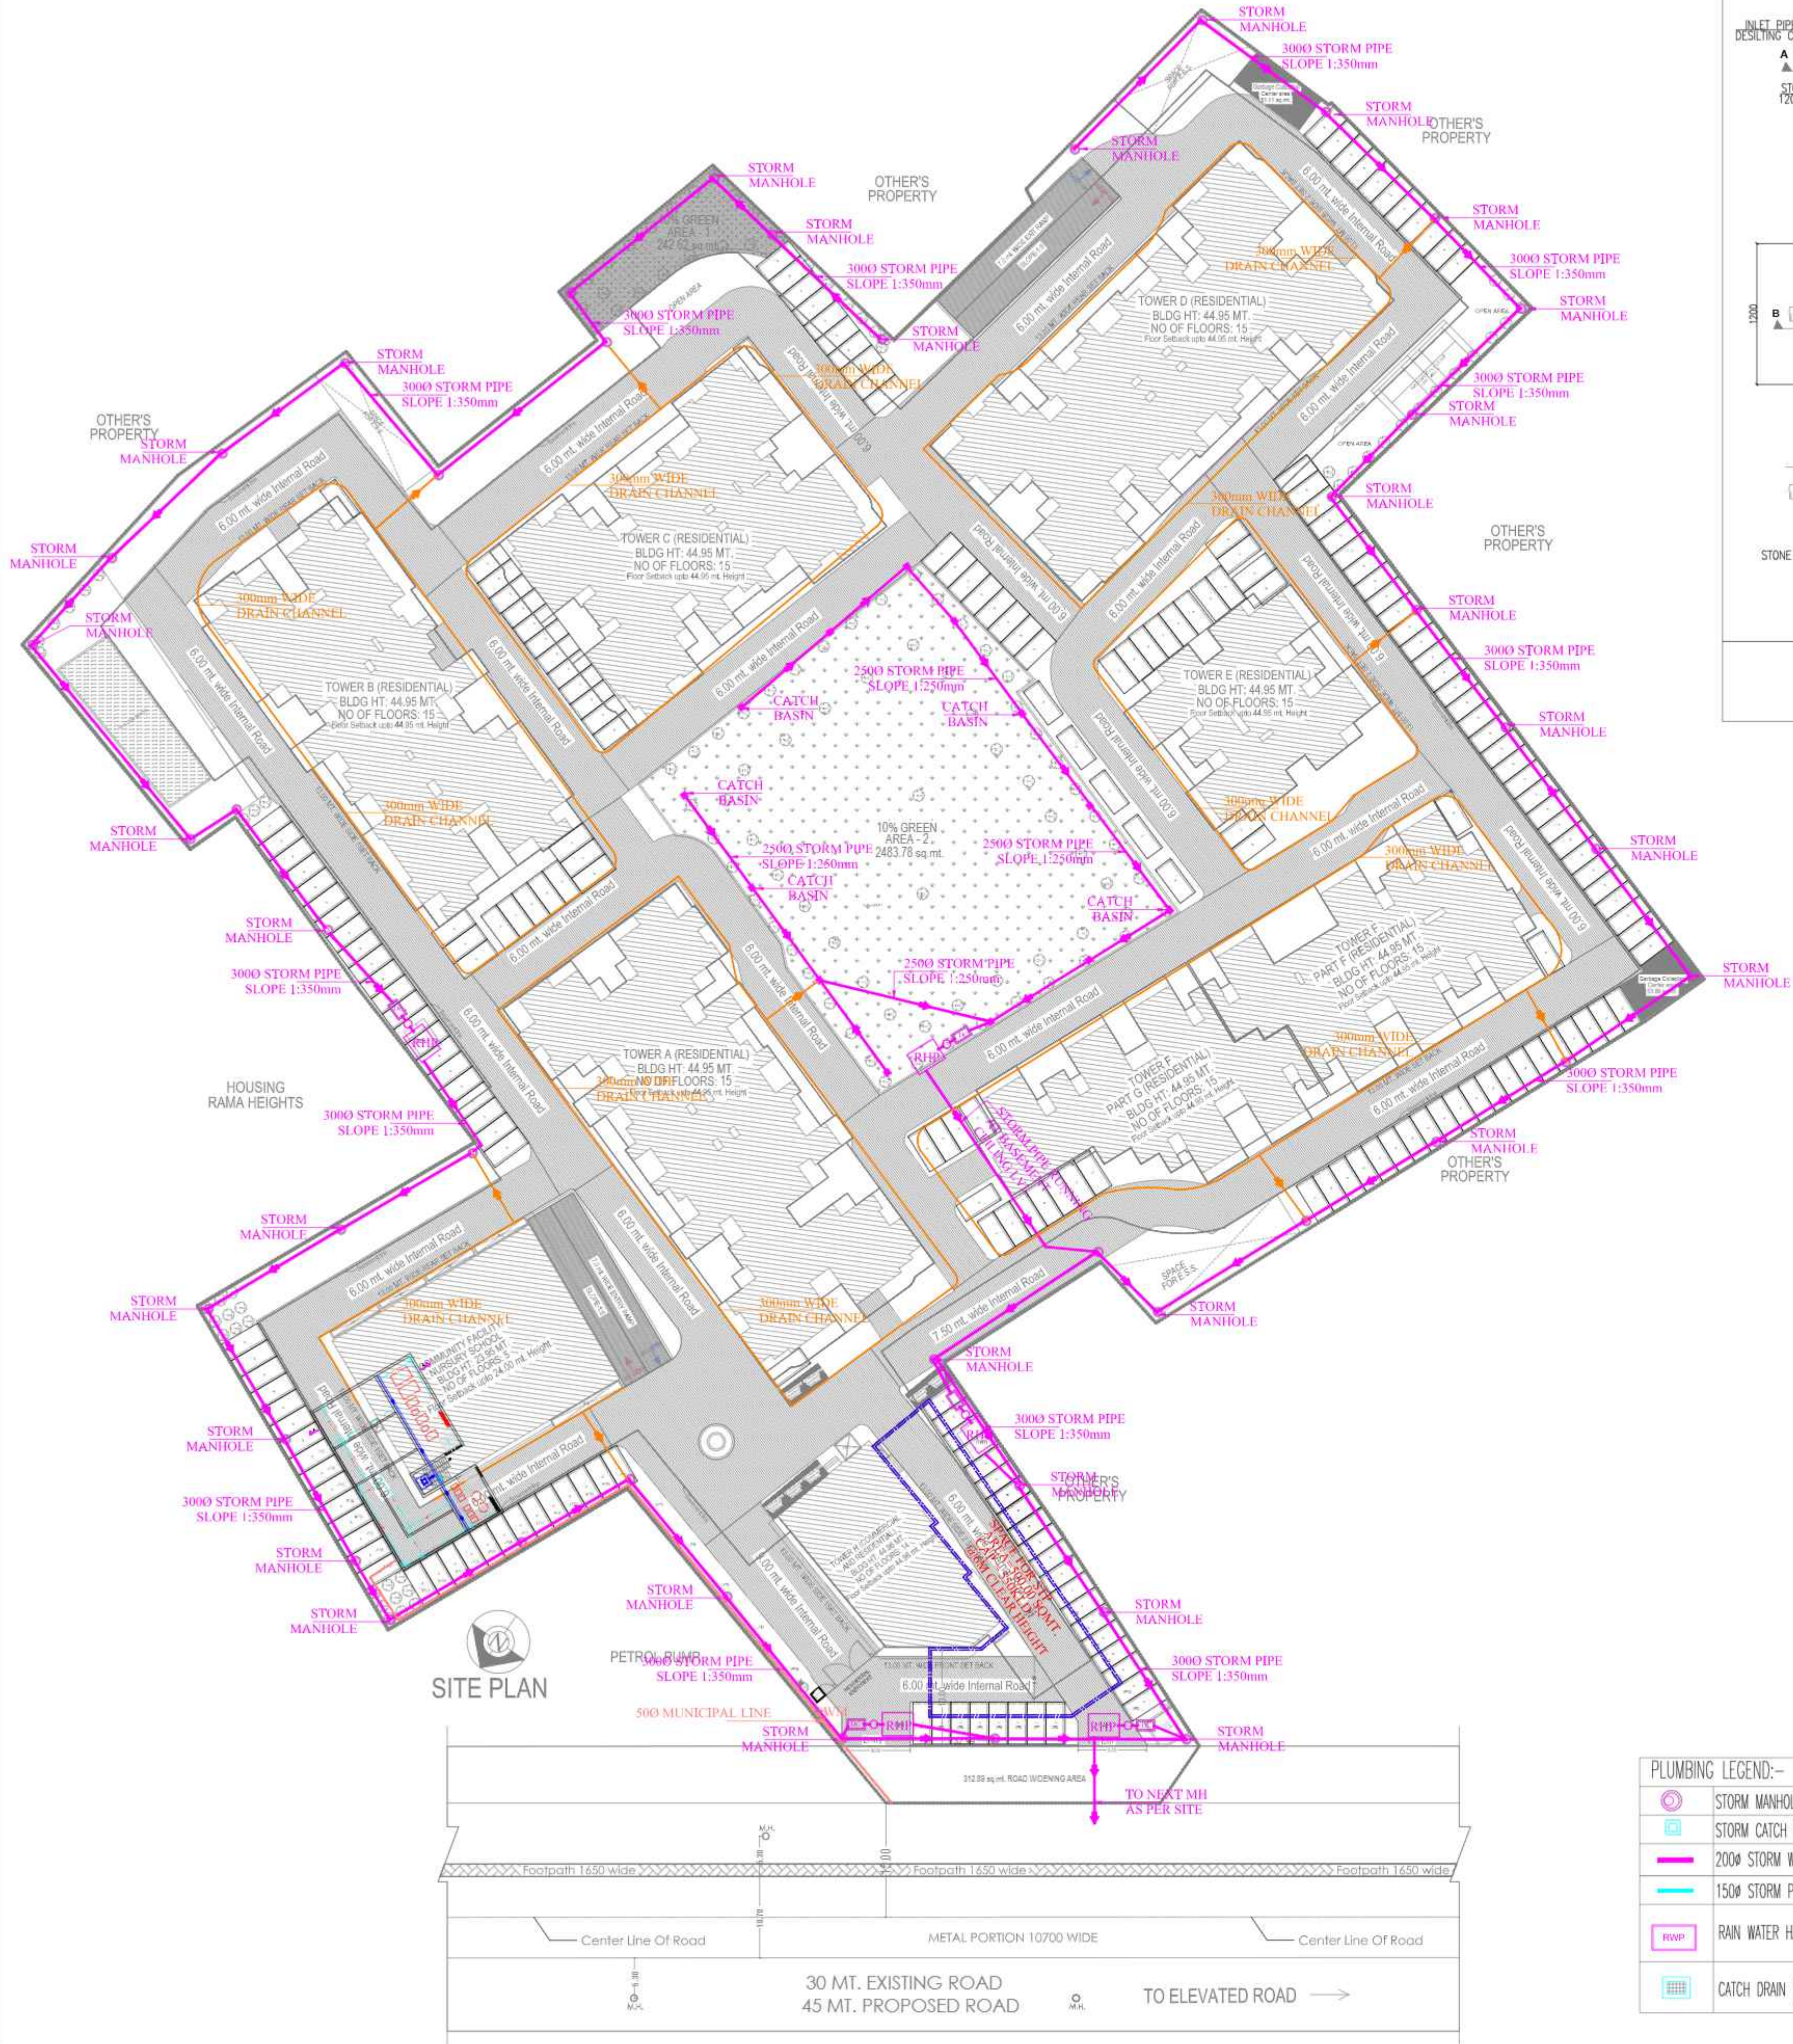

RAIN WATER HARVESTING DETAIL

PROJECT TITLE :-
SUBMISSION DRAWINGS FOR THE PROPOSED GROUP HOUSING
PROJECT "UNINAV RESIDENA" AT KHASRA NO. - 254, 259, 260,
261, 262, 263, 264, 265, 266, 306m, 307m, 354, 355, 356, 357,
358, 373, 374 & 377 VILLAGE NOOR NAGAR, GHAZIABAD (U.P.)

OWNER - M/s. :-
UNINAV BUILDCON PVT. LTD.
(formerly known as)
KW DREAM HOMES CONSORTIUM PRIVATE LIMITED)
Through - Mr. : ANOOP GARG

DRAWING TITLE :-
WATER DISPOSAL PLAN
STORM LAYOUT/RAIN WATER HARVESTING PLAN

PLUMBING LEGEND:-	
	STORM MANHOLE(910mm & ABOVE)
	STORM CATCH BASIN
	200mm STORM WATER LINE
	150mm STORM PIPE
	RAIN WATER HARVESTING PIT
	CATCH DRAIN (600X300X450mm)

PLUMBING NOTE FOR STORM WATER :-	
CATCH BASIN SIZE (MM)	DEPTH OF CB (MM)
CB - 600 X 600 mm	600 - 750 mm
CB - 750 X 750 mm	750 TO 900 mm
Plumbing Note :-	
DIA OF M.H.	DEPTH OF MH
910mm Dia	900 TO 1650
1220mm Dia	1650 TO 2300
1520mm Dia	2300 & ABOVE

OWNER SIGN.

ARCHITECT'S SIGN.

ANUJ AGARWAL ARCHITECTS
OFFICE:- A-244 KAUSHAMBI GHAZIABAD (U.P.)
Ph:-0120 - 4165716 , 4563716 , 6454182
e-mail : arch.anujagarwal@gmail.com

SCALE

DESIGN BY

DEALT BY

CHECKED BY

DATE

DRG. No.

SD- 03