


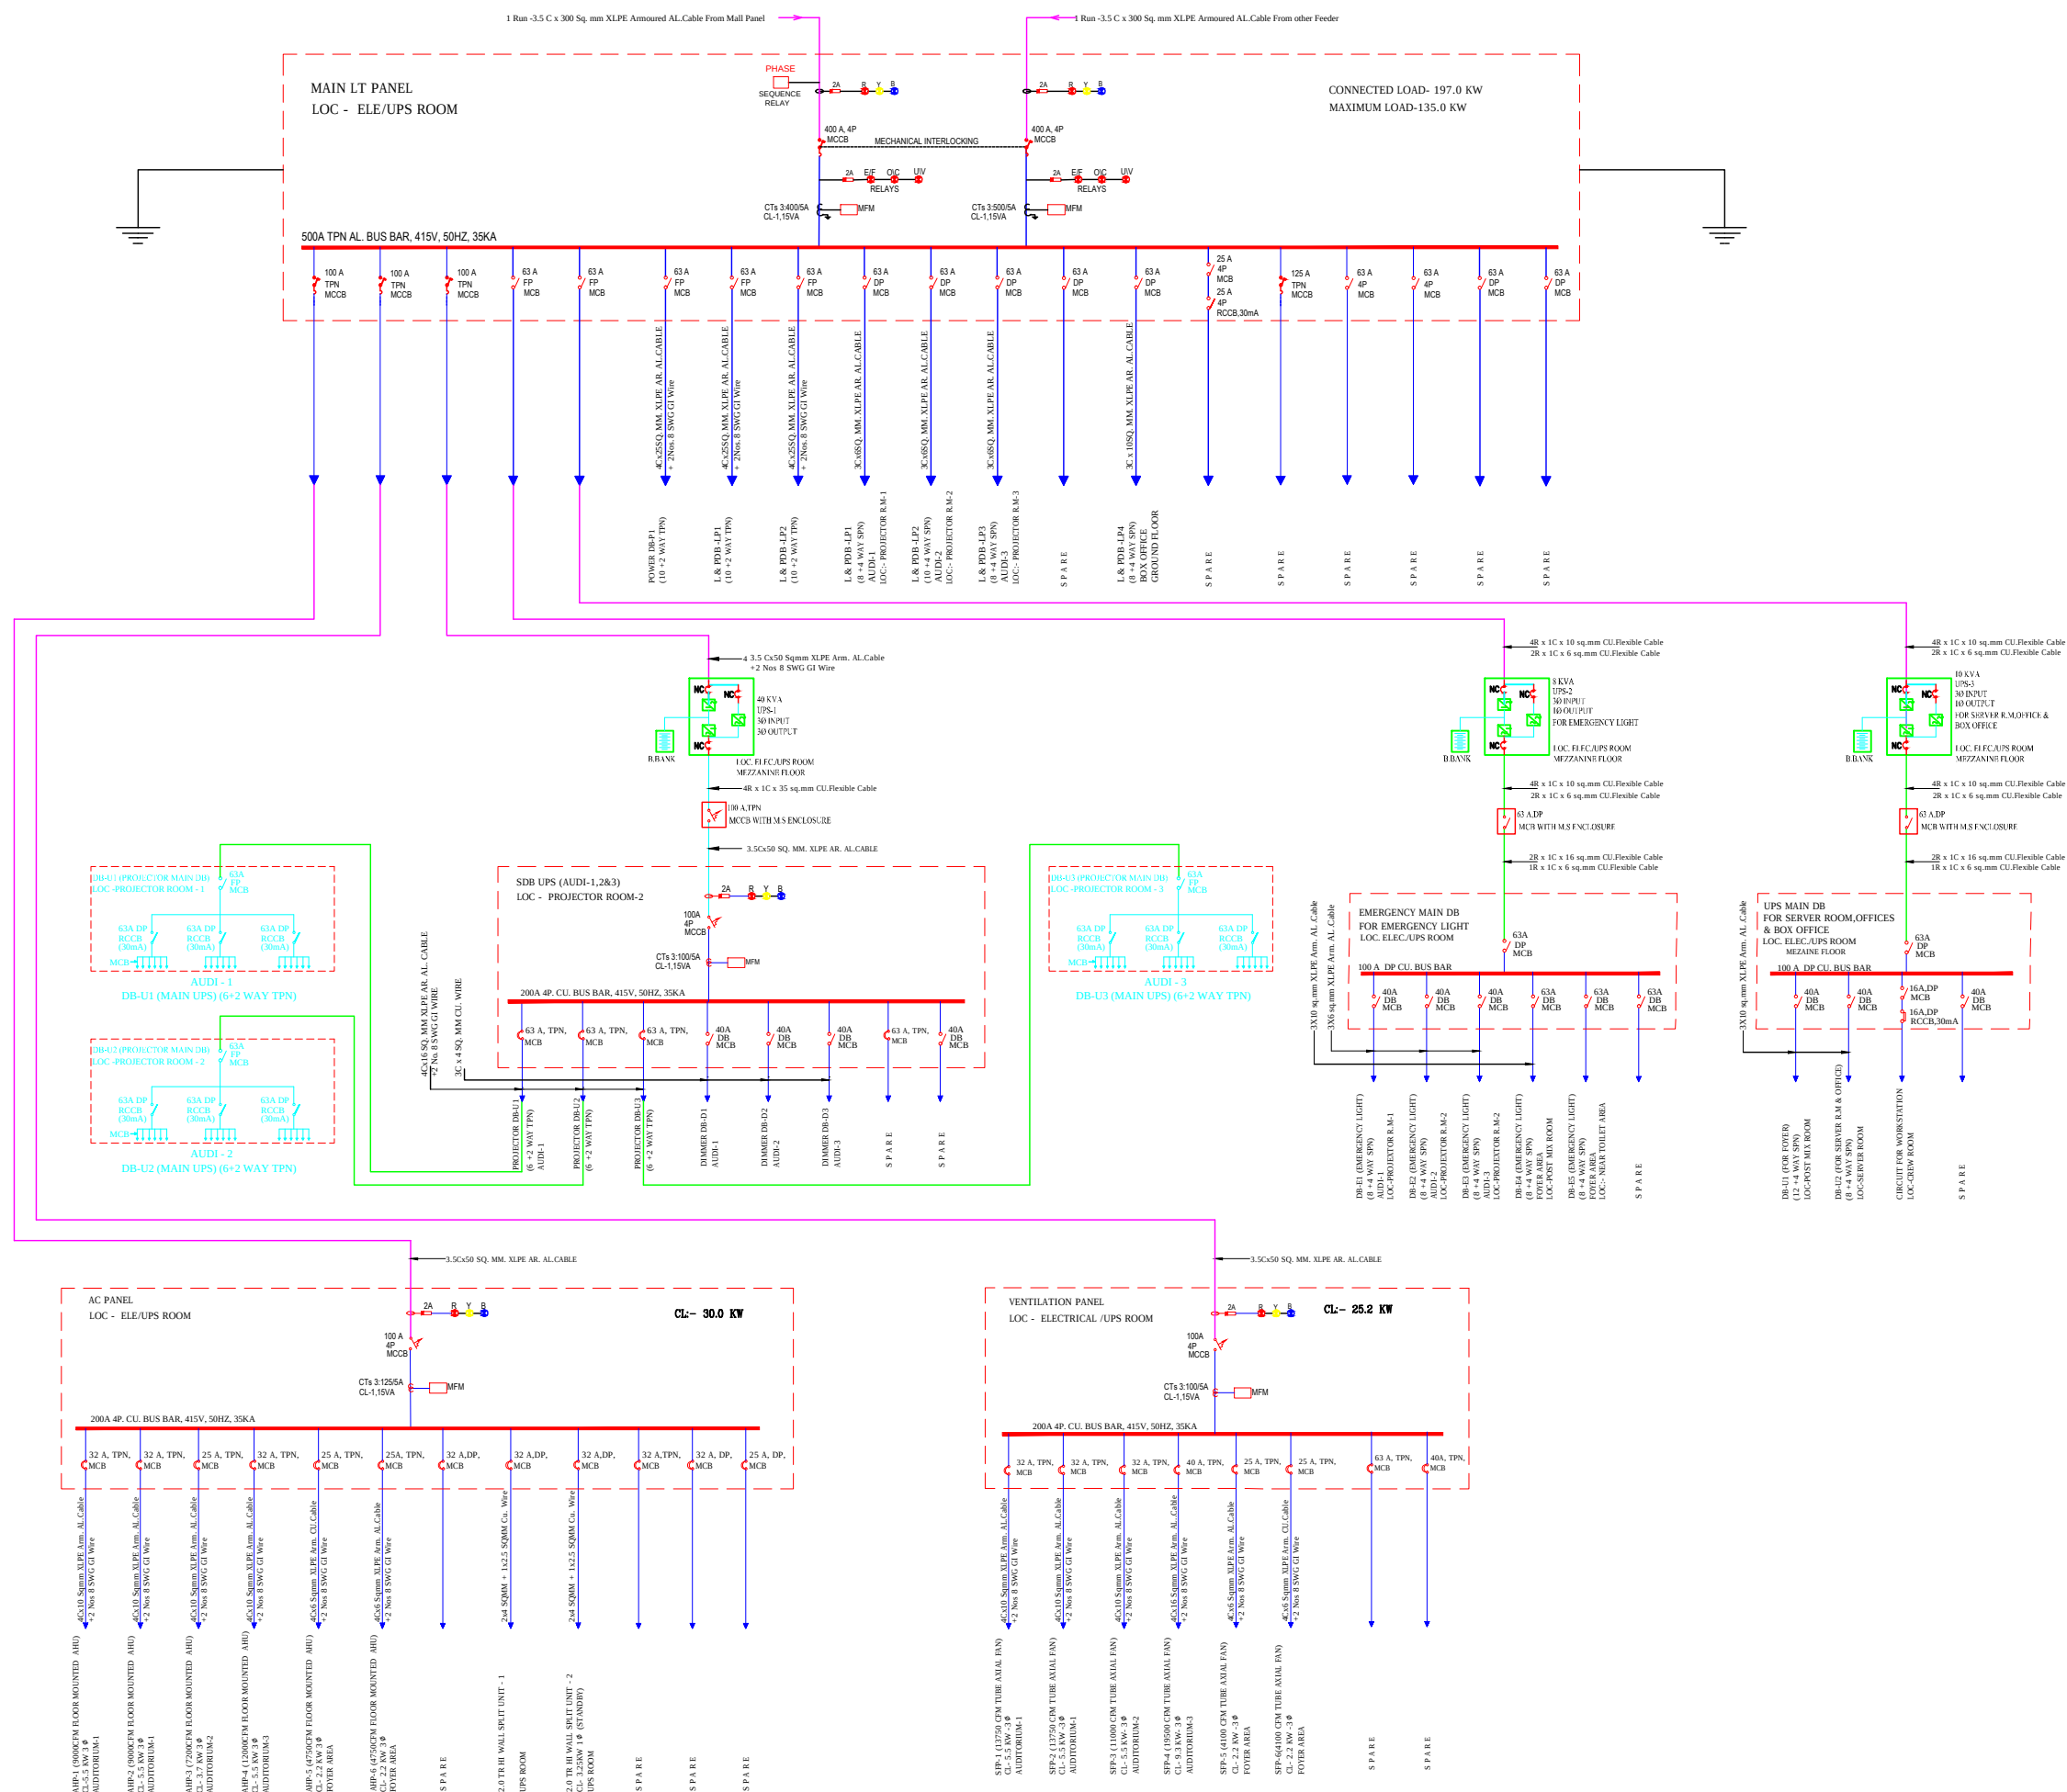


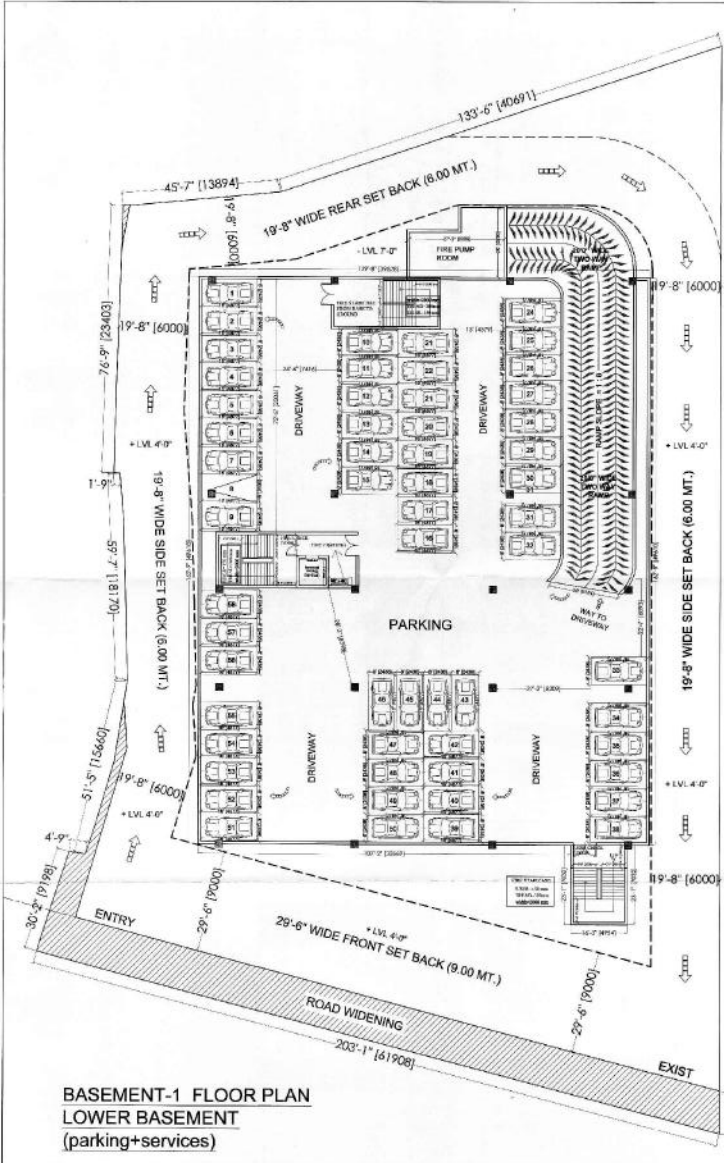

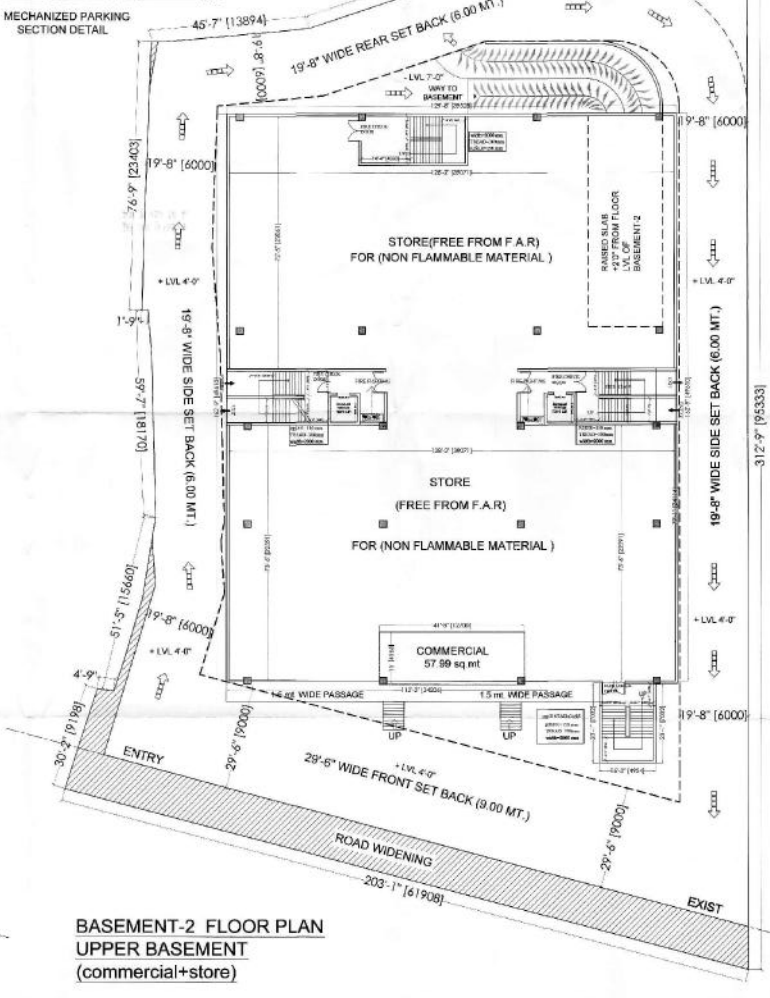

BASEMENT-1 FLOOR PLAN
LOWER BASEMENT
(parking+services)

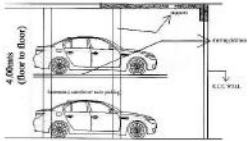

BASEMENT-2 FLOOR PLAN
UPPER BASEMENT
(commercial+store)

STAMP OF APPROVAL



PROJECT TITLE:

PROPOSED COMMERCIAL
& MULTIPLEX FOR
LAND OWNER - KUWAR KAMESHWAR SINGH
BUILDER - SUPERLATIVE MARKETING PVT LTD
GATA NO 952/2 RAKSA 4022 SQ.MT
MAUIZA - BASTI KHAS, TAPPA - HAVELI
TEHsil AND DISTRICT - BASTI





sheet number 02

SCALE: 1:200 (1"=16')


DWN BY: [signature] CHKD BY: [signature]

OWNER SIGN: [signature]
ACORE ARCHITECTURAL SERVICES PVT. LTD
BASTI DIST. BASTI KHAS
BRANCH OFFICE: 100/100 ANKAL, BASTI
CORPORATE OFFICE: 100/100 ANKAL, BASTI
TEL.: OFF. 3284813, RES. 225290, MOBILE 9415321836



ELECTRICAL PLAN

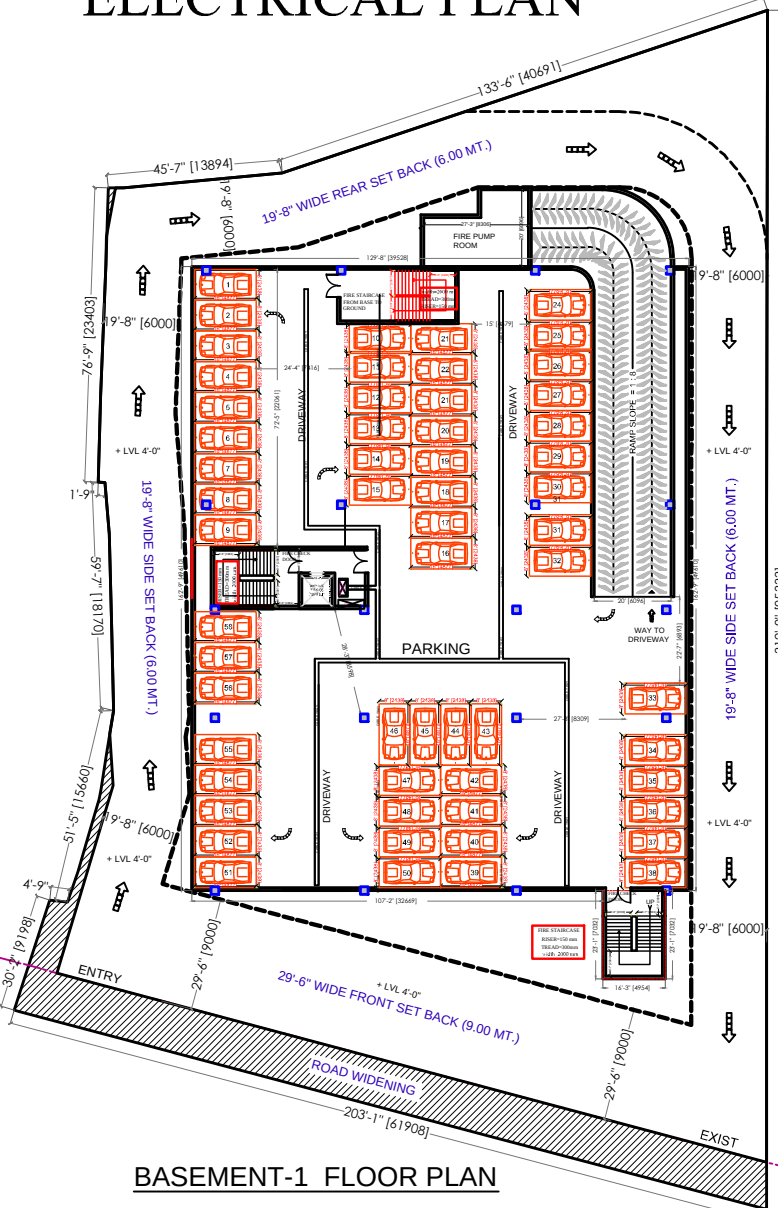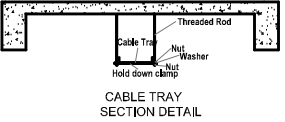

BASEMENT-1 FLOOR PLAN

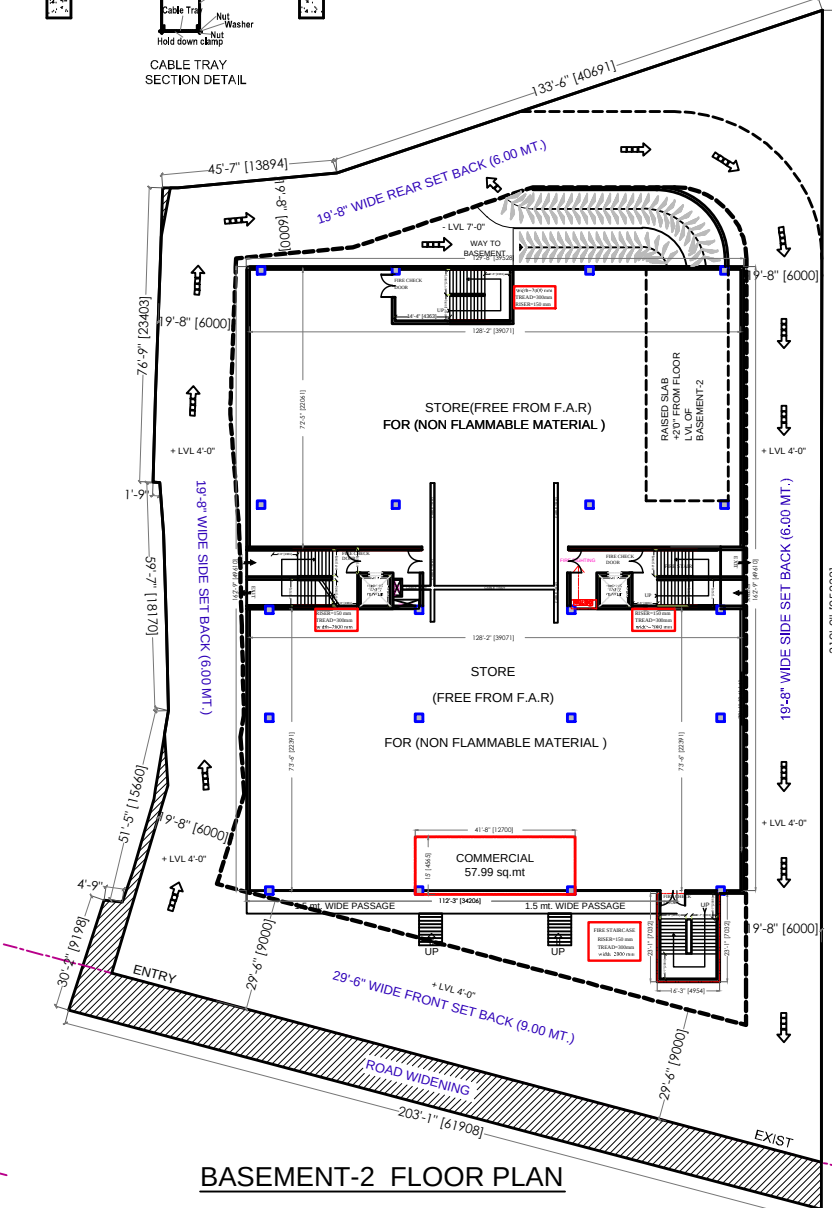

BASEMENT-2 FLOOR PLAN

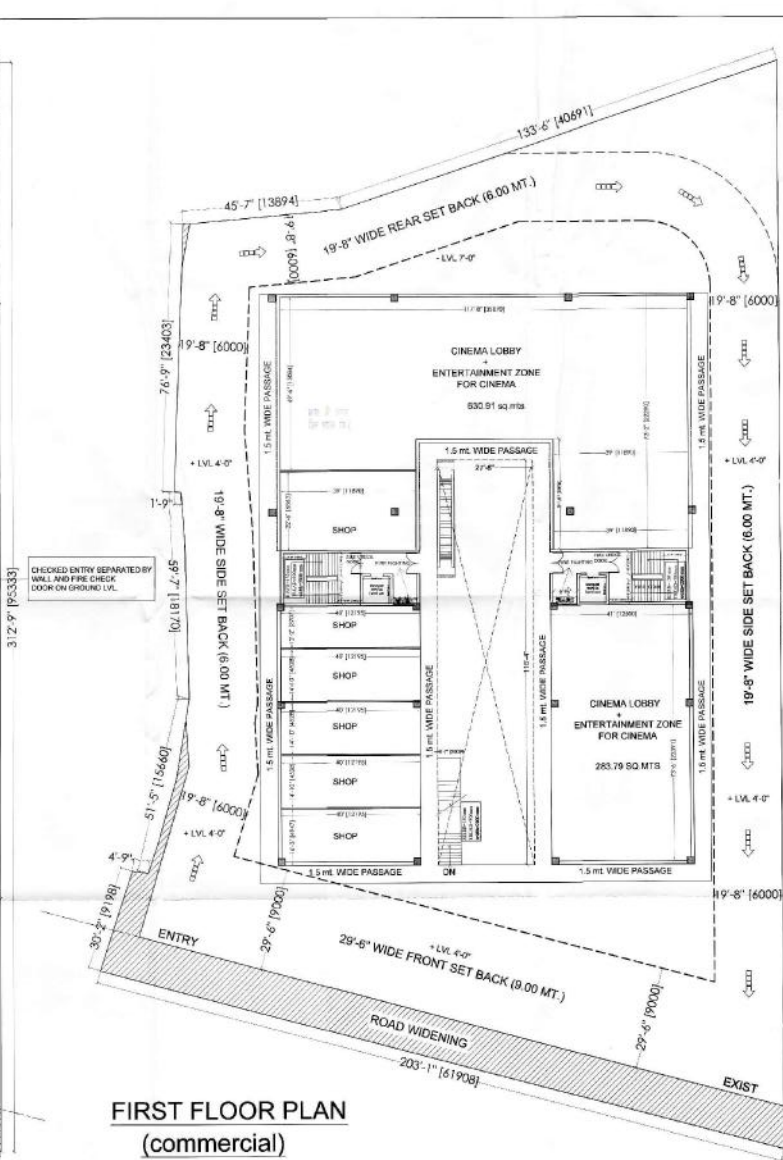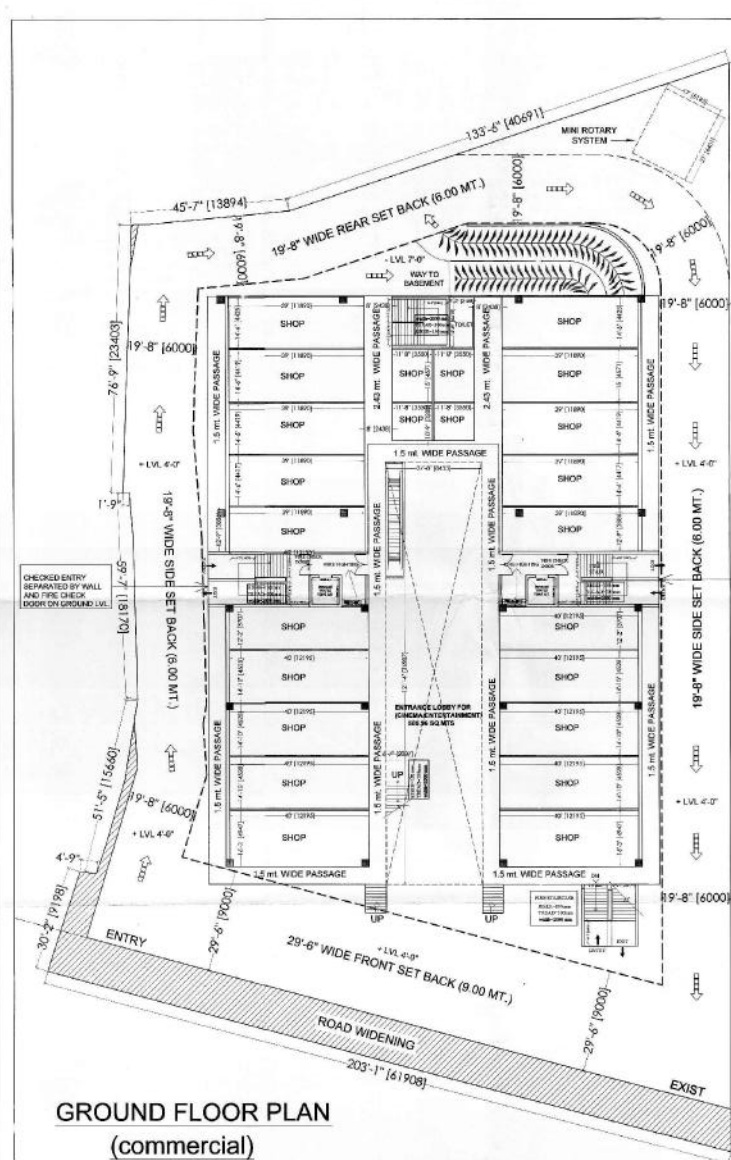

STAMP OF APPROVAL



PROJECT TITLE: नौट सिम्पलवर्किंग हस्तश्रम पर ओकित

PROPOSED COMMERCIAL,
& MULTIPLEX FOR
LAND OWNER - KUWAR KAMESHWAR SINGH
BUILDER - SUPERLATIVE MARKETING PVT LTD
GATA NO 952/2 RAKBA 4022 SQ.MT
MAUZA - BASTI KHAS, TAPPA - HAVELI
TEHSIL AND DISTRICT - BASTI



sheet number	she
--------------	-----

SCALE: 1" = 1'-0"

DWN BY:	CKD BY:
---------	---------

OWNER SIGN: *K. Gumbert*

ACORE ARCHITECTURAL SERVICES PVT. LTD.

ARCHITECT ASHISH SRIVASTAVA
(B. ARCH)

BRANCH OFFICE, 9510 MATRI ANCHAL, MAHARASHTRA
GUJARINATHI TRAIL WAY CROSSING GORAKH...

TEL: OFF-3294813, RES-2255290, MOBILE-941532183

TEL: OFF: 3254813, RES: 2255290, MOBILE: 941532103

