


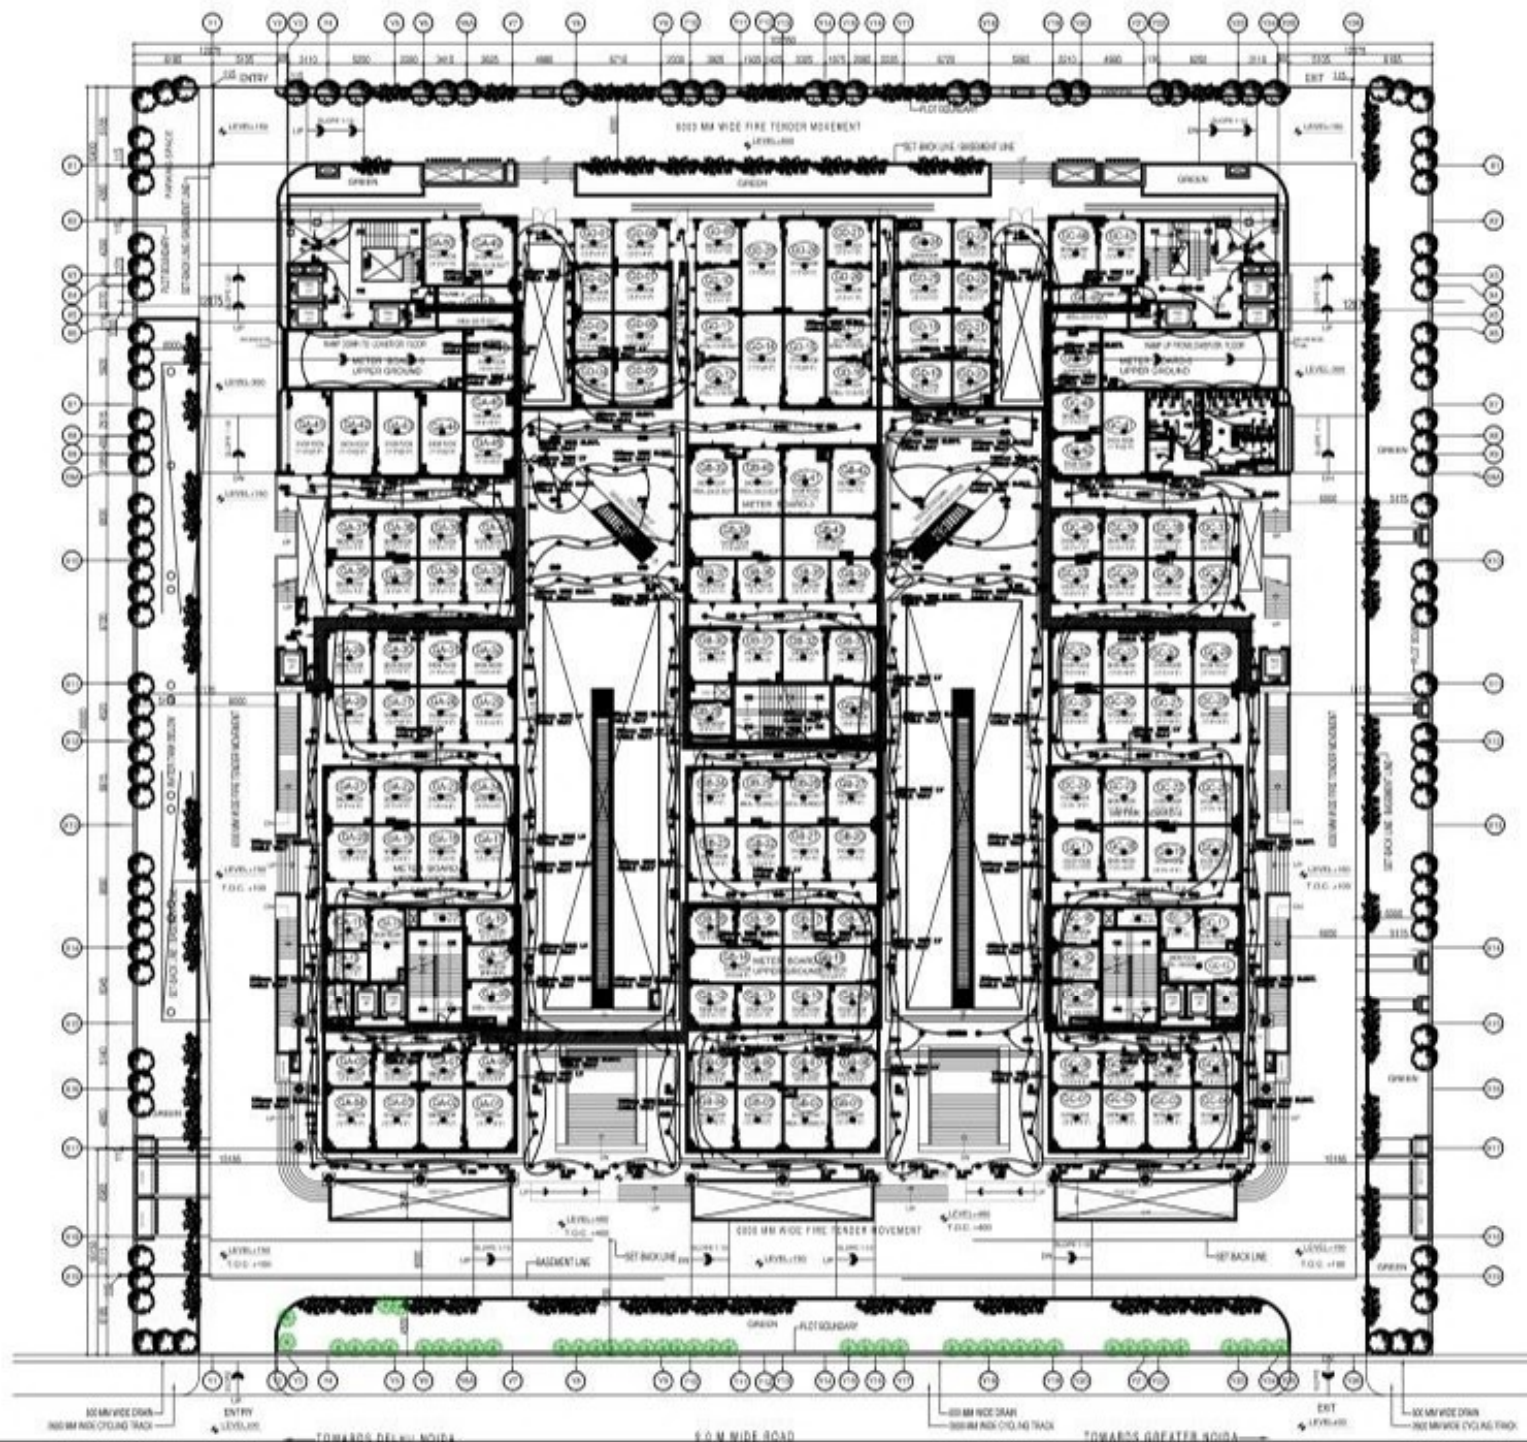

LEGEND	
	NORMAL SWITCH BOARD
	EMERGENCY SWITCH BOARD
	1x12W LED TUBE LIGHT (WM)
	1x12W SURFACE LED TUBE LIGHT
	MIRROR LIGHT
	1x12W RECESSED TYPE LED LIGHT
	20W LED LIGHT
	1x3W BULK HEAD
	1x3W LED FOOT LIGHT
	6A 2PIN POWER PLUG
	16A 6 PIN POWER PLUG
	TV, TELEPHONE/DATA JB
	ISOLATOR PANEL
	DISTRIBUTION BOARD
	EMERGENCY LIGHT POINT
	HOOTER ALARM STROBE
	MANUAL CALL POINT
	FIRE TELEPHONE JACK
	SMOKE DETECTOR (A.F.C.)
	SMOKE DETECTOR (B.F.C.)
	RESPONSE INDICATOR
	EXIT SIGN
	SPEAKER
	SPEAKER WALL MOUNTED
	6A SOCKET FOR CCTV CAMERA
	CCTV CAMERA
	MV CABLE TRAY
	LV CABLE TRAY
CLIENT	
M/S ASTEROID SHELTERS HOMES PVT. LTD.	
B-55, Basement, Sector Nagar New Delhi-110017 Tel No: 011-49648107 & 49640025 Consulting Email: info@vsworlding.com	
ARCHITECTS	
VSWorlding 11, Gurgaon Road, New Delhi-110017 Tel No: 011-49648107 & 49640025 Email: info@vsworlding.com	
PROJECT	
PROPOSED BUILDING PLAN OF COMMERCIAL AT PLT 100/101, C-101, SECTOR - 101, GREATER NOIDA, U.P.	
TITLE	
LIGHTING & POWER LAYOUT	
JOB NO.	
17/06/2017	
SCALE	
1:100 (A1)	
DRAWN BY	
R0	
CHKD. BY	
R0	
DRG. NO.	
1EL-04	