


(ELECTRICAL WITH BEAM)

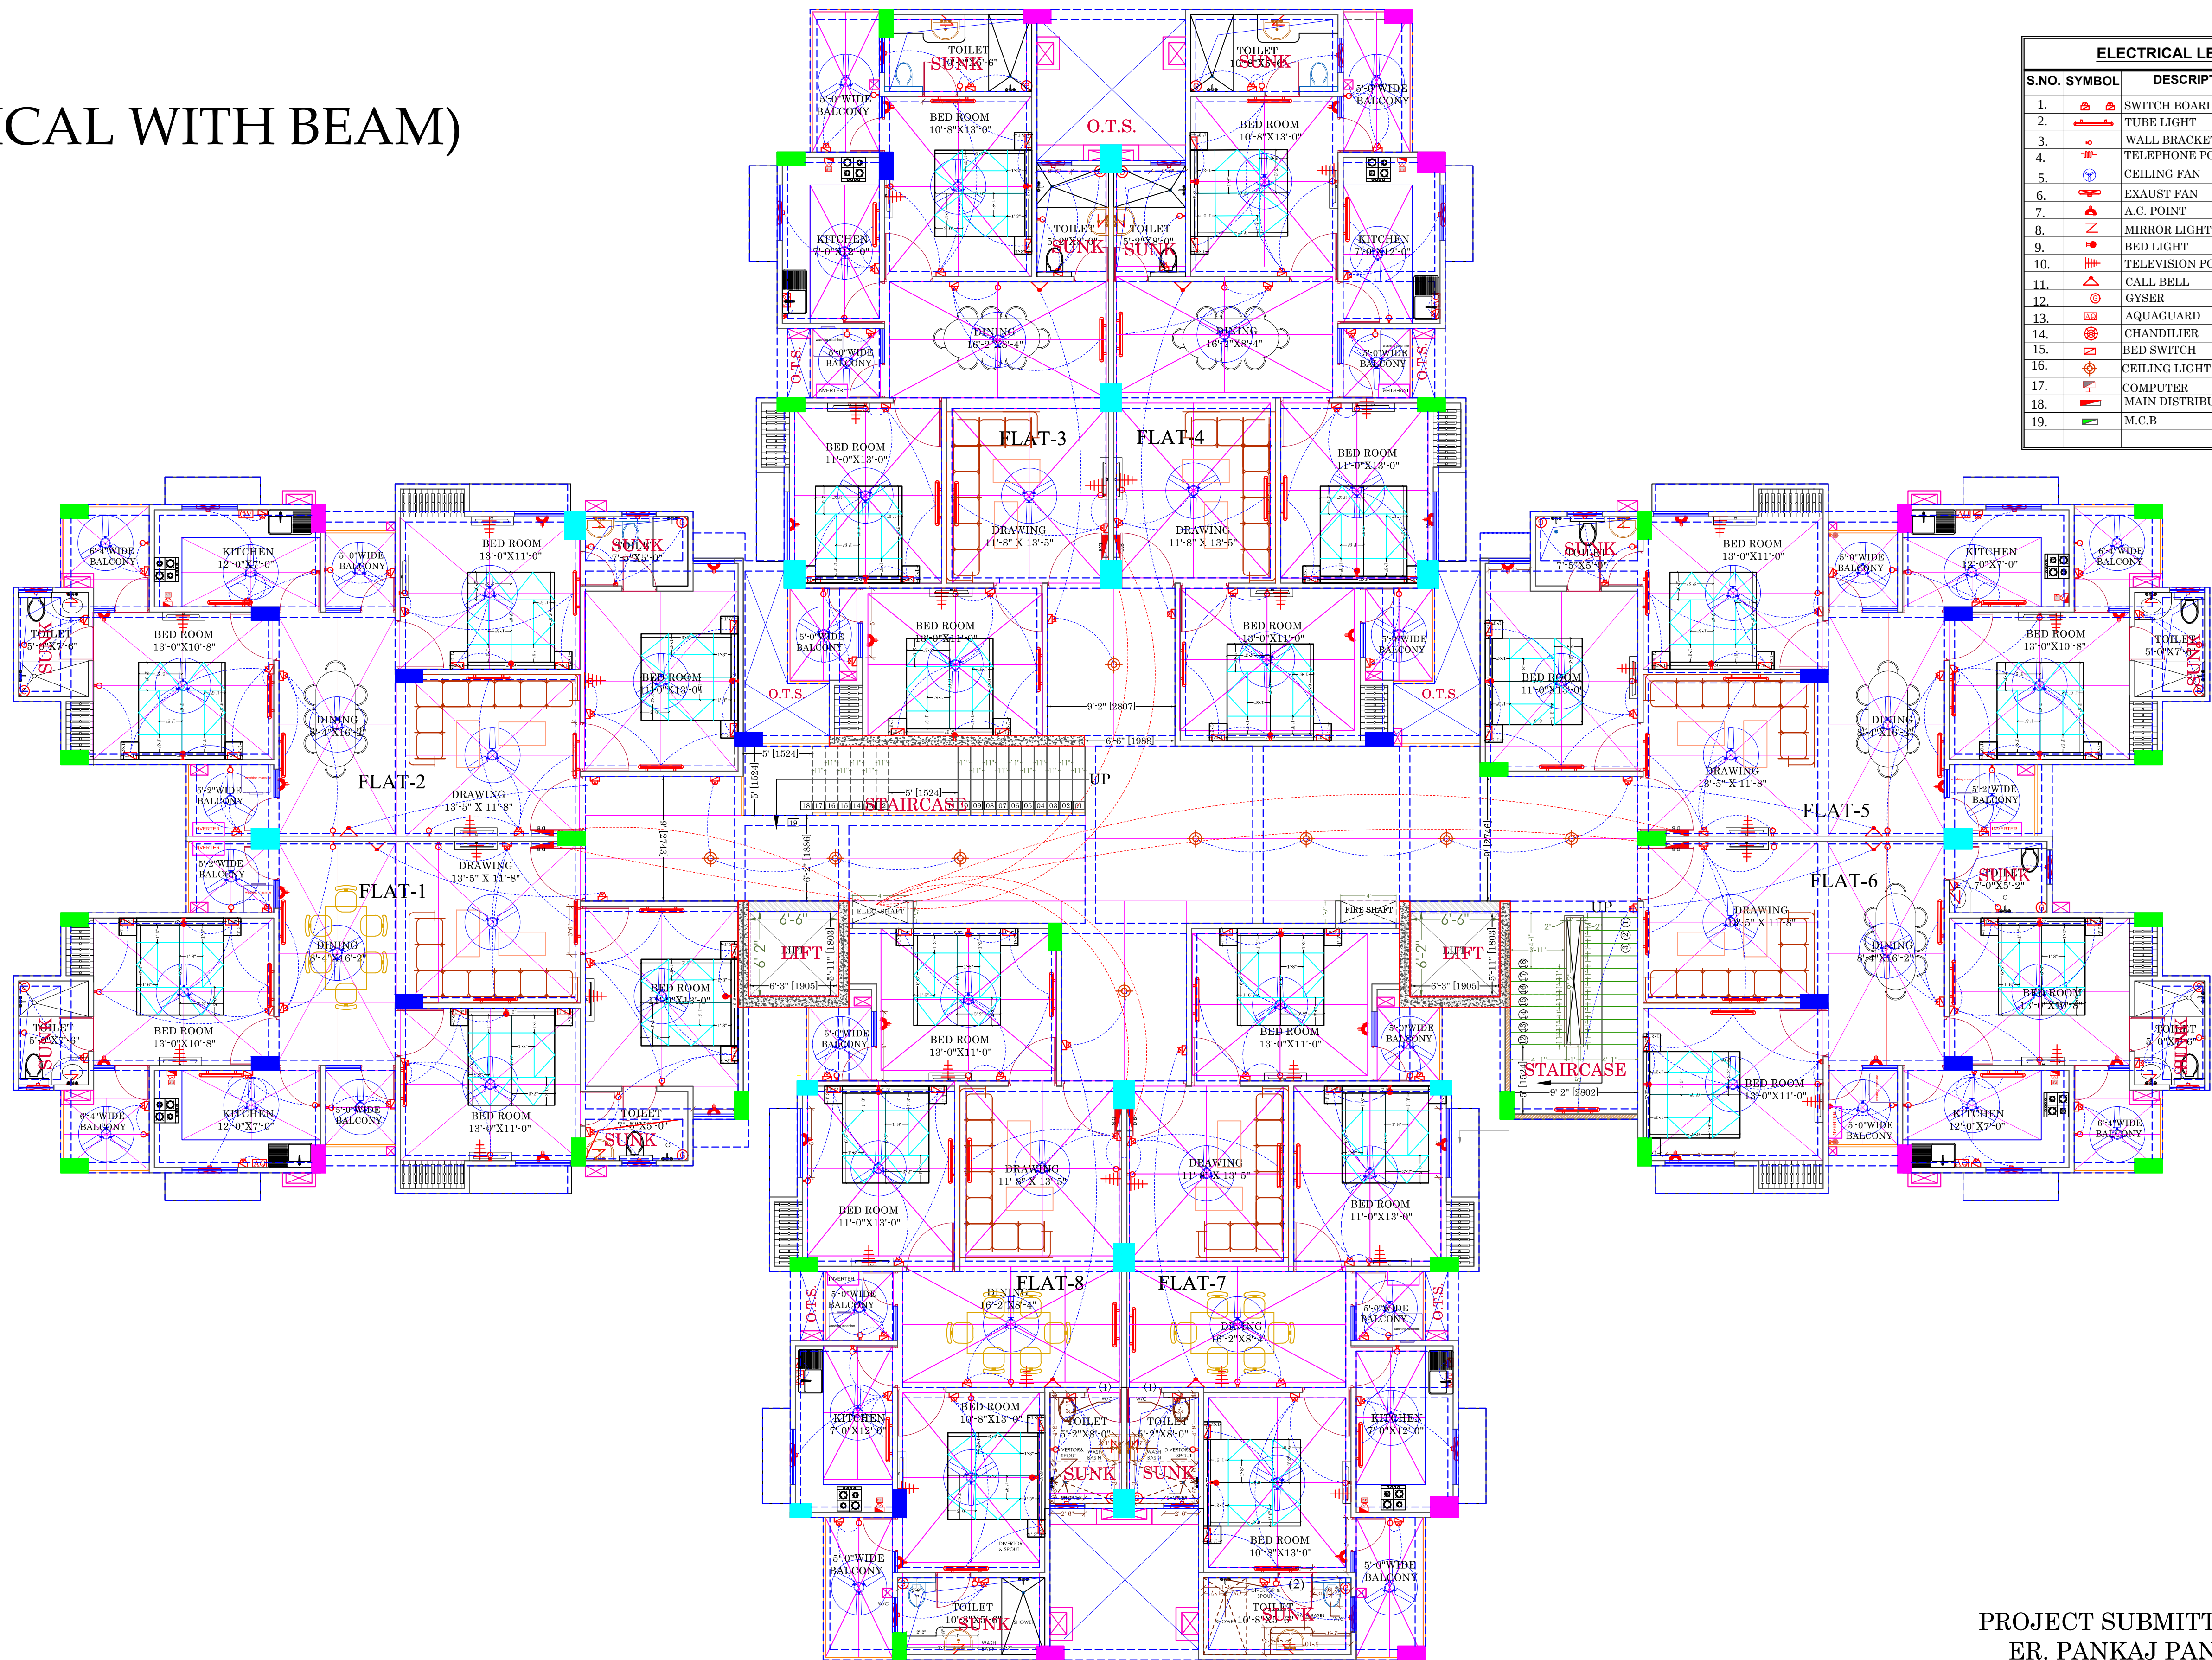

ELECTRICAL LEGEND			
S.NO.	SYMBOL	DESCRIPTION	LVL
1.		SWITCH BOARD	4'-0"
2.		TUBE LIGHT	8'-0"
3.		WALL BRACKET LIGHT	8'-0"
4.		TELEPHONE POINT	2'-6"
5.		CEILING FAN	
6.		EXHAUST FAN	7'-0"
7.		A.C. POINT	2'-0"
8.		MIRROR LIGHT	6'-0"
9.		BED LIGHT	8'-0"
10.		TELEVISION POINT	2'-6"
11.		CALL BELL	5'-0"
12.		GYSER	7'-0"
13.		AQUAGUARD	
14.		CHANDILIER	
15.		BED SWITCH	2'-6"
16.		CEILING LIGHT	
17.		COMPUTER	3'-6"
18.		MAIN DISTRIBUTION BOARD	
19.		M.C.B	

PROJECT SUBMITTED TO-
ER. PANKAJ PANDEY

NOTE:-

1. SIZE OF COLUMN ARE SUBJECT TO FINALIZE OF STRUCTURE DRAWING BY STRUCTURE CONSULTANT.
2. ANY AMBIGUITY IN ARCHITECTURAL DRAWINGS SHOULD BE BROUGHT TO THE NOTICE OF THE ARCHITECT BEFORE EXECUTION OTHERWISE WE WILL NOT BE RESPONSIBLE FOR ANY MISTAKE.
3. THIS DRAWING IS THE PROPERTY OF A-CORE ARCHITECTURAL SERVICES PVT. LTD. AND ISSUED FOR THE SPECIFIC PROJECT MENTIONED THEREIN. THIS IS NOT TO COPIED OR USED FOR THE OTHER PROJECTS UNLESS EXPRESSLY PERMITTED BY THE ARCHITECT.

PROJECT:


LAKE VIEW APARTMENT

OWNER:-

GORAKHPUR DEVELOPMENT
AUTHORITY

DRG. TITLE:-

DRG/ NO. GDA/PROJECT
2-ACRE SITE

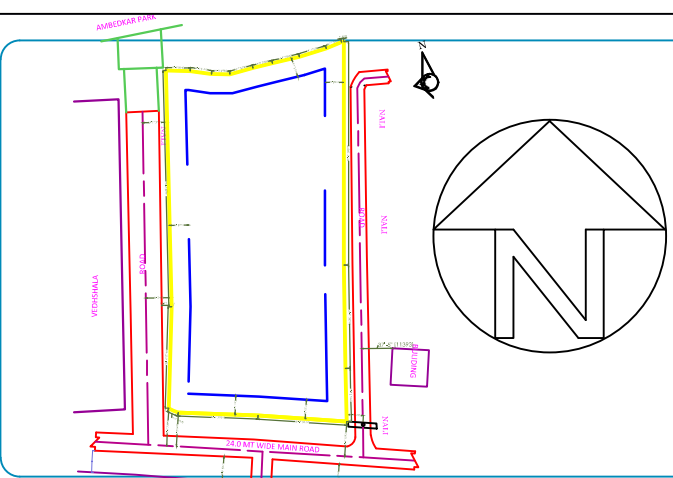

ASST.
ENGINEER

EXECUTIVE
ENGINEER

TOWN
PLANNER

SECRETARY

VICE
CHAIRMAN

