


5 M SET BACK

5 M SET BACK

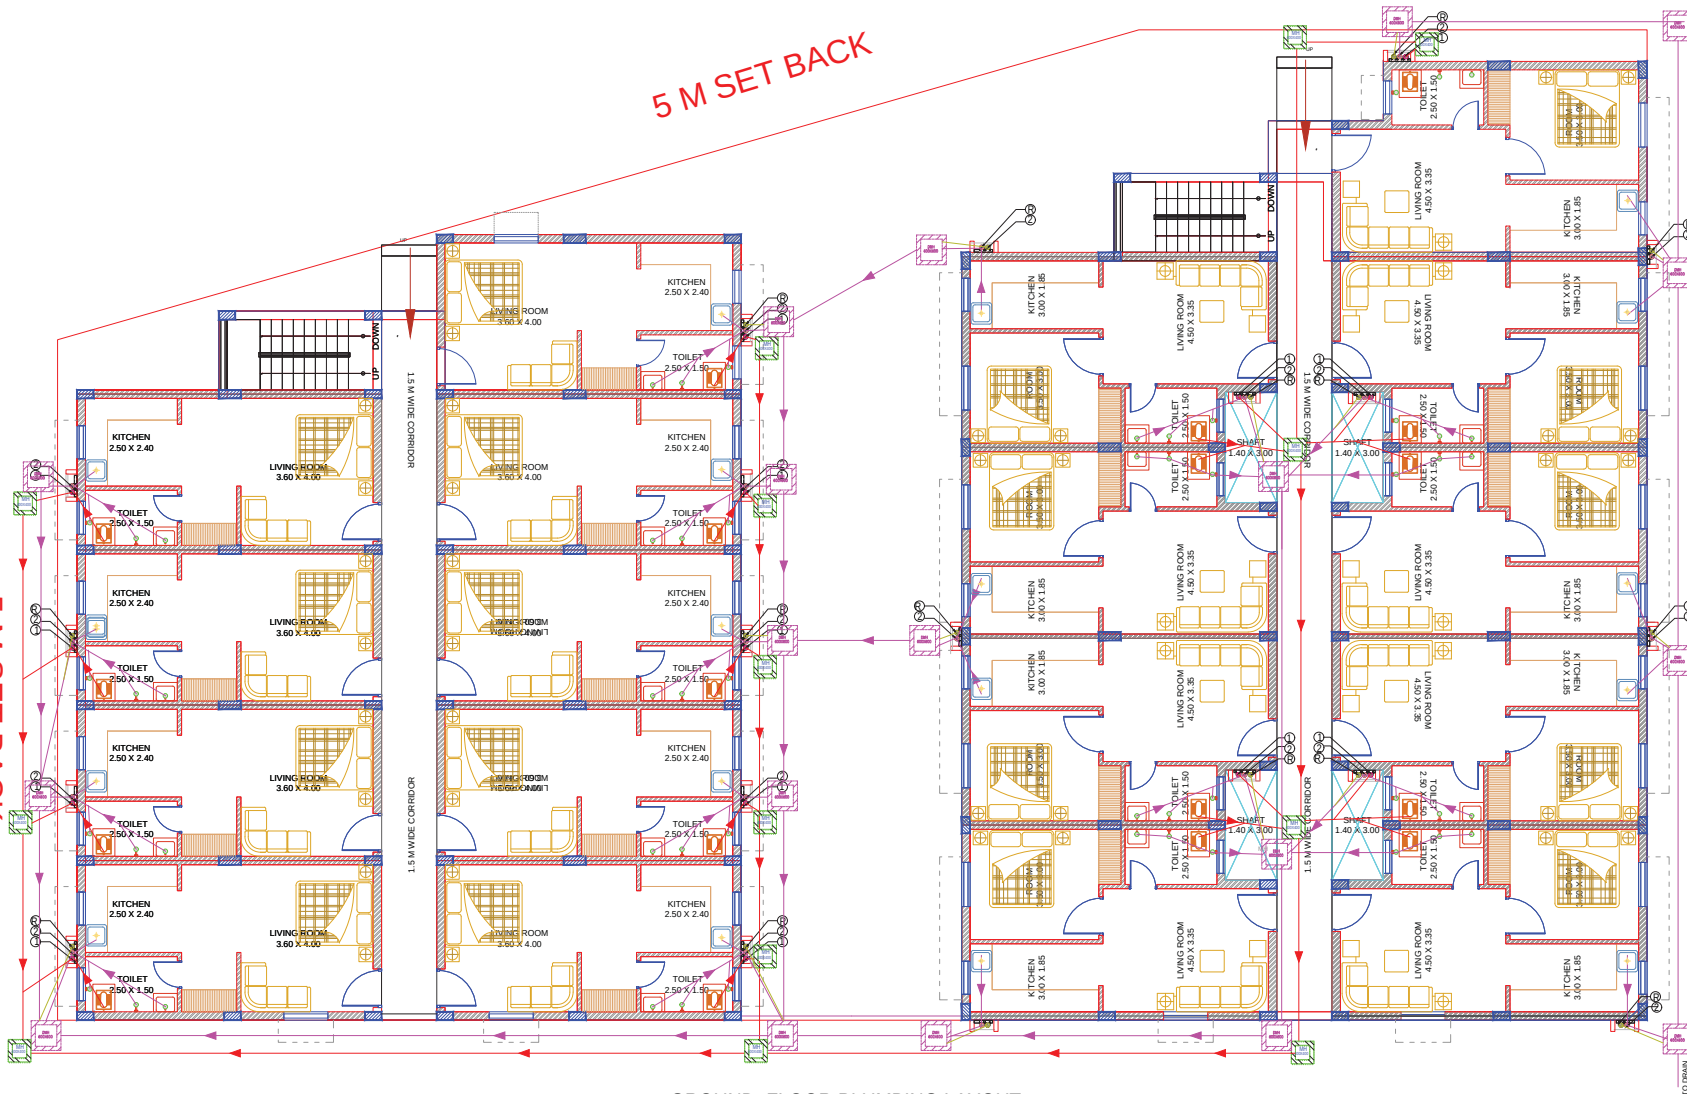

GROUND FLOOR PLUMBING LAYOUT


S.NO.	SYMBOL	DESCRIPTION
1	⊕	90 OD SOIL & VENT PIPE
2	⊖	90 OD WASTE & VENT PIPE
3	⊕	COLD WATER SUPPLY PIPE
4	⊖	COLD WATER RISER PIPE
5	⊕	110 OD uPVC RAIN WATER PIPE
6	⊕	FLOOR TRAP
7	⊖	FLOOR DRAIN
8	⊕	URINAL TRAP
9	⊕	CLEAN OUT PLUG
10	⊕	FLOOR CLEAN OUT PLUG
11	⊕	PIPE DROP
12	⊕	VALVE
13	⊕	SEWERAGE MANHOLE SIZE 400X400
14	⊕	DRAINAGE MANHOLE SIZE 400X400
15	⊕	CATCH BASIN SIZE 450X450 MM
16	⊕	GULLY TRAP SIZE 300X300 MM
17	⊕	SOIL PIPE
18	⊕	WASTE PIPE

ALL THE BALCONY/TERRACE WATER POINT SHALL BE AT 800MM ABOVE FROM FFL

NOTES:

1. FD TO FT 63 OD PP WASTE PIPE
2. WASH BASIN TO FT 40 OD PP WASTE PIPE
3. WC TO VERTICAL 90 OD PP SOIL PIPE
4. FT TO VERTICAL 110 OD PP WASTE PIPE
5. UT TO VERTICAL 110 OD PP SOIL PIPE
6. URINAL TO UT 50 OD PP SOIL PIPE

Drawing Name:		GROUND FLOOR PLUMBING LAYOUT	
Drawing No:	Scale:		
EWS LIG /GUL4/13			
Client Name:			
EWS LIG /GUL4			
Date:	Revision No:		
16/05/2024			
Drawing Status:		VIRIN GOYAL	
F.I.O	Tender	G.F.C	
ARCHITECTS - Hindyam Design Inc. HINDYAM DESIGN INC. IMPORTER OF HINDYAM PLUMBING 10/2, Main Road, Phone: 091-87554422 1 www.hindyam.com			

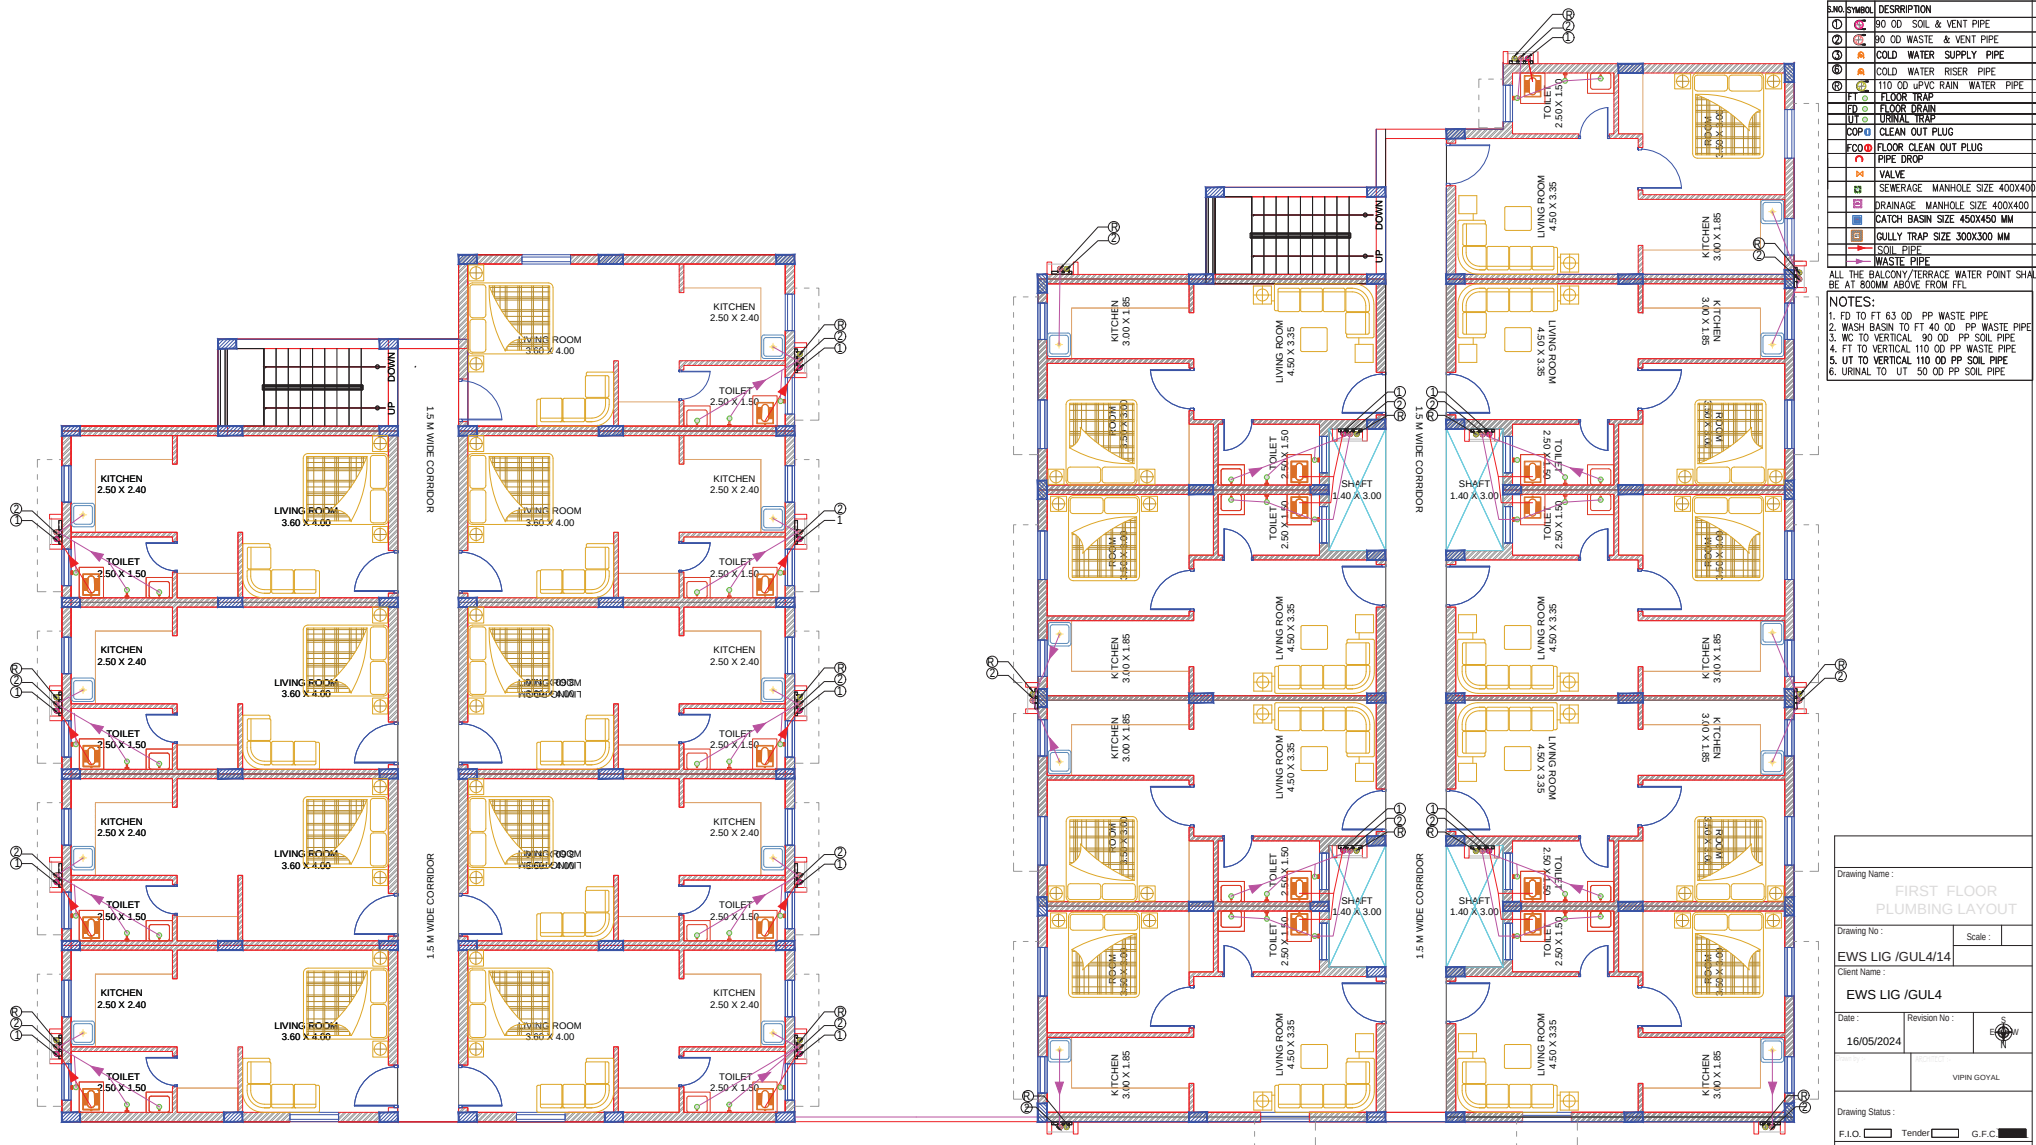

FIRST FLOOR PLUMBING LAYOUT

Drawing Name: **FIRST FLOOR PLUMBING LAYOUT**

Drawing No: **EWS LIG/GUL4/14** Scale:


Client Name: **EWS LIG/GUL4**


Date: **16/05/2024** Revision No:

VPIN GOYAL

Drawing Status: F.I.O. ☐ Tender ☐ G.F.C. ☒

ARCHITECTS: **Hridayam Design Inc.**
 REGISTERED CIVIL ENGINEER,
 MEMBER OF REGISTERED CIVIL ENGINEERS,
 HYDRA, MUMBAI (P)
 Phone: 09820554202 (1)
 www.hridayamdesign.com

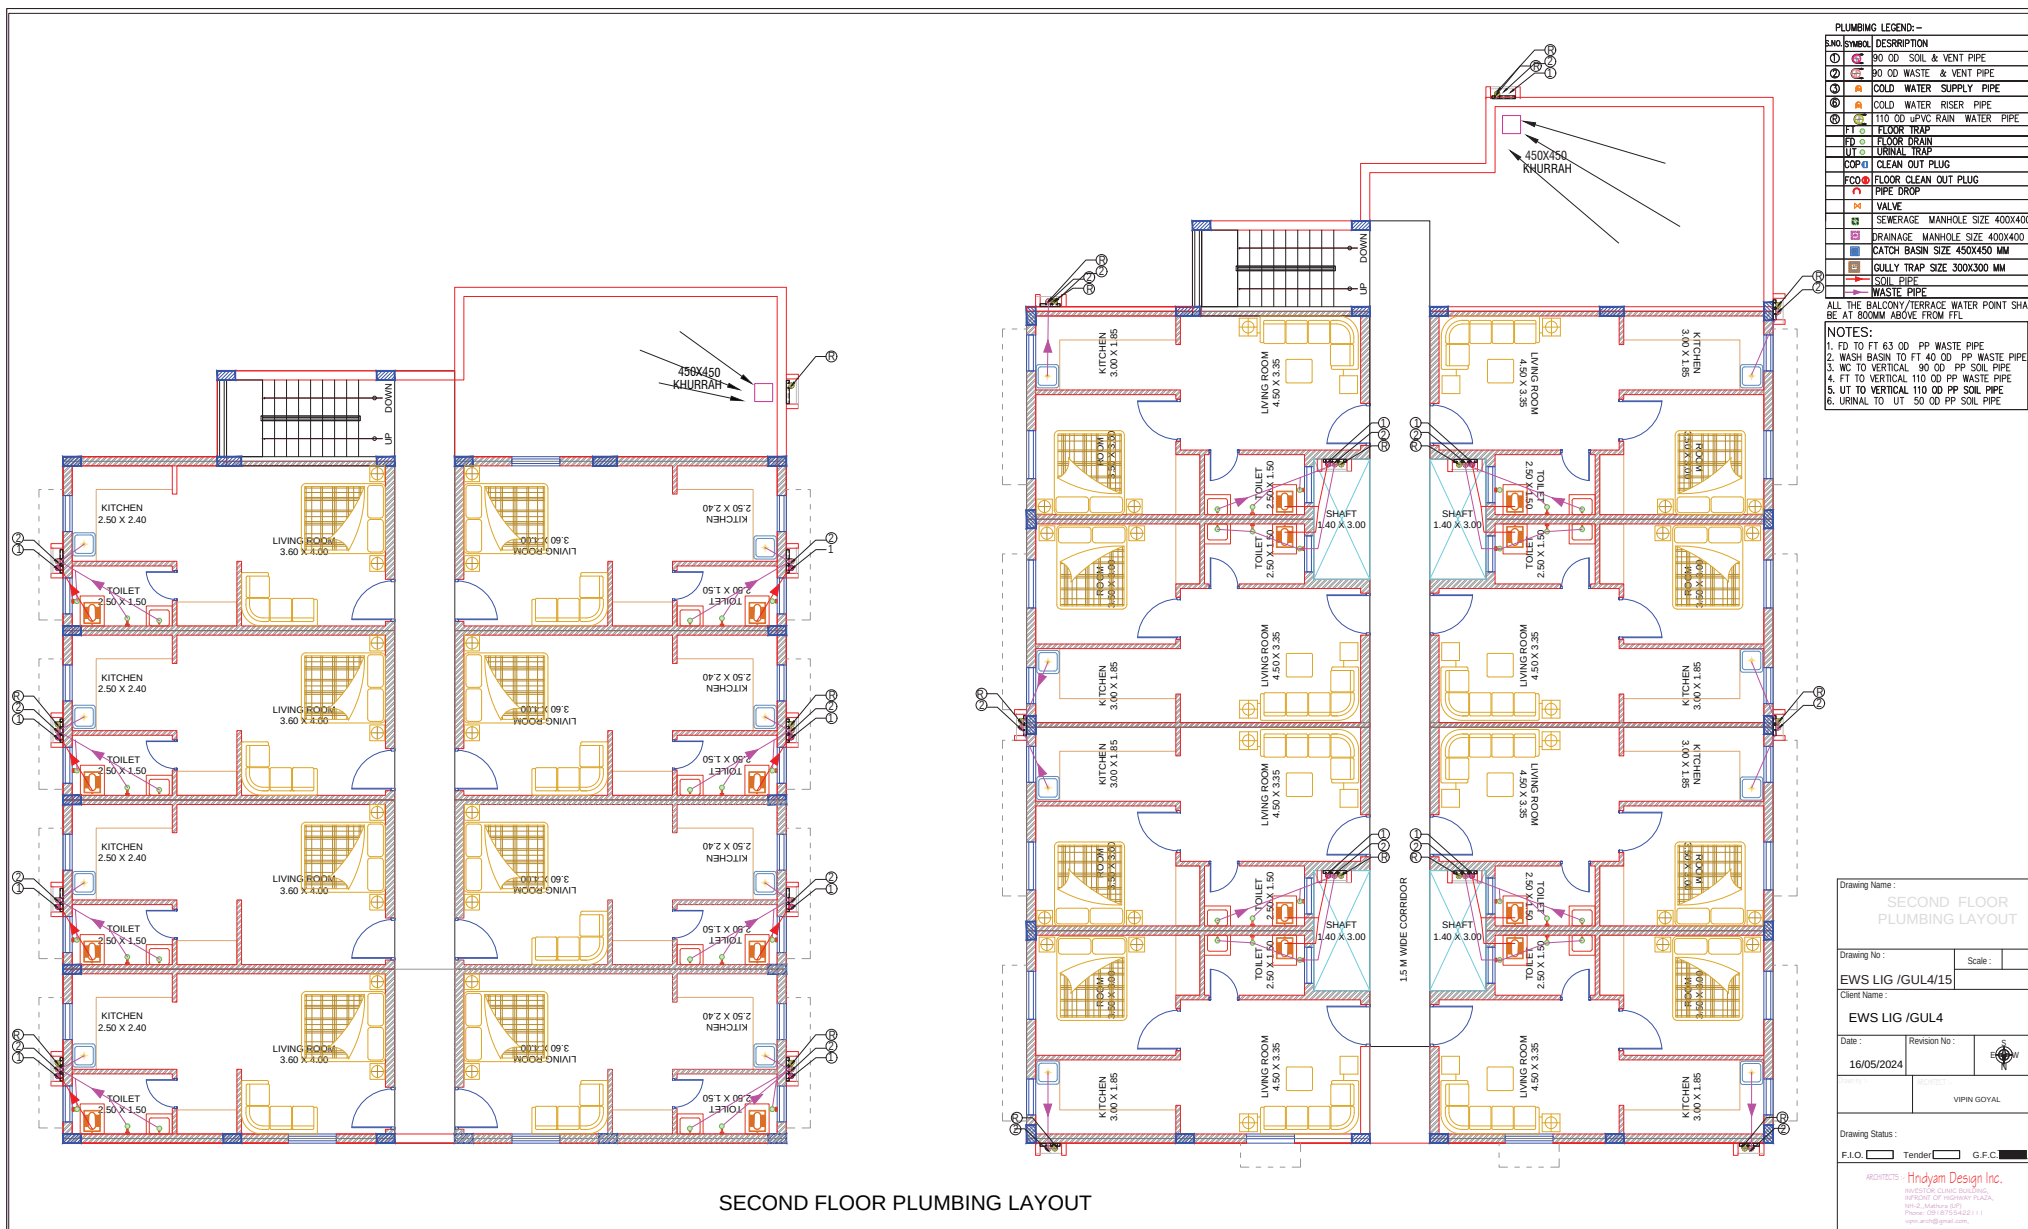

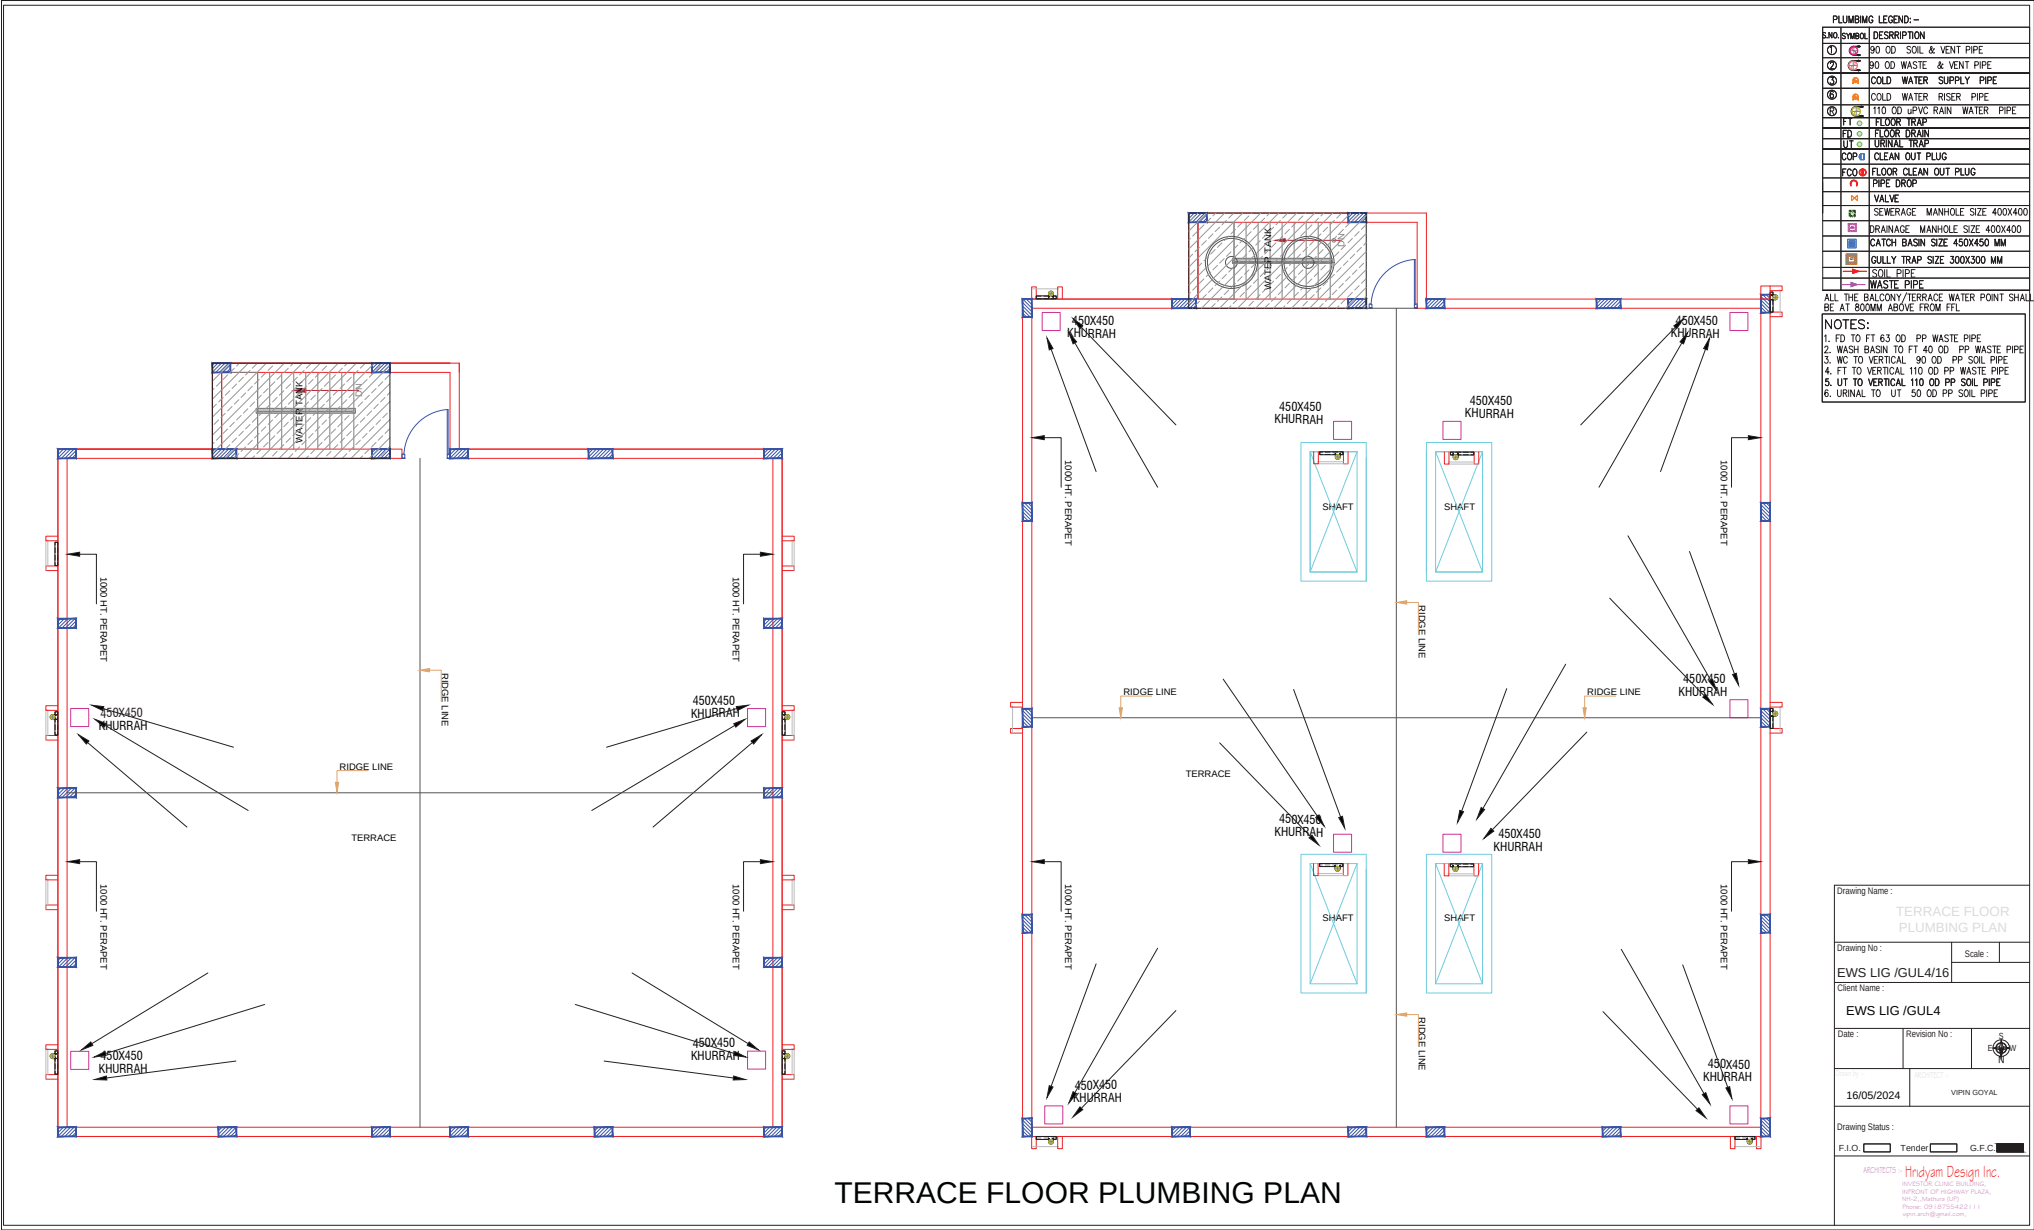

TERRACE FLOOR PLUMBING PLAN