


755.74 Sq.m.

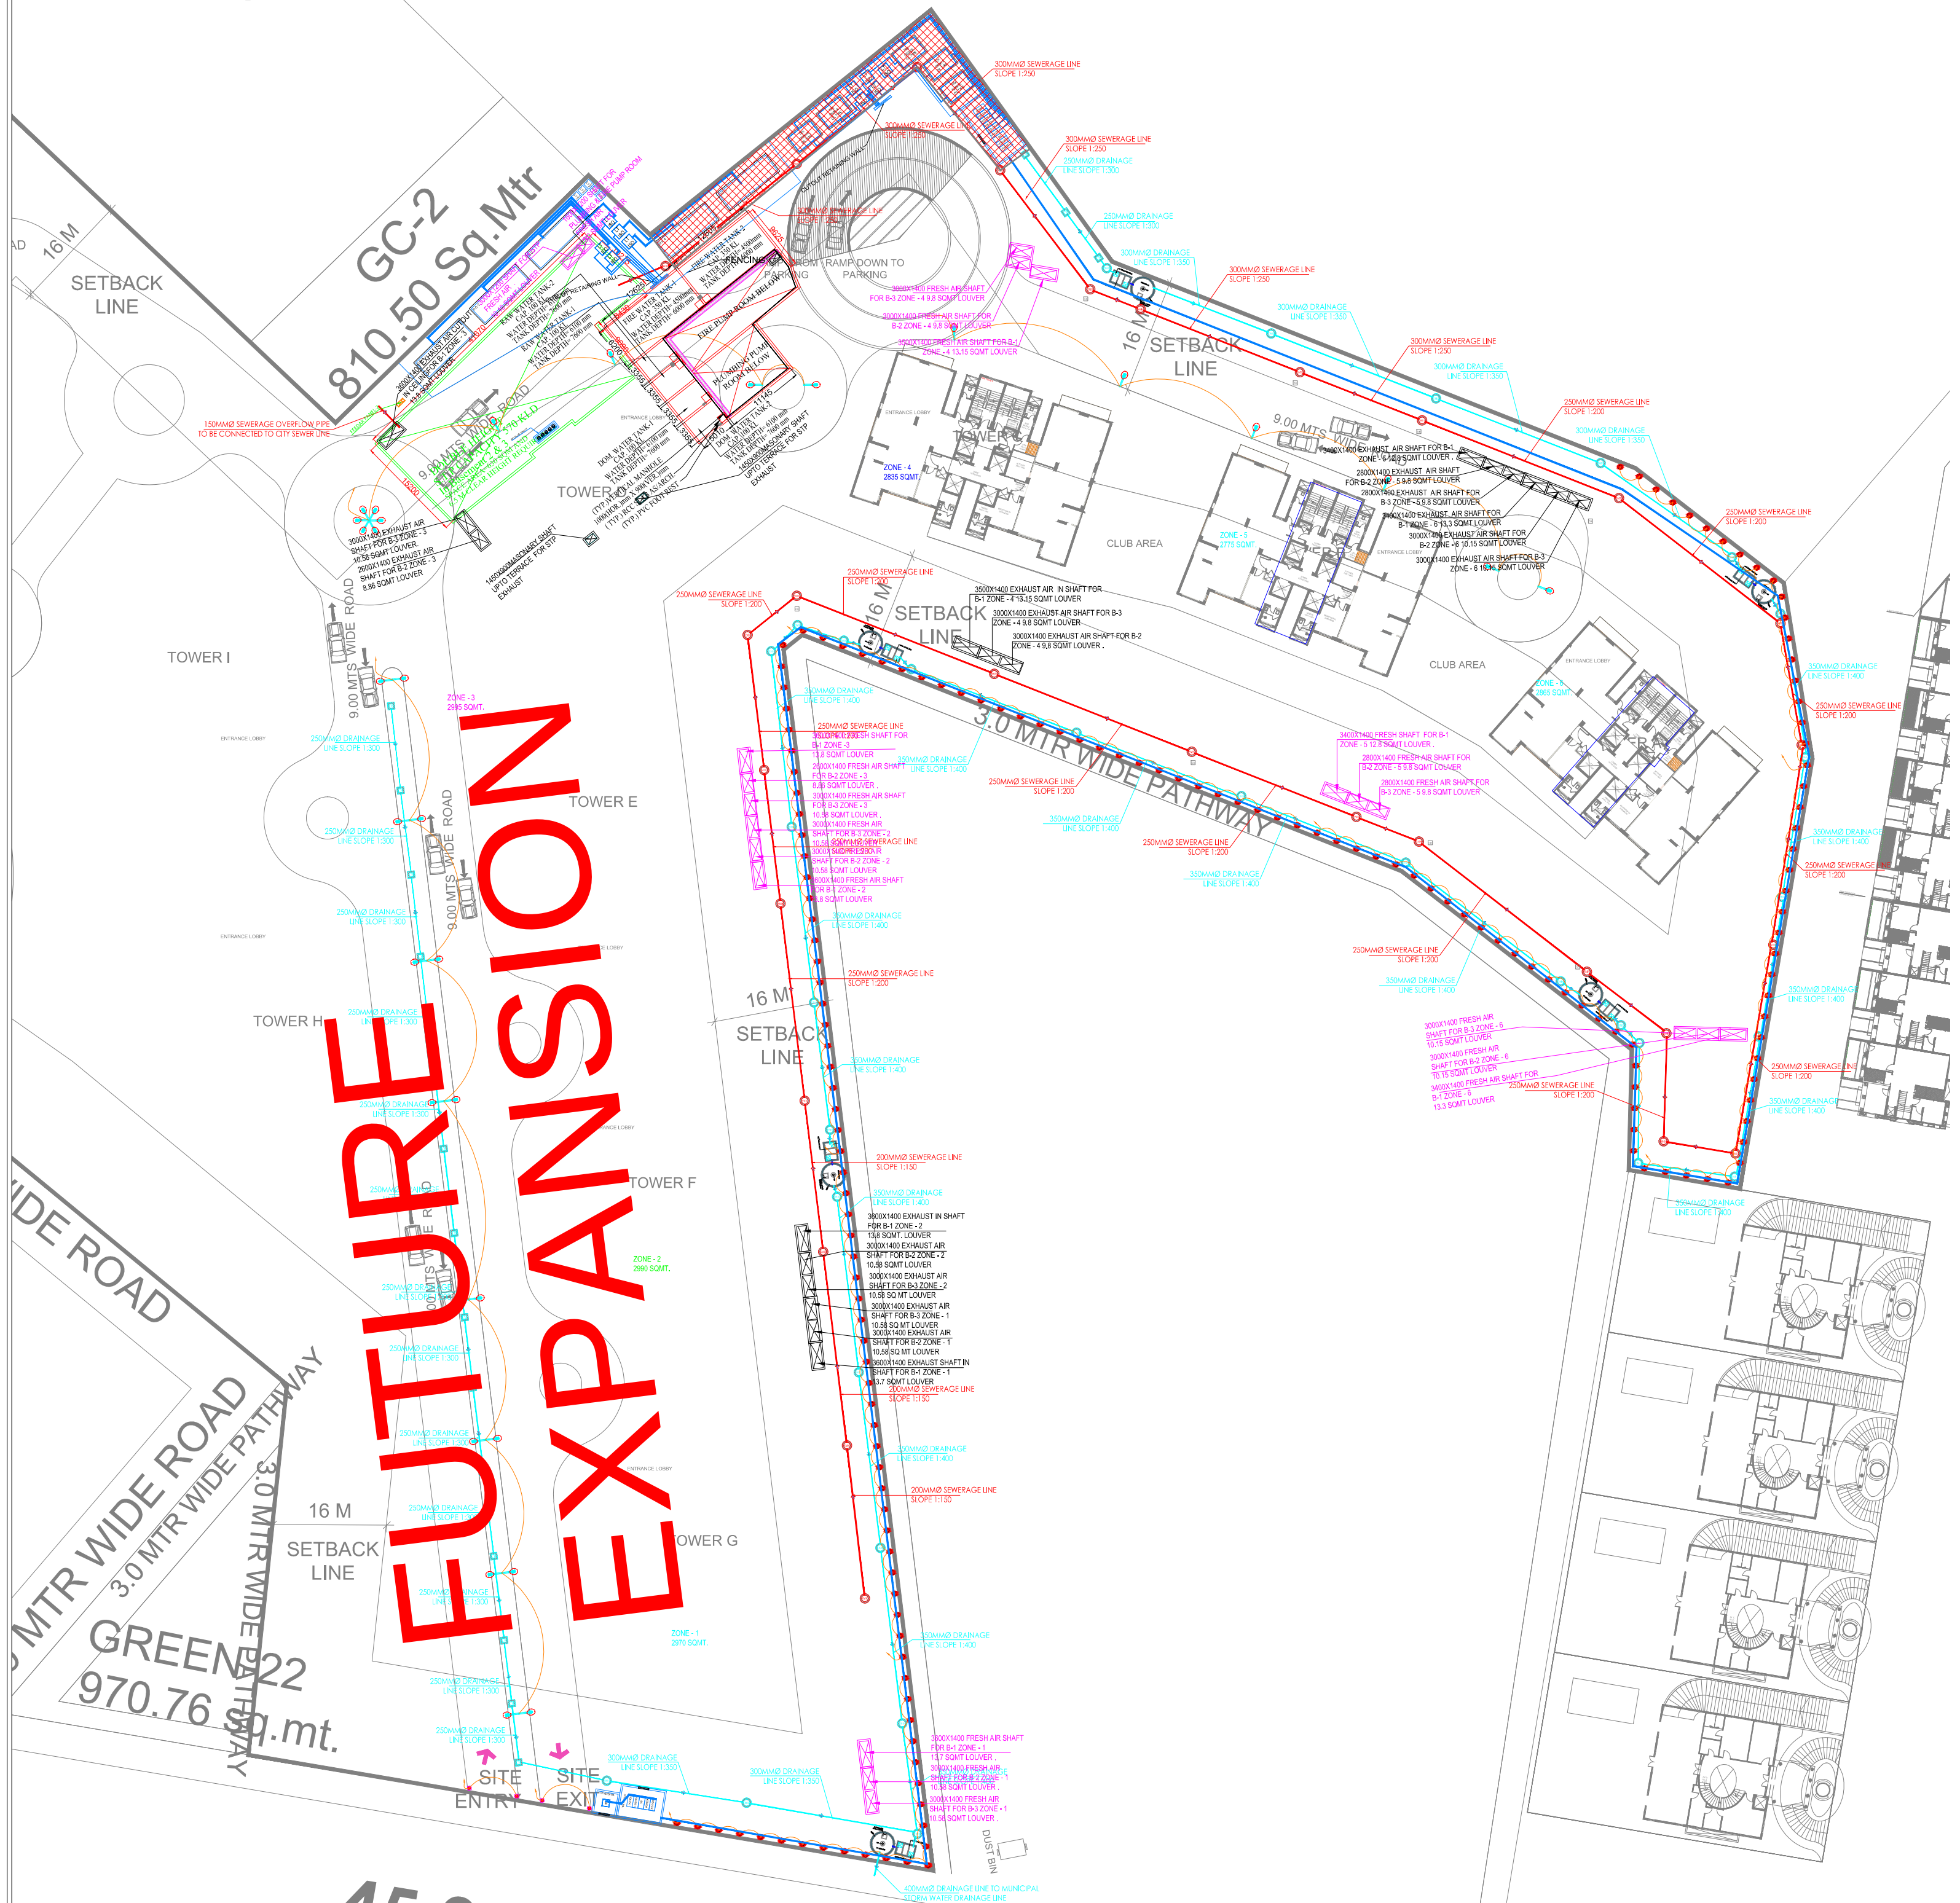

PLUMBING LEGEND	
SYMBOL	DESCRIPTION
	DRAINAGE PIPE LINE
	DRAINAGE MANHOLE
	DRAINAGE CATCH BASIN
	RAIN WATER HARVESTING PIT

PLUMBING LEGEND	
SYMBOL	DESCRIPTION
	SEWEGAGE PIPE LINE
	SEWERAGE MANHOLE
	GULLY TRAP
S.T.P.	SEWERAGE TREATMENT PLANT

LEGEND :-		
S. No.	SYMBOL	DESCRIPTION
1.		1X36W GATE LIGHT
2.		90 W LED POLE LIGHT SINGLE ARM
3.		180 W LED POLE LIGHT DOUBLE ARM
4.		540W HIGH MAST LIGHT
5.		5W LED BOLLARD LIGHT
6.		FEEDER PILLER
7.		LOOPING

	LEGEND	SYMBOL
1.	EXHAUST AIR CUTOUT	
2.	FRESH AIR CUTOUT	
3.	AC EXHAUST AIR DUCT	
4.	AC FRESH AIR DUCT	
5.	AXIAL FLOW FAN	
5.	AXIAL FLOW FAN	

Architect
Hafeez
Contractor

PROJECT:-
PROPOSED BUILDING PLANS OF GROUP
HOUSING-17 SCHEME AT VIBHUTI KHAND, GOMTI
NAGAR , LUCKNO,UTTAR PRADESH-226010

OWNER:
SHALIMAR
ONE WORLD

MEP Consultants:-
PDA Consultants
MEP & Green Building Consultants
REGD OFFICE:
PLOT NO-190 SECOND FLOOR
PATIPARGANJ INDUSTRIAL AREA,
DELHI-110002, INDIA
TEL. : +91-11-42408301/42408302
E-MAIL : dmh@pdaconsultants.in

DRG.TITLE:-
CO-ORDINATE SITE PLAN
MEP LAYOUT

REVISION	JOB NO:-	DRG NO:-	NORTH:-
	SCALE @A0 1:325	DATE:- 15.02.2023	
FILE:-	DEALT BY:- S.D.S	CHECKED BY:- P.J	APPROVED BY:

FOR RERA SUBMISSION