


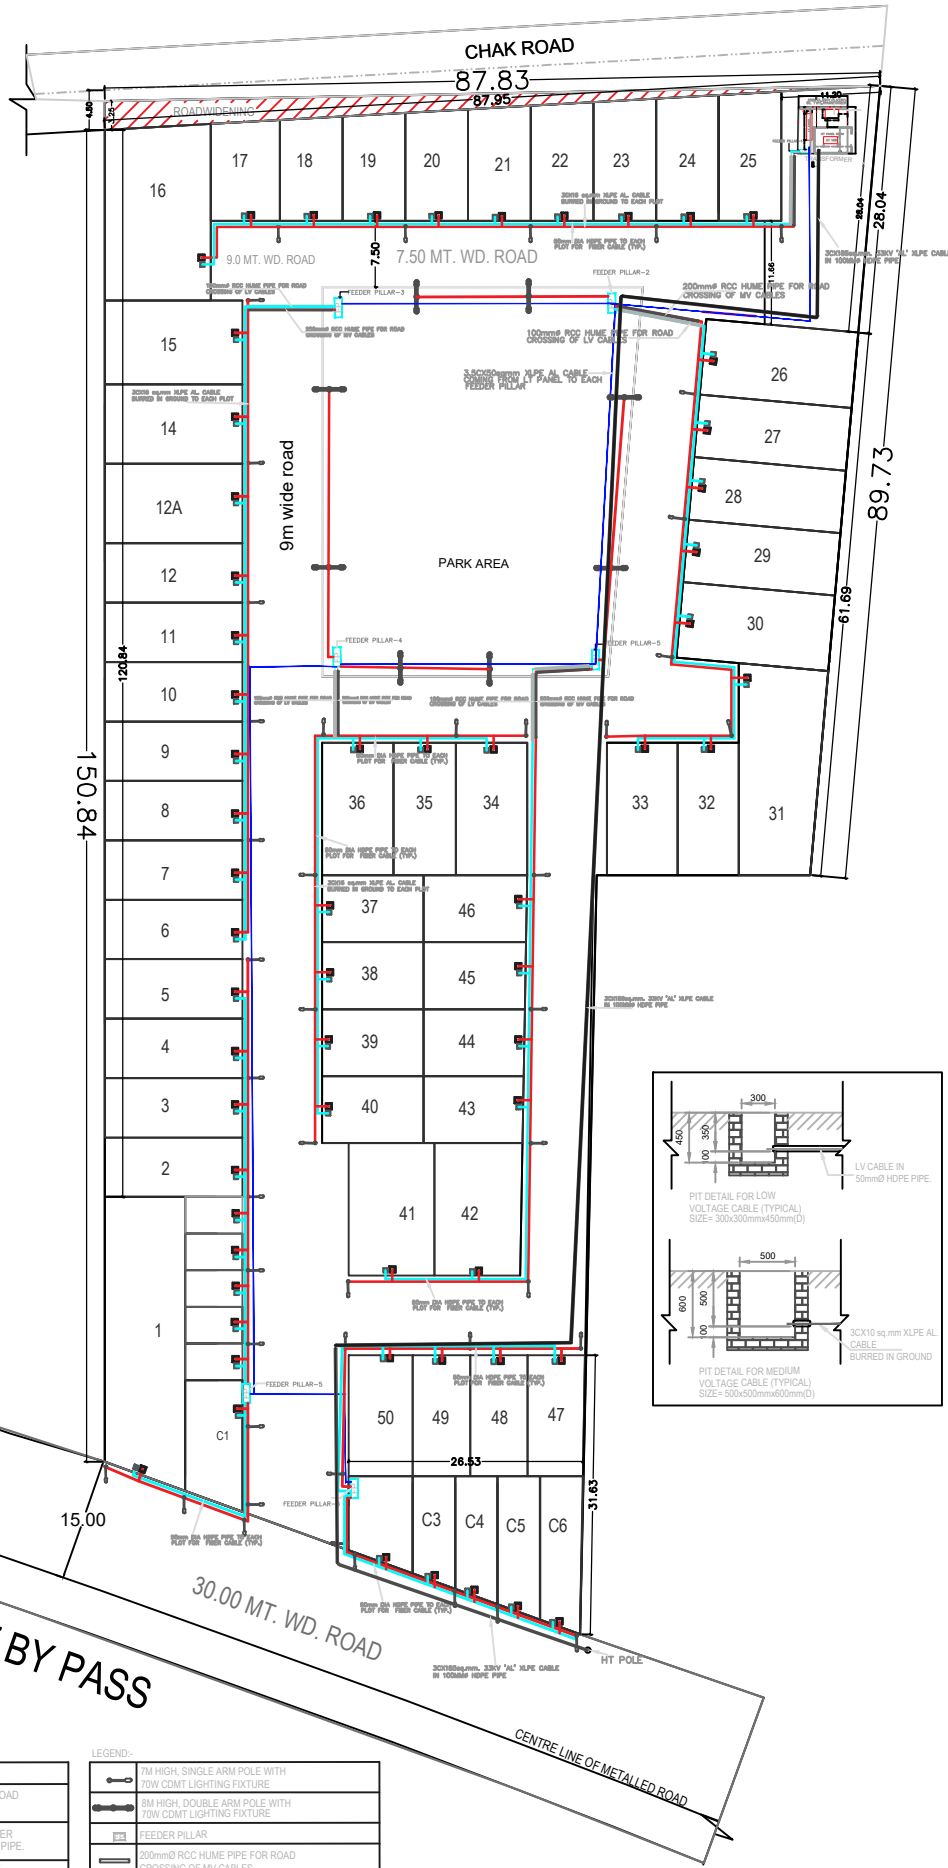

LEGEND:-

	FEEDER PILLAR
	100mm Ø RCC HUME PIPE FOR ROAD CROSSING OF LV CABLES
	LV CABLE ROUTING FROM FEEDER PILLAR TO EACH PLOT IN HDPE PIPE
	LOW VOLTAGE ELECTRICITY PIT 300x300mmx450mm DEEP (TYP.)

LEGEND:-

	7M HIGH, SINGLE ARM POLE WITH 70W COMET LIGHTING FIXTURE
	8M HIGH, DOUBLE ARM POLE WITH 70W COMET LIGHTING FIXTURE
	FEEDER PILLAR
	200mm Ø RCC HUME PIPE FOR ROAD CROSSING OF MV CABLES
	MV CABLE ROUTING FROM FEEDER PILLAR TO EACH PLOT BURIED IN GROUND
	MEDIUM VOLTAGE ELECTRICITY PIT 500x500mmx600mm DEEP (TYP.)

rev	description	by	00/00/0000
REV:	DESCRIPTION:	BY:	DATE:

PROJECT NAME:
KINGS AVENUE
Bareilly,
Uttar Pradesh
243006

DRAWING TITLE:
SITE PLAN
ELECTRICAL LAYOUT

DRAWN BY:

CHECKED BY:

APPROVED BY:

DATE:
15/11/2022

ARCHITECT:

DESIGN VIEWS
ARCHITECTS, PLANNERS & ENGINEERS.
FIRST FLOOR, DESIGN COMPLEX
PILIBHIT ROAD
BAREILLY

SERVICES CONSULTANT:

graft studio

Shop no. 09, Shri Jagdamba Market
Rithala, Rohini, Delhi, 110085
+91-9555043558
+91-8989047460