
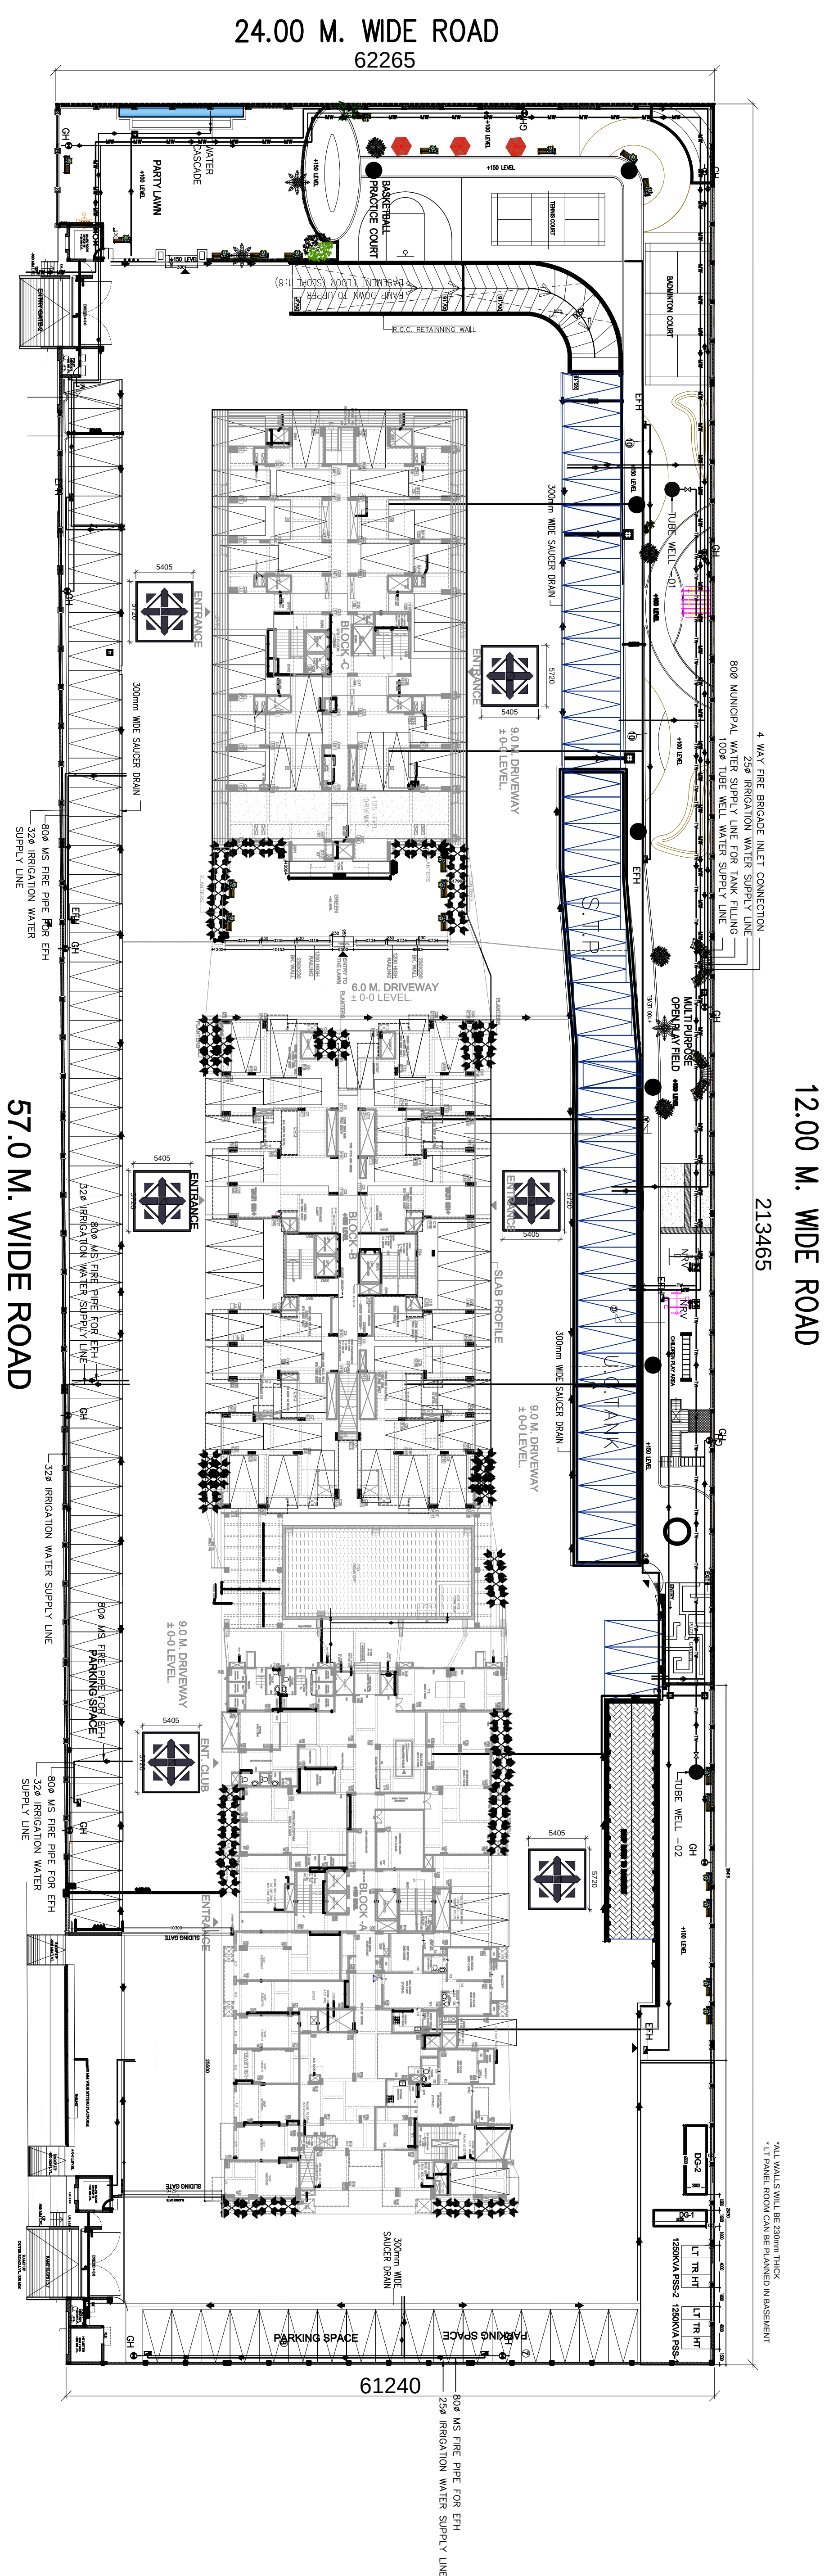
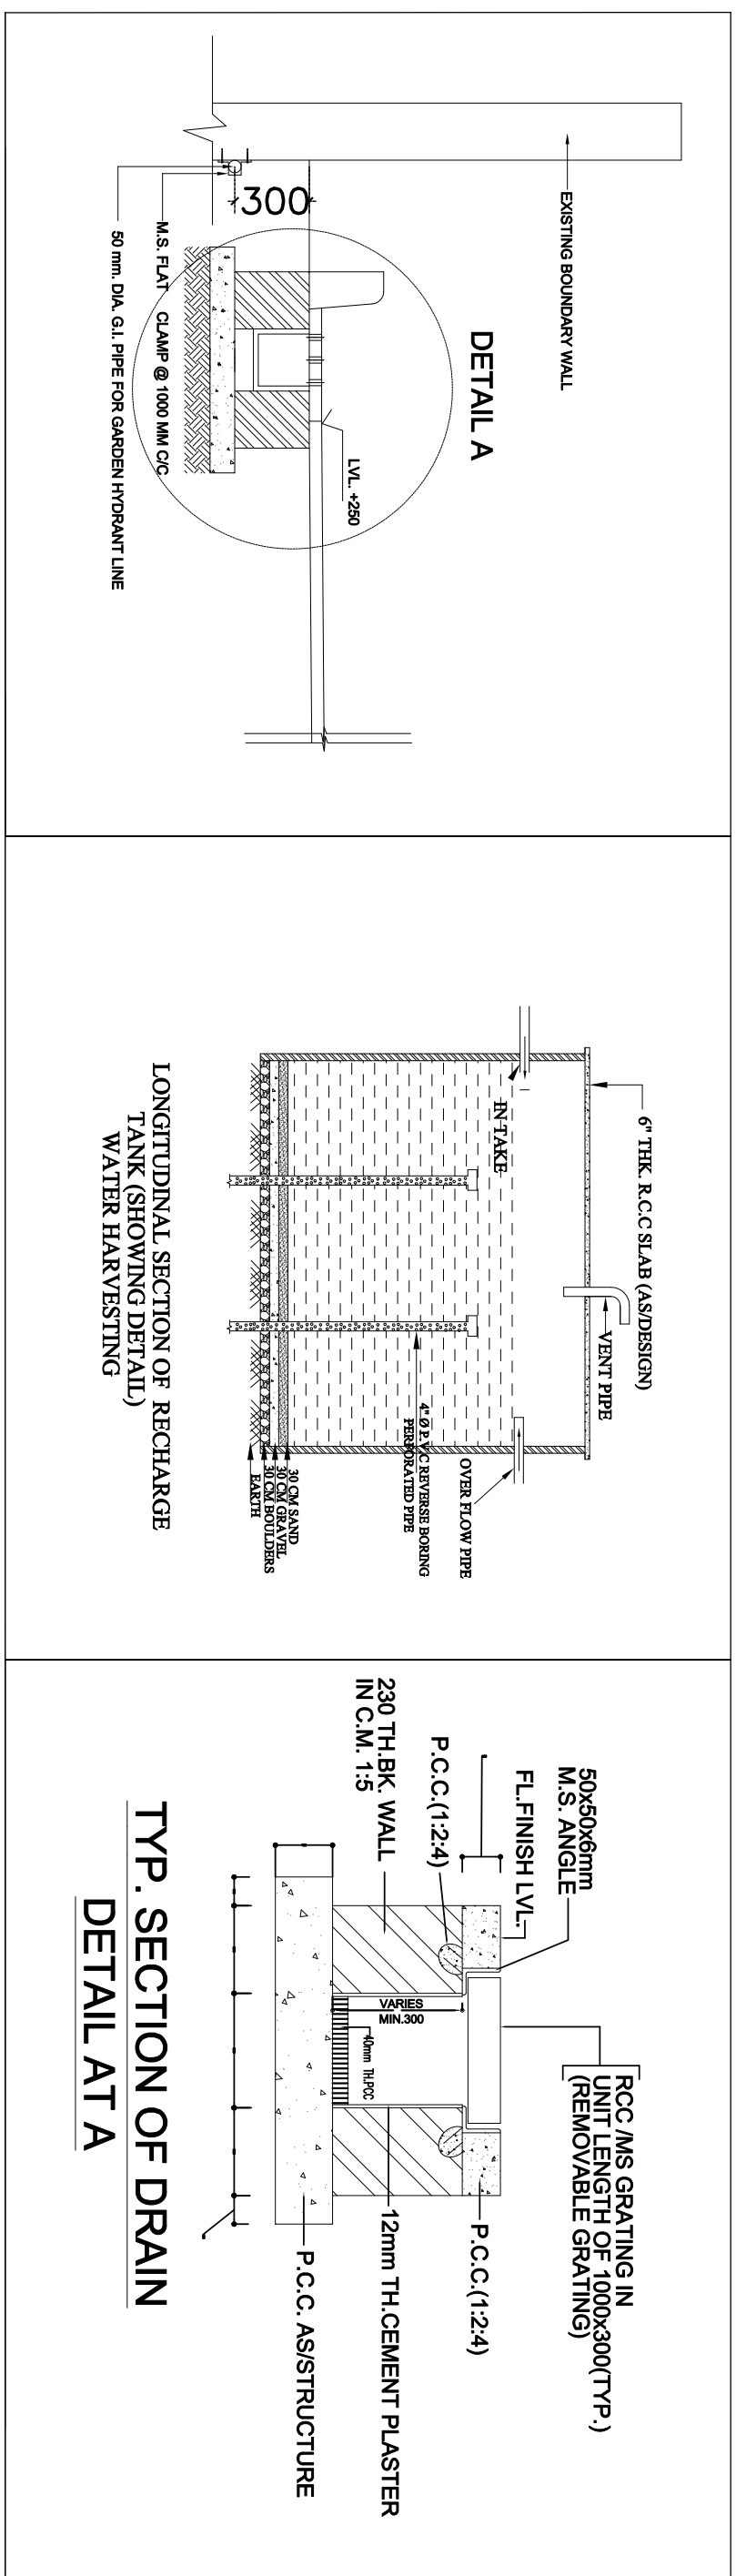


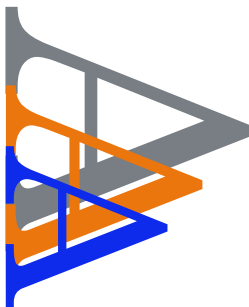

PLUMBING LEGEND:	
—MW—	DOMESTIC WATER SUPPLY FILLING LINE FROM MUNICIPAL / TANKER LINE.
—	IRRIGATION WATER SUPPLY LINE
—TW—	TUBE WELL WATER SUPPLY LINE
— — —	EXTERNAL FIRE HYDRANT LINE
EFH	EXTERNAL FIRE HYDRANT
 GH	GARDEN HYDRANT
	VALVE WITH CHAMBER
	NON RETURN VALVE WITH CHAMBER

PROJECT: DRAWING FOR THE PROPOSED GROUP HOUSING AT PLOT-NO.GH-1 SEC.- 6 IN "WAVE CITY", NH-24GHAZIABAD DEVELOPER COMPANY:- Uppal Chadha Hi- Tech Developers Pvt. Ltd. Plot No.-757, Village Dasna, Kazipura More, NH-24 Ghaziabad DRAWING TITLE: EXTERNAL WATER SUPPLY PLAN			OWNERS SIGN		
			 ANUJ AGARWAL ARCHITECTS		
SCALE		DEALT BY		DATE	
DESIGN BY		CHECKED BY		DRG. No.	