



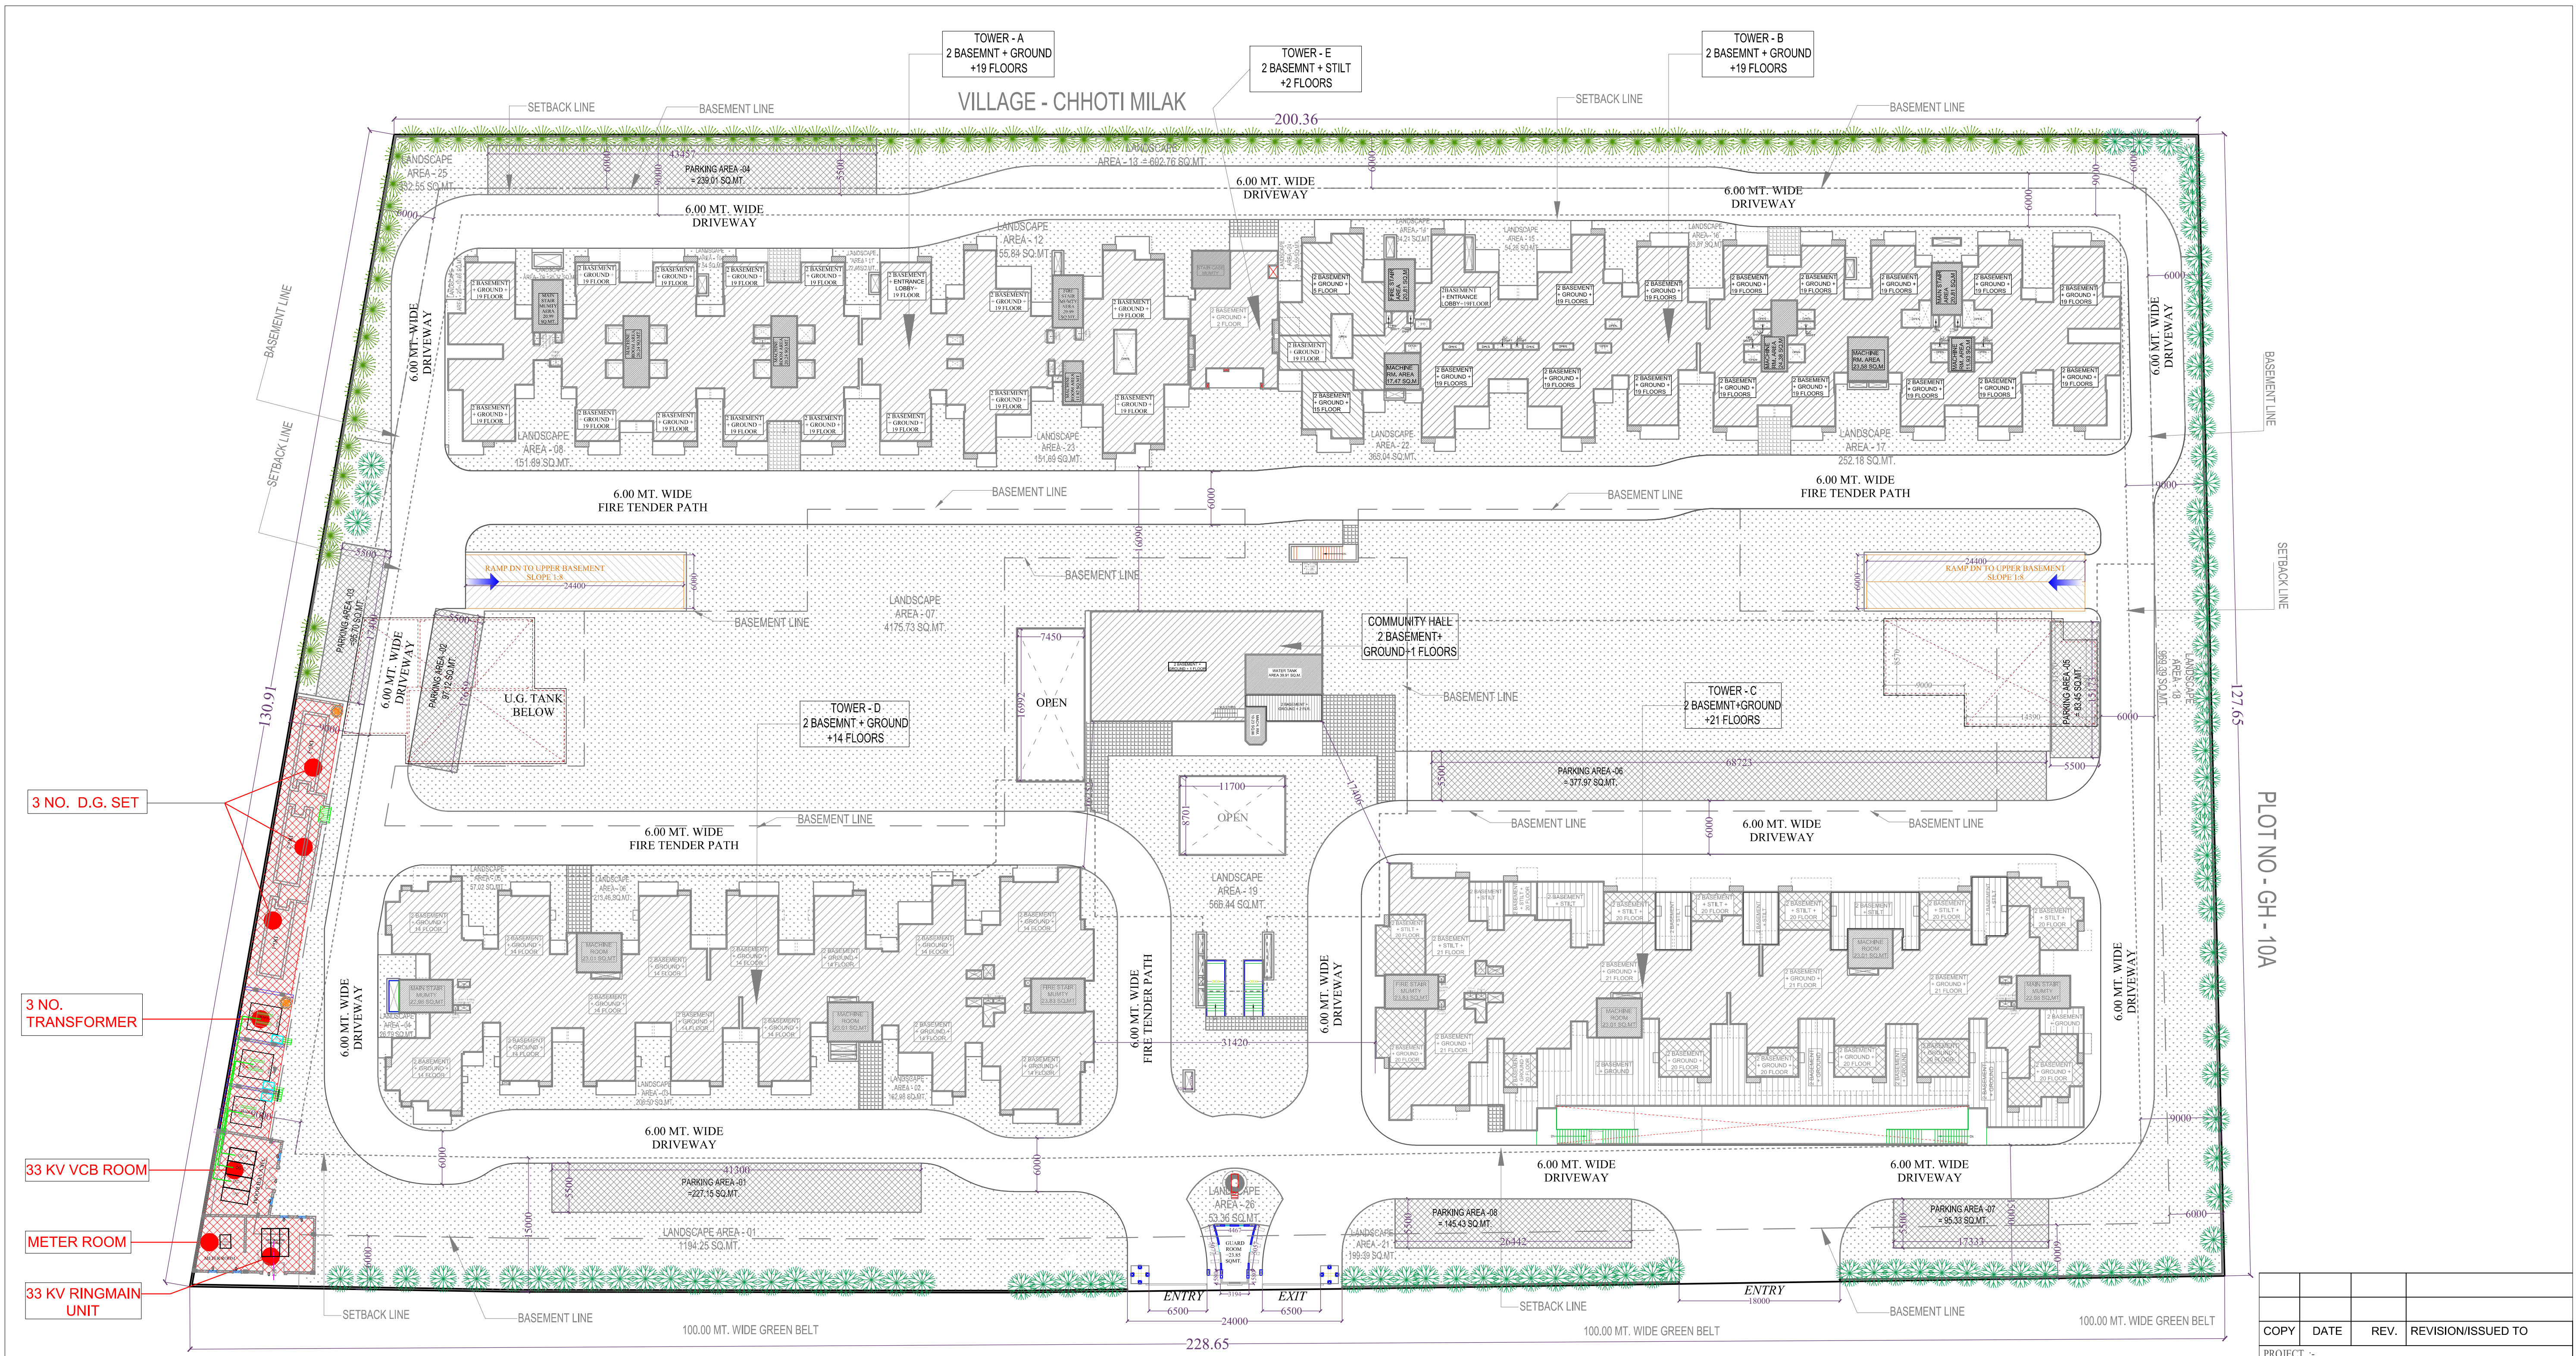

- 3 NO. D.G. SET
- 3 NO. TRANSFORMER
- 33 KV VCB ROOM
- METER ROOM
- 33 KV RINGMAIN UNIT

PLOT NO - GH - 10A

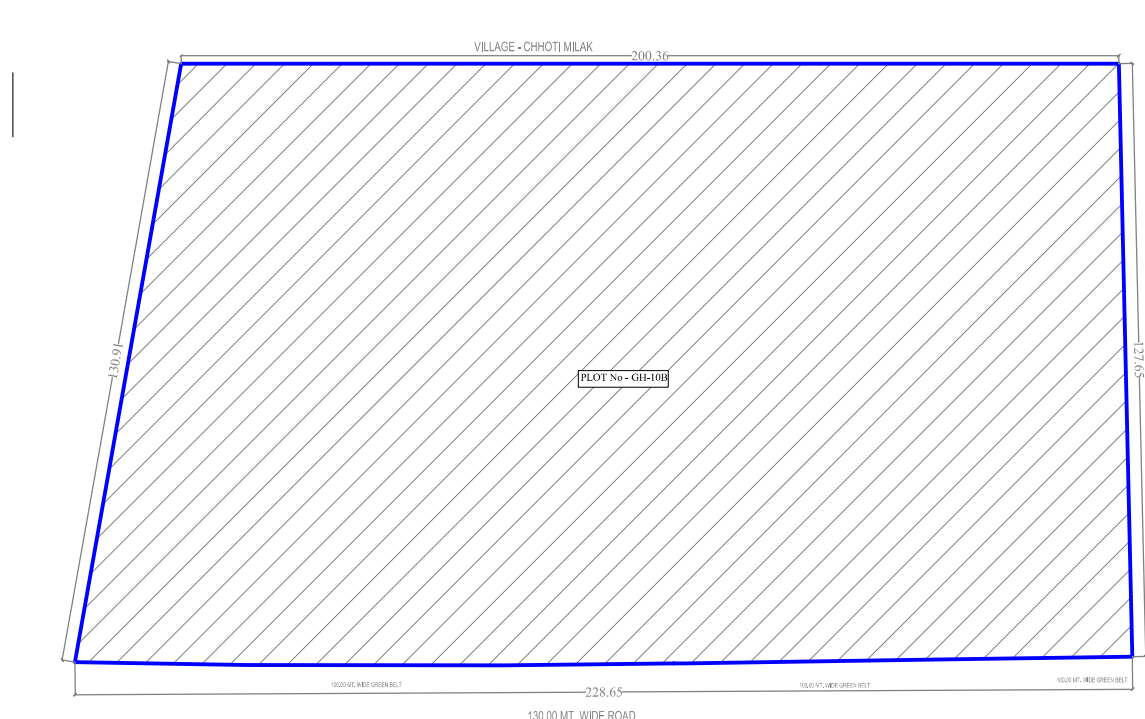

KEY PLAN

SITE PLAN

LEGEND :-	
1	SETBACK LINE
2	BASEMENT LINE
3	TOWER ENTRANCE
4	PARKING AREA

COPY	DATE	REV.	REVISION/ISSUED TO

PROJECT :-
GROUP HOUSING " HIMALAYA PRIDE"
AT PLOT NO - GH-10B , TECH ZONE-IV
GREATER NOIDA (U.P.)

OWNER :-
M/s HIMALAYA REAL STATE PVT.LTD.
REGD. OFFICE : 7365, PREM NAGAR (SHAKTI NAGAR),
NEW DELHI - 110043

DRAWING TITLE :-
ELECTRICITY SUPPLY PLAN

ARCHITECTS :-
Space Designers International
B-34, Sector-67, Noida-201301 (U.P.)
PH : 0971633717, 718, 719, 720
e-mail : spacesdi@gmail.com, www.spacedi.com

ELECTRICAL CONSULTANT
G. R. ELECTRICAL CONSULTANTS
38,D.D.A.SHOPPING CENTRE
SUHDEV VIHAR NEW DELHI-110025
TEL.No.-26836893,TEL/FAX26318925

DRAWN BY	CHECKED BY	DATED	DRWG-NO
ARPAN	R.M.S.	21.06.18	GREC/HM-PRIDE/ESS/EL-02A