


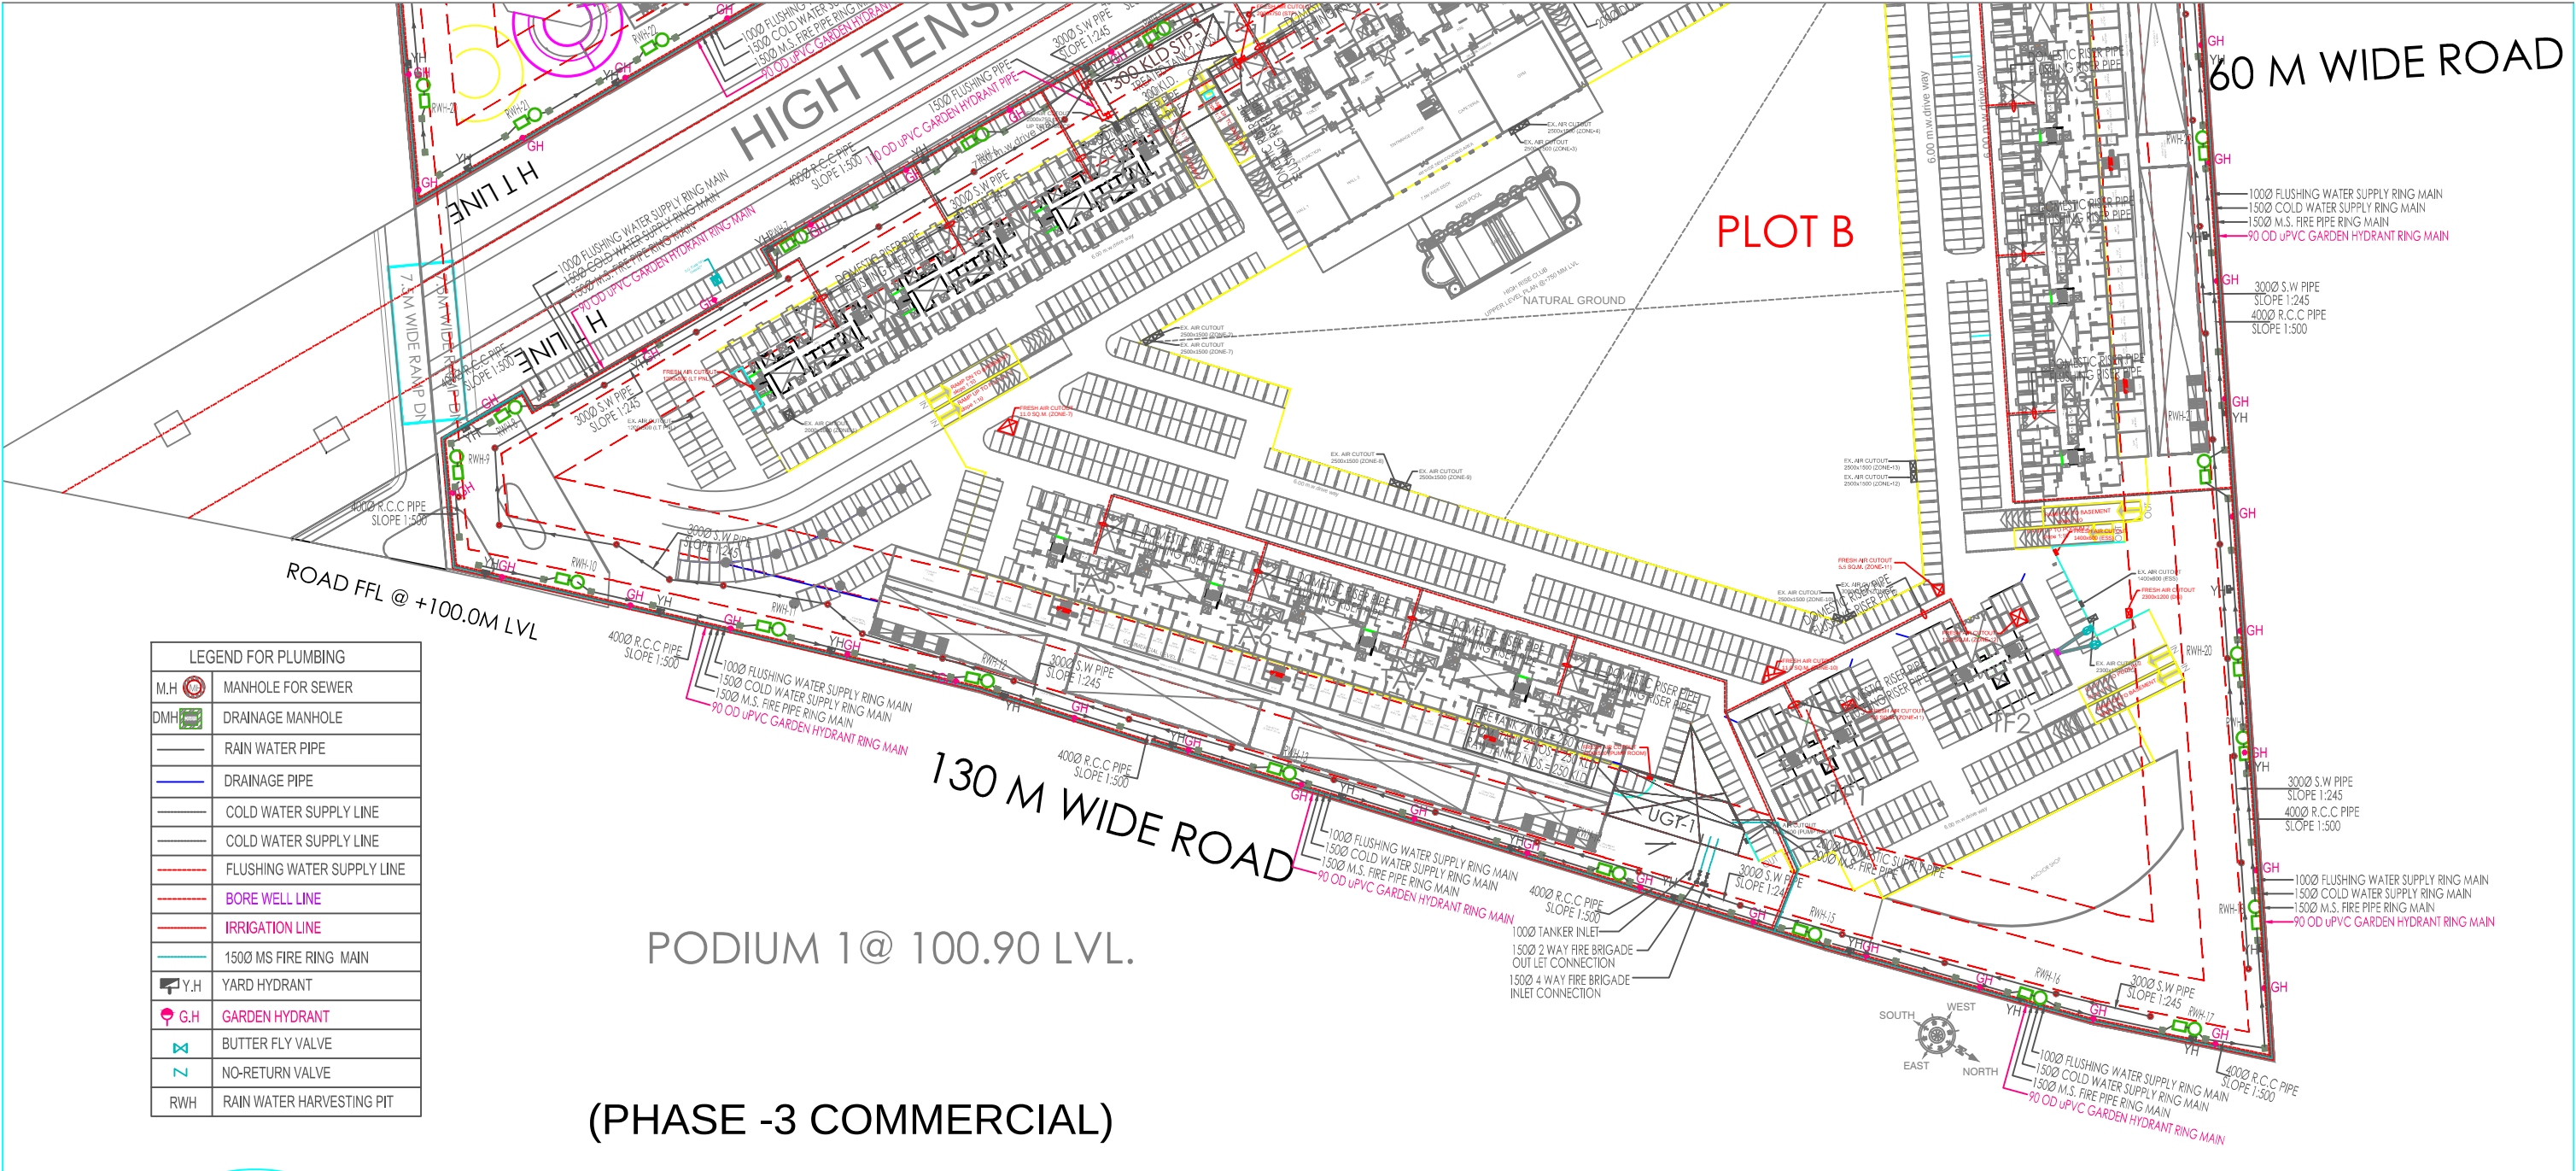

(PHASE -3 COMMERCIAL)

SPORTS CITY AT GREATER NOIDA
PLUMBING & FIRE SITE PLAN

DRAWING TITLE:
CO-ORDINATION LAYOUT (PHASE -3 COMMERCIAL)
SCALE 1:1100 (A1)
DRG.NO. : CO-PL-SP-01

Architect
Hafeez
Contractor