


280-03

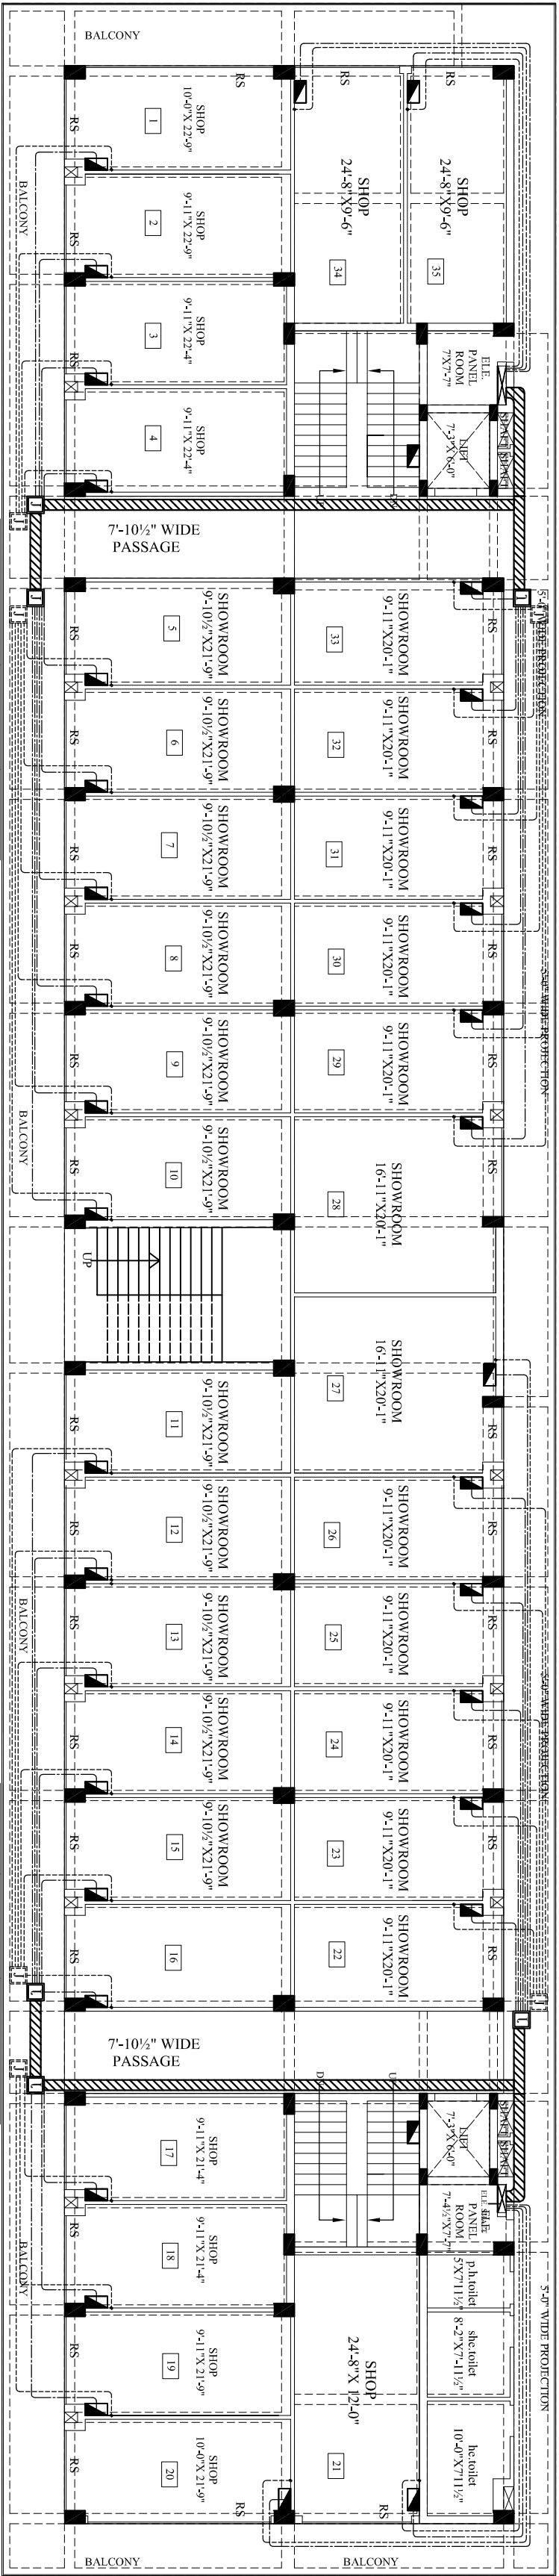

87-51

PROJECT:

PROPOSED COMMERCIAL BUILDING PLAN AT PALLAVPURAM, MEERUT

DRAWING TITLE:-			
CABLE TRAY LAYOUT & SHOP 'S MAINS DISTRIBUTION LAYOUT			
FIRST /SECOND FLOOR PLAN			
SCALE	DATE	DRAWN BY	
NTS	17-10-2019	MANOJ	
DRAWING NO.	REVISION	CHECKED BY	
ES-503	R/0	DT	



ARCHITECTS:

SM ASSOCIATES

PRAVAG FARMS, GARH ROAD, MEERUT, [U.P.]
PH:0121-2600096, M:+91-9927010096
E-mail: sm.associates95@gmail.com

ELECTRICAL CONSULTANTS:

ELECTRO-SOLUTIONS



109-1111, ADITYA PALACE, GARH ROAD, MEERUT
PH. NO. 0121-4005360
MOB: 9837072162
emcill: electro_meerut@yahoo.com