
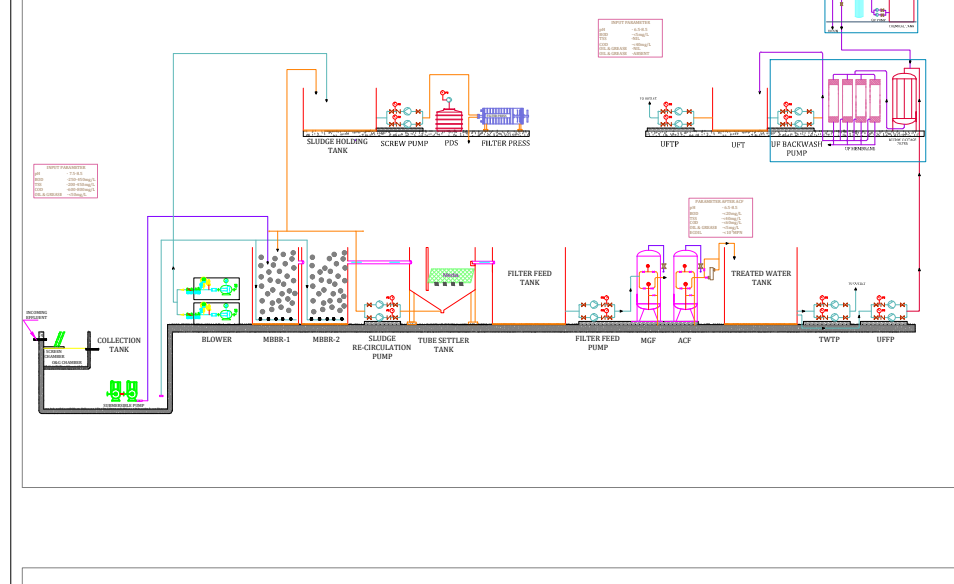
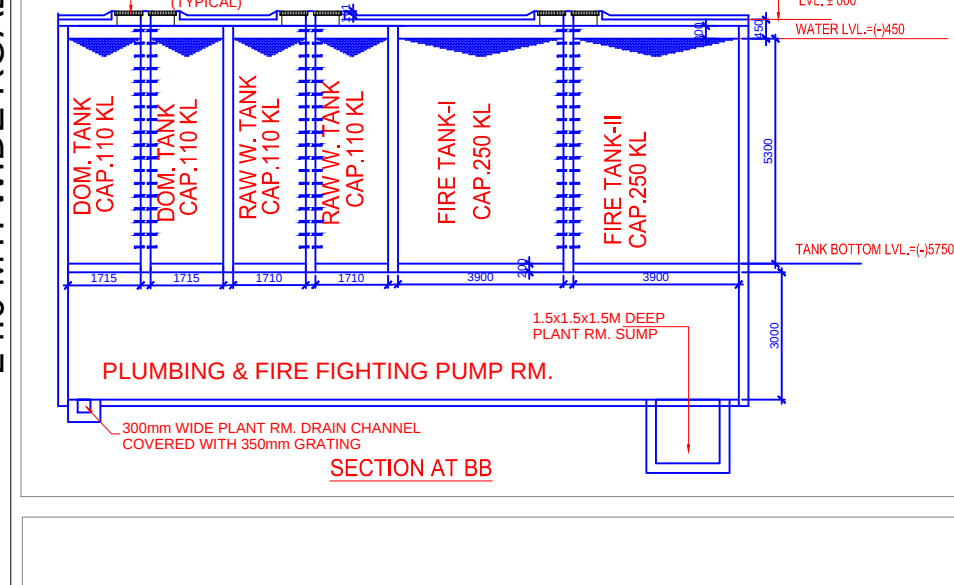
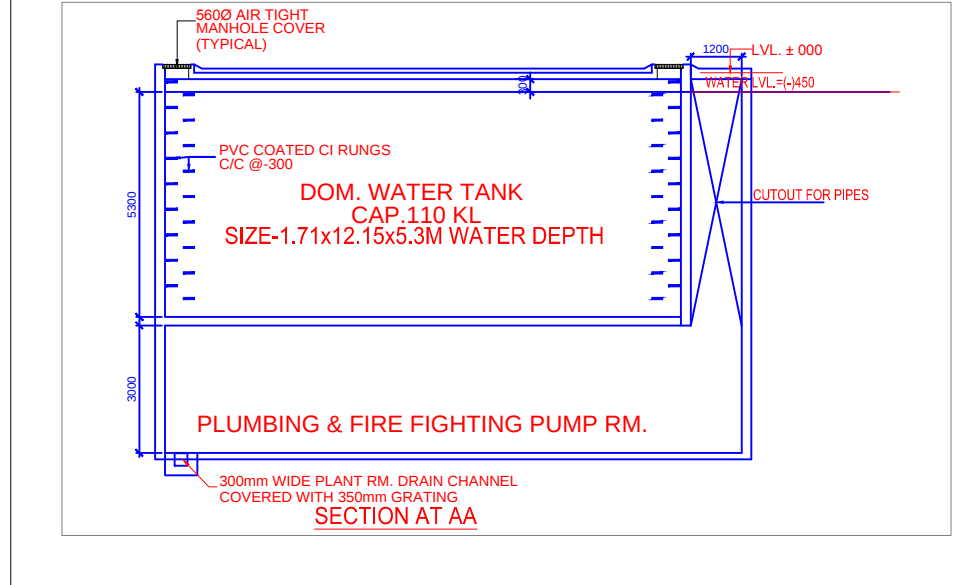
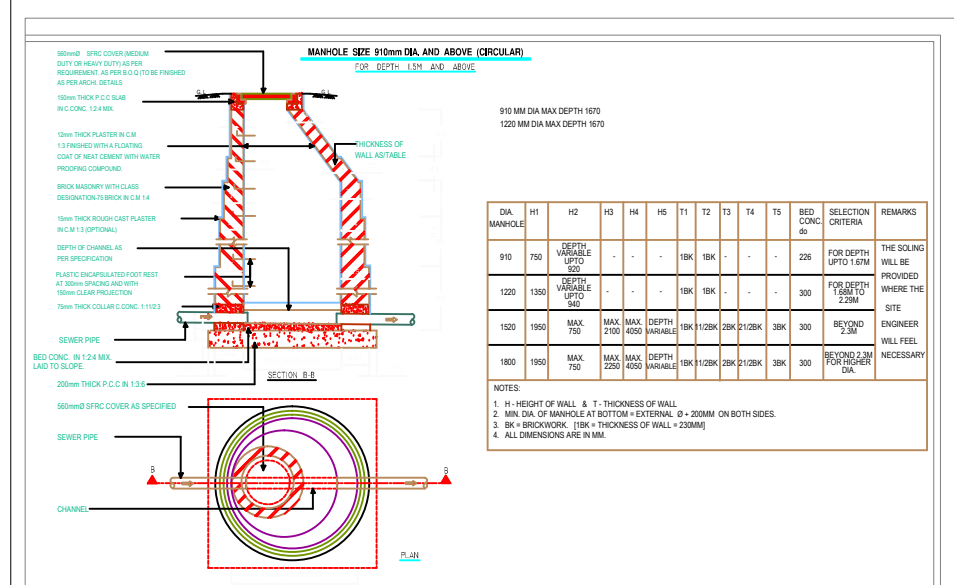
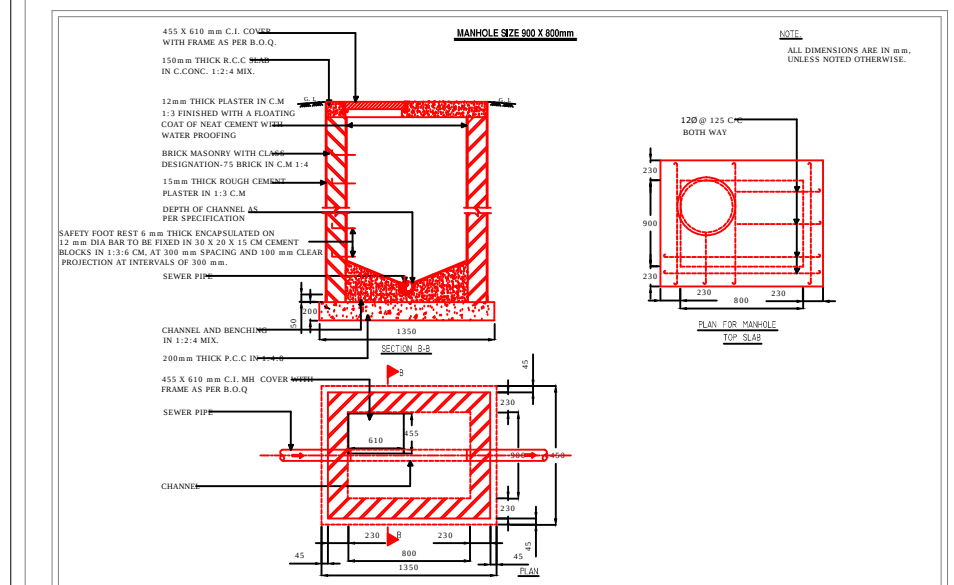


45.0 M. WIDE


PEDESTRIAN ENTRY

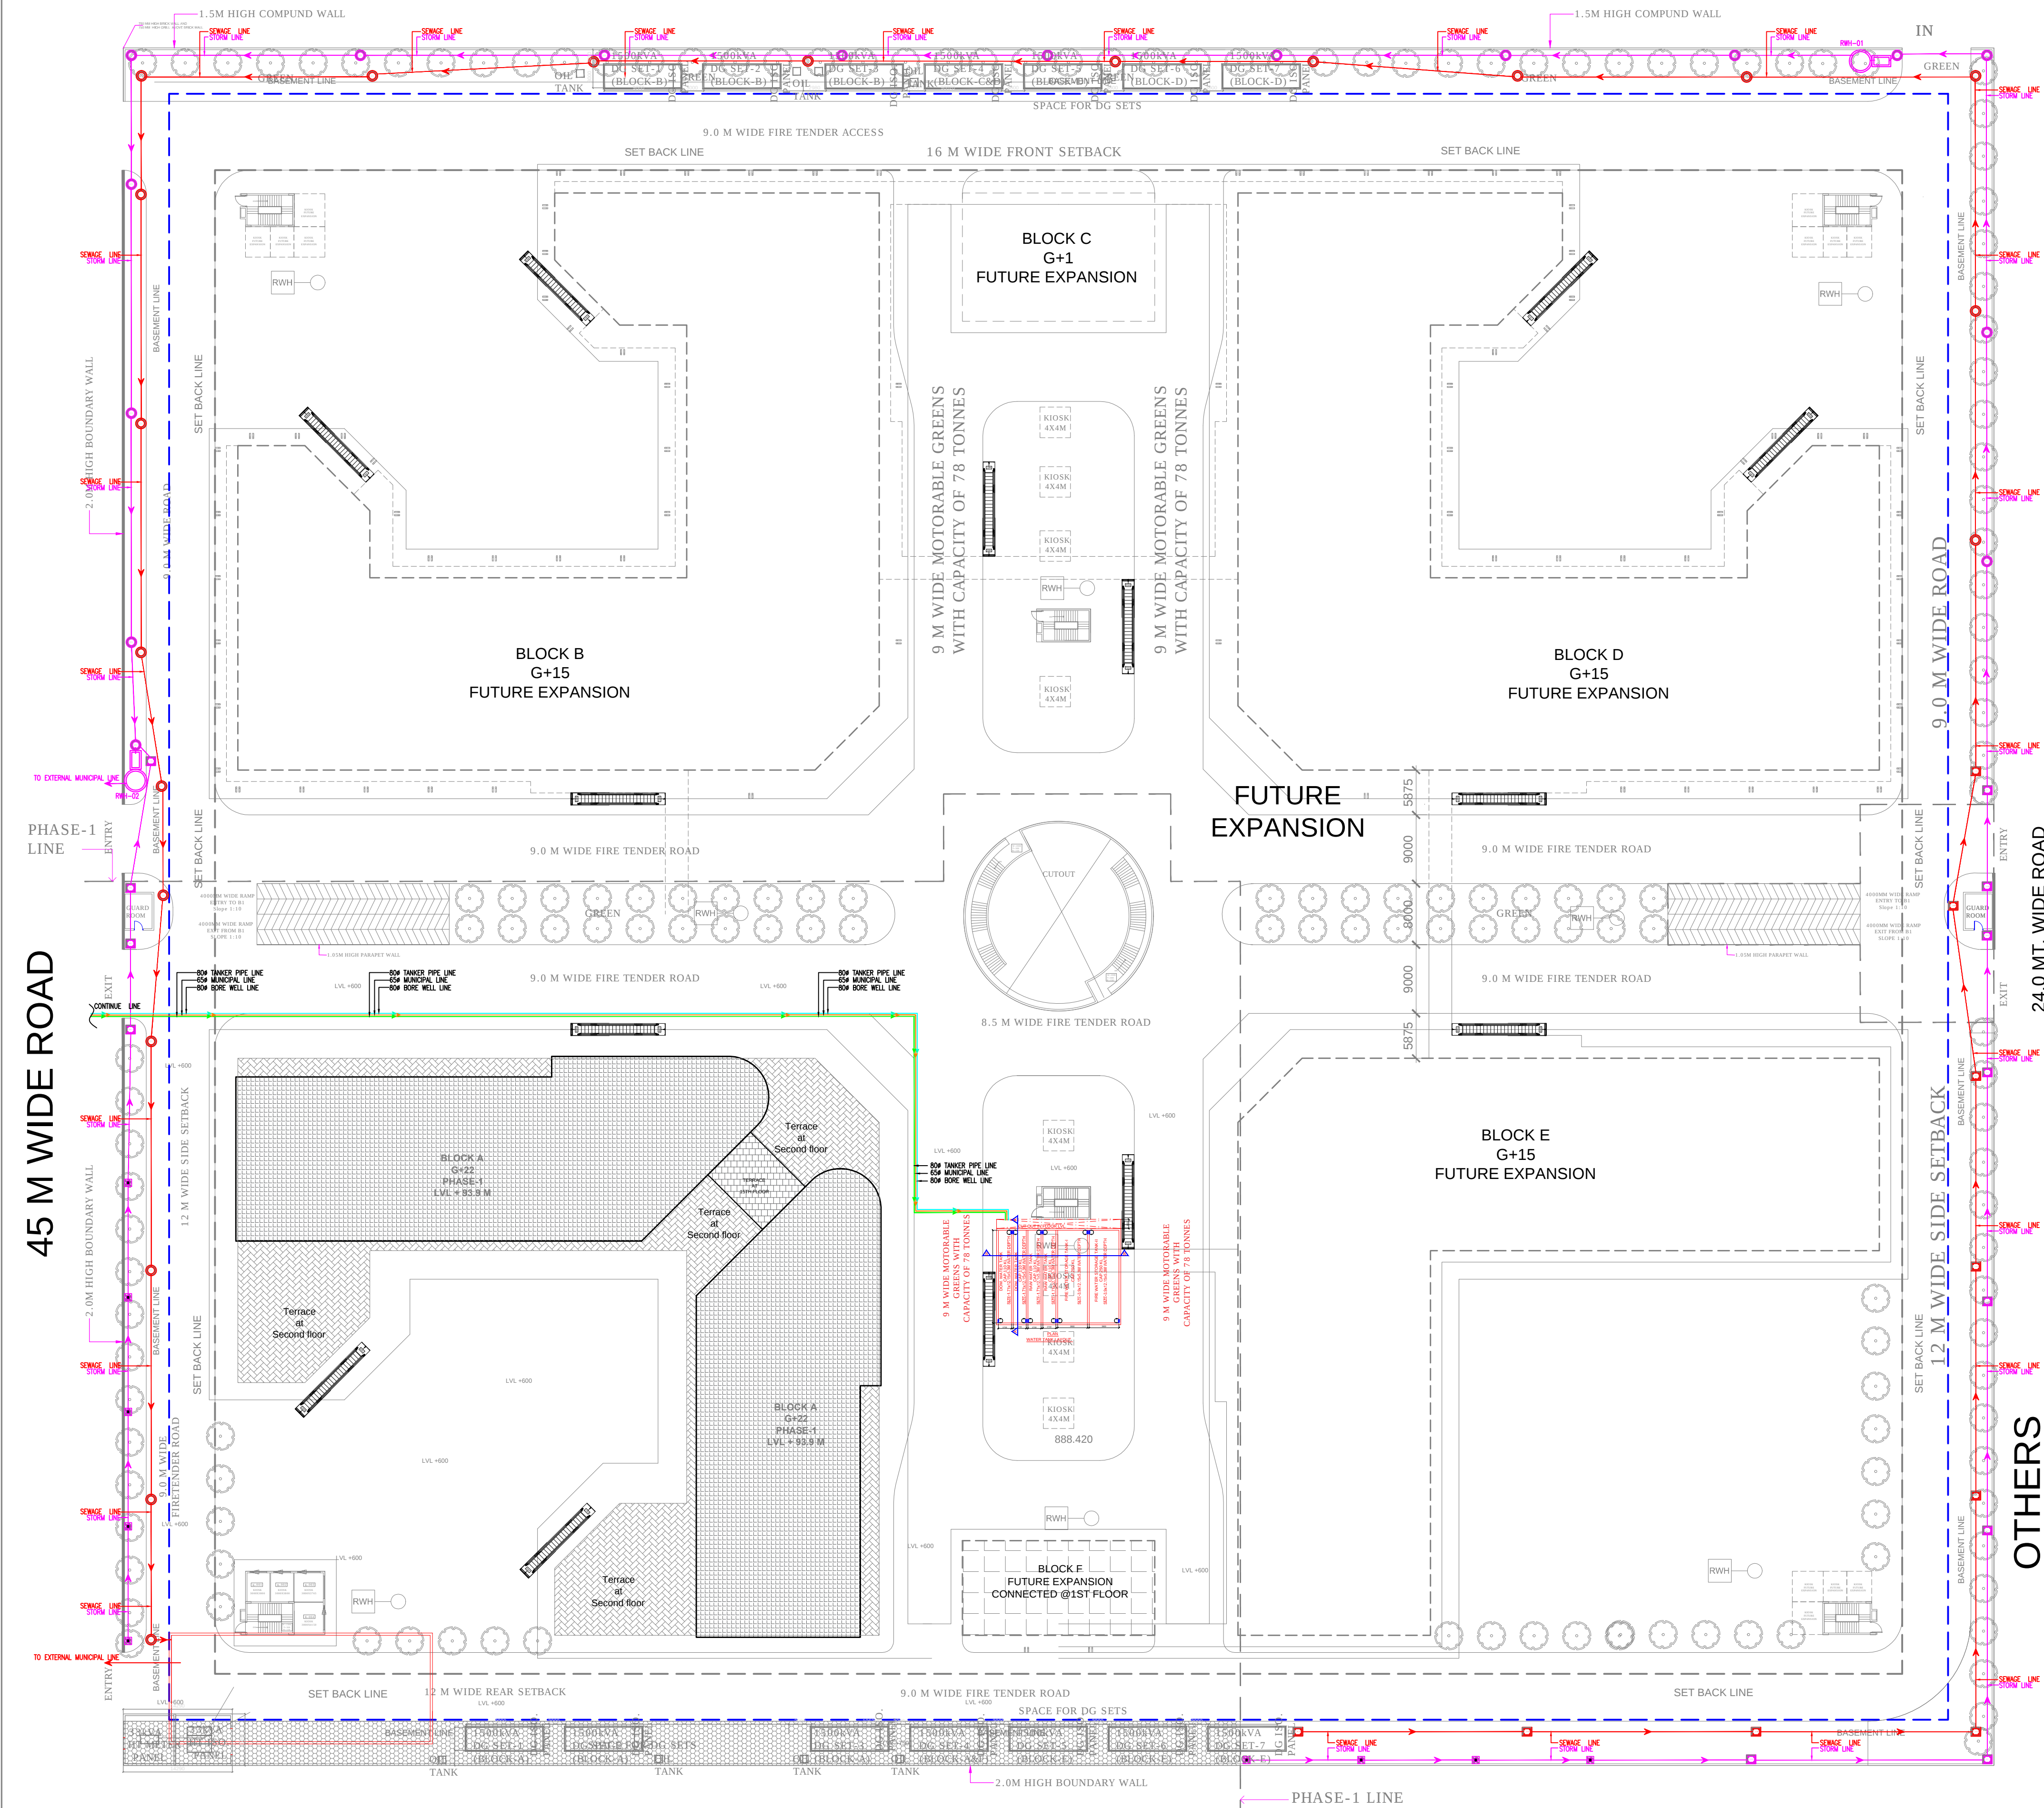

LIST OF ELECTROMECHANICAL UNIT		
S.NO.	DESCRIPTION	UNITS
1	RAW SEWAGE WATER TRANSFER PUMP	2 NOS
2	SLUDGE RECIRCULATION PUMP	2 NOS
3	FILTER FEED PUMP	2 NOS
4	AIR BLOWER	2 NOS
5	MULTIGRADE FILTER	1 NO
6	ACTIVATED CARBON FILTER	1 NO
7	SCREW PUMP	2 NO
8	ULTRA FILTRATION	1 NO
9	UF FEED PUMP	2 NO
10	UF BACK WASH PUMP	2 NO
11	UF CP PUMP	2 NO
12	TREATED WATER PUMP	2 NO
13	UF TRANSFER PUMP	2 NO
14	FILTER PRESS	1 NO

LEGEND	
MARK	DESCRIPTION
---	AIR LINE
---	SLUDGE LINE
---	EFFLUENT LINE
---	EFFECTIVE WATER LEVEL
---	BALL VALVE
---	NON RETURN VALVE
---	DIFFUSER/FIXED GRID
---	PUMP
---	AIR BLOWER
---	ROTO METER

PLUMBING LEGEND	
---	SEWERAGE LINE
---	STORM LINE
---	TANKER SUPPLY LINE
---	BORE WELL LINE
---	MUNICIPAL LINE
---	WATER FLOW
---	SEWAGE MH
---	SEWAGE MH
---	CATCH BASIN
---	STORM MH
---	STORM MH

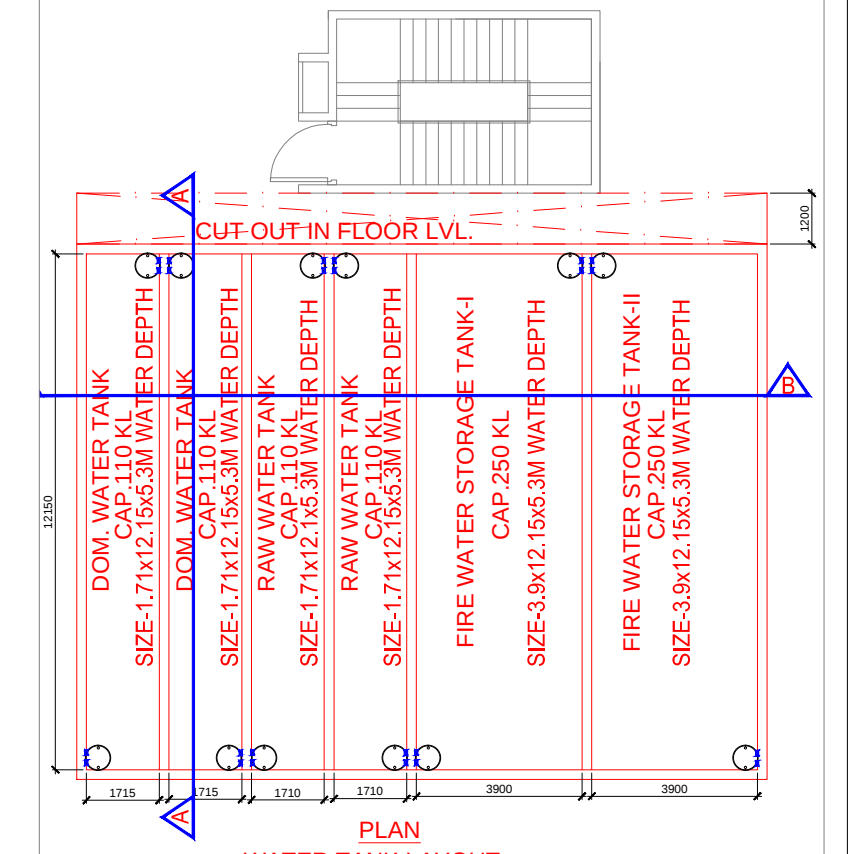

RERA SUBMISSION DRAWING

NO	DATE	REVISION DISCRPTION

PURPOSE OF DRAWING
G.F.C ☐ F.I.O ☐ TENDER ☐

PROJECT
IT/ITES BUILDING
PLOT NO. 1A, Sector 140A,
Noida, Uttar Pradesh 201305

CLIENT
FAIRFOX ITINFRA PRIVATE LIMITED
REDD ADDRESS:- PLOT NO. DV.GH.99C.SEC. TECHZONE IV,
GREATER NOIDA WEST, UTTAR PRADESH

STRUCTURE CONSULTANT
NNC DESIGN INTERNATIONAL
CONSULTING STRUCTURAL ENGINEERS
G-70, 2nd FLOOR, JASWANT PLAZA, NEAR KALINDI KUNJ MAIN SARITA
VIHAR ROAD, OKHLA, NEW DELHI-110025PHONE NO.: +91-11-26940734/5/6/7/8
FAX: 26940738 E-Mail: nnc_consultants@hotmail.com
Web: www.ncdesigninternational.com

MEP CONSULTANT
MULTIPLE SERVICE CONSULTANT
253/B, Rajpur Khurd Extension,
Chattarpur, New Delhi-110068,
Ph. no. -8920225677/8920228058
mscigbc@gmail.com

LANDSCAPE CONSULTANT
INTEGRAL DESIGNS
LANDSCAPE ARCHITECTURE, LIGHTING DESIGN
E-90, ANAND KRENTAL NEW DELHI-110021
E-301, KANAK DHAR
email: designintegral@gmail.com

ARCHITECT
DESIGN FORUM
INTERNATIONAL
ARCHITECTURE, URBAN DESIGN, TOWN PLANNING

K-47, KAILASH COLONY, NEW DELHI-110048
PH. NO:- 011-46556600, FAX:- 011-46556601
www.designforuminternational.com.

Date : 25-10-2021

Scale : 1:325

Rev. No. R 01

Sheet Title
SITE PLAN WATER SUPPLY AND DRAINAGE PLAN

Sheet No.
MSC/DFI/NOIDA/IT/SP/PL-01