



- FIRE DOOR WITH TWO HOURS FIRE RESISTANCE
- INTERNAL HYDRANT WITH HOSE REEL
- FLOW SWITCH
- BUTTER FLY VALVE
- SMOKE DETECTOR
- MANUAL CALL POINT
- HOOTER
 - CO2 TYPE FIRE EXTINGUISHER
 - WATER CO2 TYPE FIRE EXTINGUISHER
 - SPRINKLER SYSTEM

- YARD HYDRANT
- SLUICE VALVE
- BUTTER FLY VALVE
- FIRE BRIGADE CONNECTION(INLET)
- FIRE BRIGADE CONNECTION(OUT LET)

S.NO.	DESCRIPTION	
1.	NAME OF OWNER	Eldeco Housing & Industries Ltd.
2.	BUILDING NAME	BLOCK-D, GROUP HOUSING ON KH. NO.58,59,60,61,83,84,85/1 & 85/2 AT MOHIBULLAPUR,SITAPUR ROAD,LUCKNOW.
3.	NAME /REG. NO.-ARCH.	Sanjay Kr. Gupta C.A./89/12382
4.	COVD. AREA	9602.58sq.mt.
5.	HT. & INTER DISTANT	33.45mt. & 12.0mt.
6.	NOS. OF FLOORS (LESS BASEMENT)	GR.+10 floors
7.	NOS. OF BASEMENT	-
8.	PURPOSE OF BASEMENT	-
9.	COVD. AREA FLOORWISE	942.24sq.mt.
10.	APPROX. NO. OF OCCUPANTS	84flatsx5=420
11.	TYPE OF OCCUPANTS	residential
12.	SURROUNDING east west north south	Sitapur-Lucknow road other's property village road other's property
13.	SET-BACK	13.0mt.
14.	LENGTH OF ACCESS ROAD	on main road
15.	WIDTH OF ACCESS ROAD	76mt.
16.	GATE- HEIGHT & WIDTH	open gate
17.	NO. OF STAIRCASE-1.5mt.	4nos.

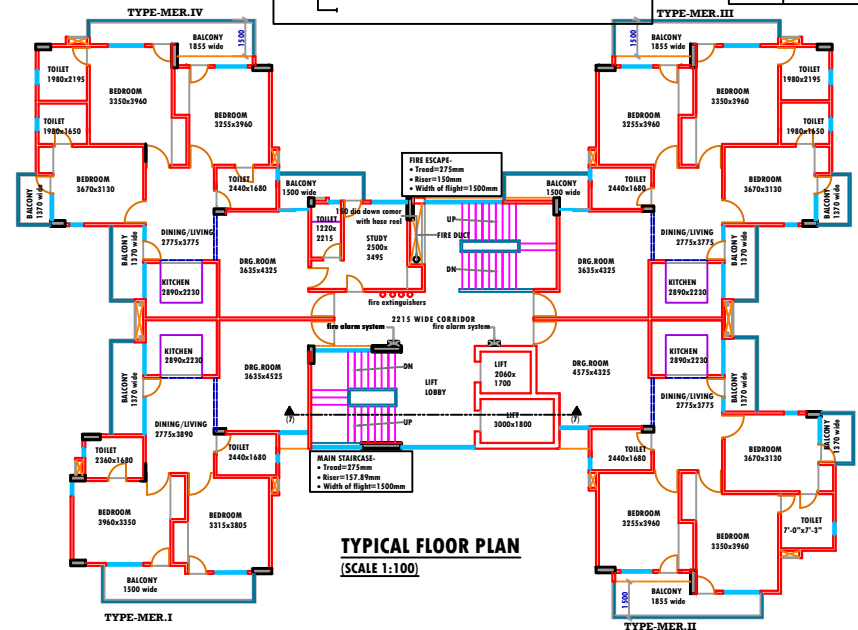


TYPICAL FLOOR PLAN (SCALE 1:100)

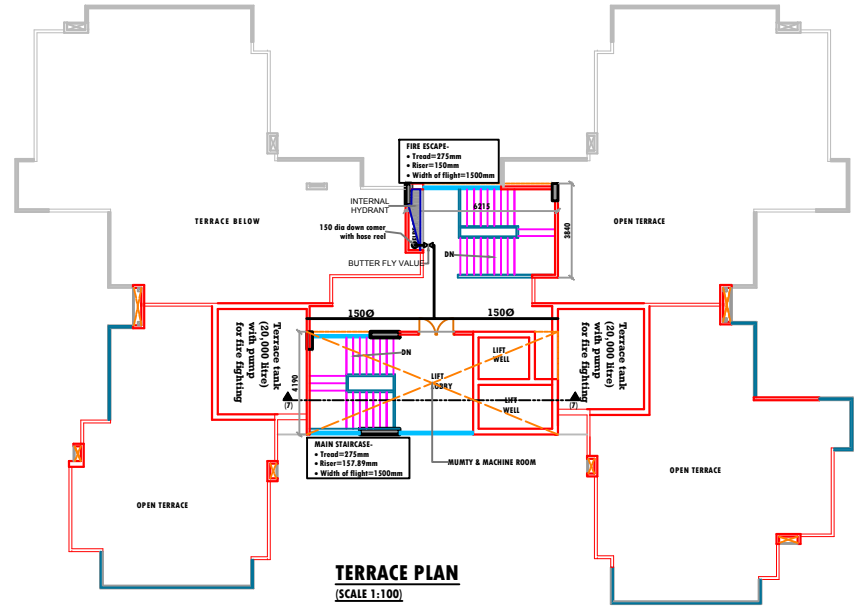

TERRACE PLAN (SCALE 1:100)


- HP- HYDRANT PUMP / MAIN ELECTRIC PUMP
- JP- JOCKEY PUMP
- DP- DIESEL PUMP
- SP- SPRINKLER PUMP
- SH- SUCTION HEADER
- DH- DLIVERY HEADER
- R- PIPE TO RISER
- Y- PIPE TO YARD HYDRANT
- S- PIPE TO SPRINKLER SYSTEM
- AV- AIR VESSEL
- ICV- INSTALLATION CONTROL VALVE

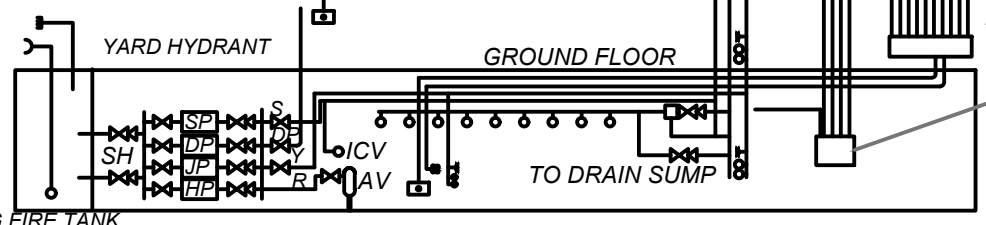


TYPICAL ARRANGEMENT OF WET RISER AND TOTAL SPRINKLER SYSTEM OF BUILDING OTHER THAN APARTMENT EXCEEDING 30.0 M IN HEIGHT

BLOCK-D(2nos.)-MERVILLE(FIRE FIGHTINGARRANGEMENTS/PROVISIONS)

PROMOTER: GROUP HOUSING ON KH. NO.58,59,60,61,83,84,85/1 & 85/2 AT MOHIBULLAPUR,SITAPUR ROAD,LUCKNOW.		ARCHITECT espaces Ar. Sanjay Kumar Gupta 108.F. Floor,Corporate Chamber-1, Vibhuti Khand, Gomti Nagar, Lucknow-226010 Ph.No.4065958,9415114589 email-espaces_arch@rediffmail.com	
DRG.NO. fire/01	SCALE: 1:100	OWNER	

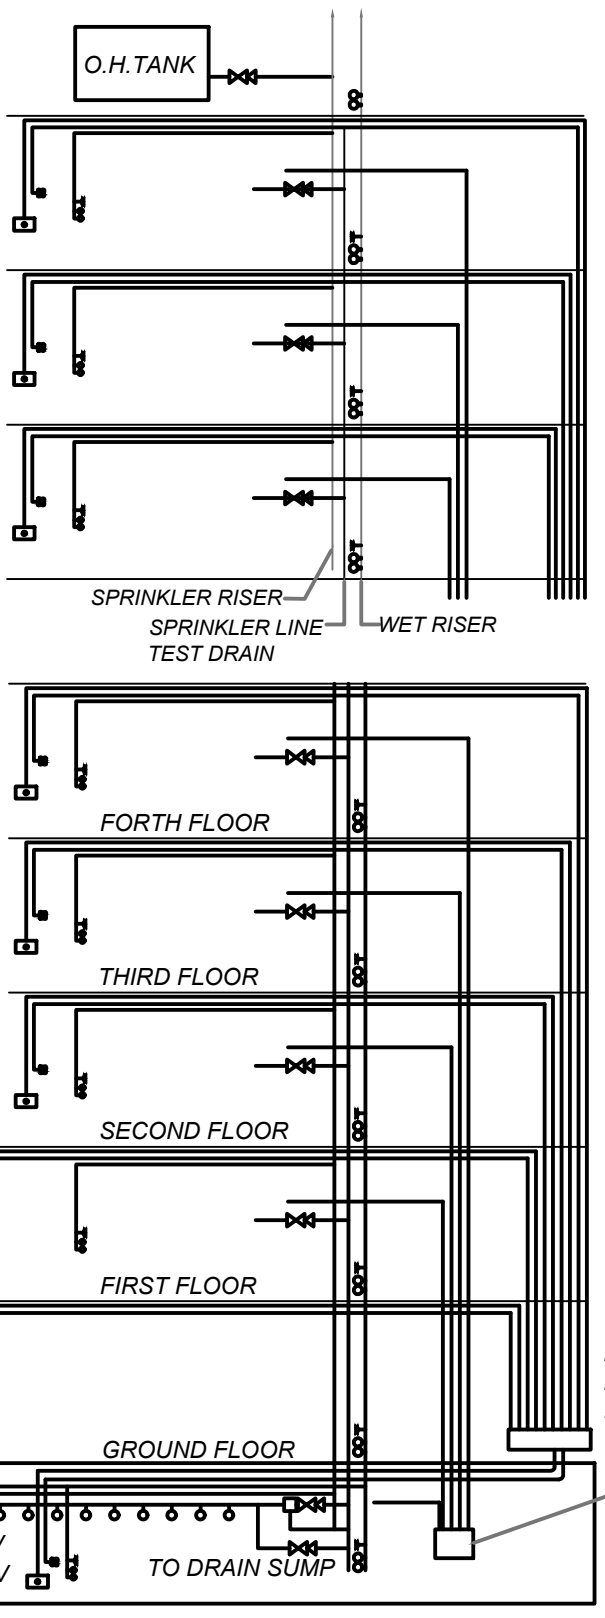

- HOSE REEL
- SINGLE HEAD LANDING VALVE
- AIR RELEASE VALVE
- SLUICE VALVE
- NON-RETURN VALVE
- FLOW SWITCH
- SPRINKLER HEAD
- CABLE TO ANNUNCIATION PANEL
- CABLE CONDUIT FOR HOOTER
- CABLE CONDUITE FOR MANUAL CALL BOX
- HOOTER
- MANUAL CALL BOX
- FIRE BRIGADE DRAW FROM TANK
- FIRE BRIGADE INLET TANK FILLING

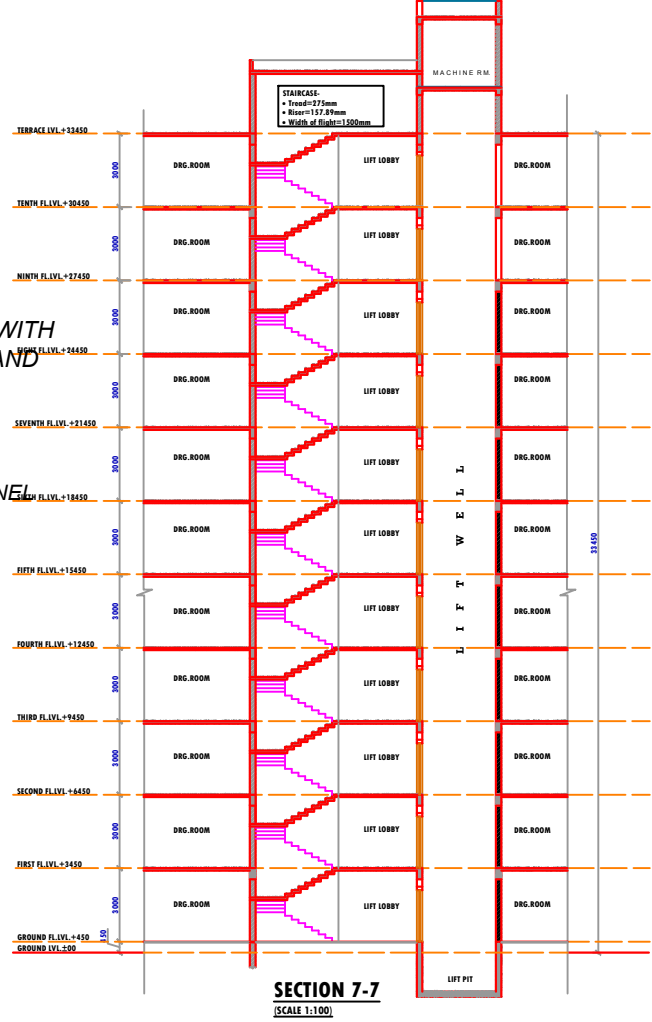

SECTION 7-7 (SCALE 1:100)

NOTE: DEVELOPER SHALL BE SOLELY RESPONSIBLE FOR INSTALLING / PROVIDING/MAINTAINING ALL FIRE FIGHTING ARRANGEMENTS SHOWN IN THIS DRAWING AND INSTRUCTED BY FIRE DEPARTMENT.