


ELECTRICAL PLAN

SN. NO.	LEGEND	DESCRIPTION
1.		MAIN HOLE
2.		HIT AND LT CABLE TRENCH 450MM (W) X 100MM (D)
3.		ELECTRICAL POLE
4.		TRANSFORMER

PROJECT: SHOPPING ARCADE AT KURSI ROAD, LUCKNOW	SHEET TITLE: ELECTRICAL PLAN	LICENSE NO. & STAMP:	EMAIL: info@edgearchitects.in
DATE: 10/12/2023	DRN. BY: EA	CHK. BY: S.N.KHAULI	SCALE: AS NOTED
SHEET: 02/04	ARCHITECTURAL CONSULTANT:		
STRUCTURAL CONSULTANT:			

Salman Nasir Khalil
ARCHITECT
CA/2013/60995

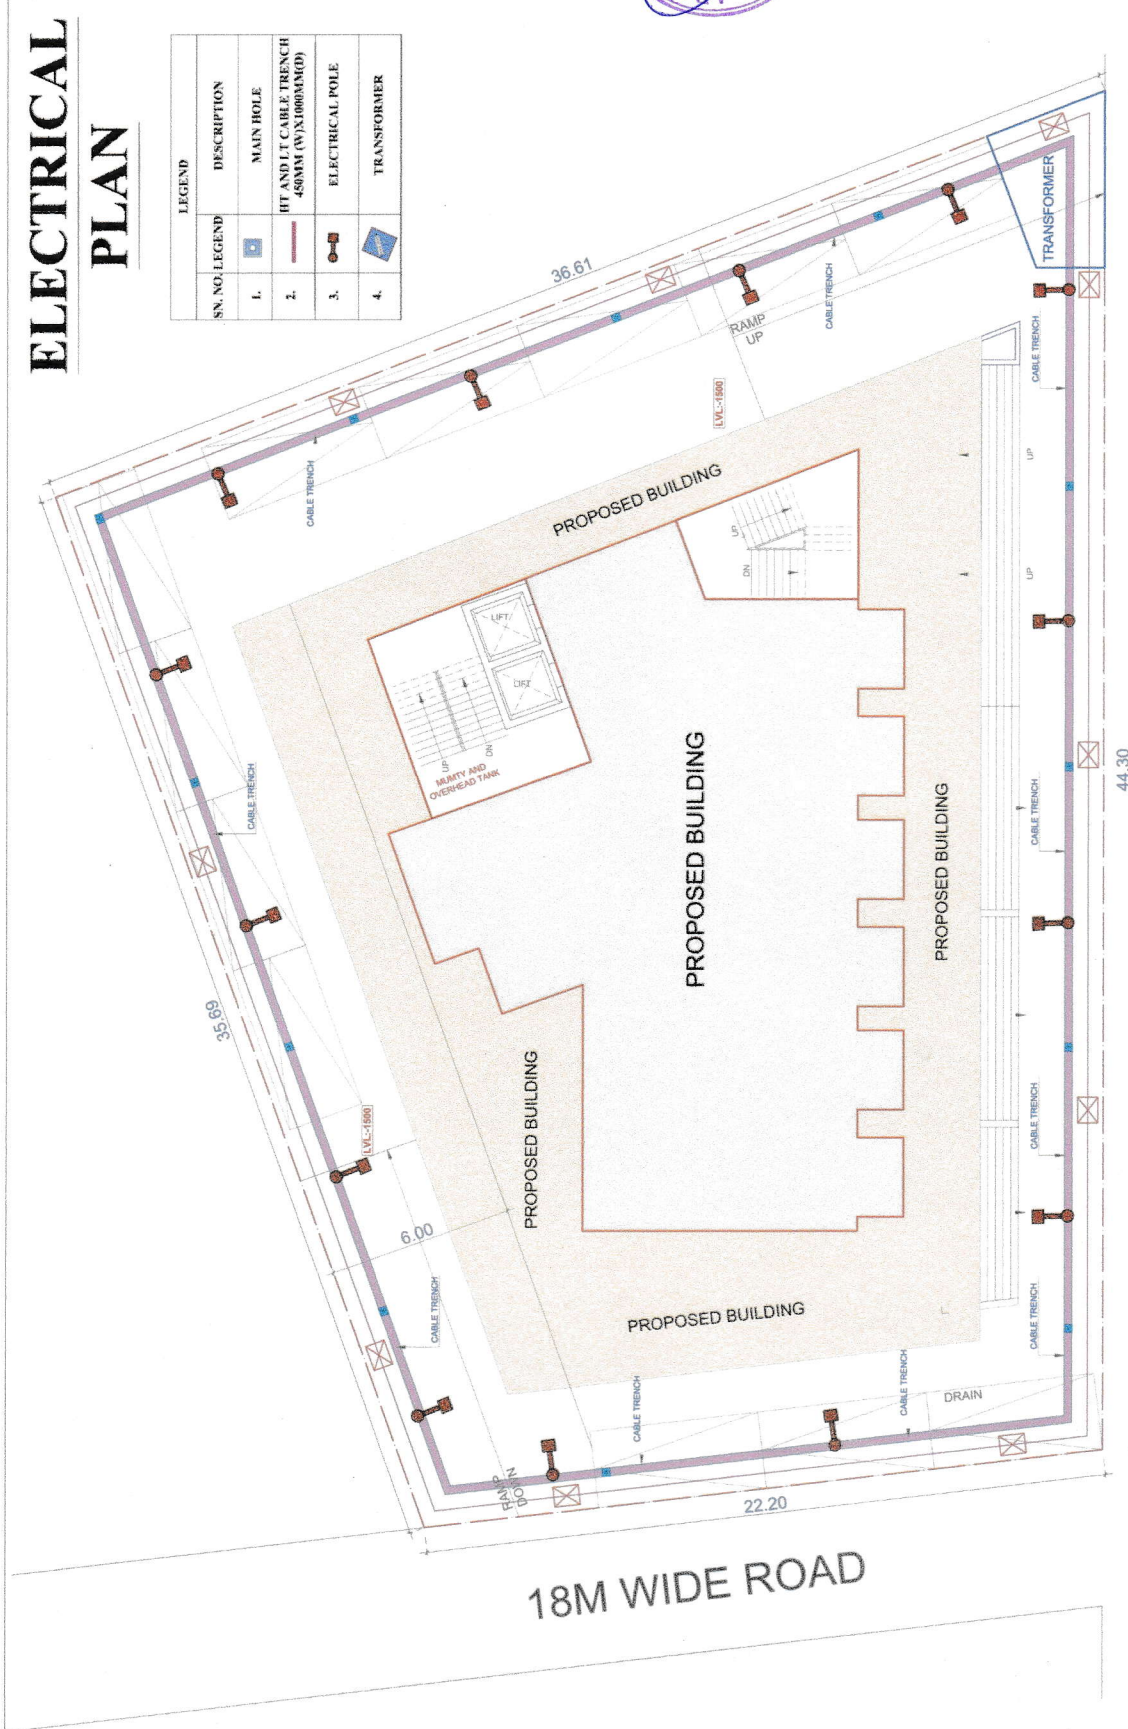

KURSI ROAD