


# MDP




## SL-FP

LIGHT POLE (S1)  
SINGLE L. POLE (18 NOS.)

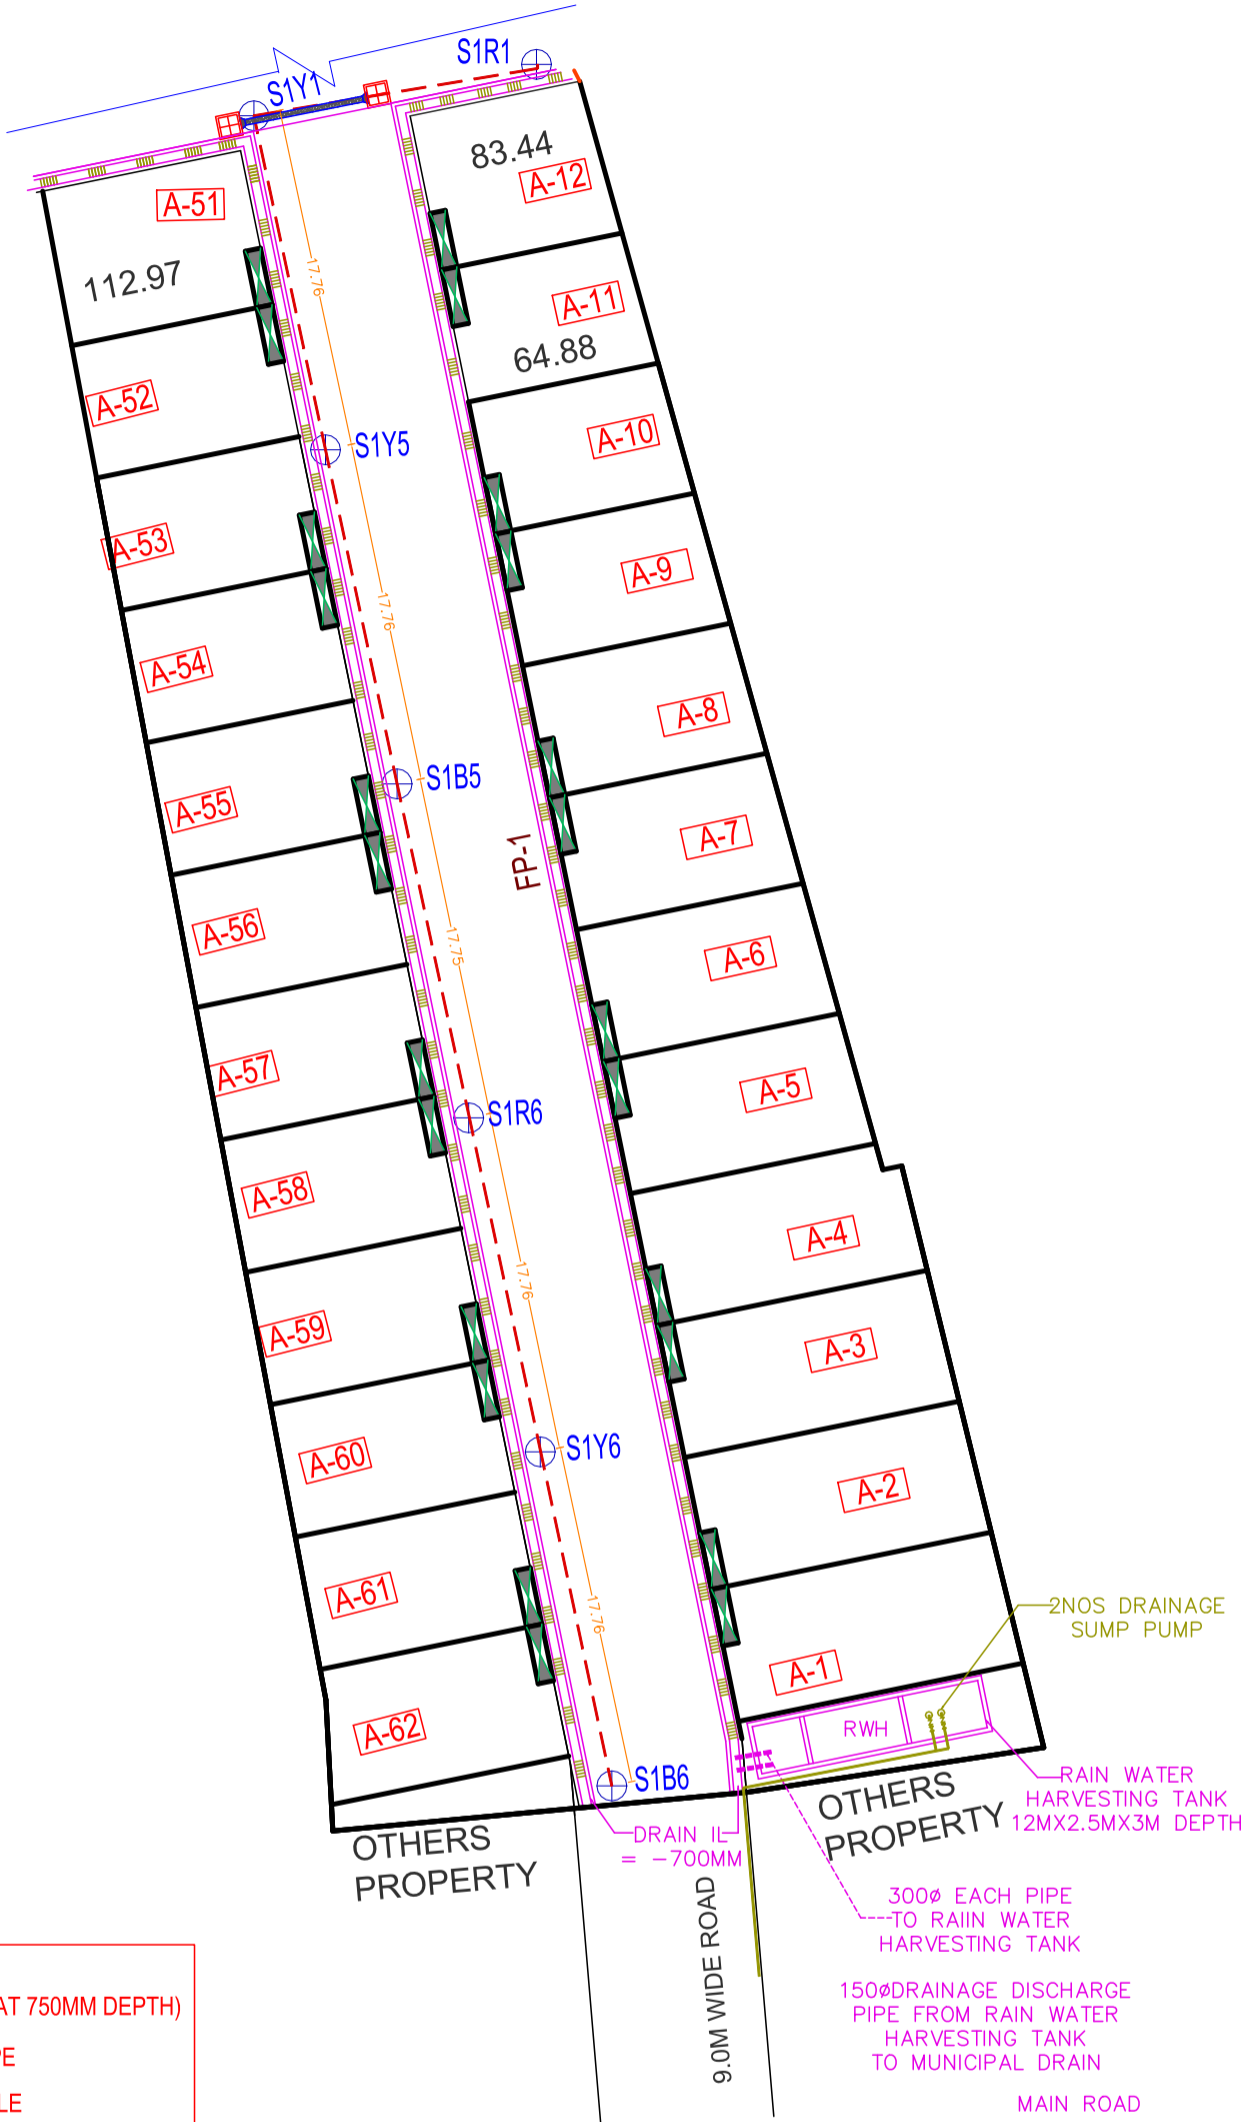

**ELECTRICAL LEGENDS:**


-  CHAMBER (600X600MM AT 750MM DEPTH)
-  150MM Ø RCC HUME PIPE
-  4CX6 SQMM A2XFY CABLE
-  STREET LIGHT FEEDER PILLAR
-  SINGLE LIGHT POLE

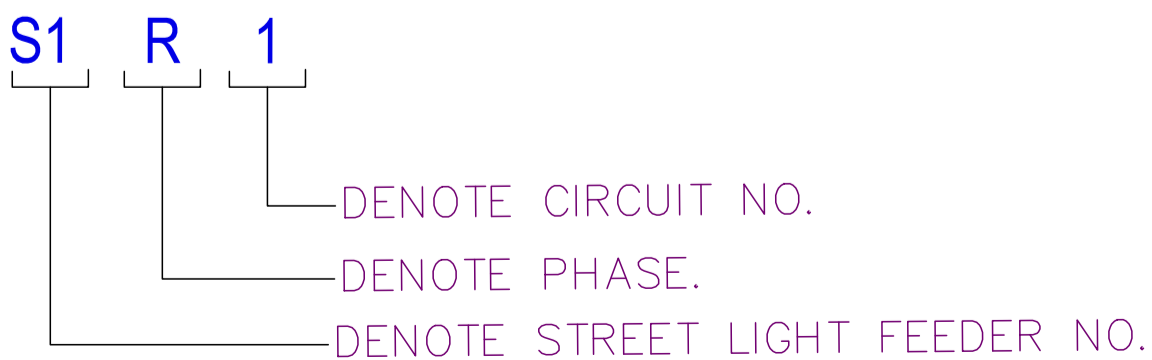

PROJECT:	
TITLE: STREET LIGHTING LAYOUT	
DATE	11-04-2022
DRG. NO.	ES-0000 R-00
DELT. BY	MANOJ
CHKD. BY	D.T.




ELECTRICAL CONSULTANTS:

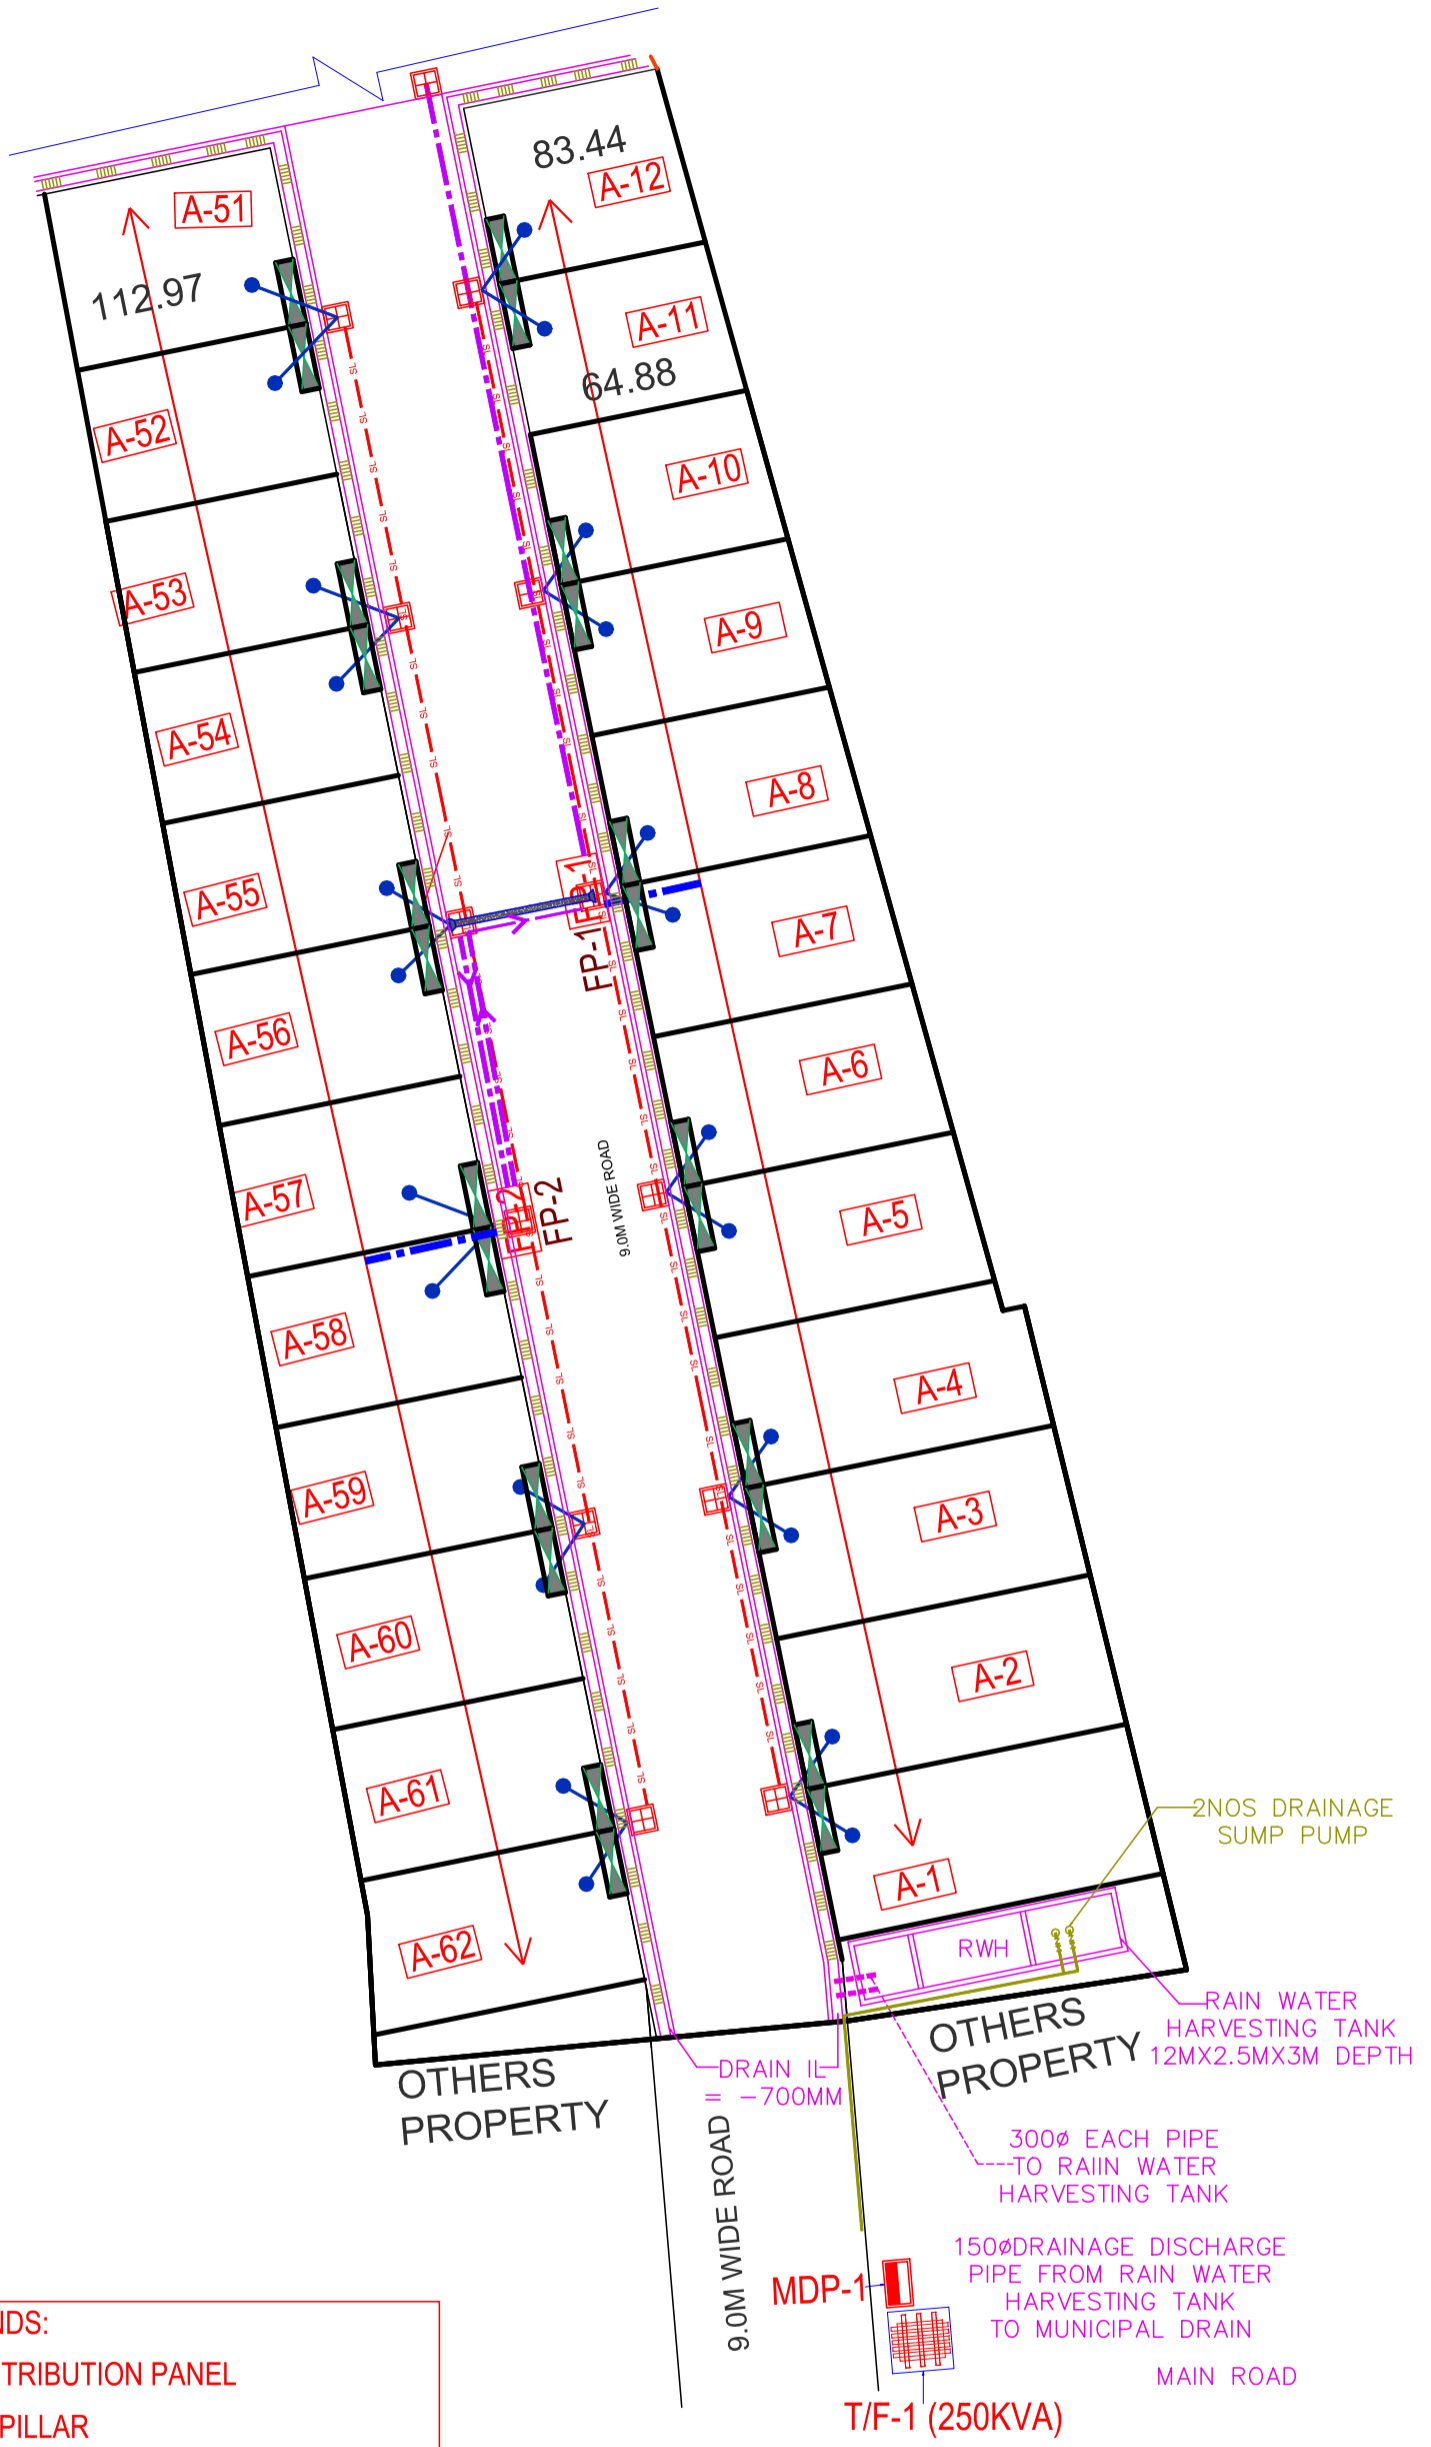
**ELECTRO-SOLUTIONS**  
 109-111, ADITYA PALACE, GARH ROAD, MEERUT  
 PH. NO. 0121-4005360  
 MOB. 983702162  
 email: electro\_meerut@yahoo.com



**ELECTRICAL LEGENDS:**

-  MAIN DISTRIBUTION PANEL
-  FEEDER PILLAR
-  TRANSFORMER
-  CHAMBER (600X600MM AT 750MM DEPTH)

-  2 Nos. 100MM Ø PIPE (For Electrical Services )  
+ 2 Nos. 40MM Ø (For LV Services )PIPE IN GROUND
-  MDP TO FP (UNDERGROUND CABLE)
-  1NO. 40MM+1NO. 25MM PVC PIPE IN GROUND

PROJECT:	
TITLE: ELECTRICAL CABLE ROUTING PLAN	
DATE	11-04-2022
DRG. NO.	ES-0000 R-00
DELT. BY	MANOJ
CHKD. BY	D.T.
ELECTRICAL CONSULTANTS:	
 <b>ELECTRO-SOLUTIONS</b> 109-111, ADITYA PALACE, GARH ROAD, MEERUT PH. NO. 0121-4005360 MOB: 9837072162 email: electro_meerut@yahoo.com	