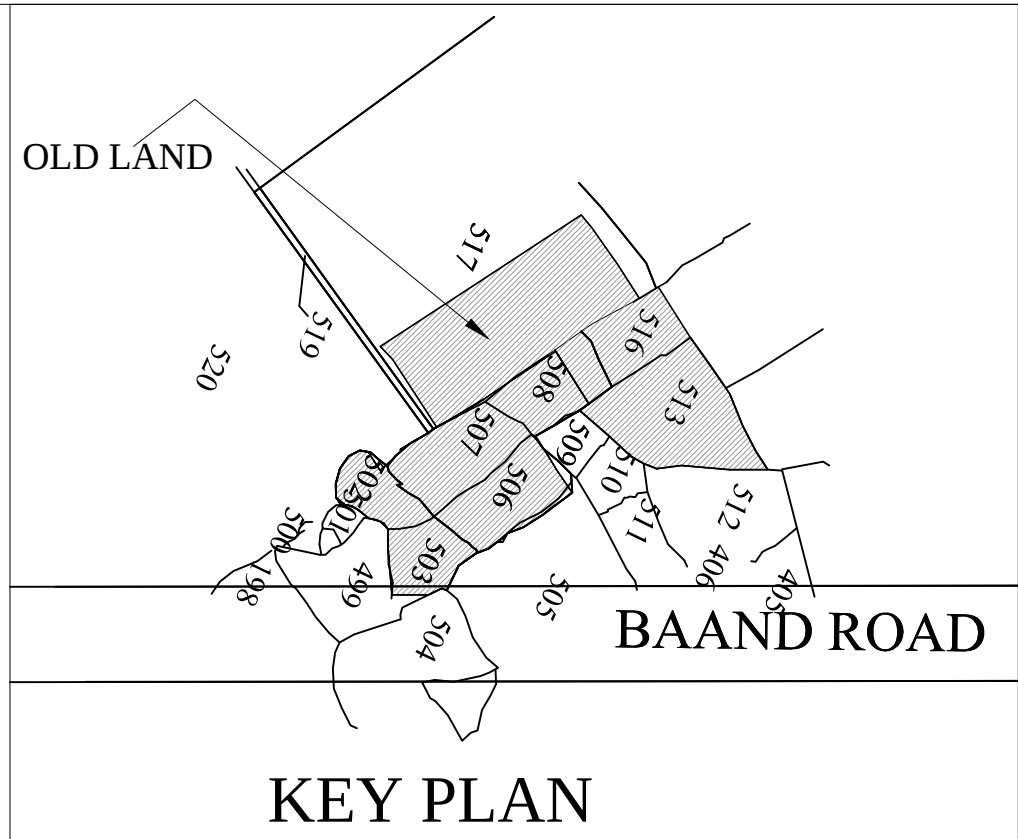
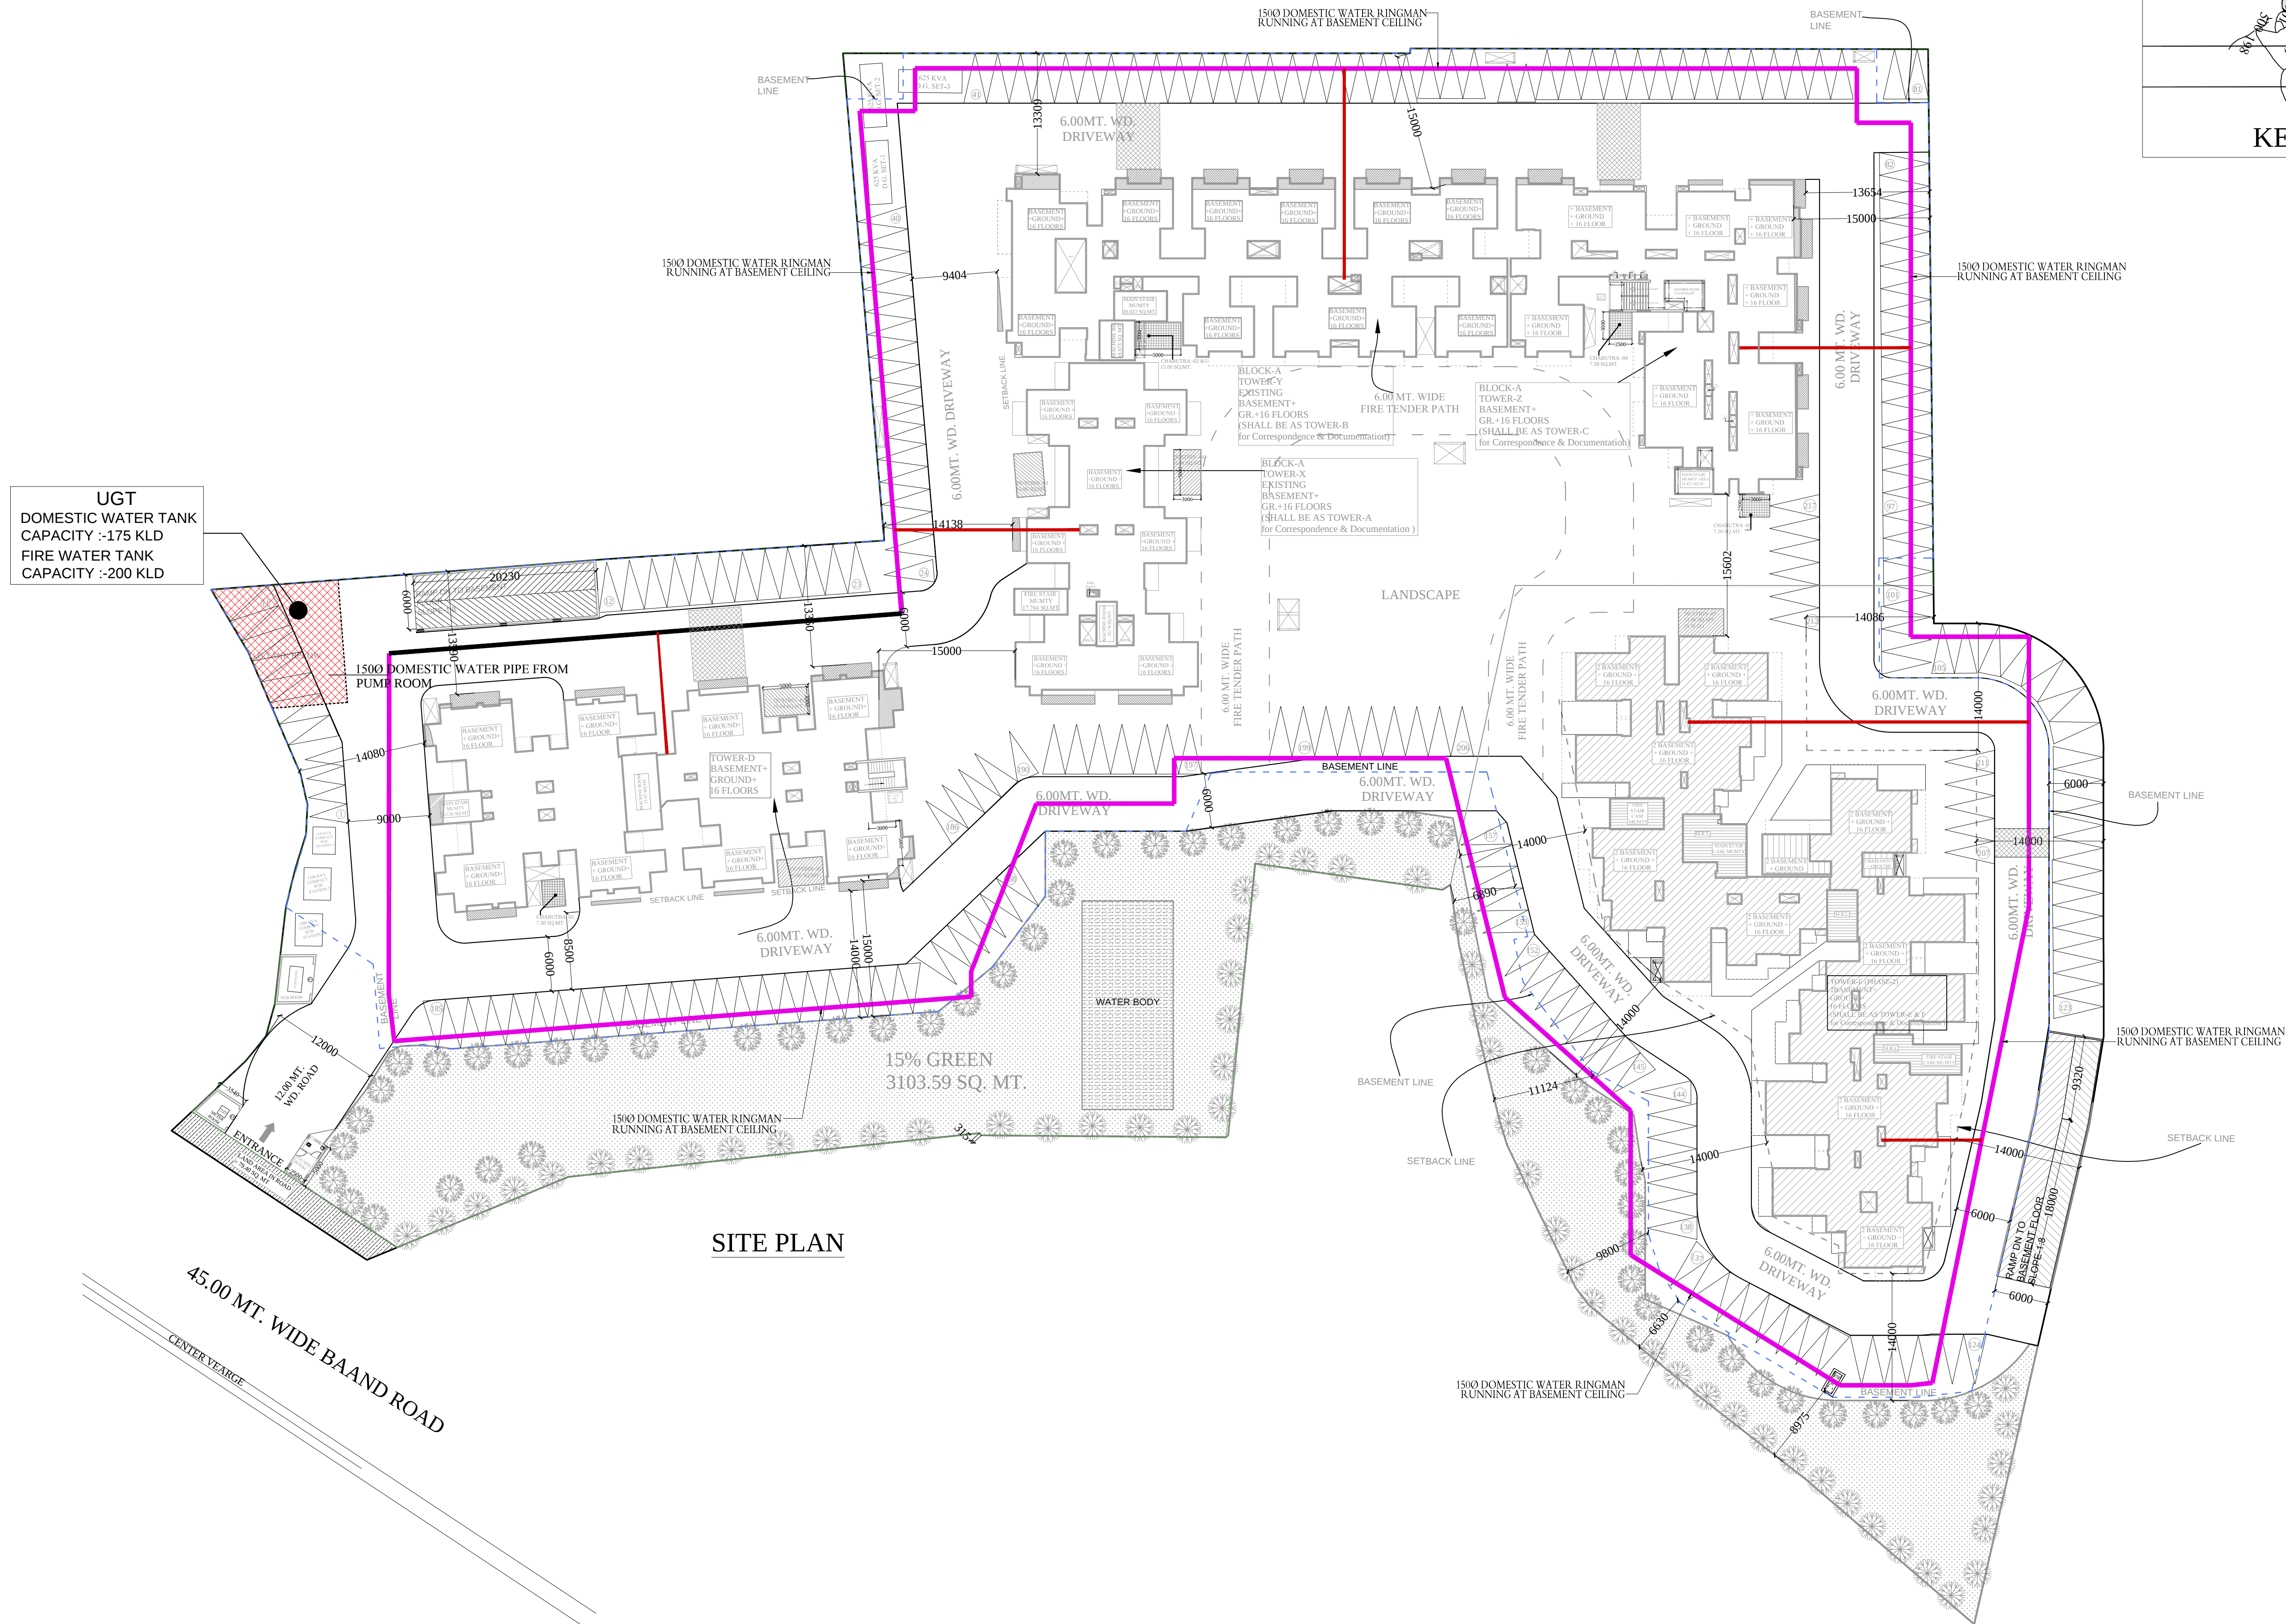


SITE PLAN

PROJECT :-
RESIDENTIAL COMPLEX AT KHASRA No.
502,503,506,507,508,513,516,517
VILLAGE:- NUR NAGAR,
N.H-58, GHAZIABAD

BUILDERS & PROMOTER :-
M/s STAR AMD REALCON
1010,Falz Rd., Karol Bagh, New Delhi.
Through:
Mr. Nitin Gupta
Ph.0120 - 4387710 - 13

DRAWING TITLE :-
WATER SUPPLY PLAN

ARCHITECTS :-
Space Designers International
B-34, Sector-67, Noida-201301 (U.P.)
Phones :- +91-011-633717, 18, 19, 20
Mob: 9811538231
Website: www.spacedesigners.com, E-mail: spacedesigners@gmail.com

DRAWN BY :- SANJAY	CHECKED BY :- VISHAL	SCALE 1: 350	DATED :-
-----------------------	-------------------------	-----------------	-------------------

OWNER'S SIGN	ARCHITECT'S SIGN DRG.NO. - 01
--------------	----------------------------------